


Proposed Floor Plan

Scale: 1:50

DATE	REVISION
9.3.2009	INITIAL ISSUE FOR PRICING

Full
In
Ro
Inc
con

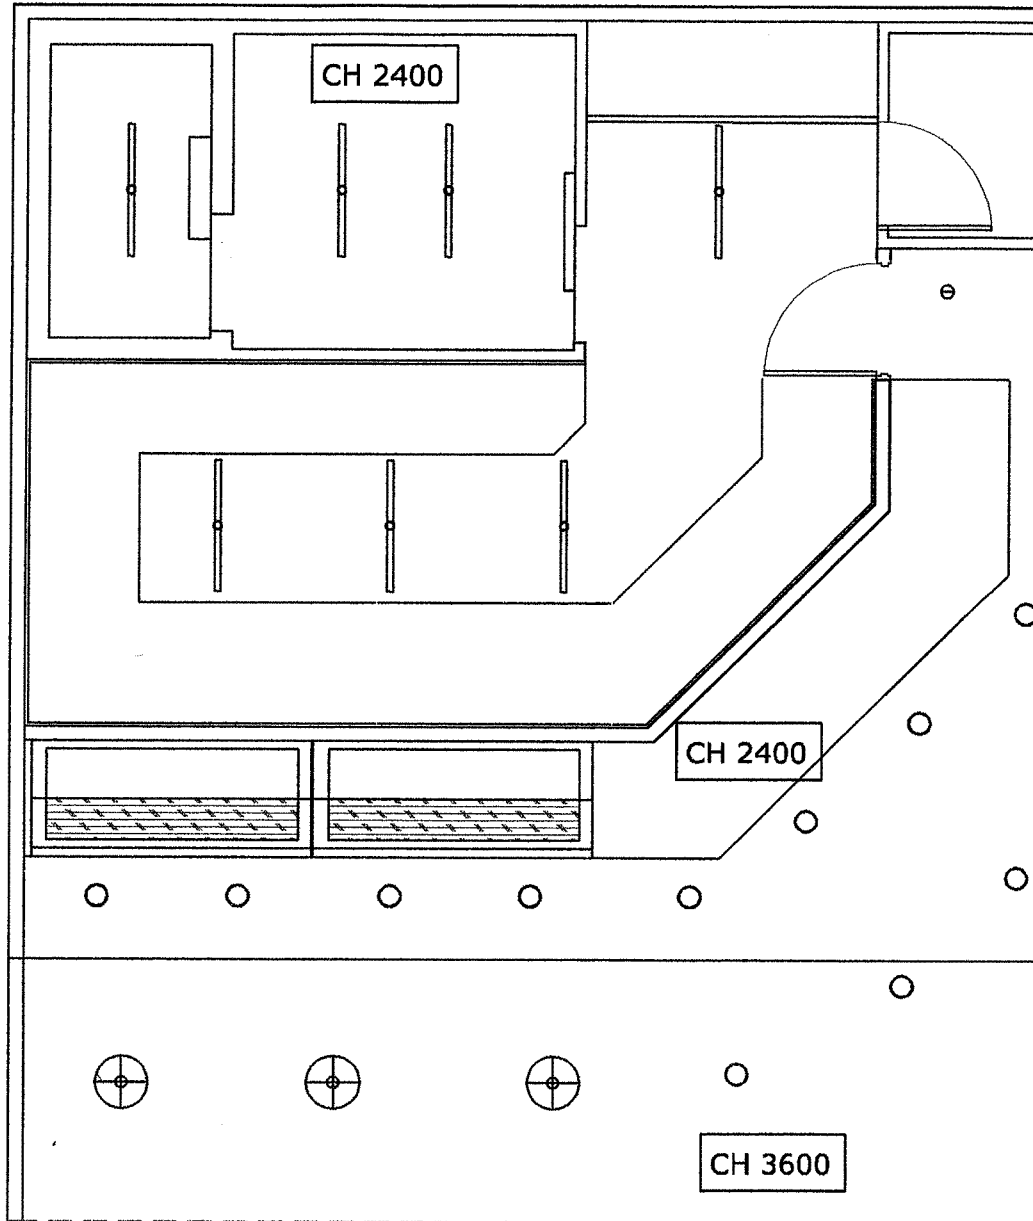

Reflected Ceiling

Scale: 1:50

LIGHTING LEGEND



L1 - TOM DIXON COPPER SERIES
'BLOW LIGHT PENDANT' FROM
DEDECE PH. 9360 2722



L2 - ANTARES 'COMPASS FIXED
135MM' CODE: CDM-TC G8.5. FROM
EUROLUCE PH. 9380 6222



L3 - FEATURE WALL LIGHTS TBC




L4 - RECESSED DOWNLIGHT FROM ANTARES
CODE: 03.3507.DD COLOUR TBC. FROM
EUROLUCE PH: 9380 6222




L4 - FLUORO LIGHT FITTINGS TBC FROM
EUROLUCE PH: 9380 6222

DATE	REVISION
9.3.2009	INITIAL ISSUE FOR PRICING

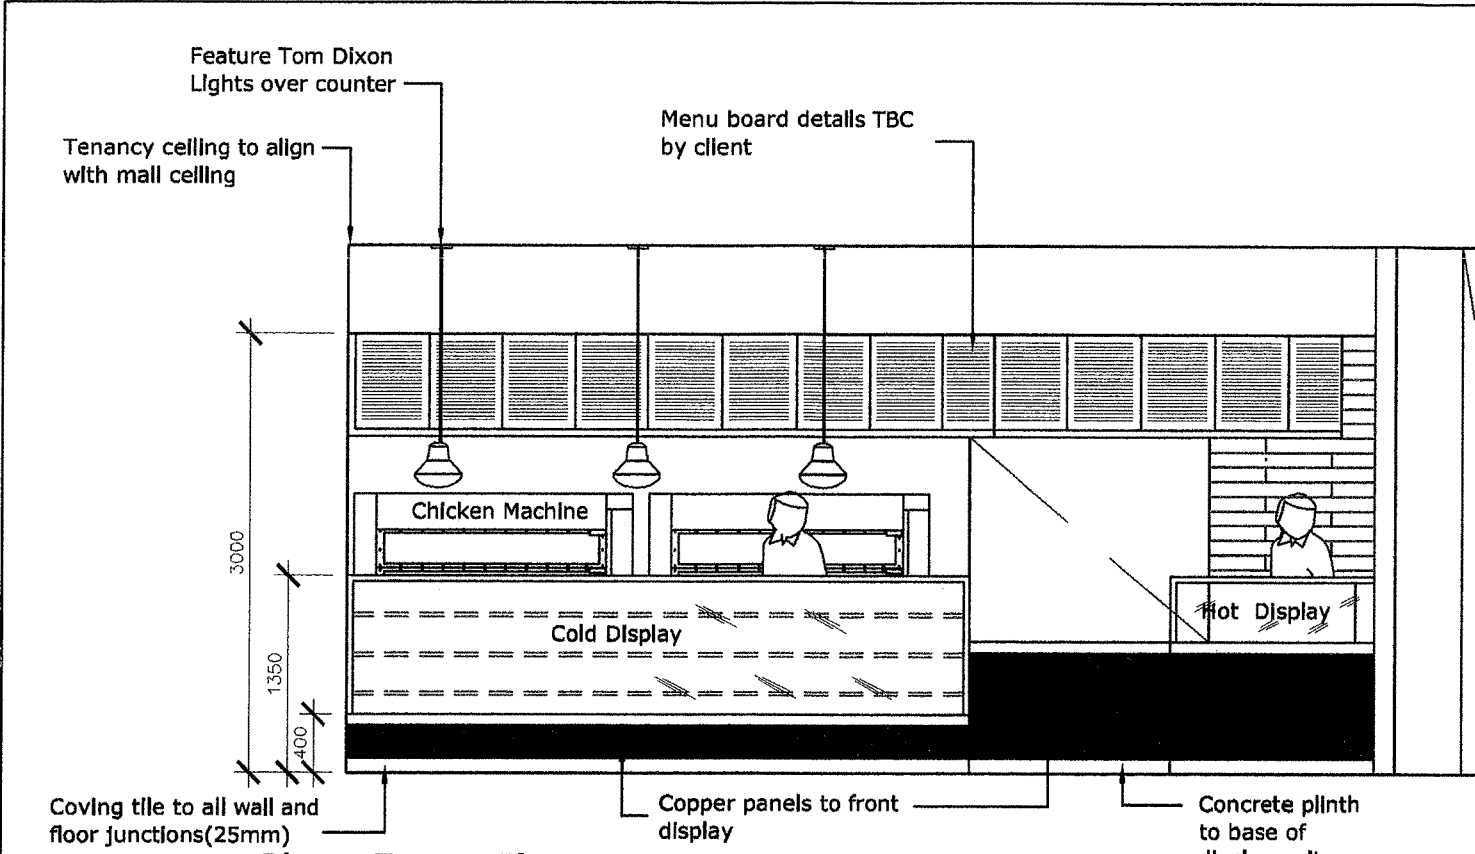

Shop Front Elevation

Scale: 1:50

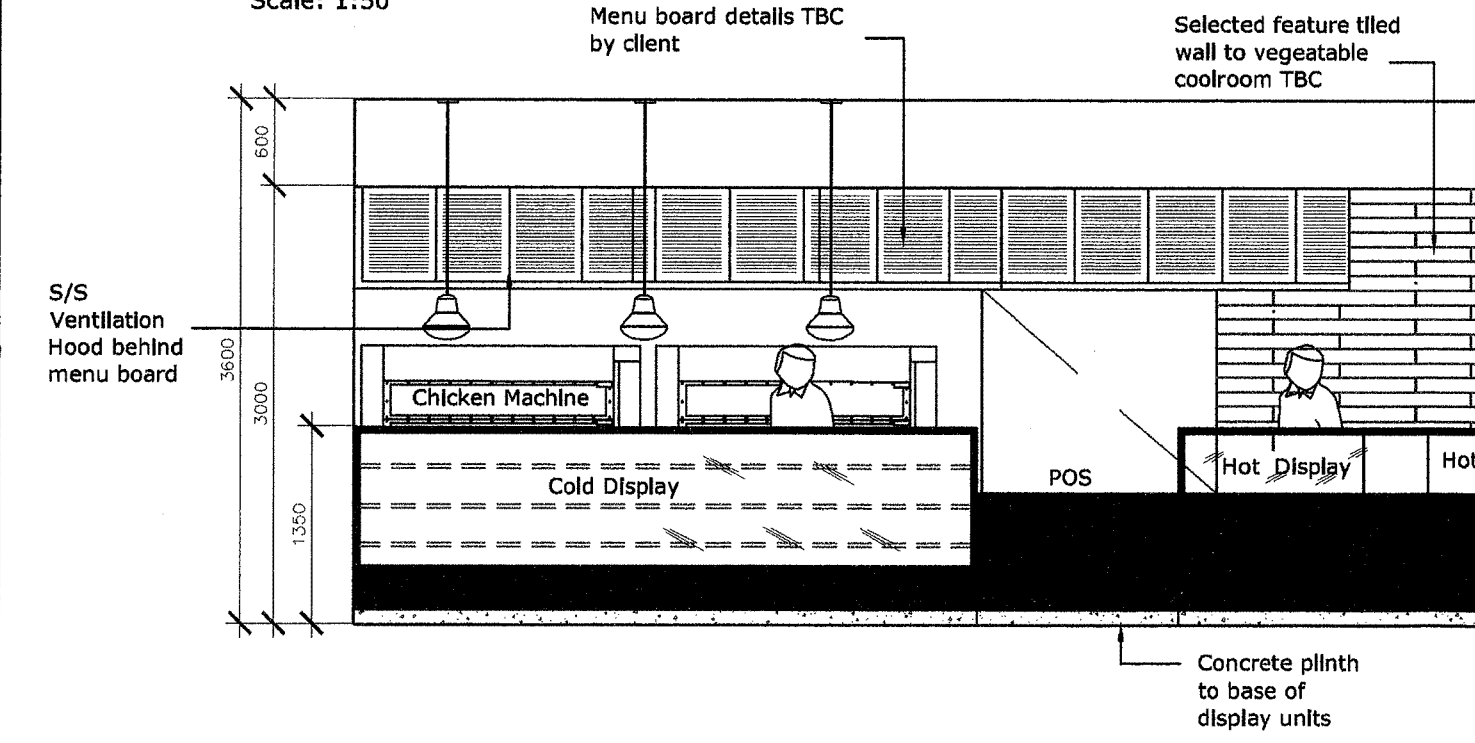

Front Elevation

Scale: 1:50

DATE	REVISION
9.3.2009	INITIAL ISSUE FOR PRICING