




SECTION

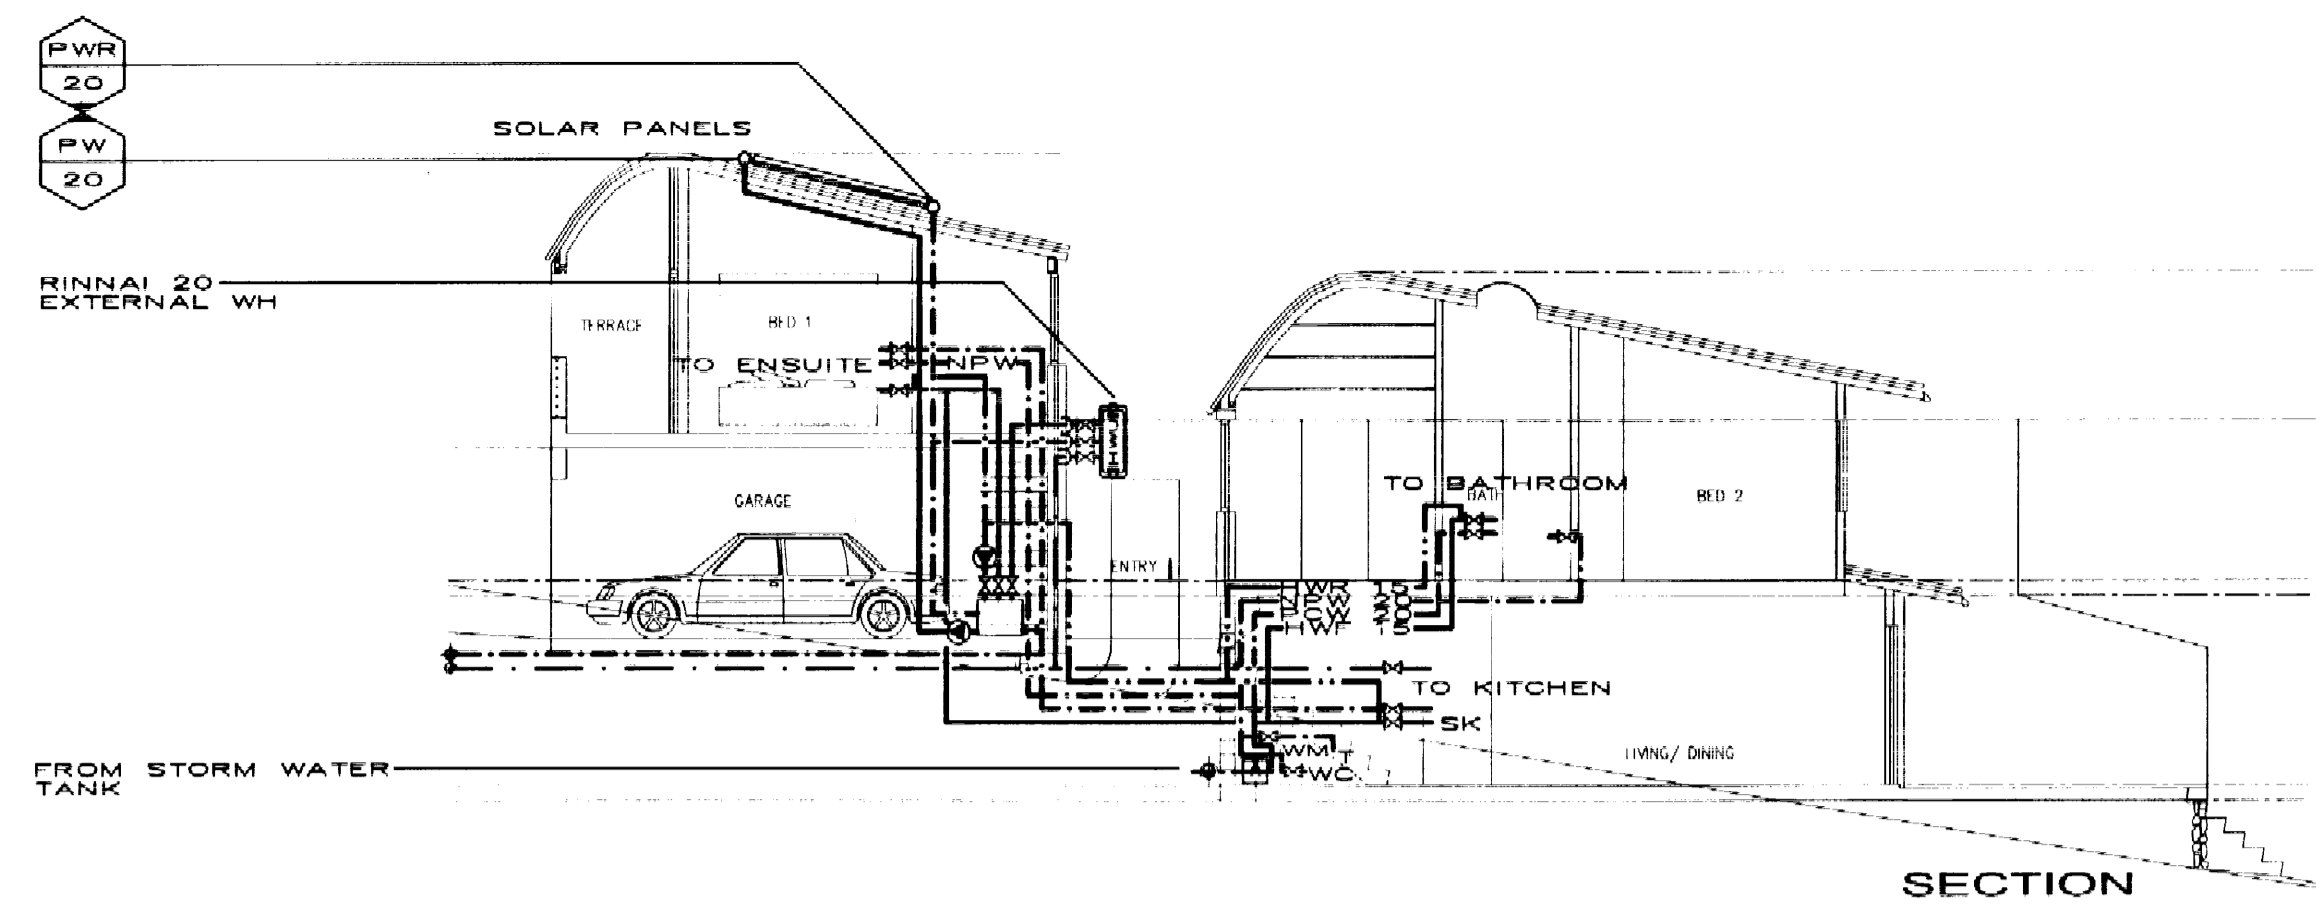


SECTION

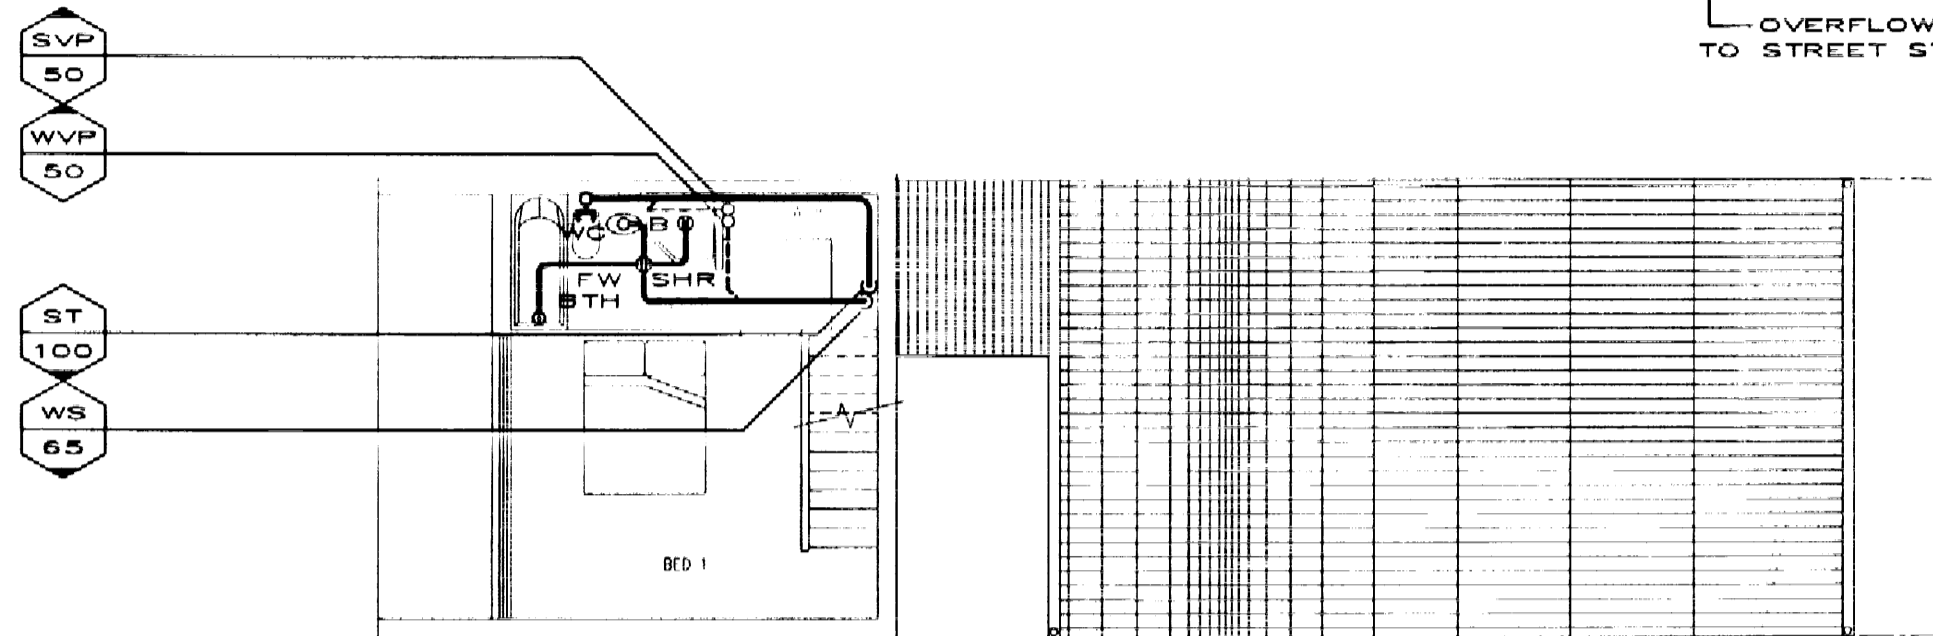


FIRST FLOOR PLAN

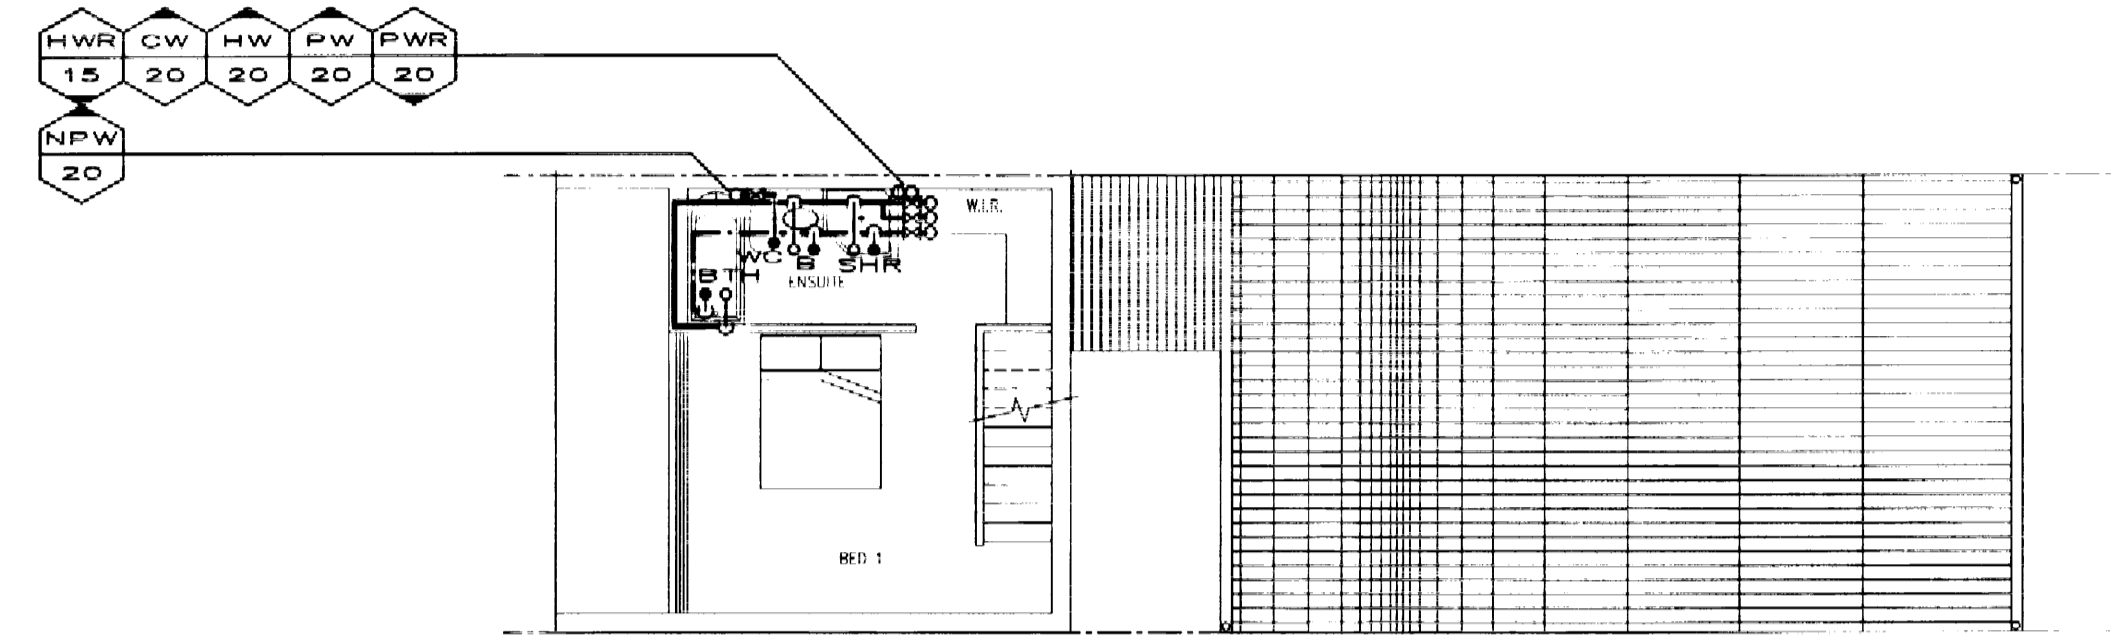


FIRST FLOOR PLAN

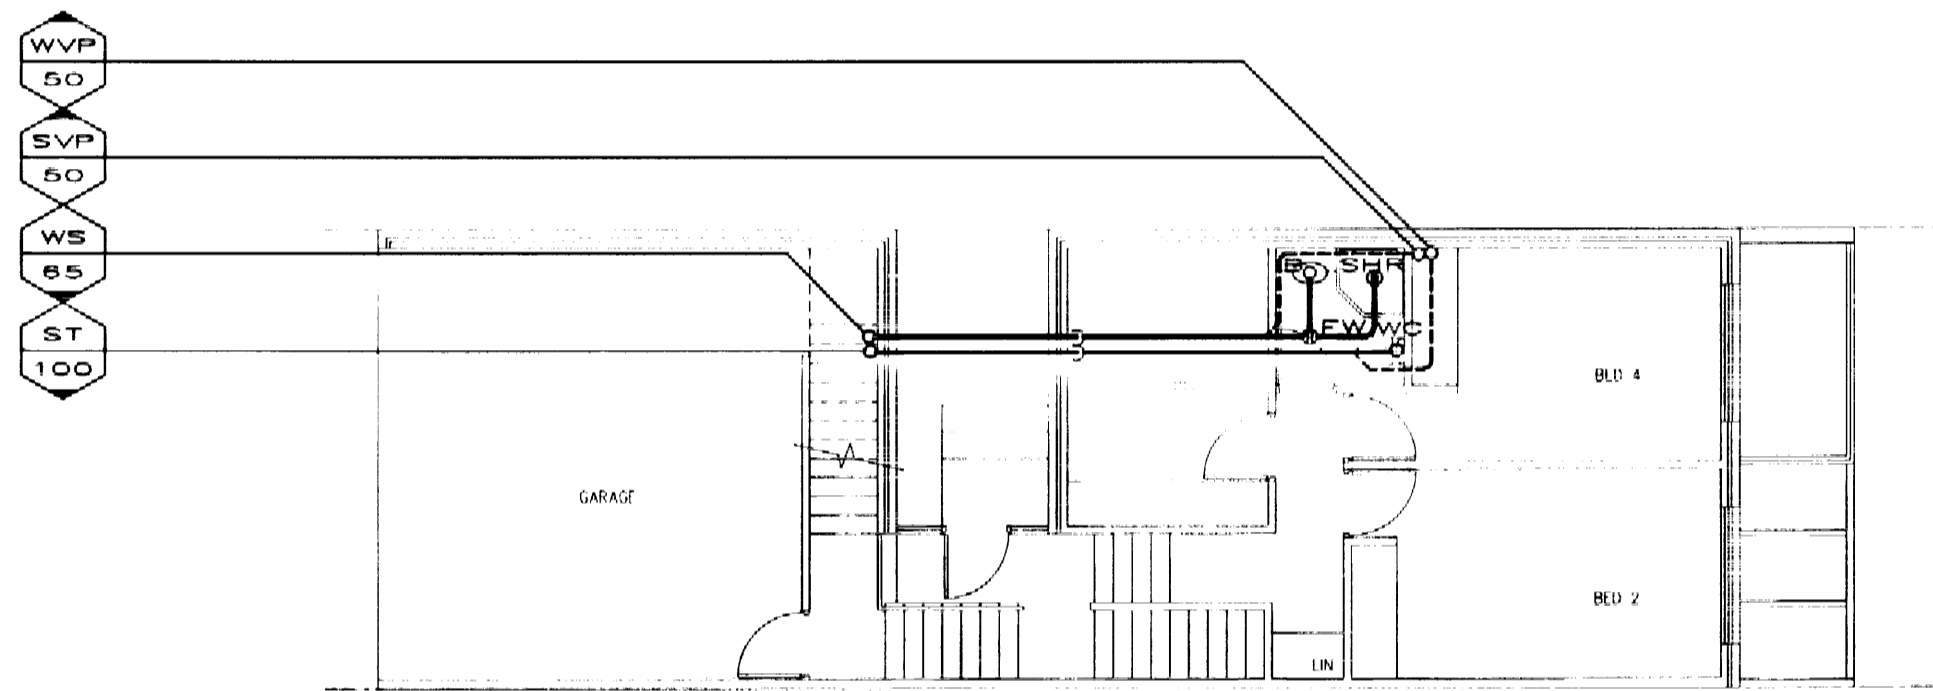


GROUND FLOOR PLAN

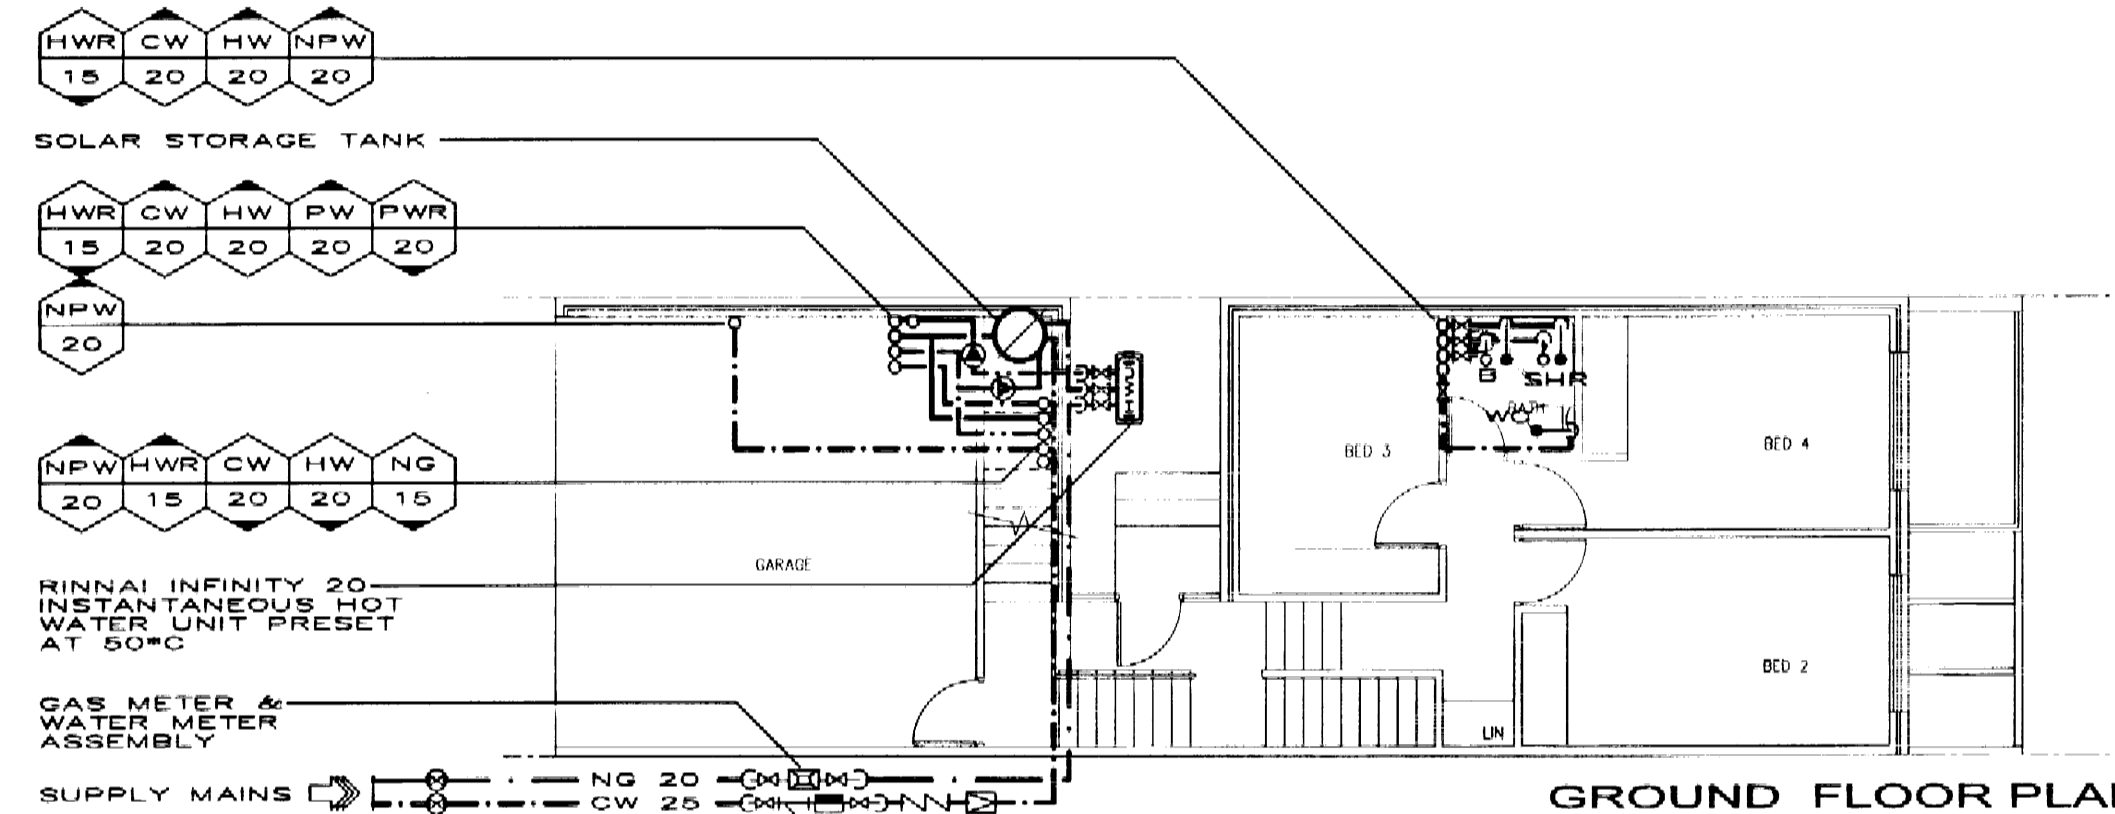


GROUND FLOOR PLAN

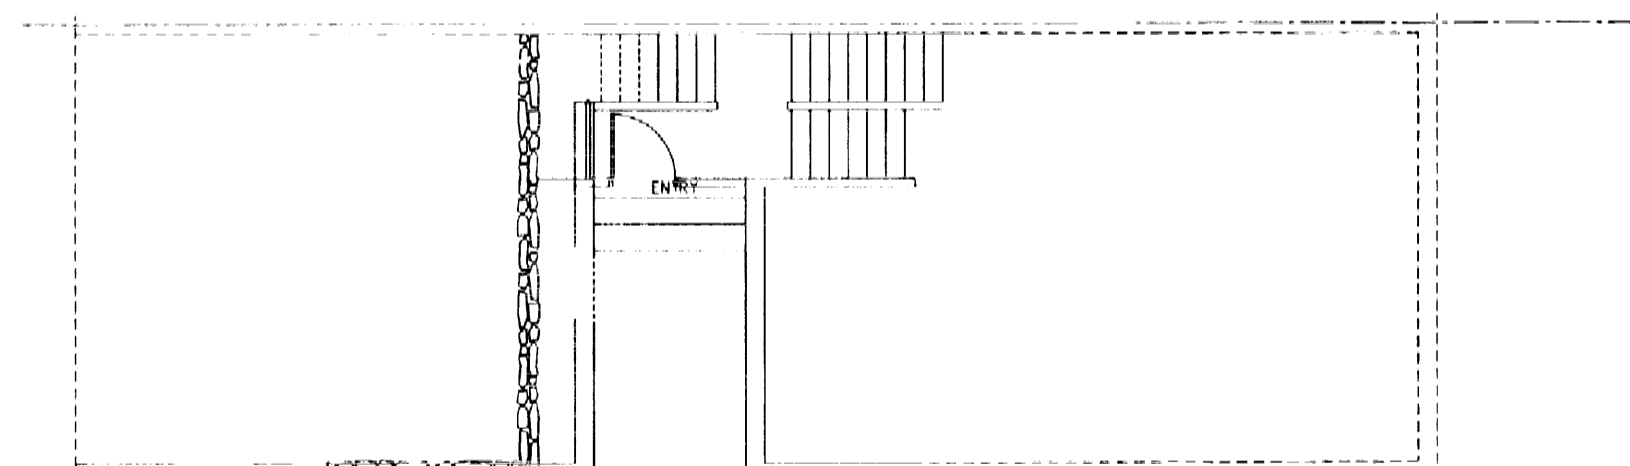


ENTRY FLOOR PLAN

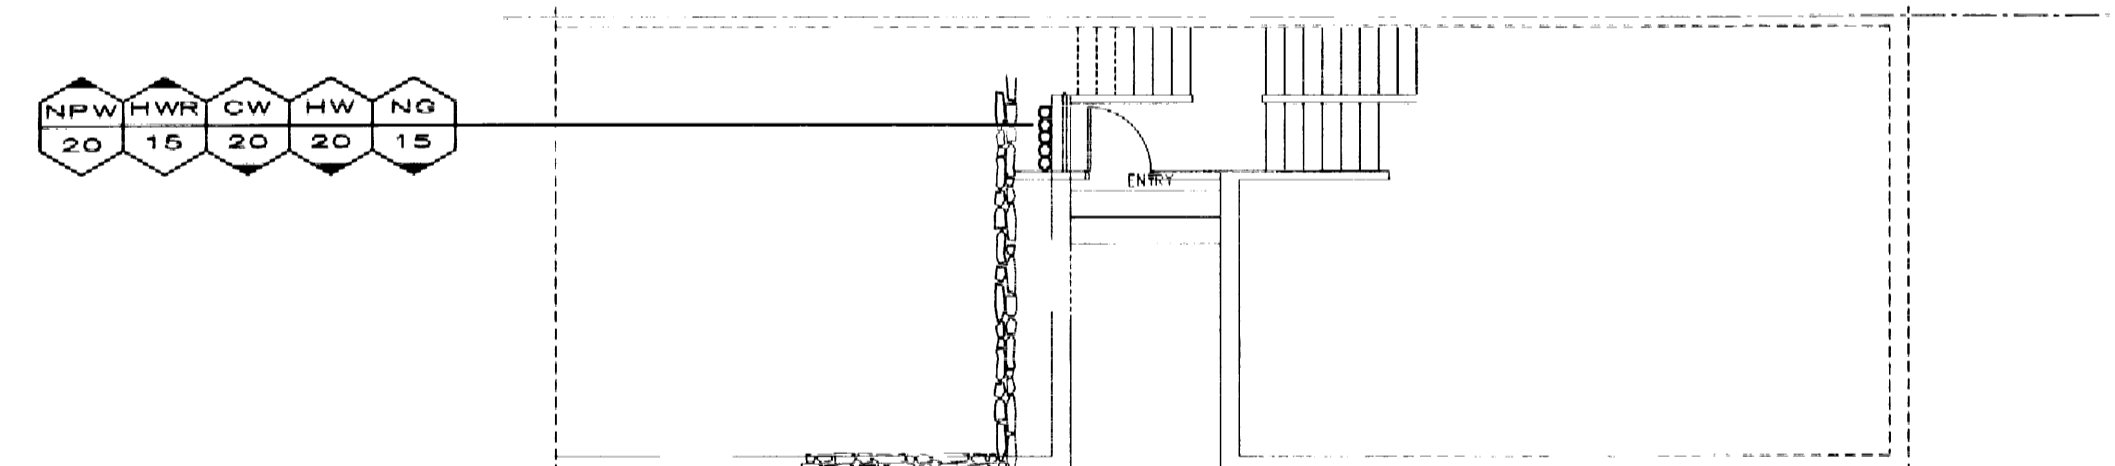

ENTRY FLOOR PLAN

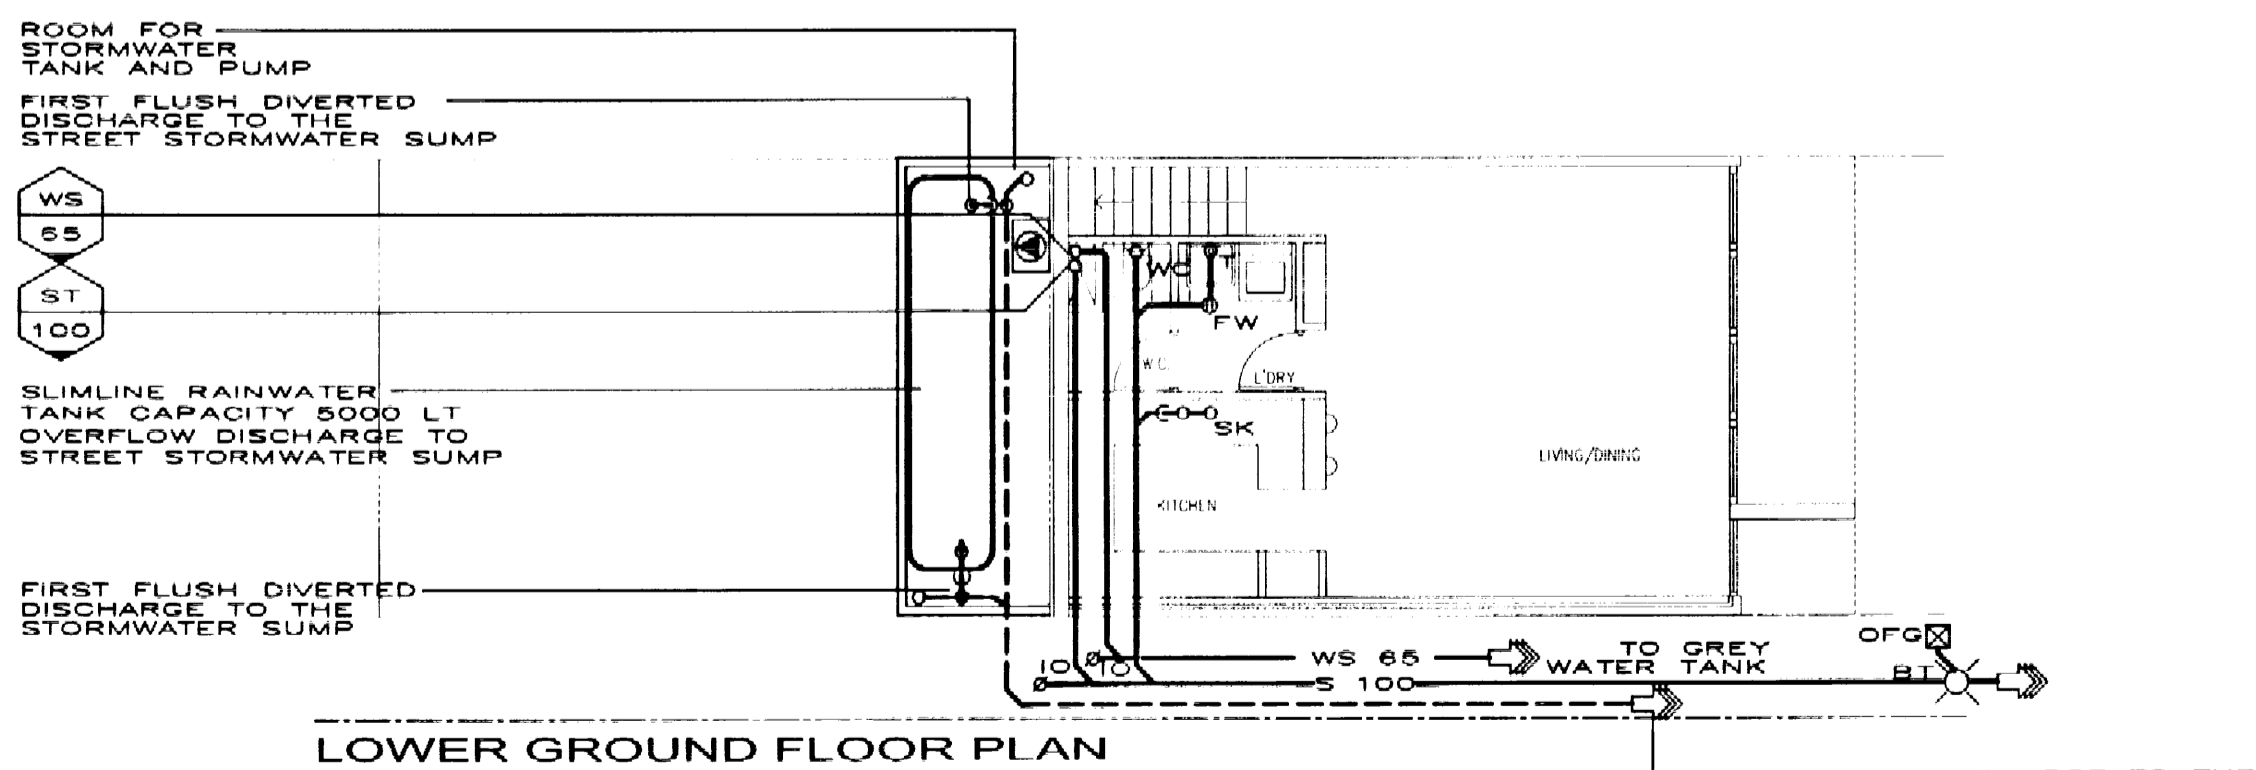


SANITARY PLUMBING DRAINAGE

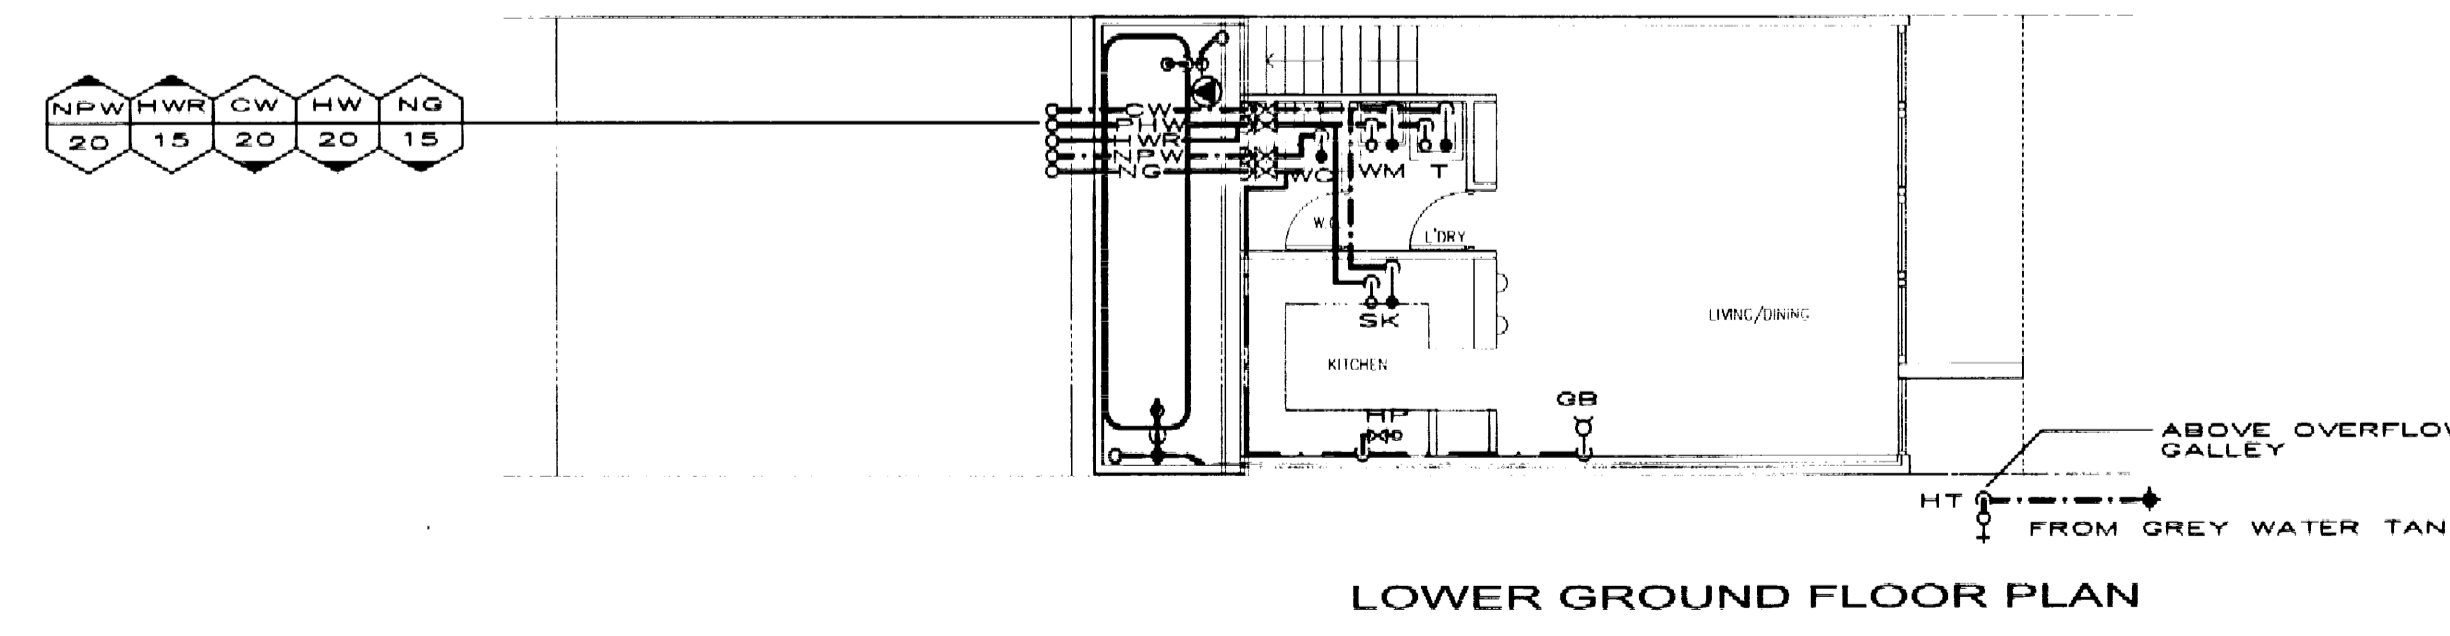

WATER & GAS SERVICES

thomsonkane

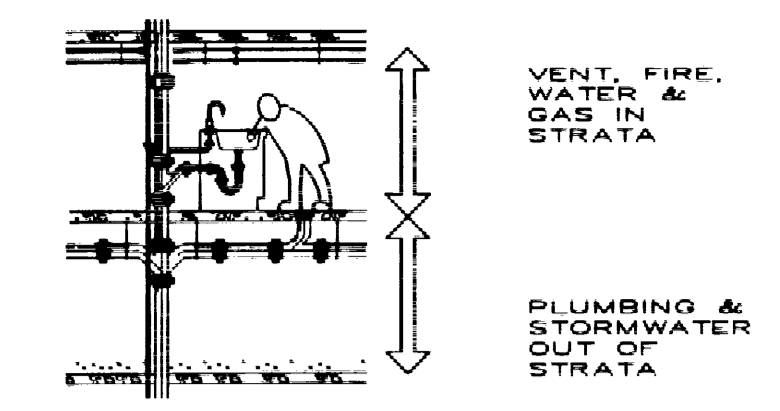

VENT. FIRE, WATER & GAS IN STRATA
PLUMBING & STORMWATER OUT OF STRATA

NOTE:
FOR GENERAL NOTES AND LEGEND REFER TO COVER SHEET DH-00

DISCIPLINE	DRG NO.	REV	TK QA SYSTEM	REASON FOR ISSUE
ARCHITECTURAL	PLANS Oct. 04			
STRUCTURAL				AUTHORISATION
MECHANICAL				BY: _____
ELECTRICAL				VERIFICATION OF LATEST AMENDMENT
CIVIL	PLANS 27.09.04			BY: _____

REV	ISSUE	BY	CHKD	DATE
P5	REVIEW		AM	AT 20.10.04
P4	REVIEW		AM	AT 10.09.04
P3	REVIEW		AM	AT 10.09.04
P2	REVIEW		AM	AT 12.07.04
P1	PRELIMINARY ISSUE		AM	AT 17.06.04

HYDRAULIC ENGINEERS:
thomsonkane Consulting Hydraulic and Fire Engineers 281 Pacific Highway, North Sydney NSW 2060 Phone: (02) 9955 0788 Fax: (02) 9954 5632 Email: tk@thomsonkane.com.au WWW.THOMSONKANE.COM.AU ACN 108 803 649 THIS DRAWING IS COPYRIGHT ©
ARCHITECTS:
Denis Leech Associates P/L 350 George Street, Sydney NSW 2000 Tel: (02) 9997 7288 Fax: (02) 9997 3164
MASTER PLANNING:
Wolski, Lycenko & Brechnock 115 Military Road, Neutral Bay NSW 2089 Tel: (02) 9953 8477 Fax: (02) 9953 8557
ELECTRICAL:
Barry Webb & Associates P/L 37 Ryde Road, Pymble NSW 2073 Tel: (02) 9418 1444 Fax: (02) 9418 1191
ENVIRONMENTAL:
WP Brown & Partners Pty Ltd Level 2, 82 Waterloo Road Macquarie Park NSW 2113 Tel: (02) 9900 1000 Fax: (02) 9900 1099
LANDSCAPE:
Place Planning & Design P/L Suite 10, Norberry Terrace, 177 Pacific Hwy North Sydney NSW 2060 Tel: (02) 9959 5021 Fax: (02) 9959 5502

PROJECT:
PROPOSED RESIDENTIAL SUBDIVISION - 5 WARRIEWOOD VALLEY, WARRIEWOOD NSW

TITLE: HYDRAULIC SERVICES
TYPICAL HOUSE TYPE 1 SEWER, WATER & GAS

SCALE:	PROJECT No:	CAD REF:
1:100	4733-1H	T: TKNEW/
DATE:	DRAWING NUMBER:	REVISION:
JULY '04	H-06	P5
DRAWN BY:	CHKD BY:	DATE:
	AT	

SCALE:	PROJECT No:	CAD REF:
1:100	4733-1H	T: TKNEW/
DATE:	DRAWING NUMBER:	REVISION:
JULY '04	H-06	P5
DRAWN BY:	CHKD BY:	DATE:
	AT	

SCALE:	PROJECT No:	CAD REF:
1:100	4733-1H	T: TKNEW/
DATE:	DRAWING NUMBER:	REVISION:
JULY '04	H-06	P5
DRAWN BY:	CHKD BY:	DATE:
	AT	

SCALE:	PROJECT No:	CAD REF:
1:100	4733-1H	T: TKNEW/
DATE:	DRAWING NUMBER:	REVISION:
JULY '04	H-06	P5
DRAWN BY:	CHKD BY:	DATE:
	AT	

SCALE:	PROJECT No:	CAD REF:
1:100	4733-1H	T: TKNEW/
DATE:	DRAWING NUMBER:	REVISION:
JULY '04	H-06	P5
DRAWN BY:	CHKD BY:	DATE:
	AT	

SCALE:	PROJECT No:	CAD REF:
1:100	4733-1H	T: TKNEW/
DATE:	DRAWING NUMBER:	REVISION:
JULY '04	H-06	P5
DRAWN BY:	CHKD BY:	DATE:
	AT	

SCALE:	PROJECT No:	CAD REF:
1:100	4733-1H	T: TKNEW/
DATE:	DRAWING NUMBER:	REVISION:
JULY '04	H-06	P5
DRAWN BY:	CHKD BY:	DATE:
	AT	