

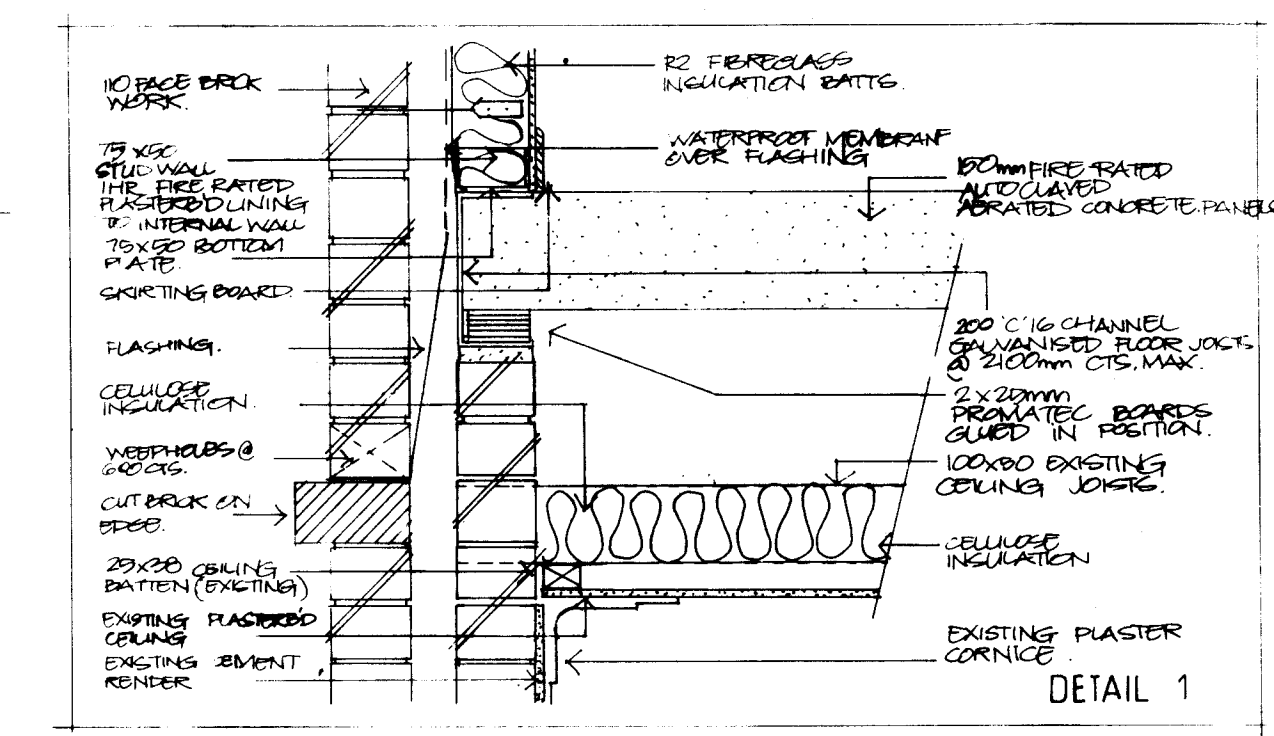
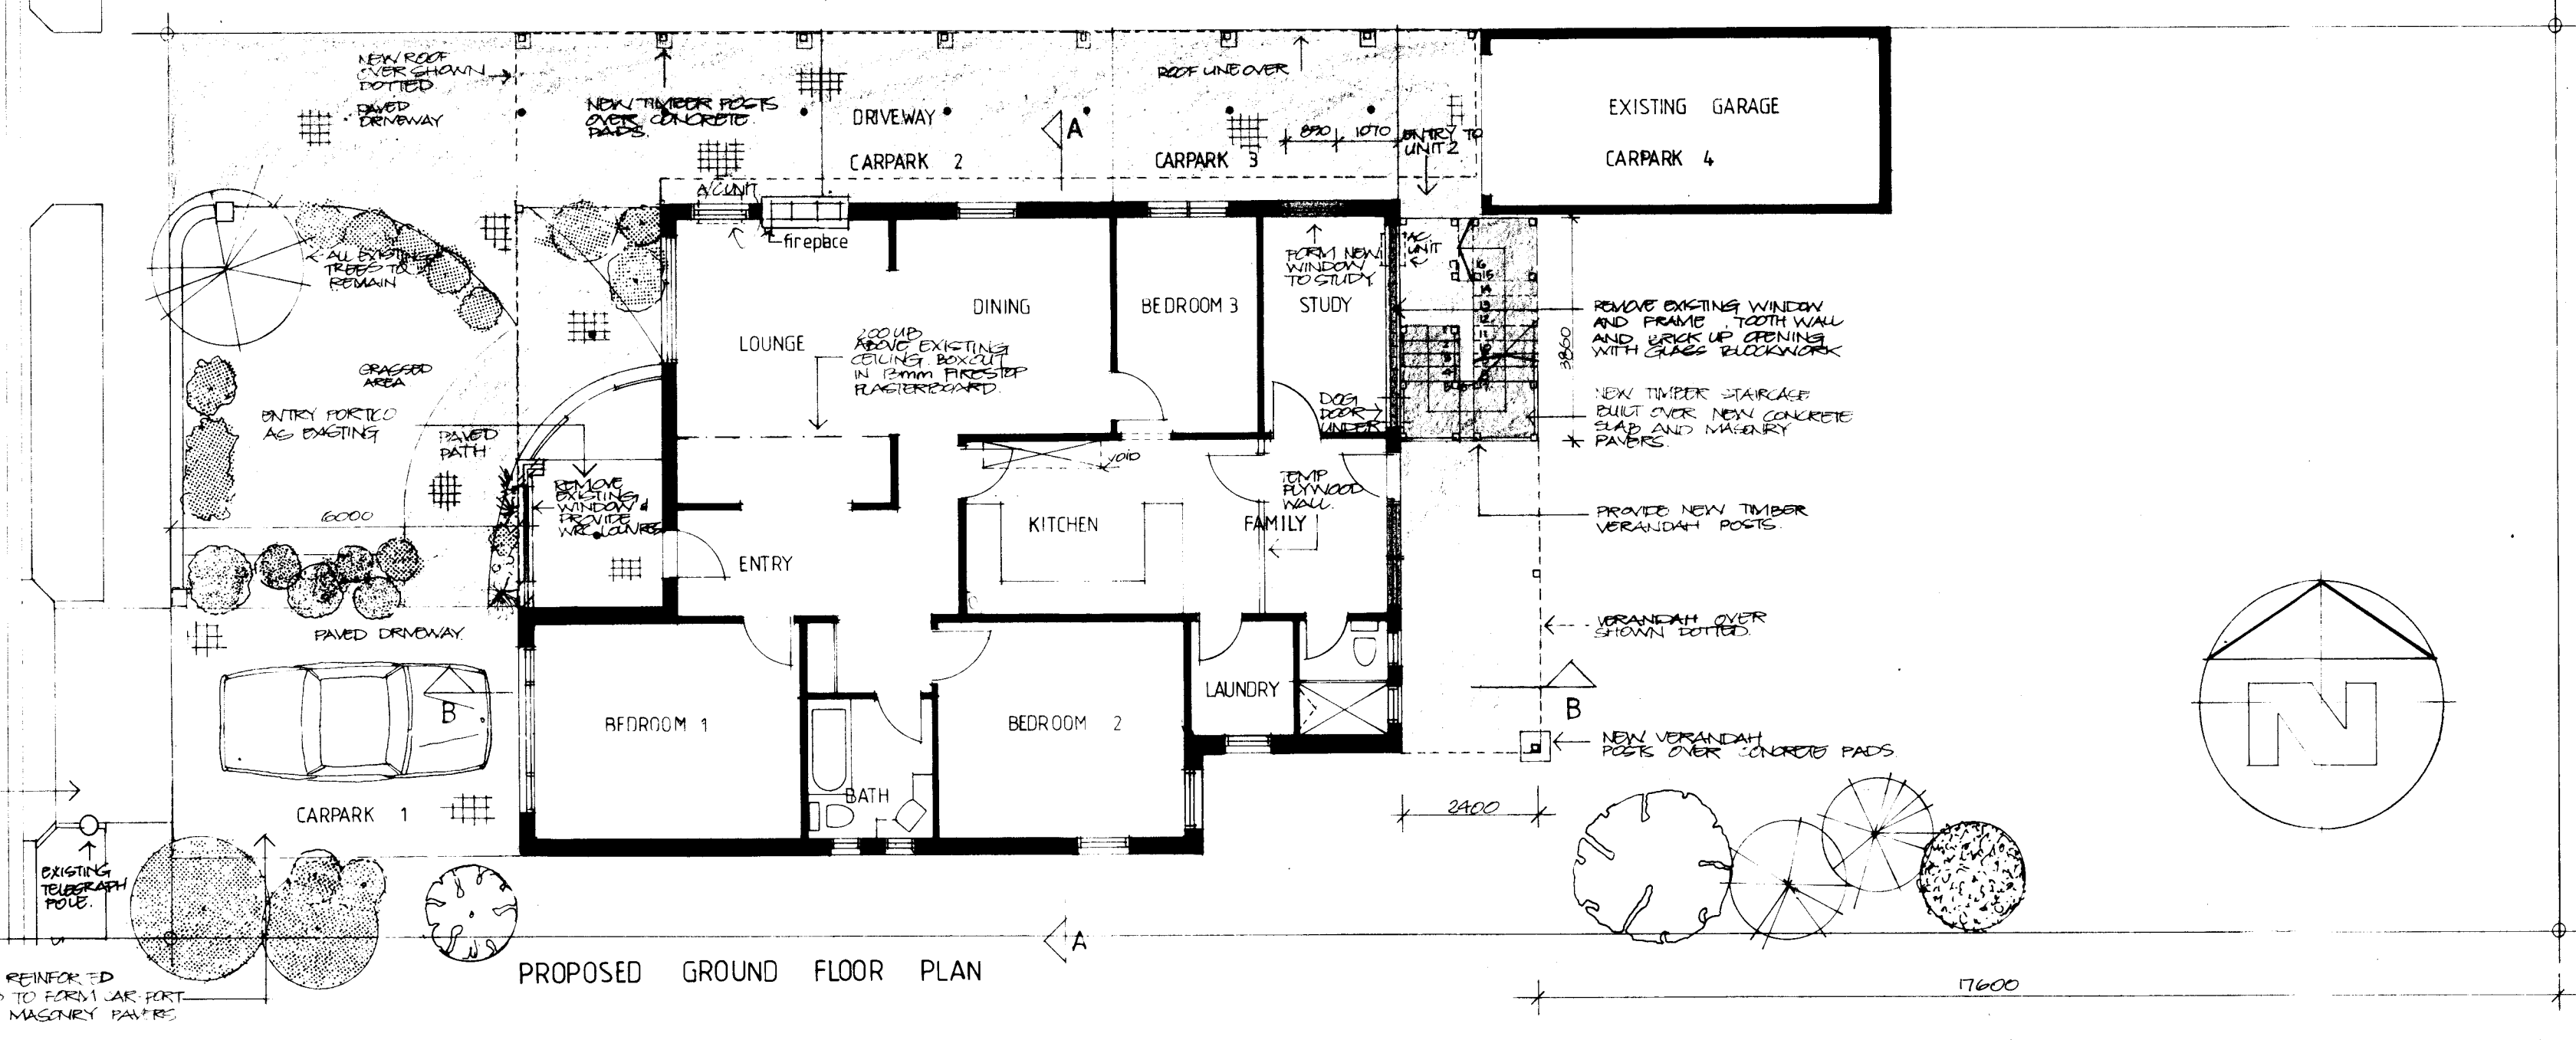
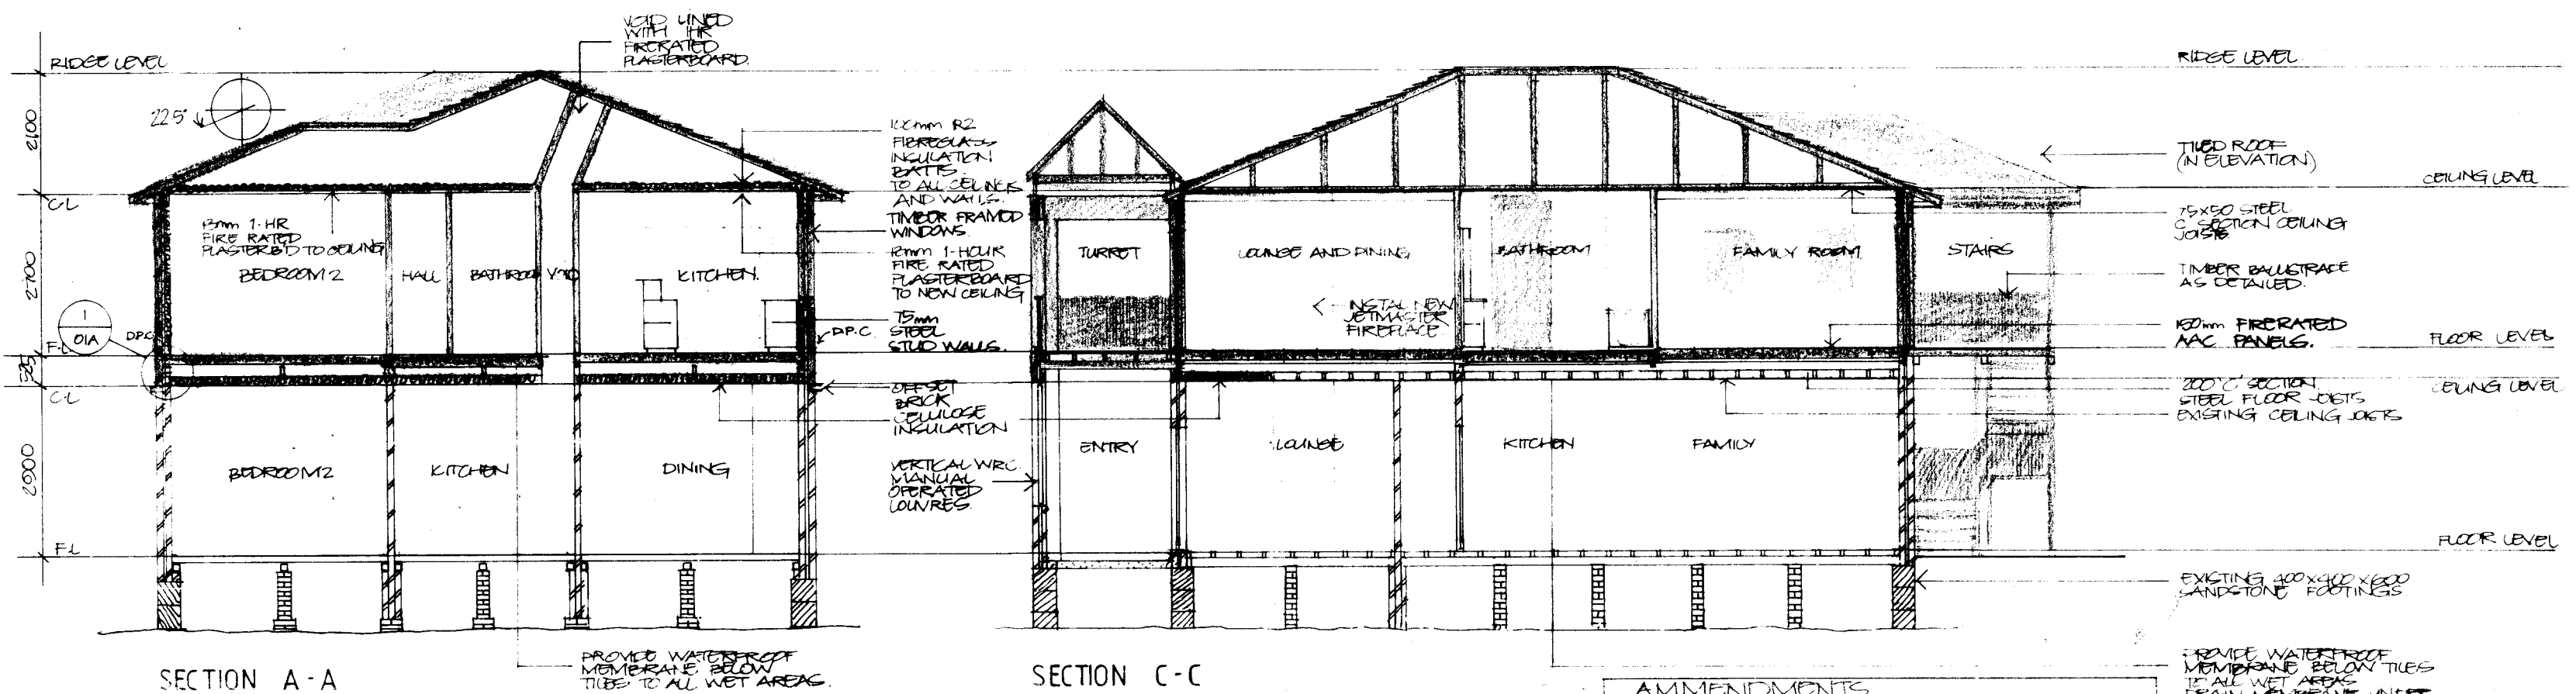
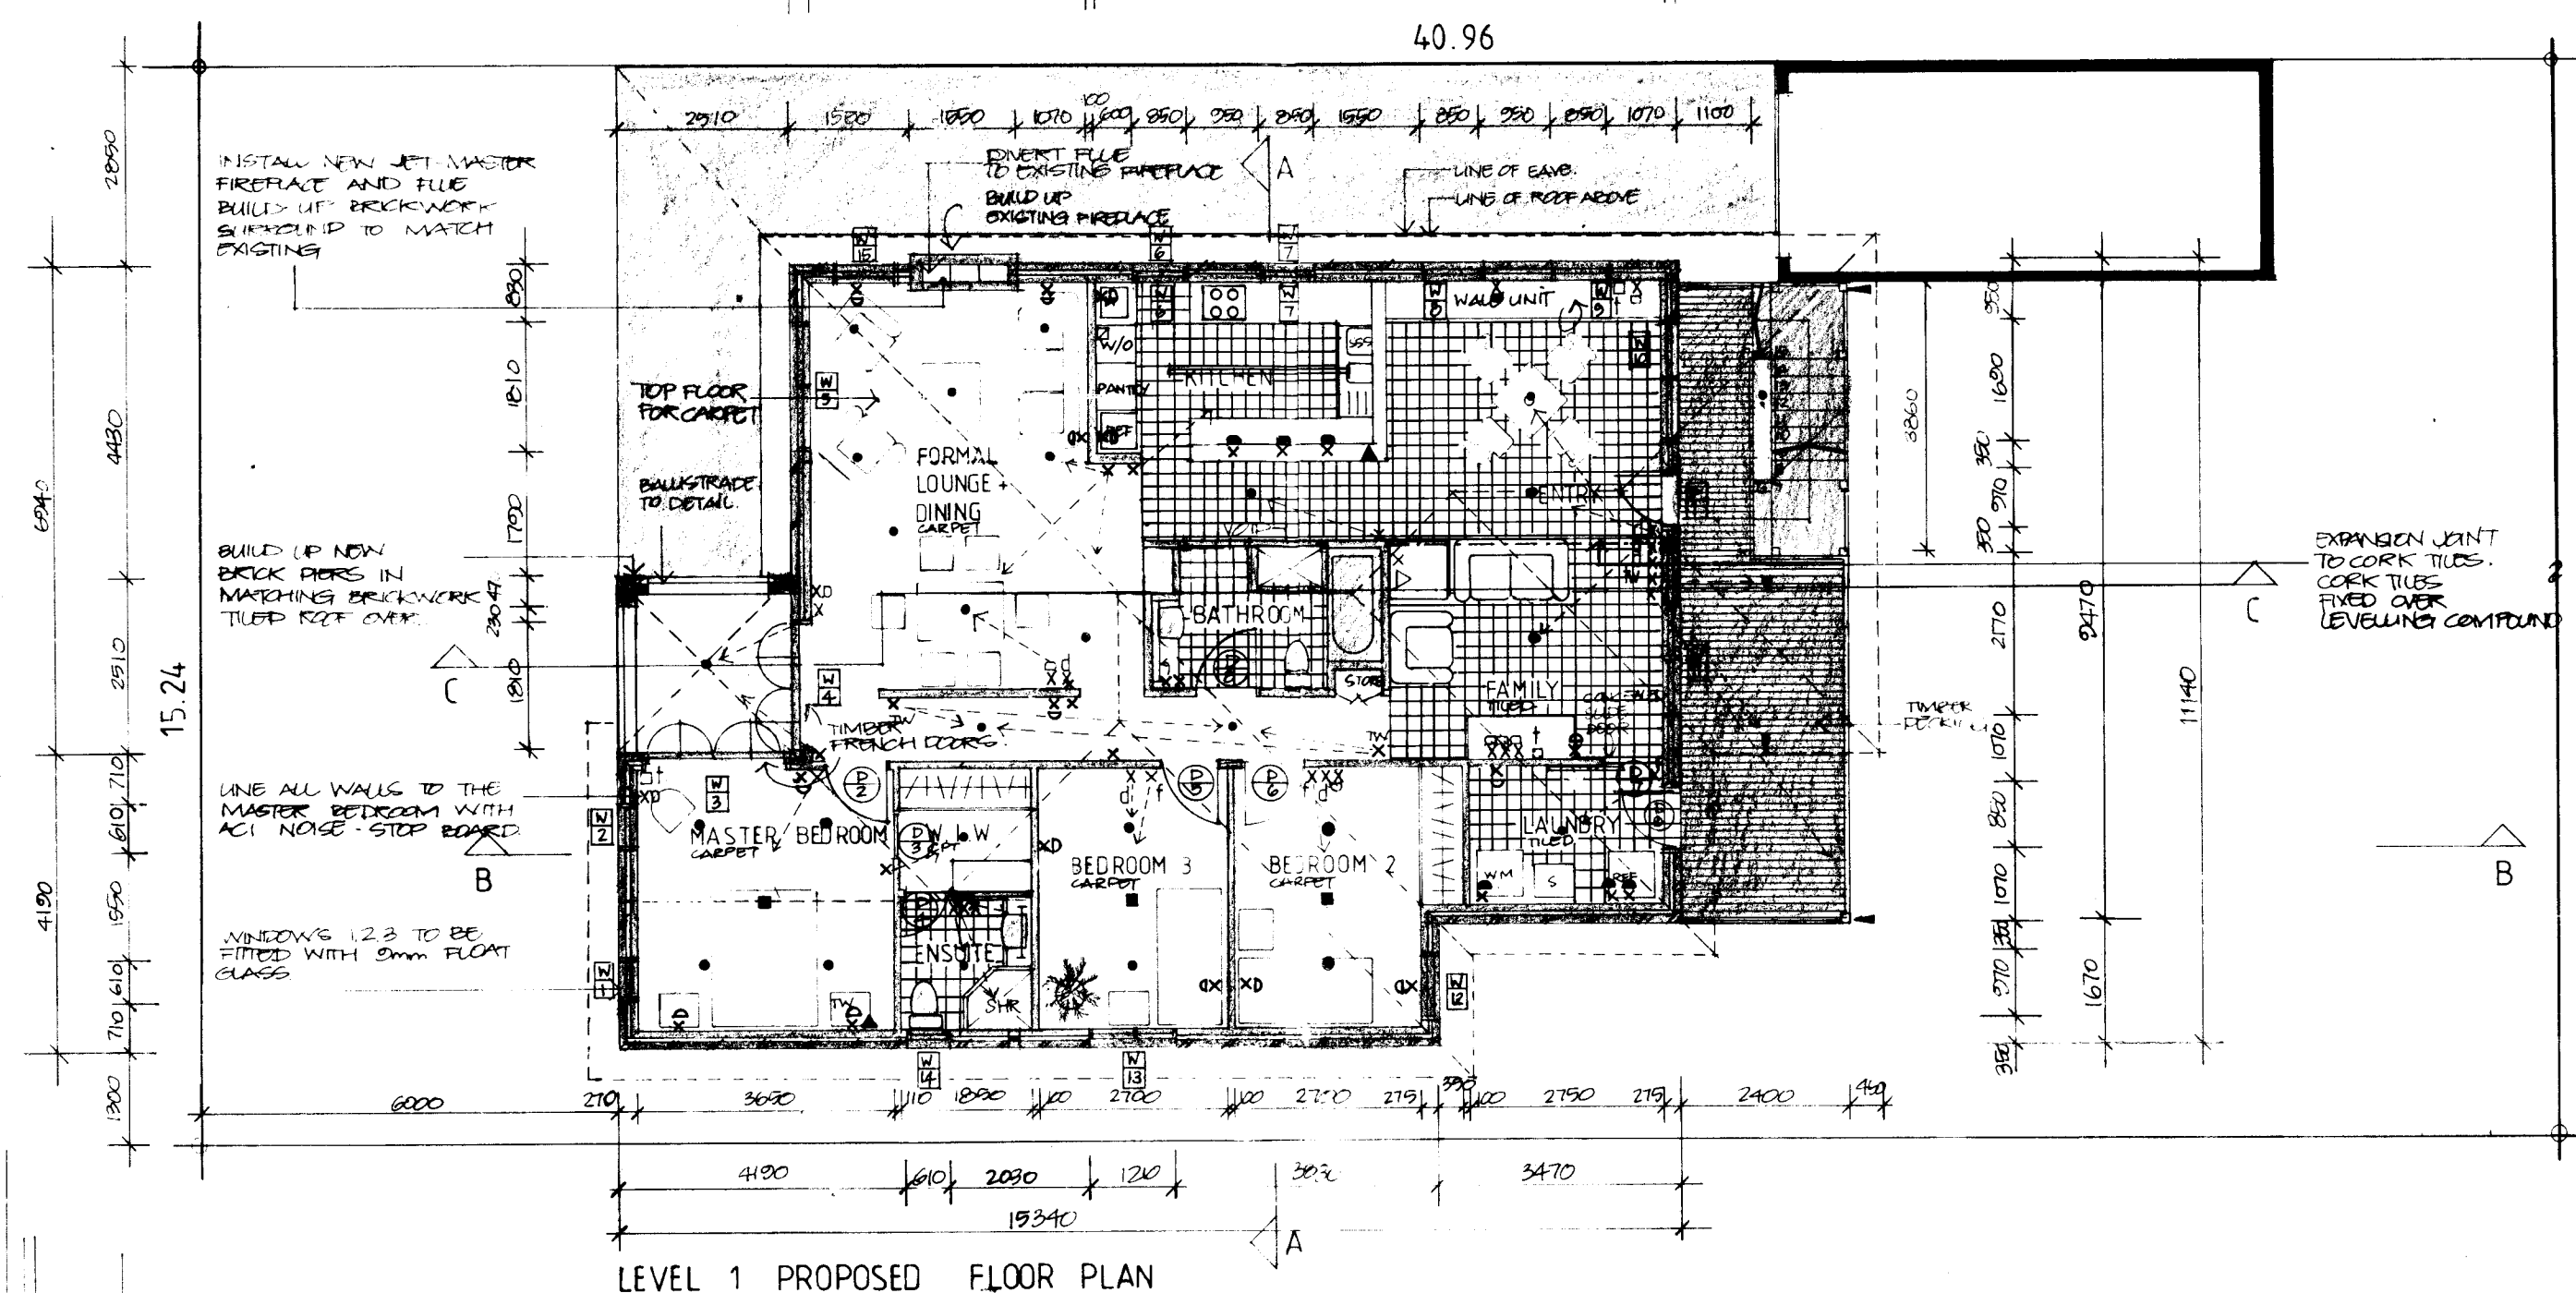


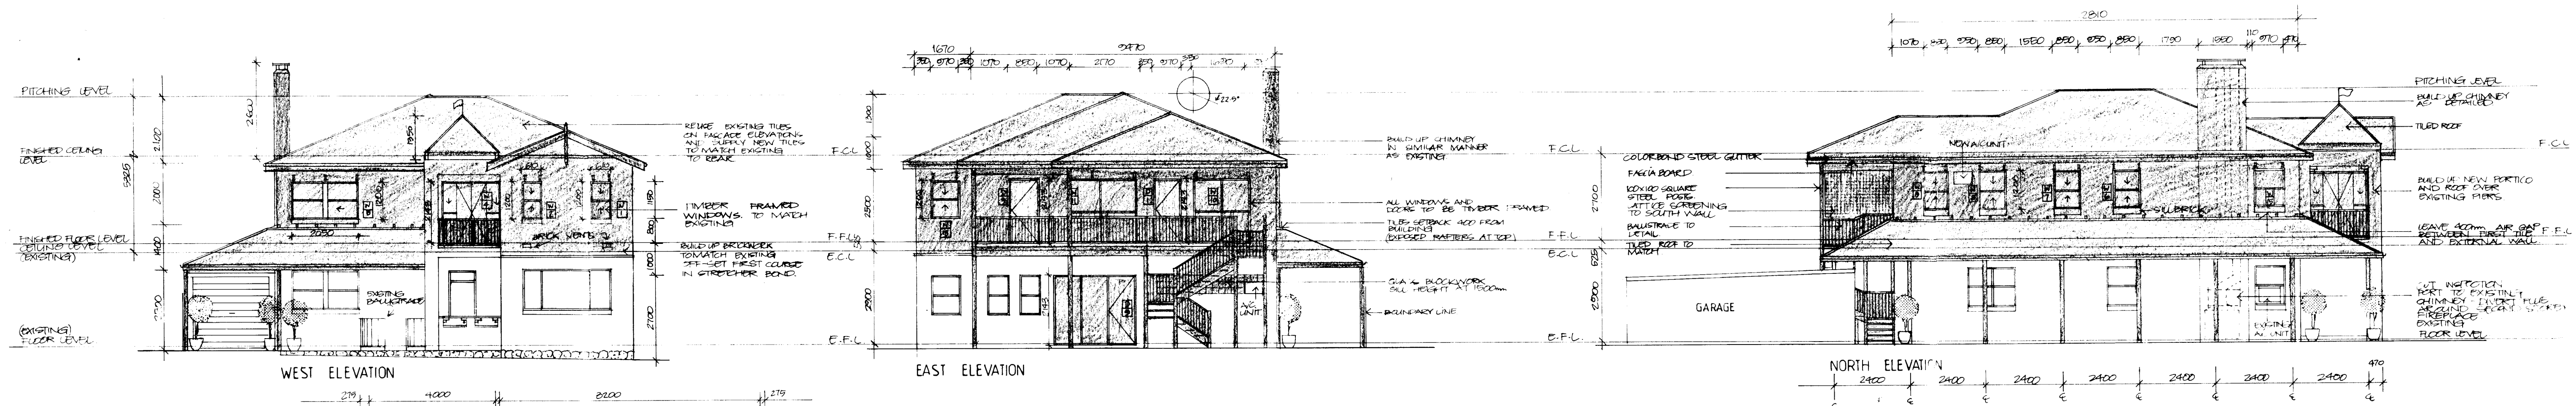

ELECTRICAL LEGEND			
X	LIGHT SWITCH	•	LOW VOLTAGE LIGHT
X TW	TWIN LIGHT SWITCH	••	TELEVISION SHORTWAVE
△	TELEPHONE OUTLET	xds	GEN' PURP' OUTLET
▲	EXTERNAL FLOOD LIGHT	xo	DOUBLE G.P.O.
o	240V CEILING SUPPLY	XB "	" BENCH HEIGHT
□	EXTERNAL DOWNLIGHT	XOH	G.P.O. HIGH LEVEL
— —	FLUORESCENT BATTEN	■	CEILING FAN
xd	LIGHT SWITCH/DIMMER	+	CONDUIT (MOUSED)
xf	FAN SWITCH	■	POWER SUPPLY

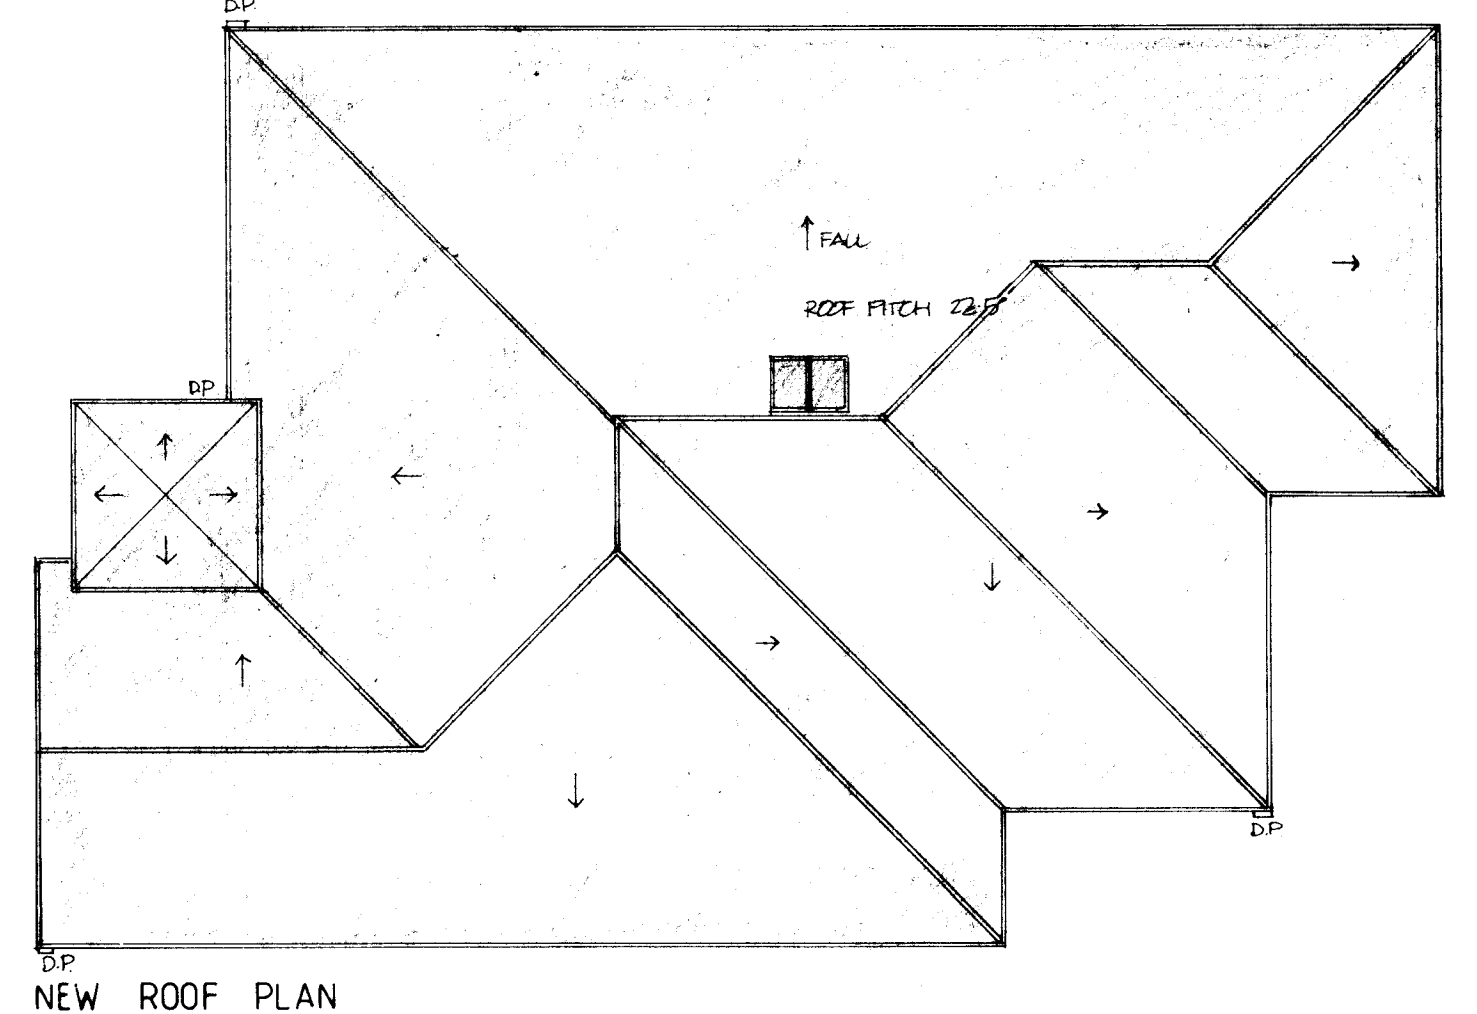

16 MARETIMO ST
BALGOWLAH HTS

THE FOUNTAINHEAD Pty Ltd,
ARCHITECTURAL AND INTERIOR DESIGN

Boatshed no.10 37 Nicholson street
EAST BALMAIN 2041, NSW
Tel - 555 9073 Fx - 810 8801

ADDITIONS AND ALTERATIONS TO:
No. 16 MARETIMO ST BALGOWLAH HEIGHTS
FOR MR & MRS SANDERSON
BUILDING APPLICATION

Date: July 91 Scale: 1:100 Dwg no: 91.10 / 010
Copyright - non transferable

M F D
91 10/01
01c