



STORMWATER DRAINAGE CONCEPT PLAN - MID FLOOR

- SCALE 1:100
- DPs AND ROOF DRAINAGE BY OTHERS.
 - U.N.O. GRATED DRAINS SHALL BE 150mm x 150mm

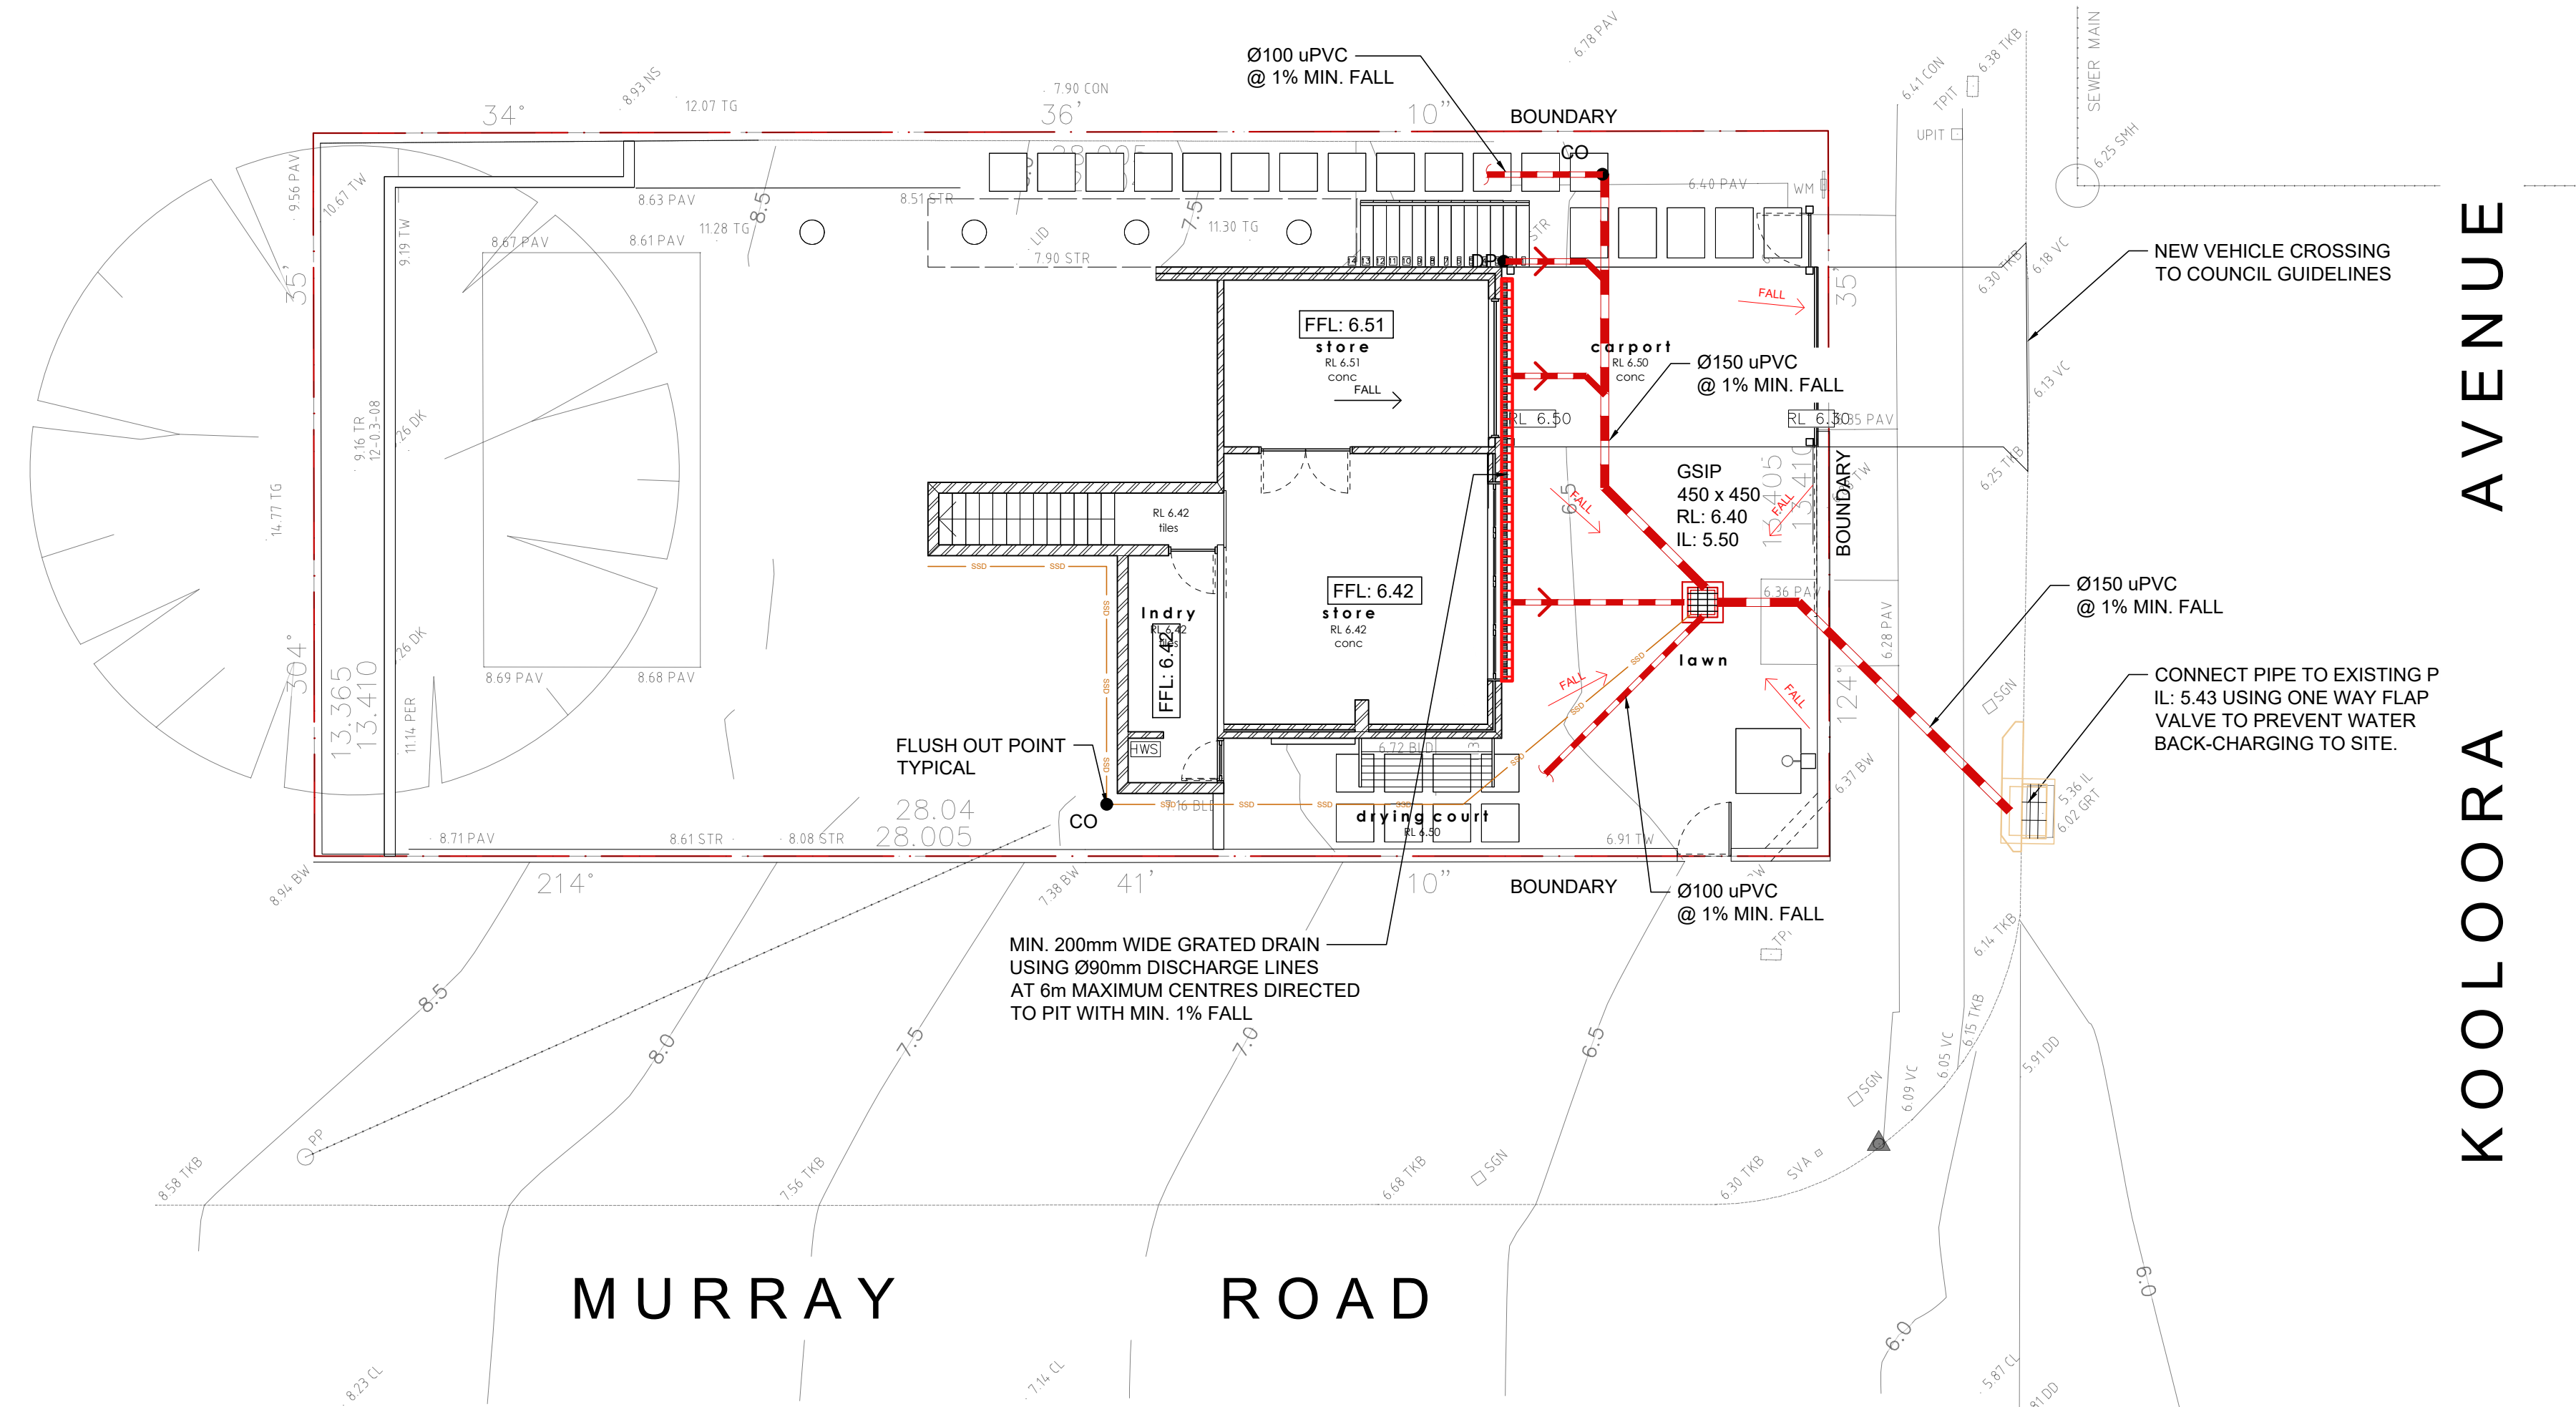

STORMWATER DRAINAGE CONCEPT PLAN - LOWER FLOOR

- SCALE 1:100
- DPs AND ROOF DRAINAGE BY OTHERS.
 - U.N.O. GRATED DRAINS SHALL BE 150mm x 150mm

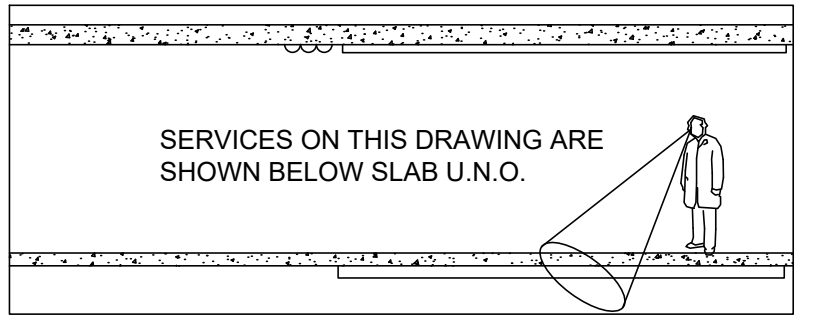

LEGEND

- PROPOSED NEW STORMWATER PIPE
- PROPOSED GRATED DRAIN
- PROPOSED NEW STORMWATER PIT
- DOWNPIPE

ISSUE	DESCRIPTION	APPROVED	DATE
3	RE-ISSUE DRAWING	-	09.08.23
2	ISSUE FOR 4.55	-	09.08.23
1	ISSUE FOR CONSTRUCTION CERTIFICATE	-	13.07.22

ARCHITECT
rachel hudson architect
web: www.rachelhudson.com.au
0410 323 564

BIRZULIS ASSOCIATES
CONSULTING STRUCTURAL & CIVIL ENGINEERS
583 DARLING STREET ROZELLE NSW 2039
tel: (02) 9555 7230 email: office@birzulisassociates.com
www.birzulisassociates.com

PROJECT
YEATES HOUSE
5 Kooloora Avenue, Freshwater NSW 2096

TITLE
STORMWATER DRAINAGE PLAN

SCALES	as noted @ A1	DATE	JUL' 2022
DRAWN	DESIGN	VERIFIED	APPROVED
C.KE	G.K/M.G		

This drawing is the copyright of Birzulis Associates Pty Ltd and may not be altered, reproduced or transmitted in any form or by any means in part or in whole without the written permission of Birzulis Associates Pty Ltd. All levels and dimensions are to be checked and verified on site prior to the commencement of any work, making of shop drawings or fabrication of components. Do not scale drawings. Use figured dimensions.

ISSUE	PROJECT No.	DRAWING No.
2	8551	C.04