

SITE LOCATION

LEGEND

- FIRE HYDRANT
- EXISTING COLD WATER
- EXISTING FIRE HYD. LINE
- NEW COLD WATER LINE
- NEW GAS LINE

REV	ISSUE	BY	CHKD	DATE
A	PRELIMINARY ISSUE	AM	AT	07.06.06

DISCIPLINE	DRG NO.	REV	REASON FOR ISSU	AUTHORISATION
ARCHITECTURAL	21.04.06			
STRUCTURAL				
LANDSCAPE				
ELECTRICAL				
CIVIL	26.05.06			

HYDRAULIC ENGINEERS:
thomsonkane
 Consulting Hydraulic and Fire Engineers
 281 Pacific Highway, North Sydney NSW 2060
 Phone: (02) 9955 0788 Fax: (02) 9954 5532
 Email: tk@thomsonkane.com.au
 WWW.THOMSONKANE.COM.AU
 ACN 109 803 849
 THIS DRAWING IS COPYRIGHT ©

ARCHITECTS:
Denis Leech Associates P/L
 350 George Street, Sydney NSW 2000
 Tel: (02) 9997 7288 Fax: (02) 9997 316

MASTER PLANNING:
Wolski, Lyncenko & Brechnock
 115 Military Road, Neutral Bay NSW 2089
 Tel: (02) 9953 8477 Fax: (02) 9953 856

ELECTRICAL:
WEBB AUSTRALIA
 37 Ryde Road, Pymble NSW 2073
 Tel: (02) 9418 1444 Fax: (02) 9418 1191


ENVIRONMENTAL:
WP Brown & Partners Pty Ltd
 Level 2, 82 Waterloo Road
 Macquarie Park NSW 2113
 Tel: (02) 9900 1000 Fax: (02) 9900 109

LANDSCAPE:
Place Planning & Design P/L
 Suite 10, Norberry Terrace, 177 Pacific Hwy
 North Sydney NSW 2060
 Tel: (02) 9959 5021 Fax: (02) 9959 550

PROJECT:
PROPOSED RESIDENTIAL SUBDIVISION - 5 WARRIEWOOD VALLEY, WARRIEWOOD NSW

TITLE: HYDRAULIC SERVICES
SITE PLAN WATER AND GAS

SCALE:	PROJECT No:	CAD REF:
1:500	4733-2H	T:TKNEW/
DATE:	DRAWING NUMBER:	REVISION:
MAY '06	H-03	A
DRAWN BY:	CHKD BY:	
AT		

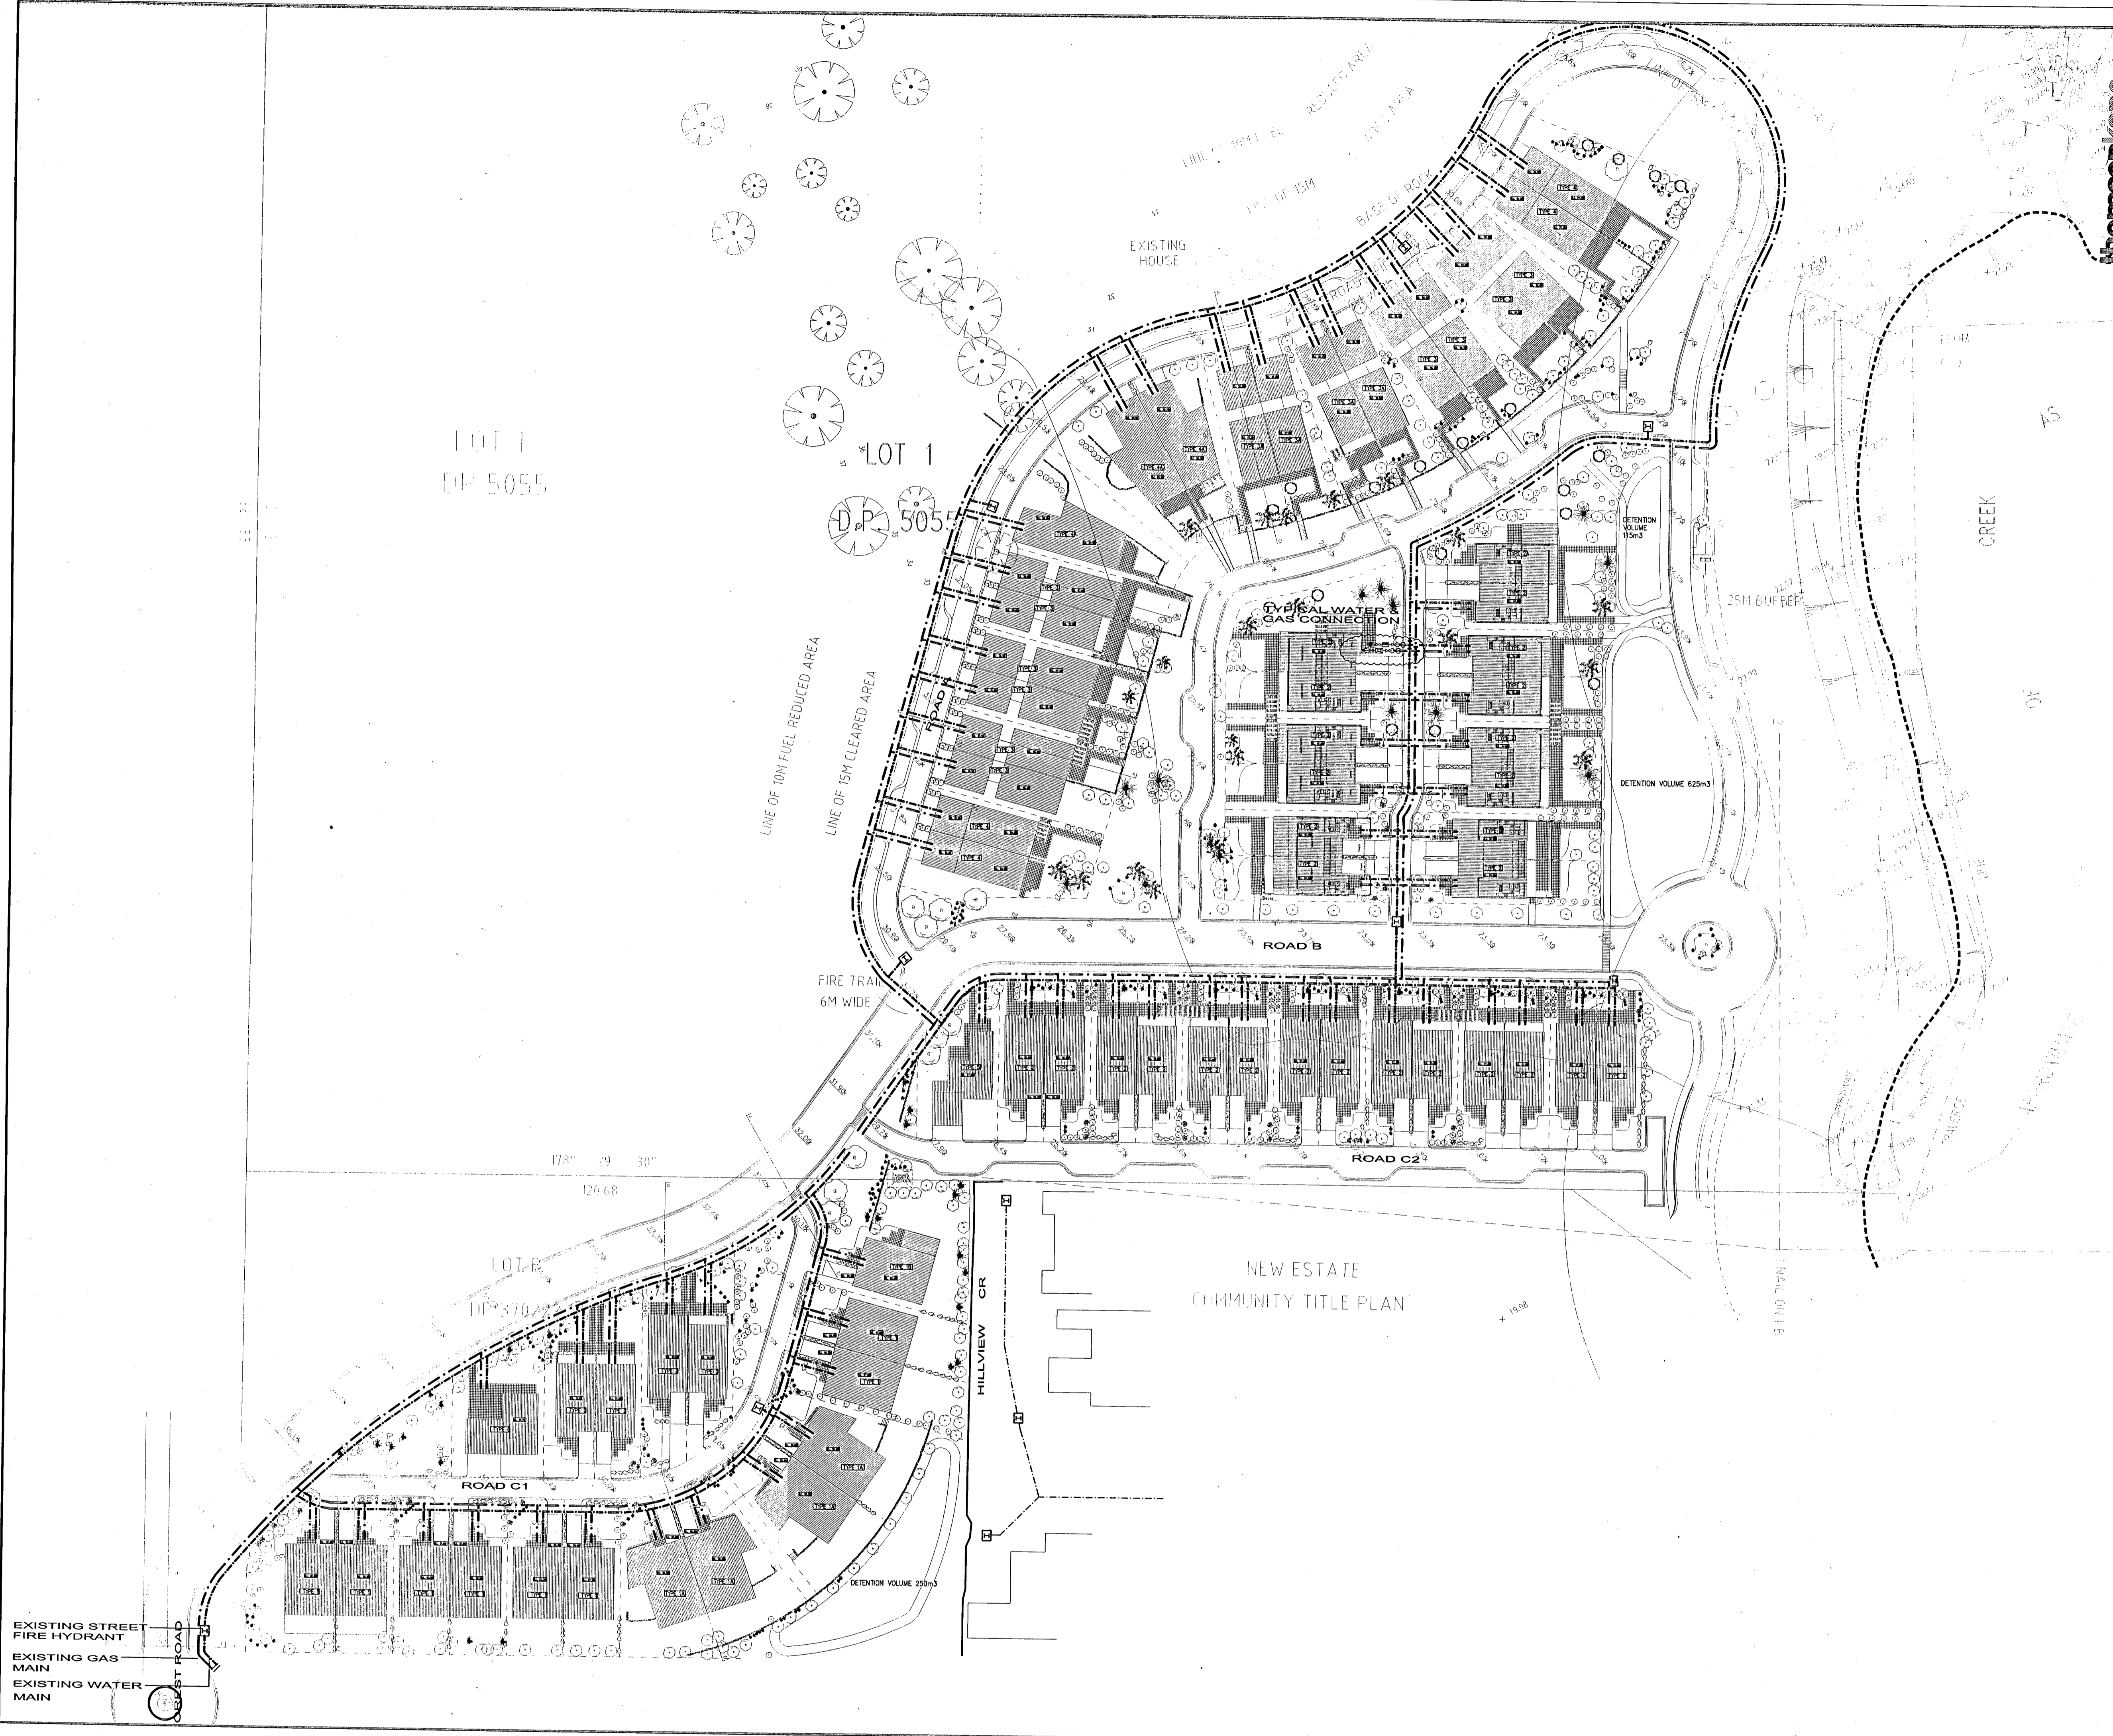

EXISTING STREET
 FIRE HYDRANT
 EXISTING GAS
 MAIN
 EXISTING WATER
 MAIN