

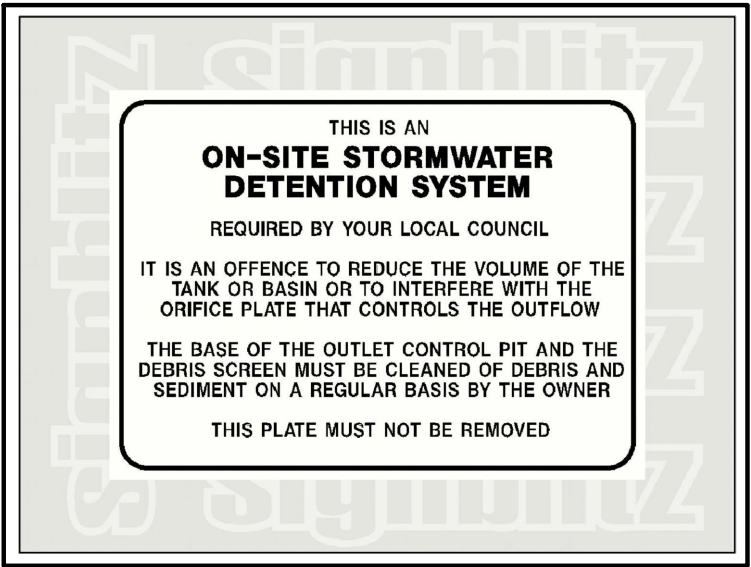
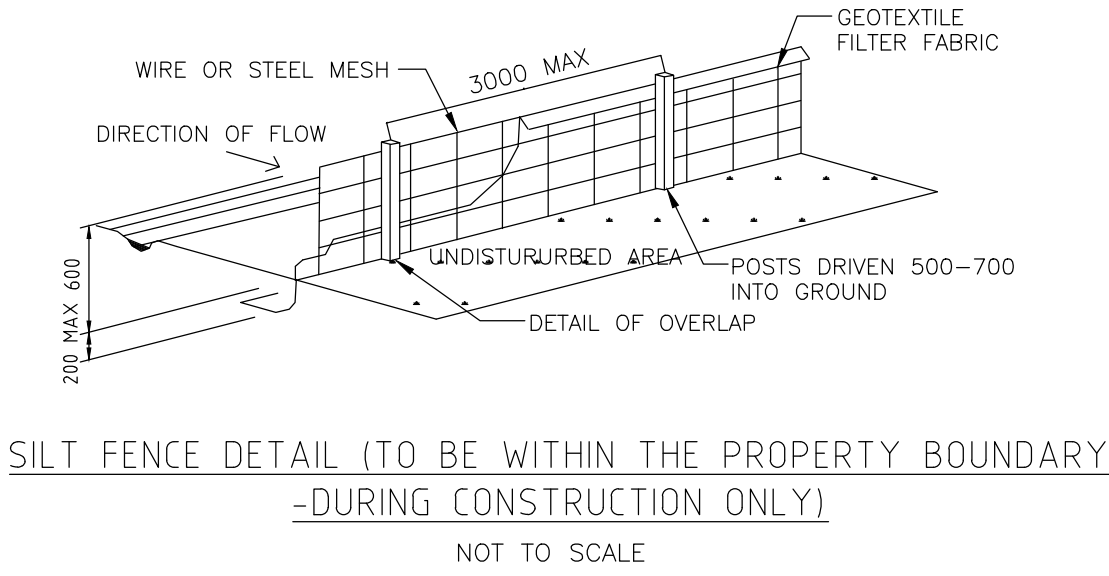


STORMWATER DRAINAGE LAYOUT PLAN
SCALE:- 1:100 @ A1

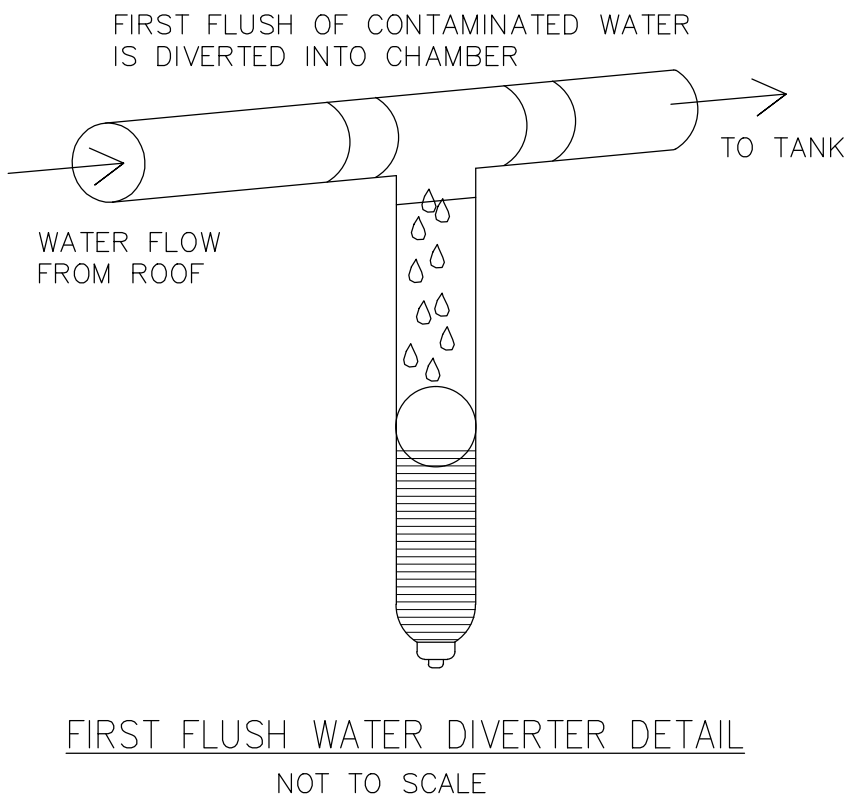


OSD SIGN
NOT TO SCALE

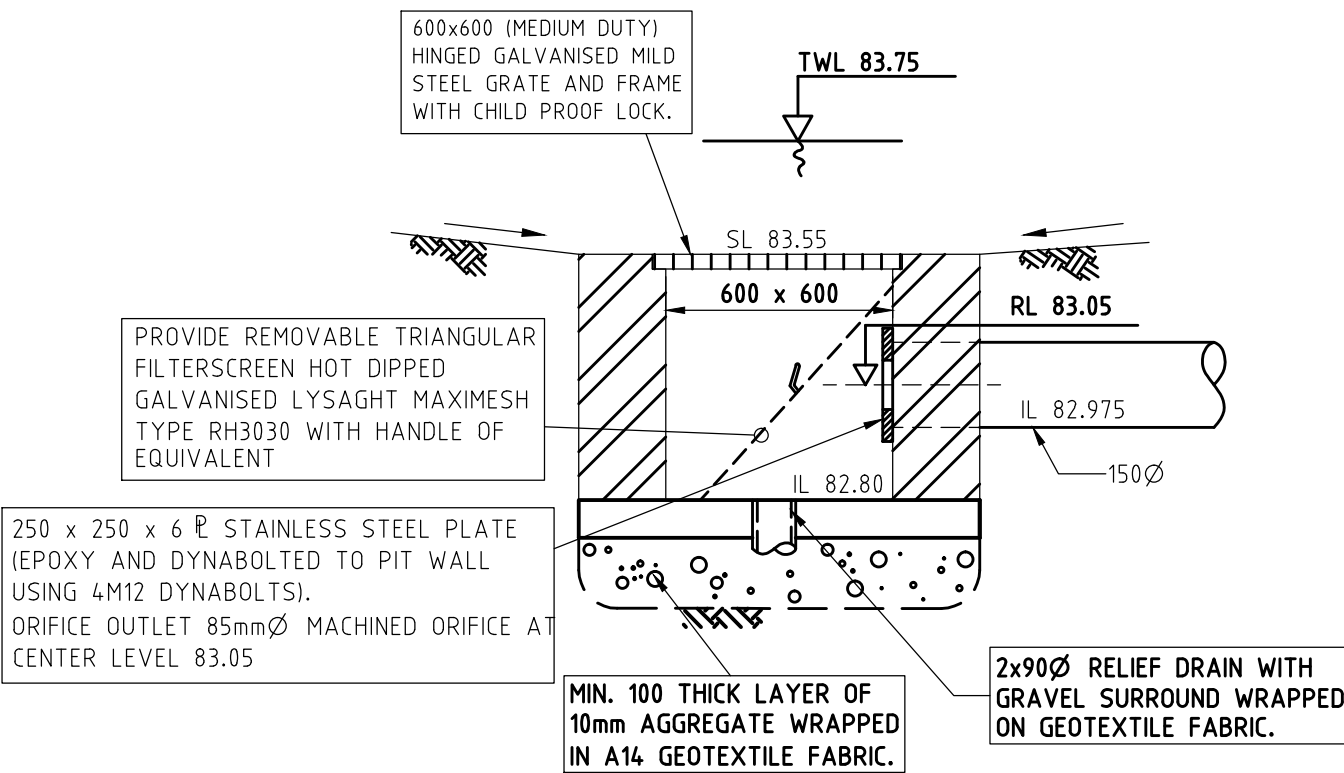

O.S.D. BASIN AND CONTROL PIT (PIT - P7)

SECTION B
SCALE NTS 1

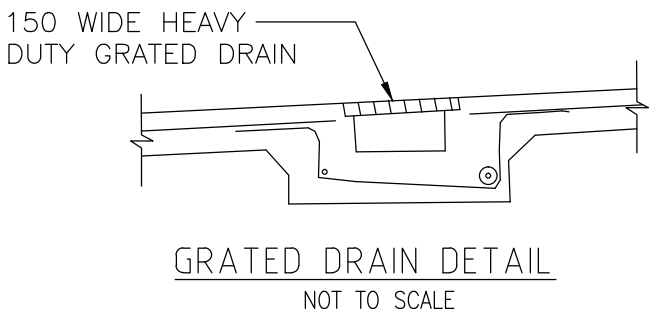




ON SITE DETENTION
WARNING SIGN

NOTE:-

1 - SIGN SHALL BE PLACED IN A CLEAR AND VISIBLE LOCATION

COLOURS:-

- TRIANGLE AND "WARNING" - RED
- WATER - BLUE
- FIGURE AND OTHER LETTERING - BLACK

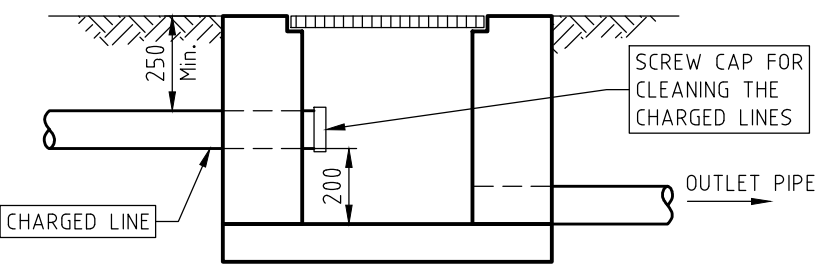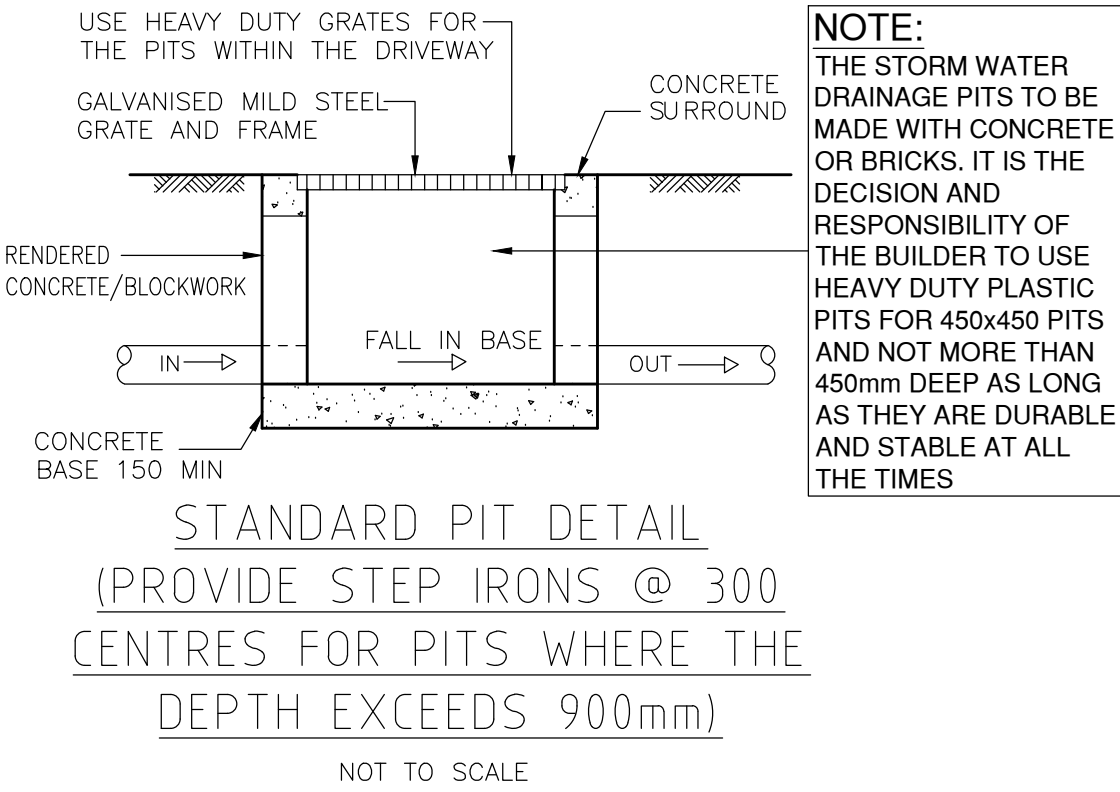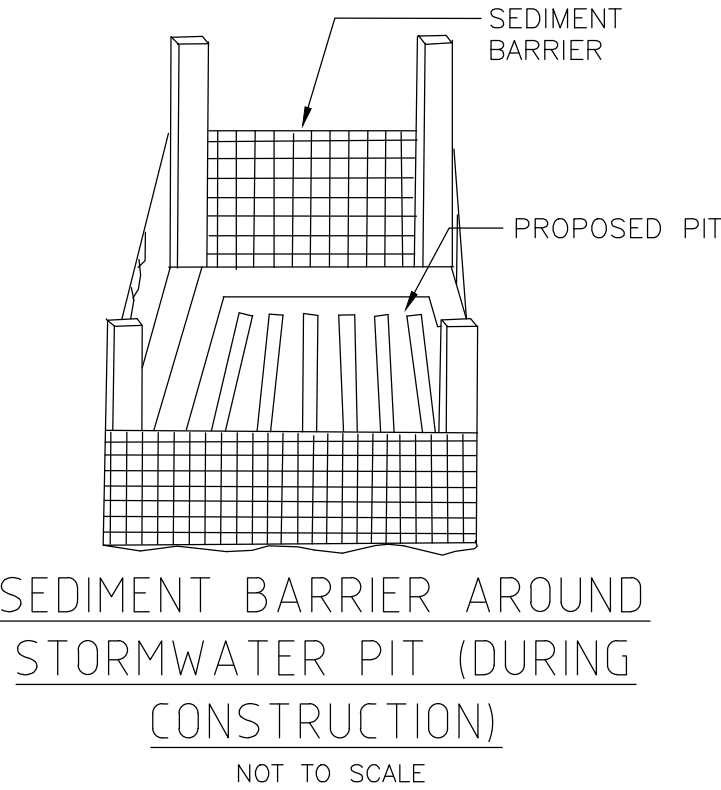

TYPICAL CHARGED LINE
CLEAN OUT CONNECTION TO A PIT
NOT TO SCALE

			DESIGN BY:	VNK CONSULTING PTY LTD PO BOX 9118 Harris Park NSW 2150 Mobile: 0401 132 386 Email: VNKCONSULTING@GMAIL.COM	Drawing Title:		DESIGNED	NL	Project:	Ref No.
							DRAWN	AJ	PROPOSED DWELLING LOT B (No. 62) ELLERY PARADE SEAFORTH NSW 2092	280322-02
			PRINCIPAL ENGINEER:	LOGAN N LOGESWARAN			DATUM	AHD		Issue:
			QUALIFICATIONS:	BscEng, MEng, MEngStud, M.ASCE, MIEAust, CPEng, NER			DATE	28.03.2022		B
B	30.03.2022	RE-ISSUED FOR DA APPROVAL	AJ							
A	28.03.2022	ISSUED FOR DA APPROVAL	AJ							
Issue	Date	Description	BY							SHEET 2 of 2