





SECTION

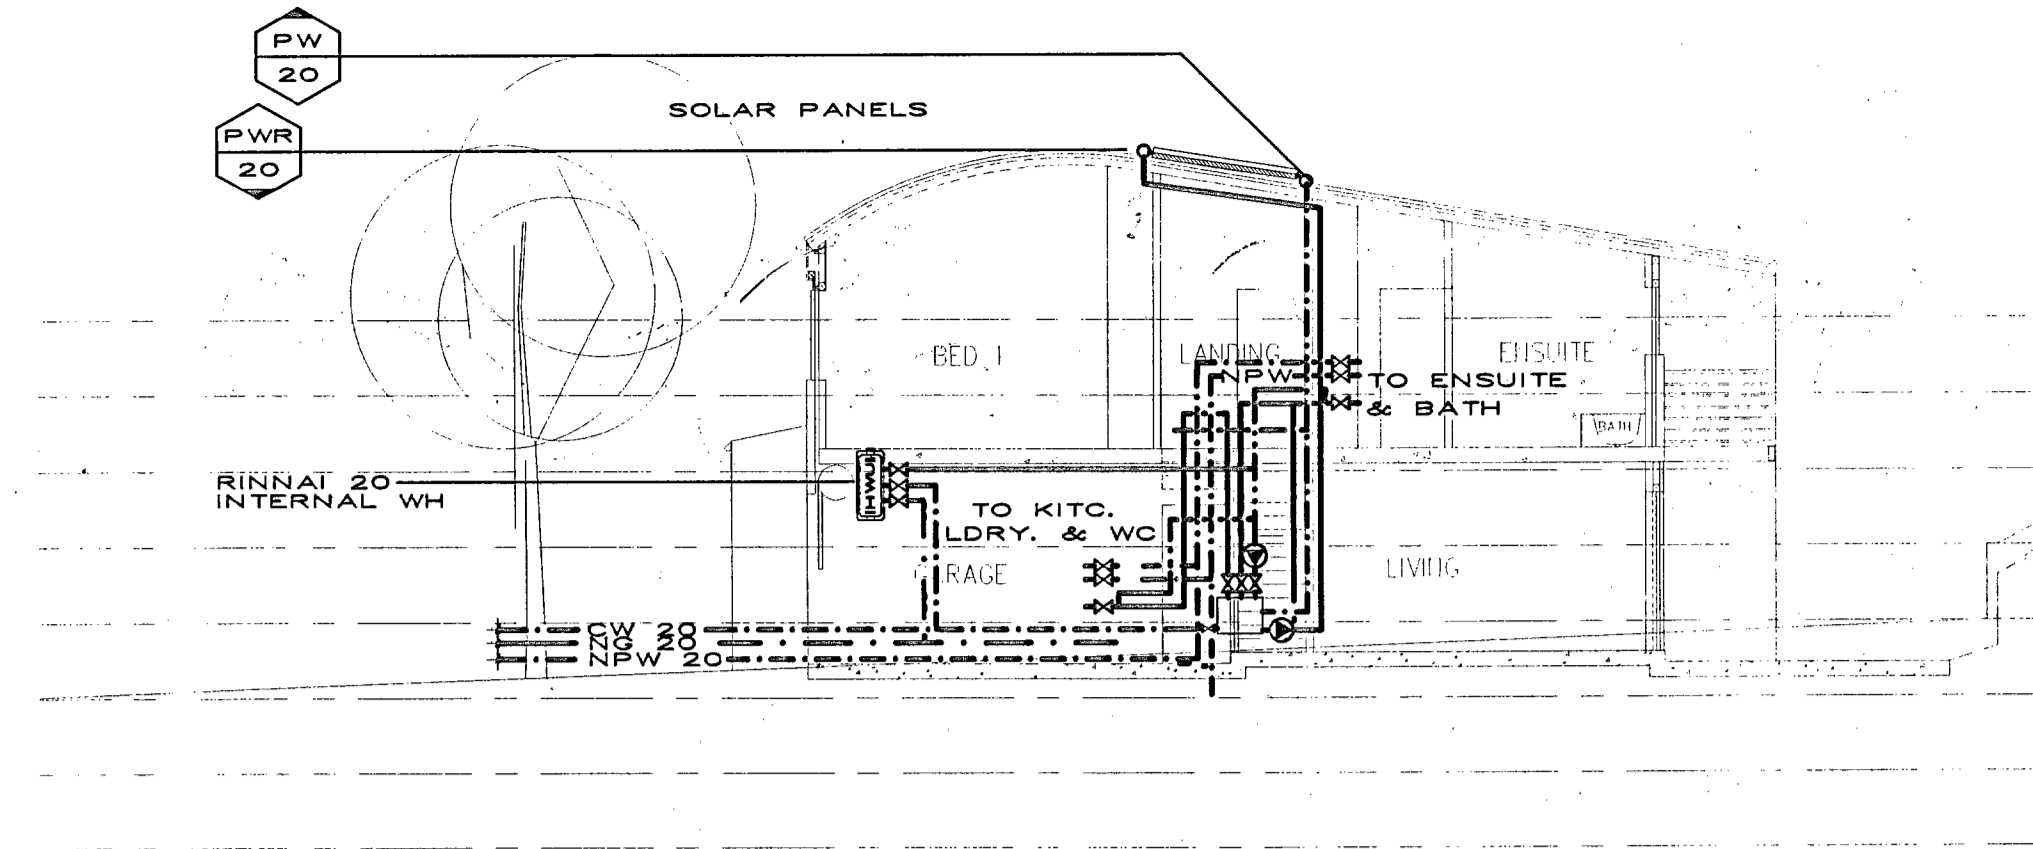


SECTION

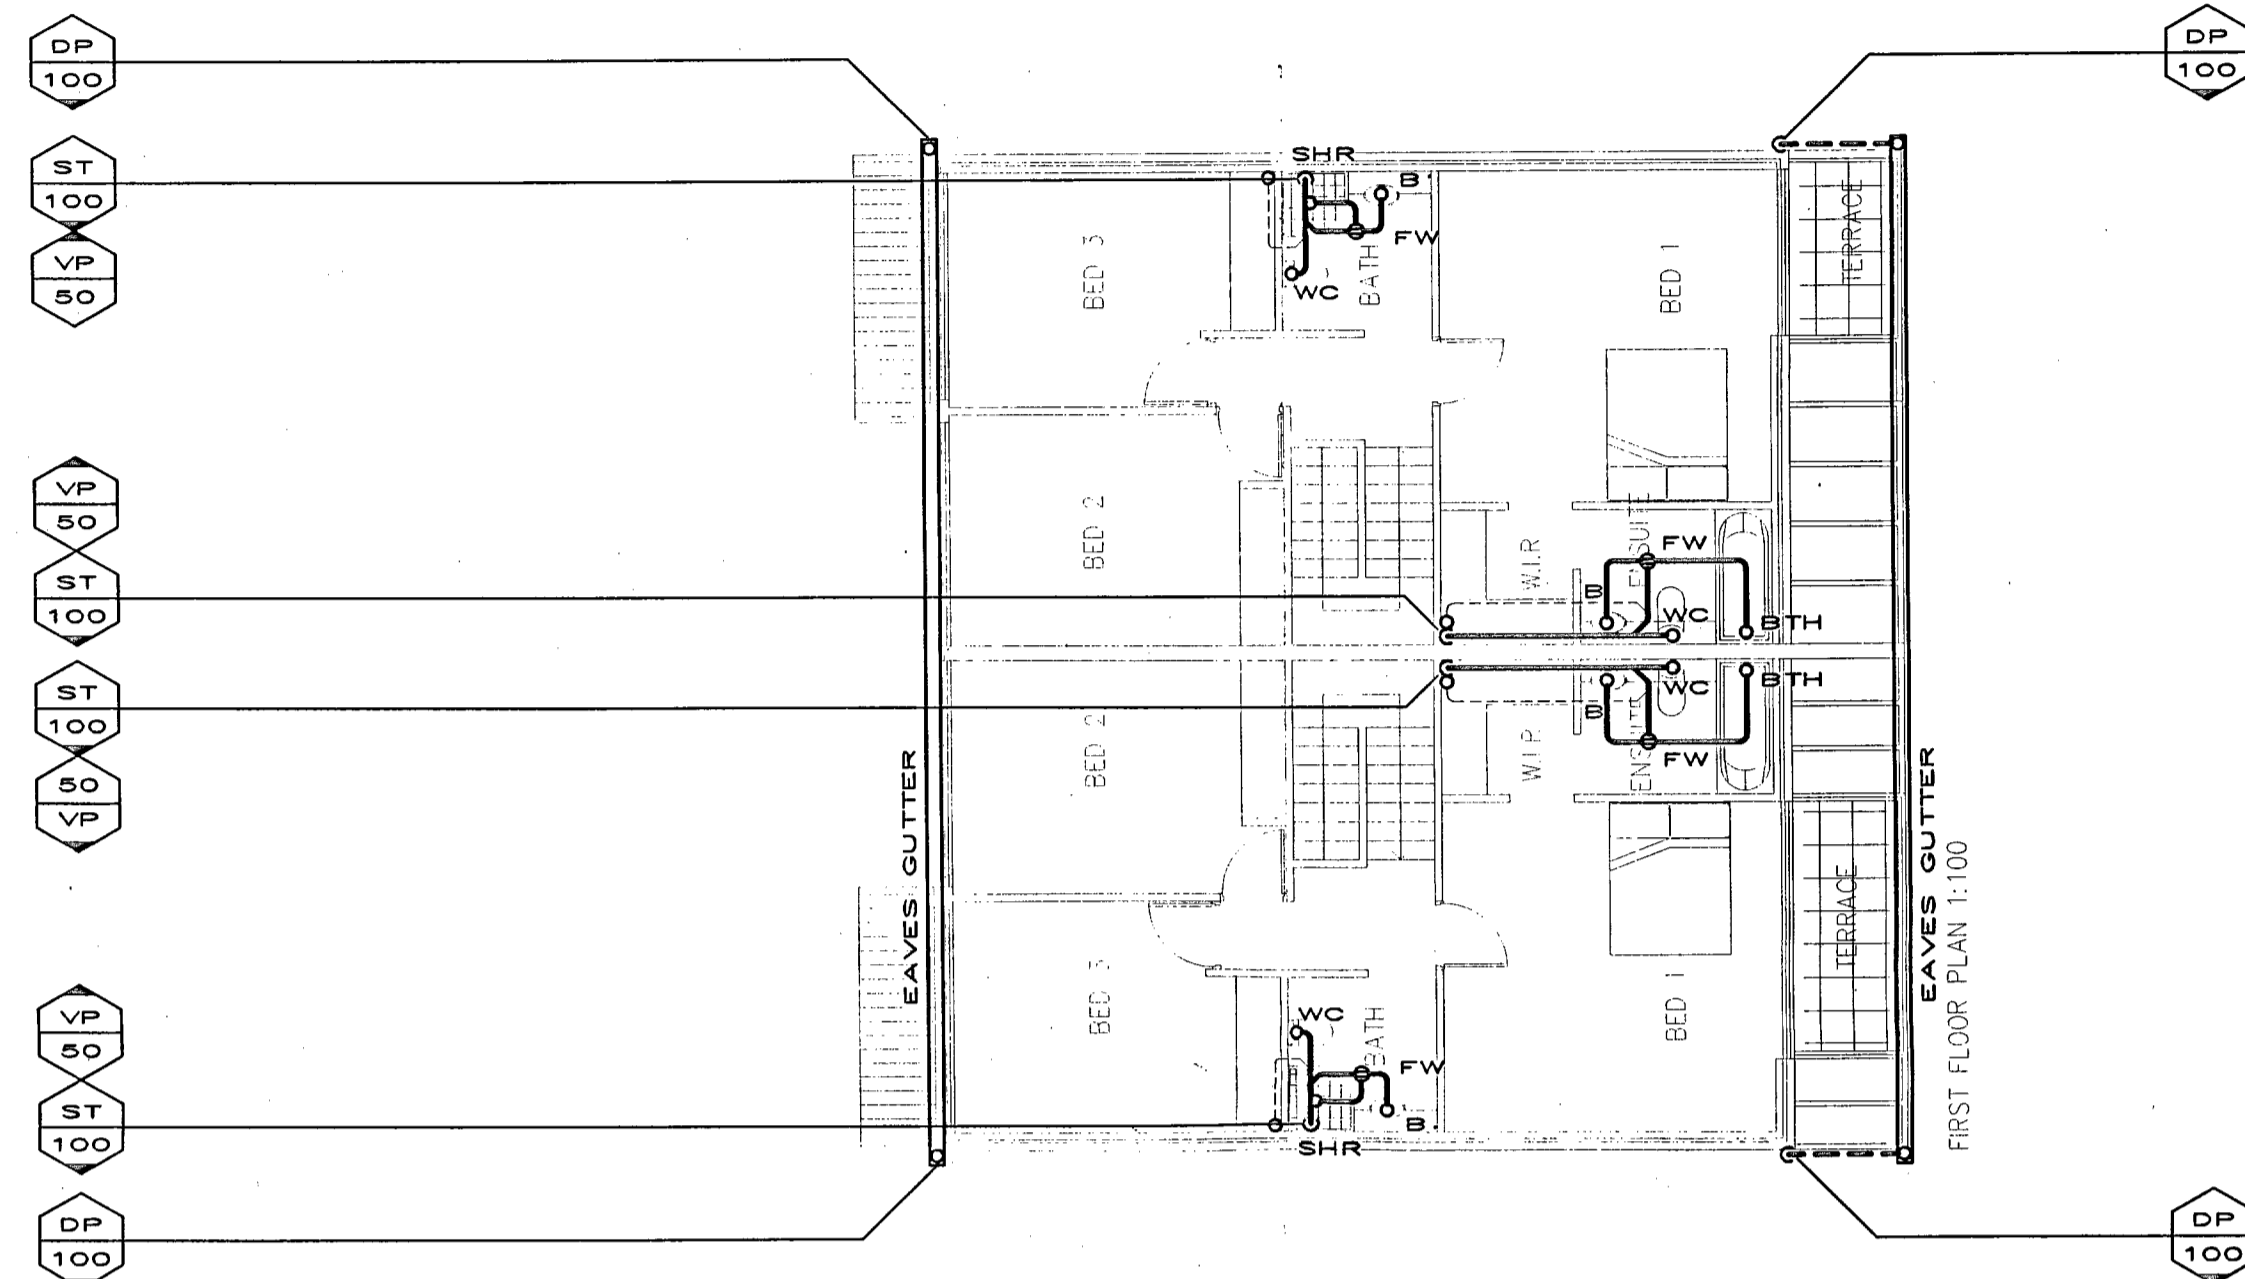

FIRST FLOOR PLAN

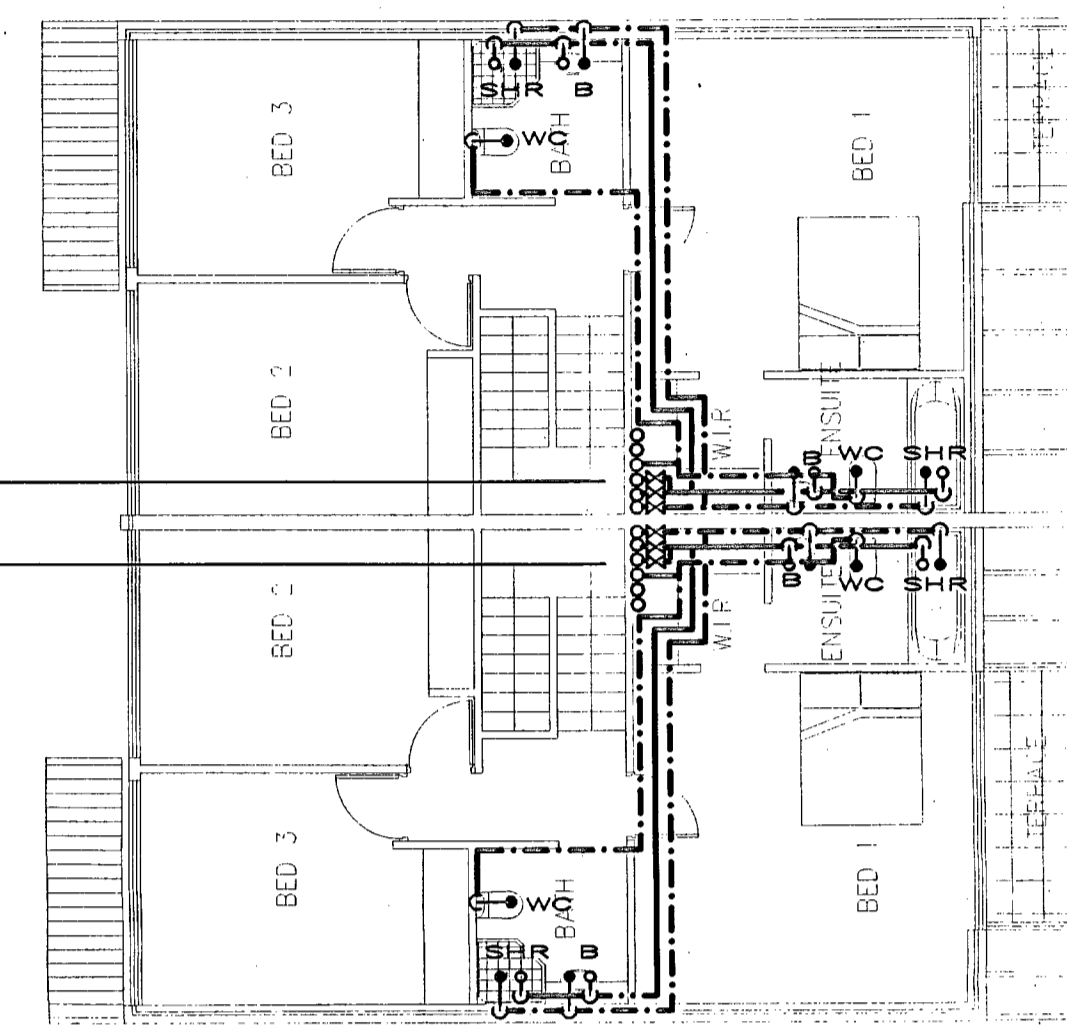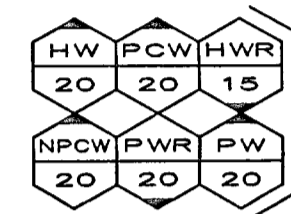


FIRST FLOOR PLAN

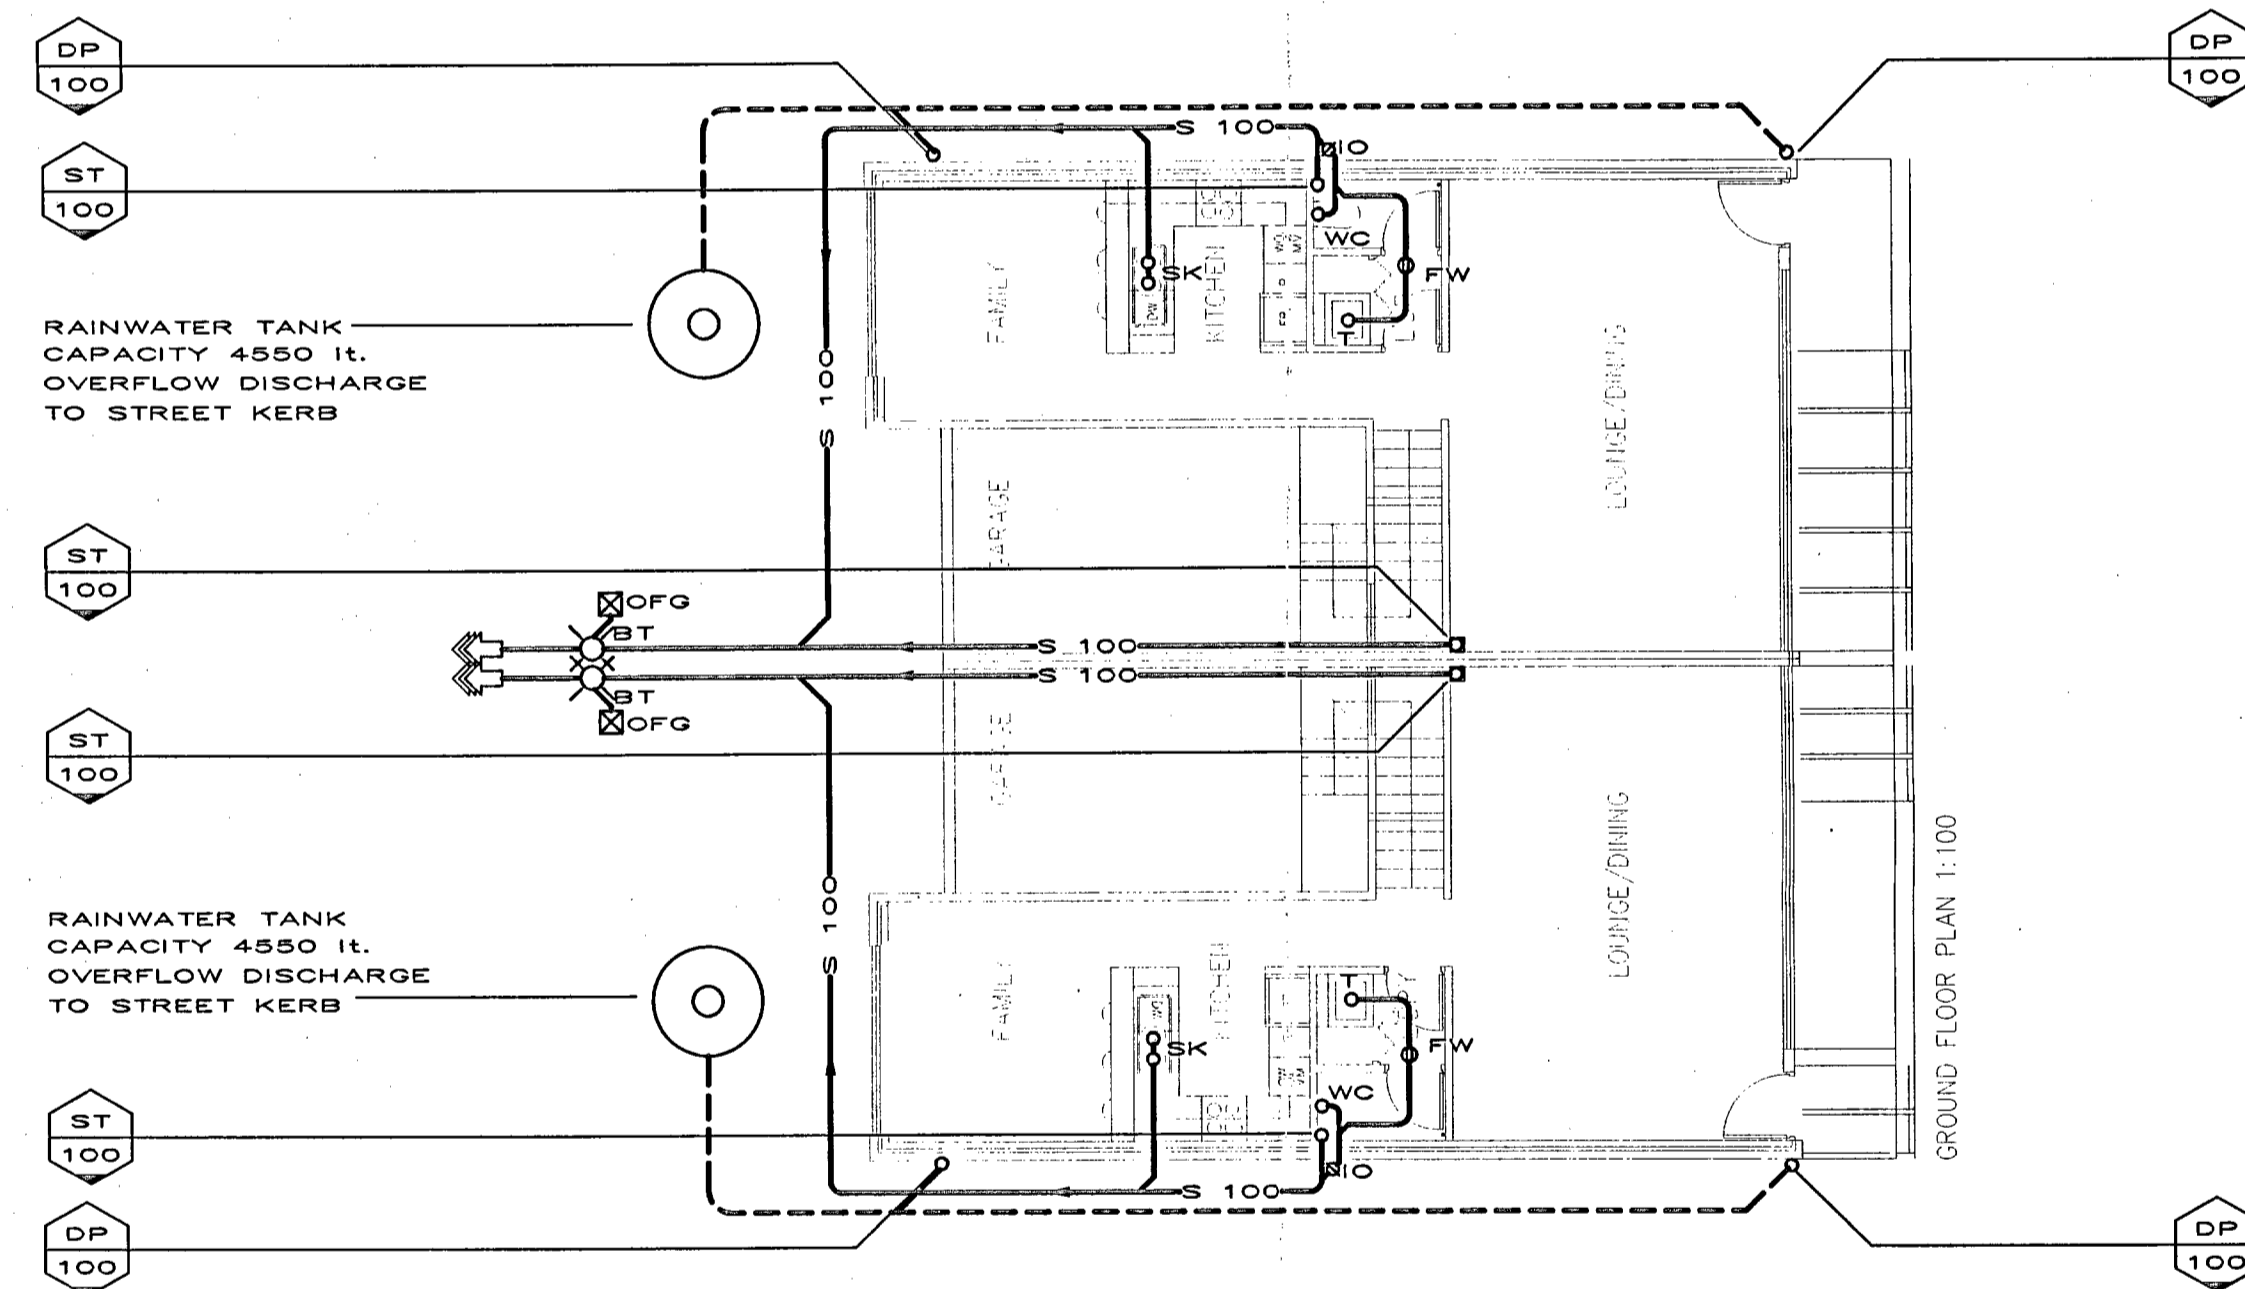

GROUND FLOOR PLAN

SANITARY PLUMBING DRAINAGE

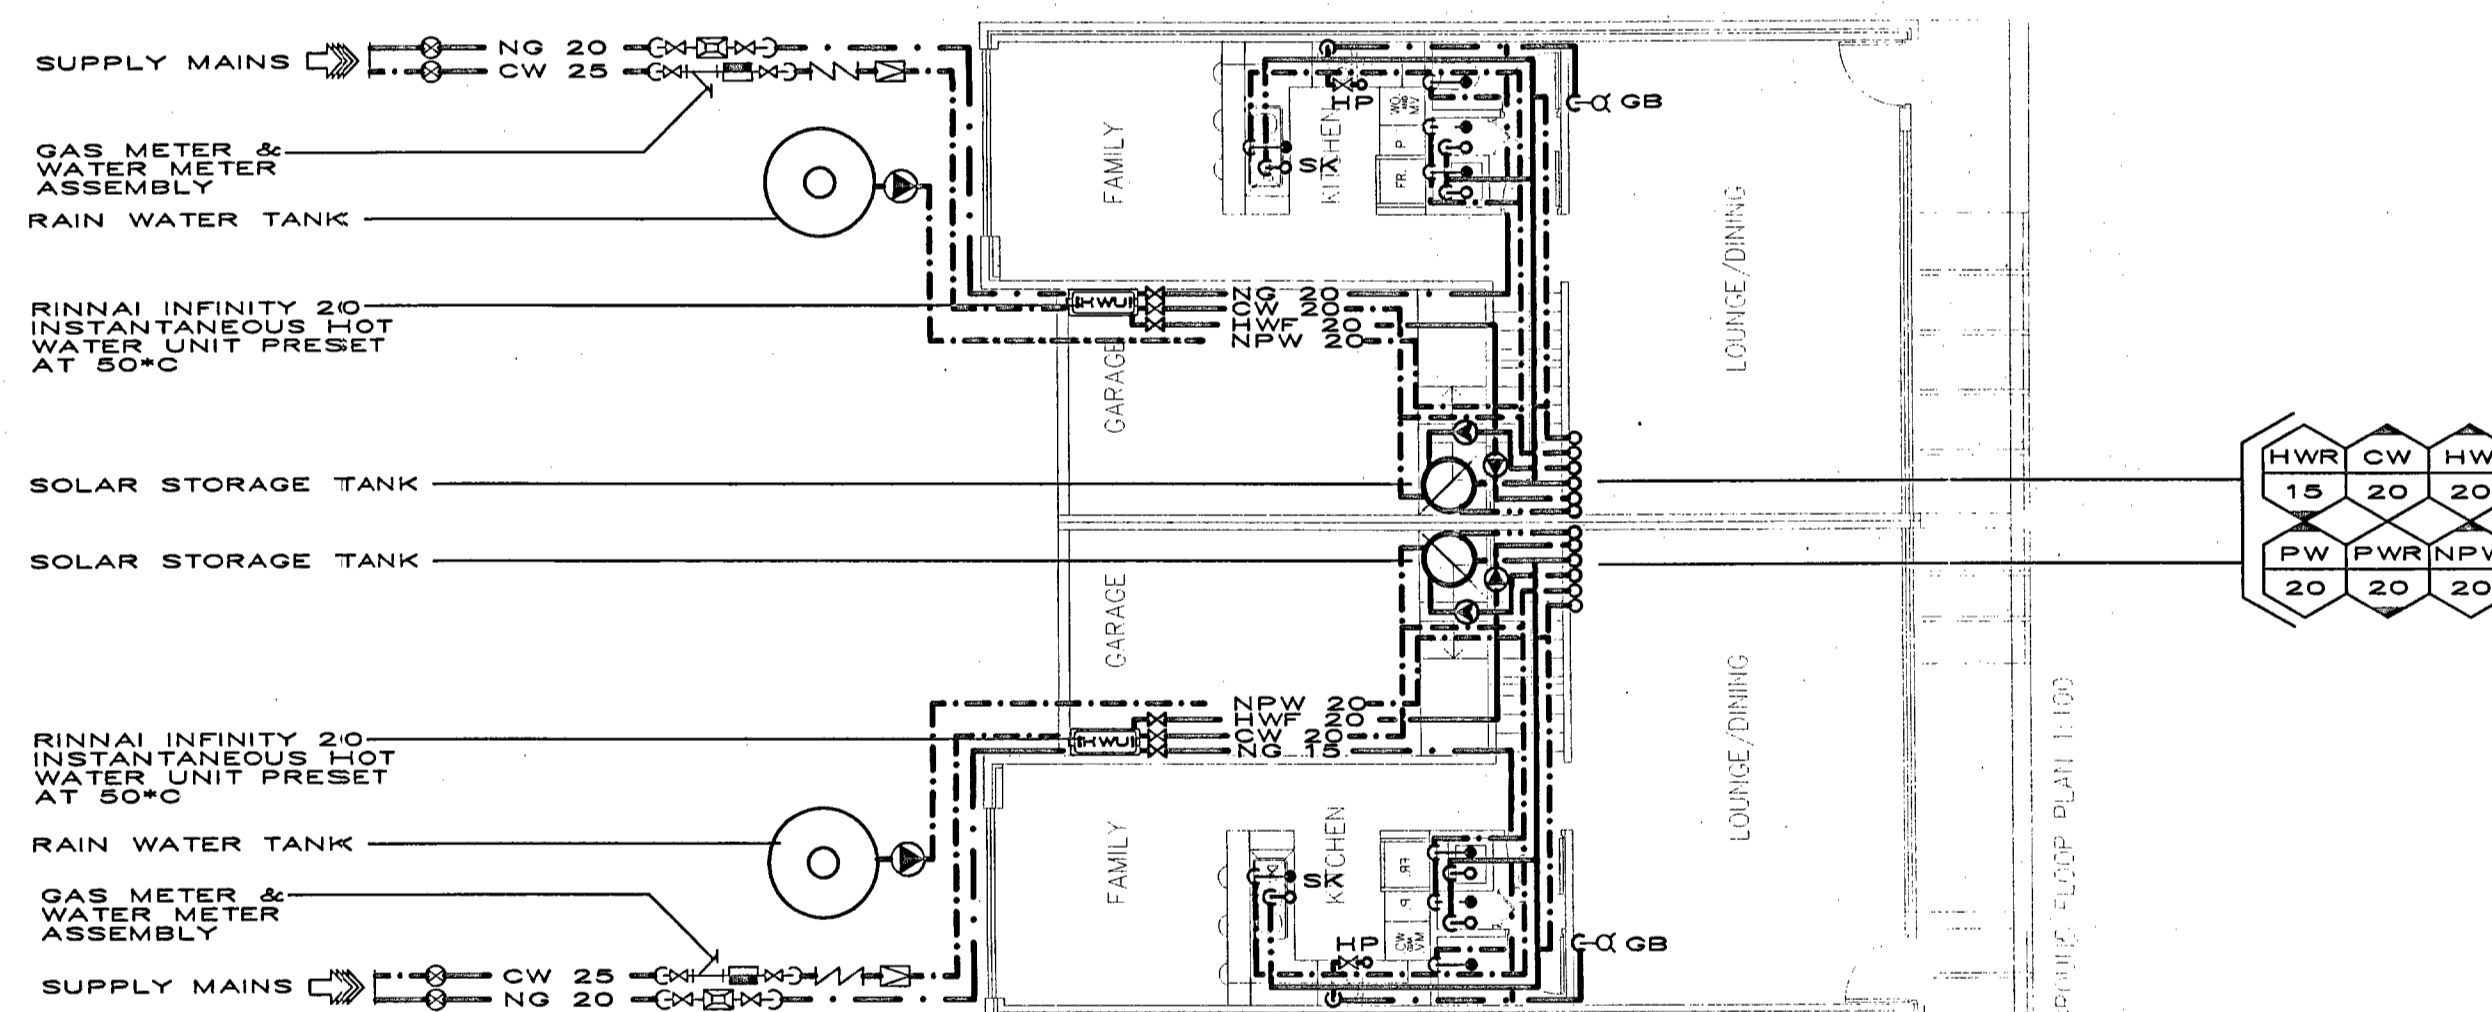

GROUND FLOOR PLAN

WATER & GAS SERVICES

**SITE PLAN**

VENT. FIRE, WATER & GAS IN STRATA

PLUMBING & STORMWATER OUT OF STRATA

**STRATA ZONES**

NOTE:  
● FOR GENERAL NOTES AND LEGEND REFER TO COVER SHEET H-00

**KEY PLAN**

1 - TYPE 1  
1A - TYPE 1A  
2 - TYPE 2  
2A - TYPE 2A  
3 - TYPE 3  
3A - TYPE 3A  
4 - TYPE 4  
4A - TYPE 4A  
6 - TYPE 6

REV	ISSUE	AM	AT	DATE
A	PRELIMINARY ISSUE	AM	AT	07.06.06

SCHEDULE OF REFERENCE FILES

DISCIPLINE	DRG NO.	REV	TK QA SYSTEM REASON FOR ISSUE
ARCHITECTURAL	21.04.06		PRELIMINARY
STRUCTURAL			
LANDSCAPE			
ELECTRICAL			
CIVIL	26.05.06		VERIFICATION OF LATEST AMENDMENT

HYDRAULIC ENGINEERS:

**Thomsonkane**  
Consulting Hydraulic and Fire Engineers  
281 Pacific Highway, North Sydney NSW 2060  
Phone: (02) 9955 0768 Fax: (02) 9954 5632  
Email: h@thomsonkane.com.au  
WWW.THOMSONKANE.COM.AU  
ACN 109 803 849  
THIS DRAWING IS COPYRIGHT ©

ARCHITECTS:

**Denis Leech Associates P/L**  
350 George Street, Sydney NSW 2000  
Tel: (02) 9997 7266 Fax: (02) 9997 3164

MASTER PLANNING:

**Wolski, Lyncenko & Brechnock**  
115 Military Road, Neutral Bay NSW 2089  
Tel: (02) 9953 8477 Fax: (02) 9953 8557

ELECTRICAL:

**WEBB AUSTRALIA**  
37 Ryde Road, Pymble NSW 2073  
Tel: (02) 9418 1444 Fax: (02) 9418 1191

ENVIRONMENTAL:

**WP Brown & Partners Pty Ltd**  
Level 2, 82 Waterloo Road  
Macquarie Park NSW 2113  
Tel: (02) 9900 1000 Fax: (02) 9900 1099

LANDSCAPE:

**Place Planning & Design P/L**  
Suite 10, Norberry Terrace, 177 Pacific Hwy  
North Sydney NSW 2060  
Tel: (02) 9959 5021 Fax: (02) 9959 5802

PROJECT:

**PROPOSED RESIDENTIAL SUBDIVISION - 5 WARRIEWOOD VALLEY, WARRIEWOOD NSW**

TITLE: HYDRAULIC SERVICES

**TYPICAL HOUSE TYPE 3 SEWER, WATER & GAS**

SCALE: 1:100	PROJECT NO: CAD REF:
DATE: MAY '06	4733-2H T: TKNEW/
DRAWN BY:	DRAWING NUMBER: REVISION
CHKD BY: AT	H-06 A