

AC	AIR CONDITIONING
E	ELECTRICAL SWITCHBOARD
PH	FIRE HYDRANT
PHR	FIRE HOSE REEL
FIP	FIRE INDICATOR PANEL
DP	DOWNPIPE
OF	OVERFLOW
RD	ROLLER DOOR
DRP	DRAINAGE POINT
FG	FIXED GLAZING
LO	LOUVRES (OPERABLE)
GA	GATE
SW	SLIDING WINDOW
OW	OPENABLE WINDOW
RF	RENDERED FINISH
MF	MOSAIC TILED FINISH
ME	MECHANICAL/ELECTRICAL RISER
HR	HYDRAULIC RISER
V	FINISHED RL
V	STRUCTURAL RL
H	HOSETAP
G	GAS POINT

CHANGE SUMMARY

ISSUE STATUS

CLIENT	Fortis Development Group
JOB	1728 Fortis South Steyne 34-35 South Steyne Manly NSW

durbach block jagers

Level 2, 9 Roslyn Street
Potts Point NSW 2011
02 8297 3500
durbachblockjagers.com


Nominated Architects
Neil Durbach NSW Reg. No 5850
David Jagers NSW Reg. No 9999


SCALE
1:100 @ A1 / 1:200 @ A3


2m 4m



PROJECT NO.	ISSUE	REV.
1728	S4.55	DA-L
DRAWING NO.		
A-DA-110-000		

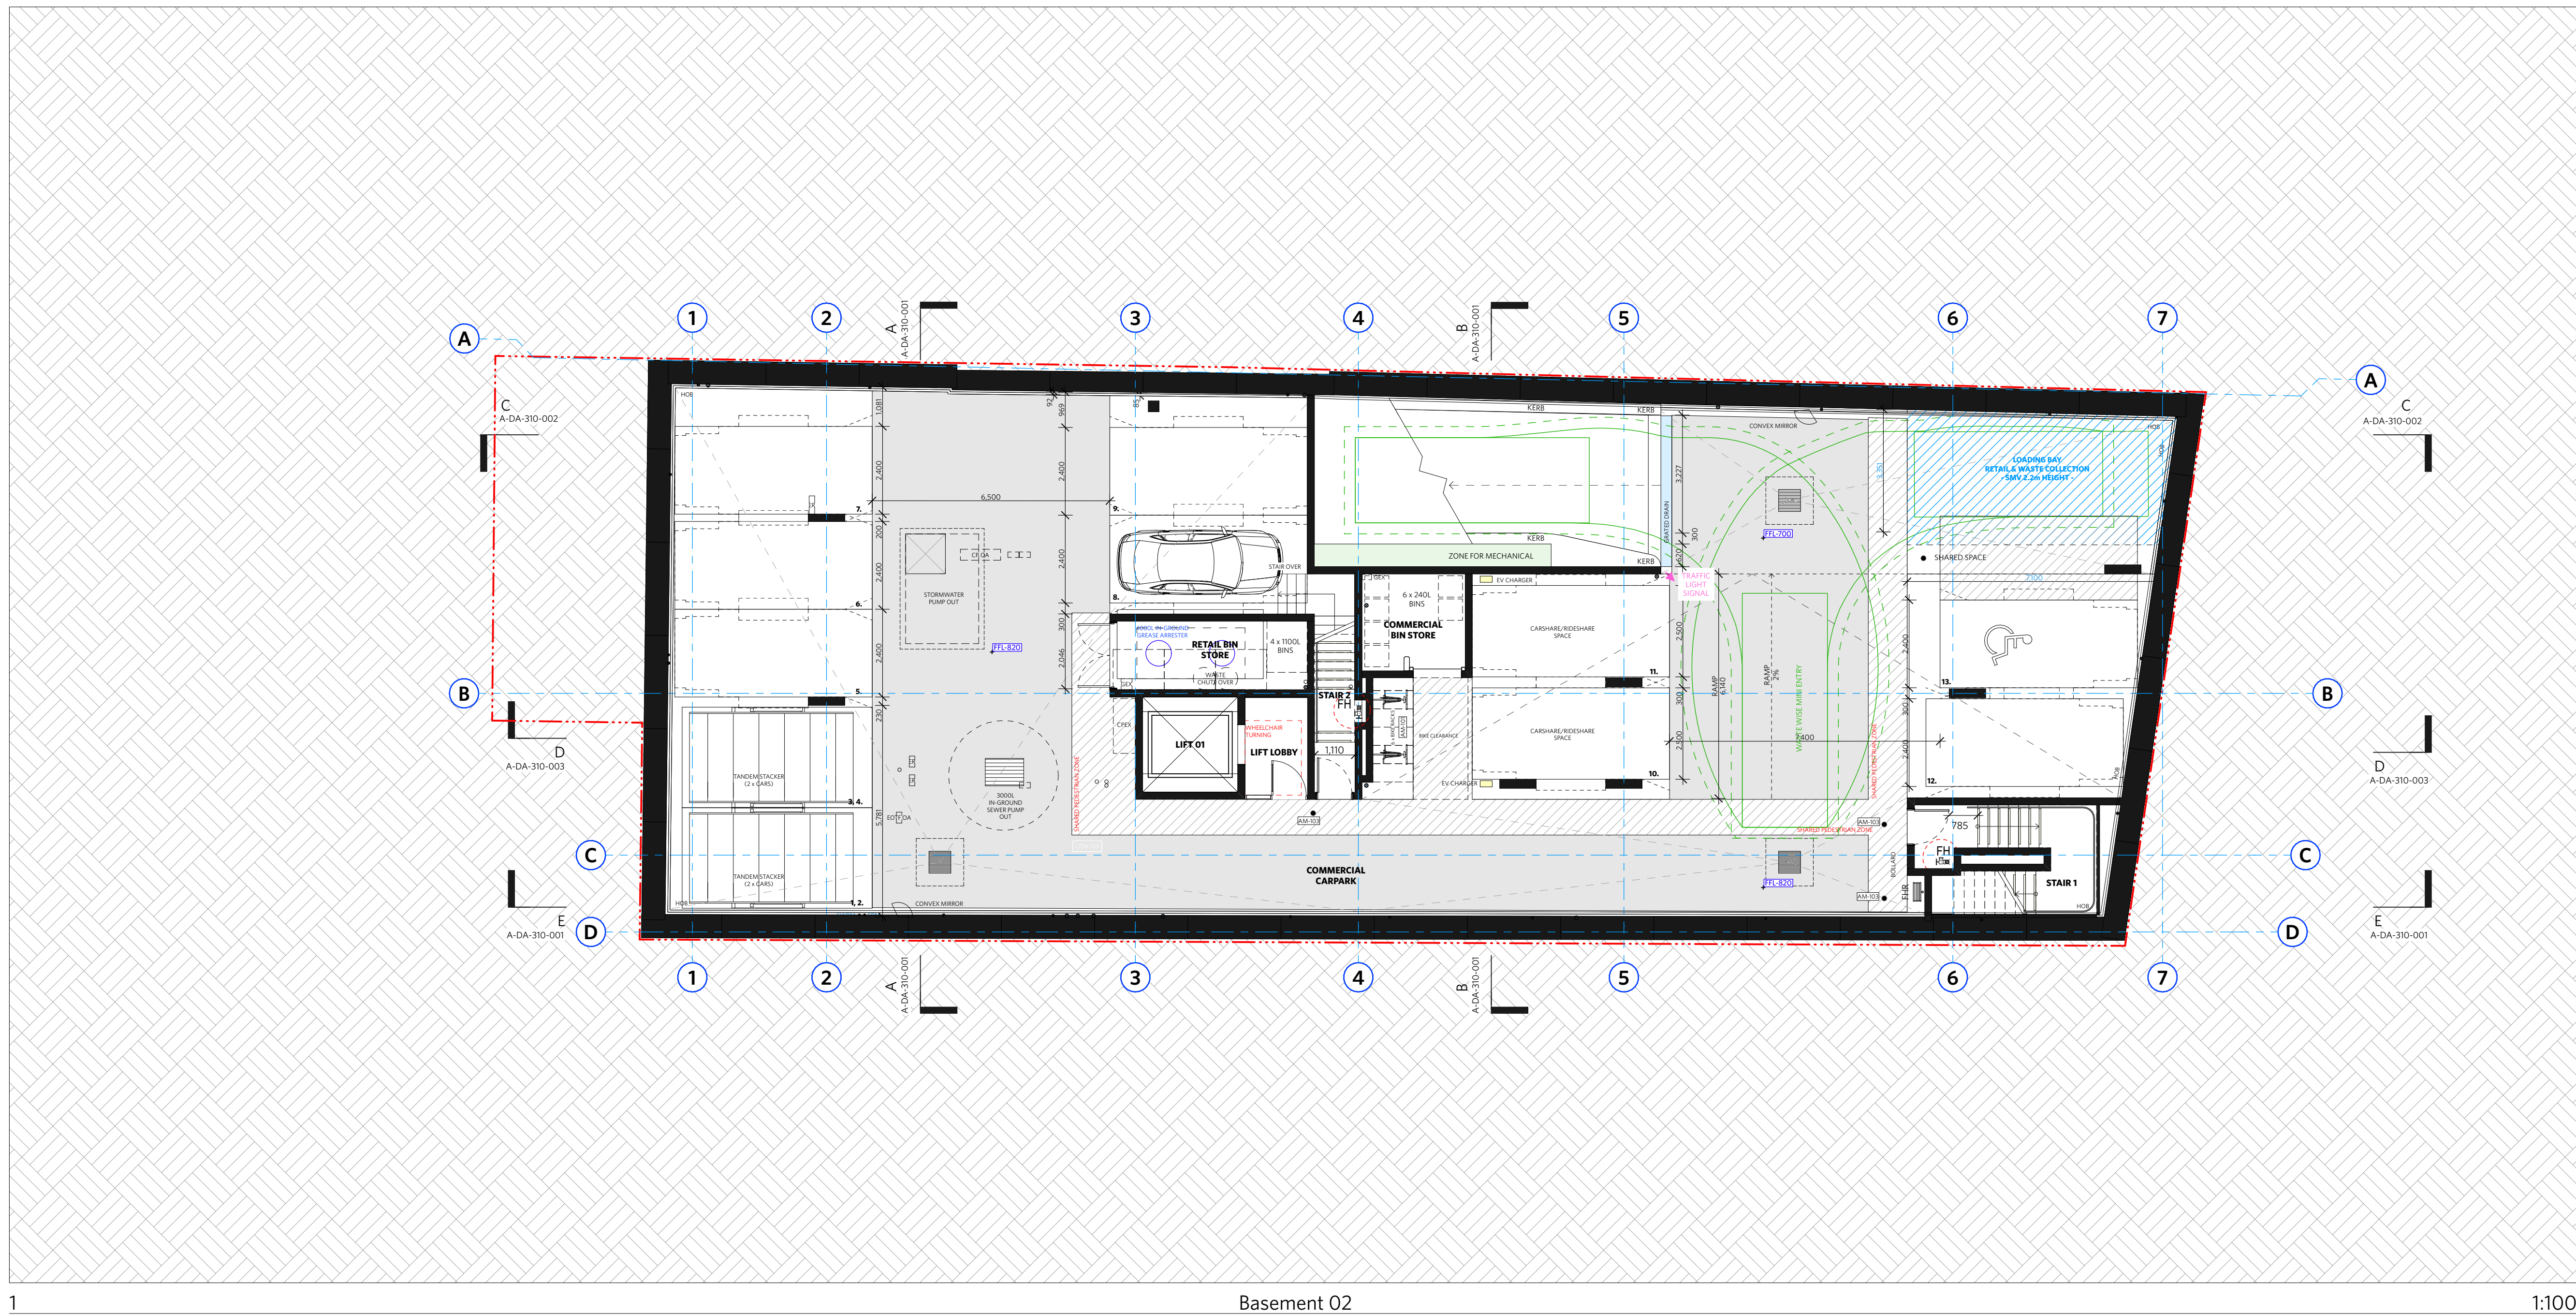

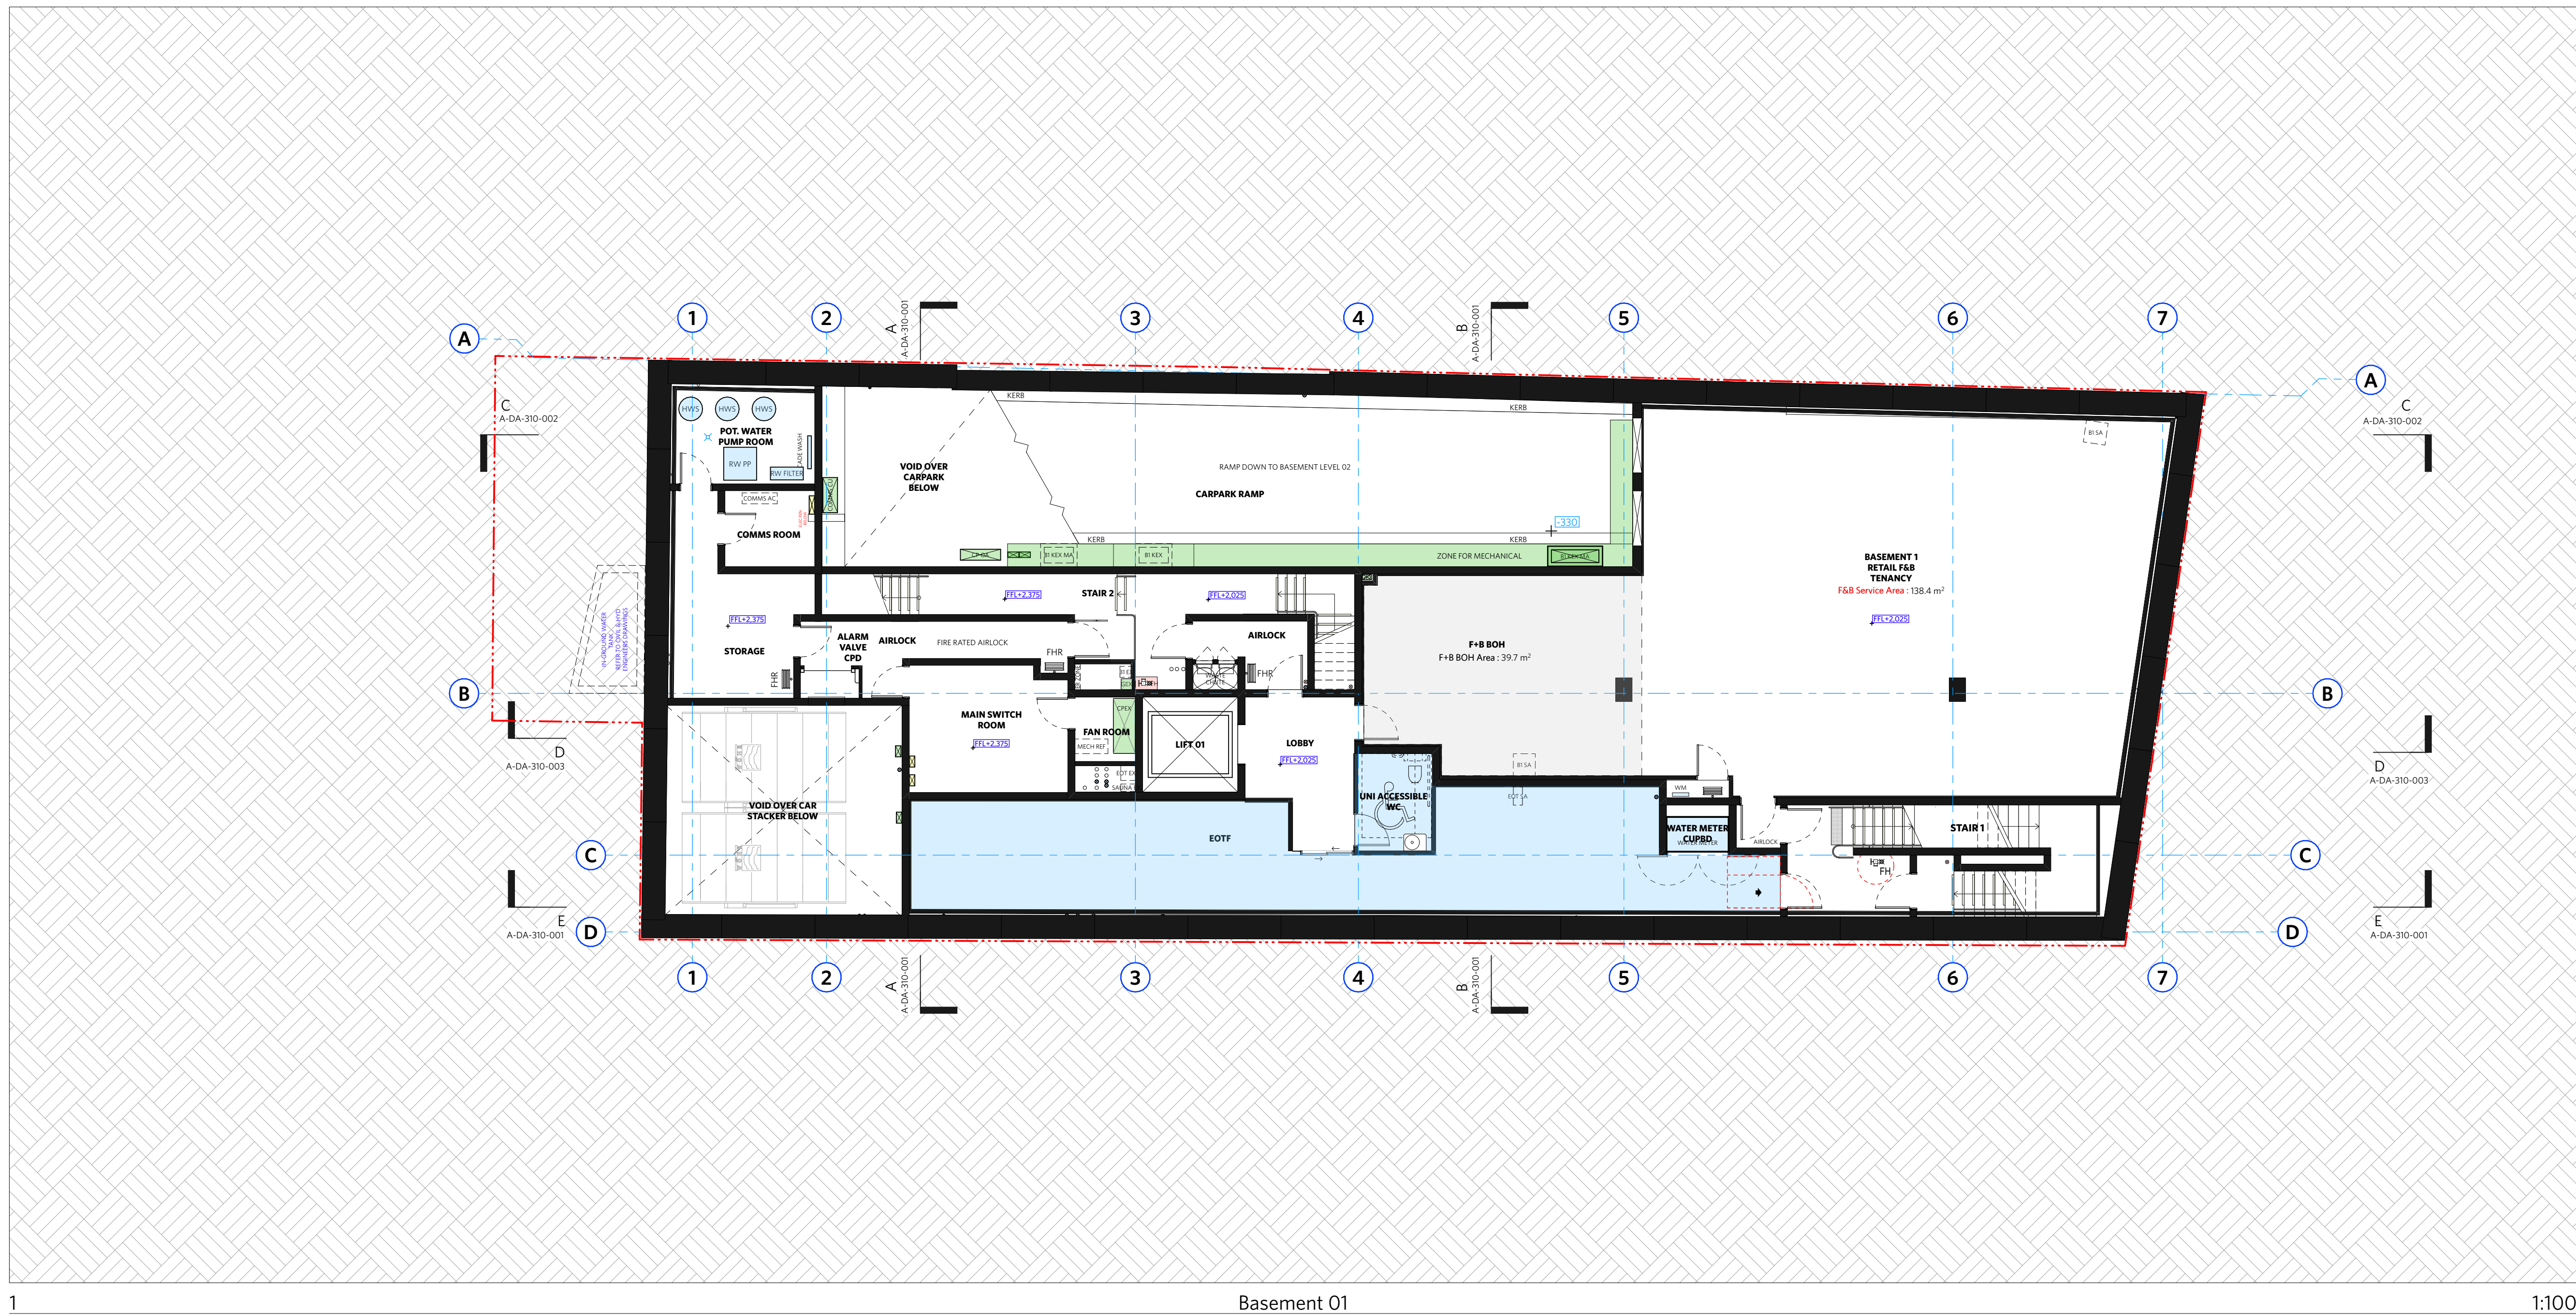

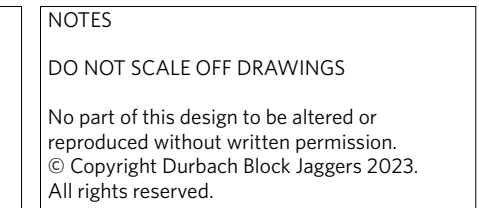

NOTE:
Traffic signals in Car Park will be implemented to give priority to entering traffic at all times except when exiting vehicle is detected

ISSUE STATUS		
REV	DESCRIPTION	DATE
A	ISSUE TO CLIENT FOR REVIEW	22/4/22
B	ISSUE FOR INFORMATION	22/5/05
C	ISSUE TO CONSULTANTS	22/5/10
D	ISSUE FOR INFORMATION	22/5/20
D	ISSUE FOR DA	26/2/09
DA-A	REVISED ISSUE FOR COORDINATION - DA RFI AMENDMENTS	23/1/12
DA-B	REVISED SUBMISSION FOR DA	23/1/20
DA-D	REVISED DA SUBMISSION- RFI AMENDMENTS	23/1/27
DA-E	REVISED DA SUBMISSION- RFI AMENDMENTS	23/1/14
DA-F	ISSUE FOR COORDINATION	24/3/08
DA-G	ISSUE FOR COORDINATION	24/03/17
DA-J	ISSUE FOR S455 02	24/07/11
DA-K	RE-ISSUE FOR S455 02	24/02/18
DA-L	ISSUE FOR S455 03 MOD	25/12/03

ARCHITECT


durbach block jagggers


Level 2, 9 Roslyn Street
Potts Point NSW 2011
02 8297 3500
durbachblockjagggers.com

Nominated Architects
Neill Durbach NSW Reg. No 5850
David Jagggers NSW Reg. No 9999

TITLE	
GA Plans	
Ground Plan	

PROJECT NO.	ISSUE	REV.
1728	S4.55	DA-L
DRAWING NO.		
A-DA-110-003		

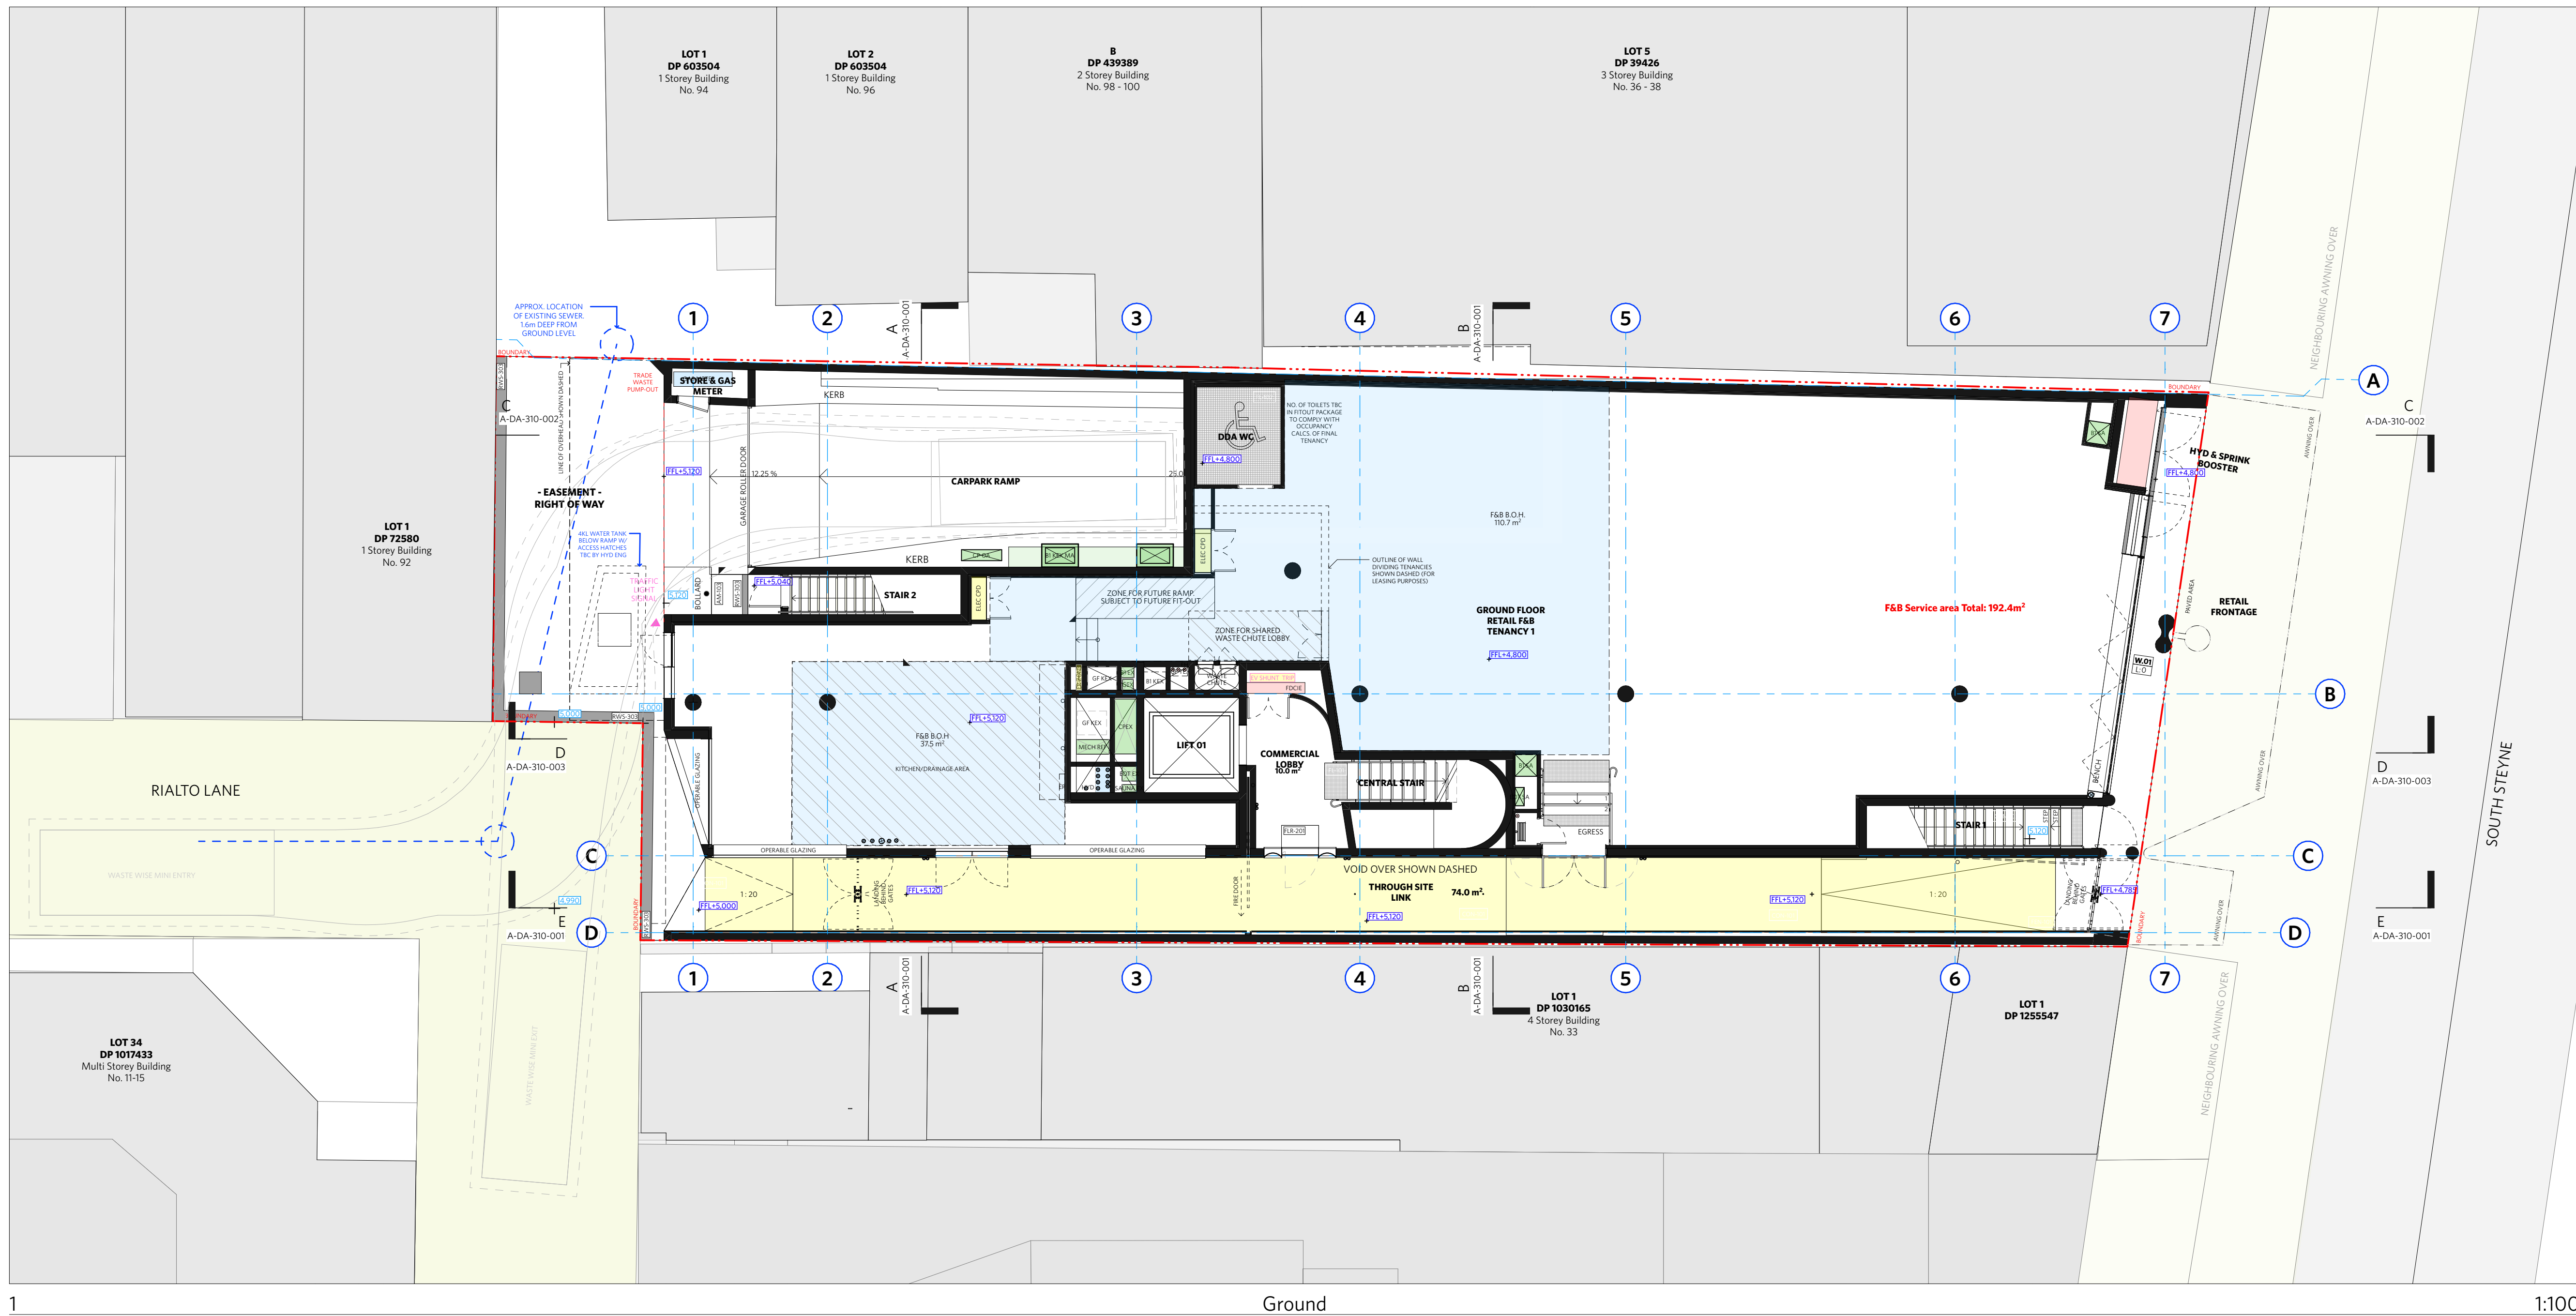

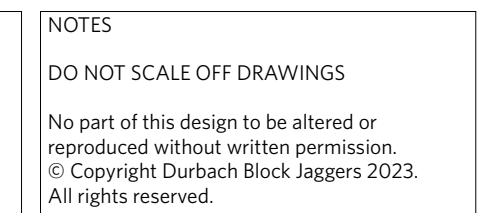

LEGEND	
AC	AIR CONDITIONING
E	ELECTRICAL SWITCHBOARD
FH	FIRE HYDRANT
HR	FIRE HOSE REEL
FP	FIRE INDICATOR PANEL
DP	DOWNPIPE
OF	OVERFLOW
RD	ROLLER DOOR
DR	DRAINAGE POINT
FG	FIXED GLAZING
LO	LOUVRES (OPERABLE)
GA	GATE
SW	SLIDING WINDOW
OW	OPENABLE WINDOW
RF	RENDED FINISH
MF	MOSAIC TILED FINISH
MR	MECHANICAL/ELECTRICAL RISER
HR	HYDRAULIC RISER
▽	FINISHED RL
▼	STRUCTURAL RL
H	HOTSPOT
G	GAS POINT

[illegible]

ISSUE STATUS		
REV	DESCRIPTION	DATE
A	ISSUE TO CLIENT FOR REVIEW	22/4/22
B	ISSUE FOR INFORMATION	22/9/05
C	ISSUE TO CONSULTANTS	23/6/10
D	ISSUE FOR INFORMATION	22/6/20
DA	ISSUE FOR DA	23/6/29
DA-A	REVISED ISSUE FOR COORDINATION - DA RFI AMENDMENTS	23/1/12
DA-B	REVISED SUBMISSION FOR DA	23/1/20
DA-D	REVISED DA SUBMISSION - RFI AMENDMENTS	23/7/27
DA-E	REVISED DA SUBMISSION - RFI AMENDMENTS	23/11/14
DA-F	ISSUE FOR COORDINATION	24/3/08
DA-G	ISSUE FOR S455	24/07/17
DA-J	ISSUE FOR S455 02	24/07/21
DA-K	RE-ISSUE FOR S455 02	24/02/18
DA-L	ISSUE FOR S455 03 MOD	25/12/23

CLIENT	Fortis Development Group
JOB	1728 Fortis South Steyne 34-35 South Steyne Manly NSW

ARCHITECT

durbach block jaggars


Level 2, 9 Roslyn Street
Potts Point NSW 2011
02 8297 3500
durbachblockjaggars.com


Nominated Architects
Neil Durbach NSW Reg. No 5850
David Jaggars NSW Reg. No 9999

DRAWN	CHECKED	DATE DRAWN	PRINTED
ND		27.2.25	27/3/2025 9:56 am
SCALE 1:100 @ A1 / 1:200 @ A3			
			

TITLE	GA Plans Level 1 Plan
-------	--------------------------

PROJECT NO.	ISSUE	REV.
1728	S4.55	DA-L
DRAWING NO.		
A-DA-110-004		

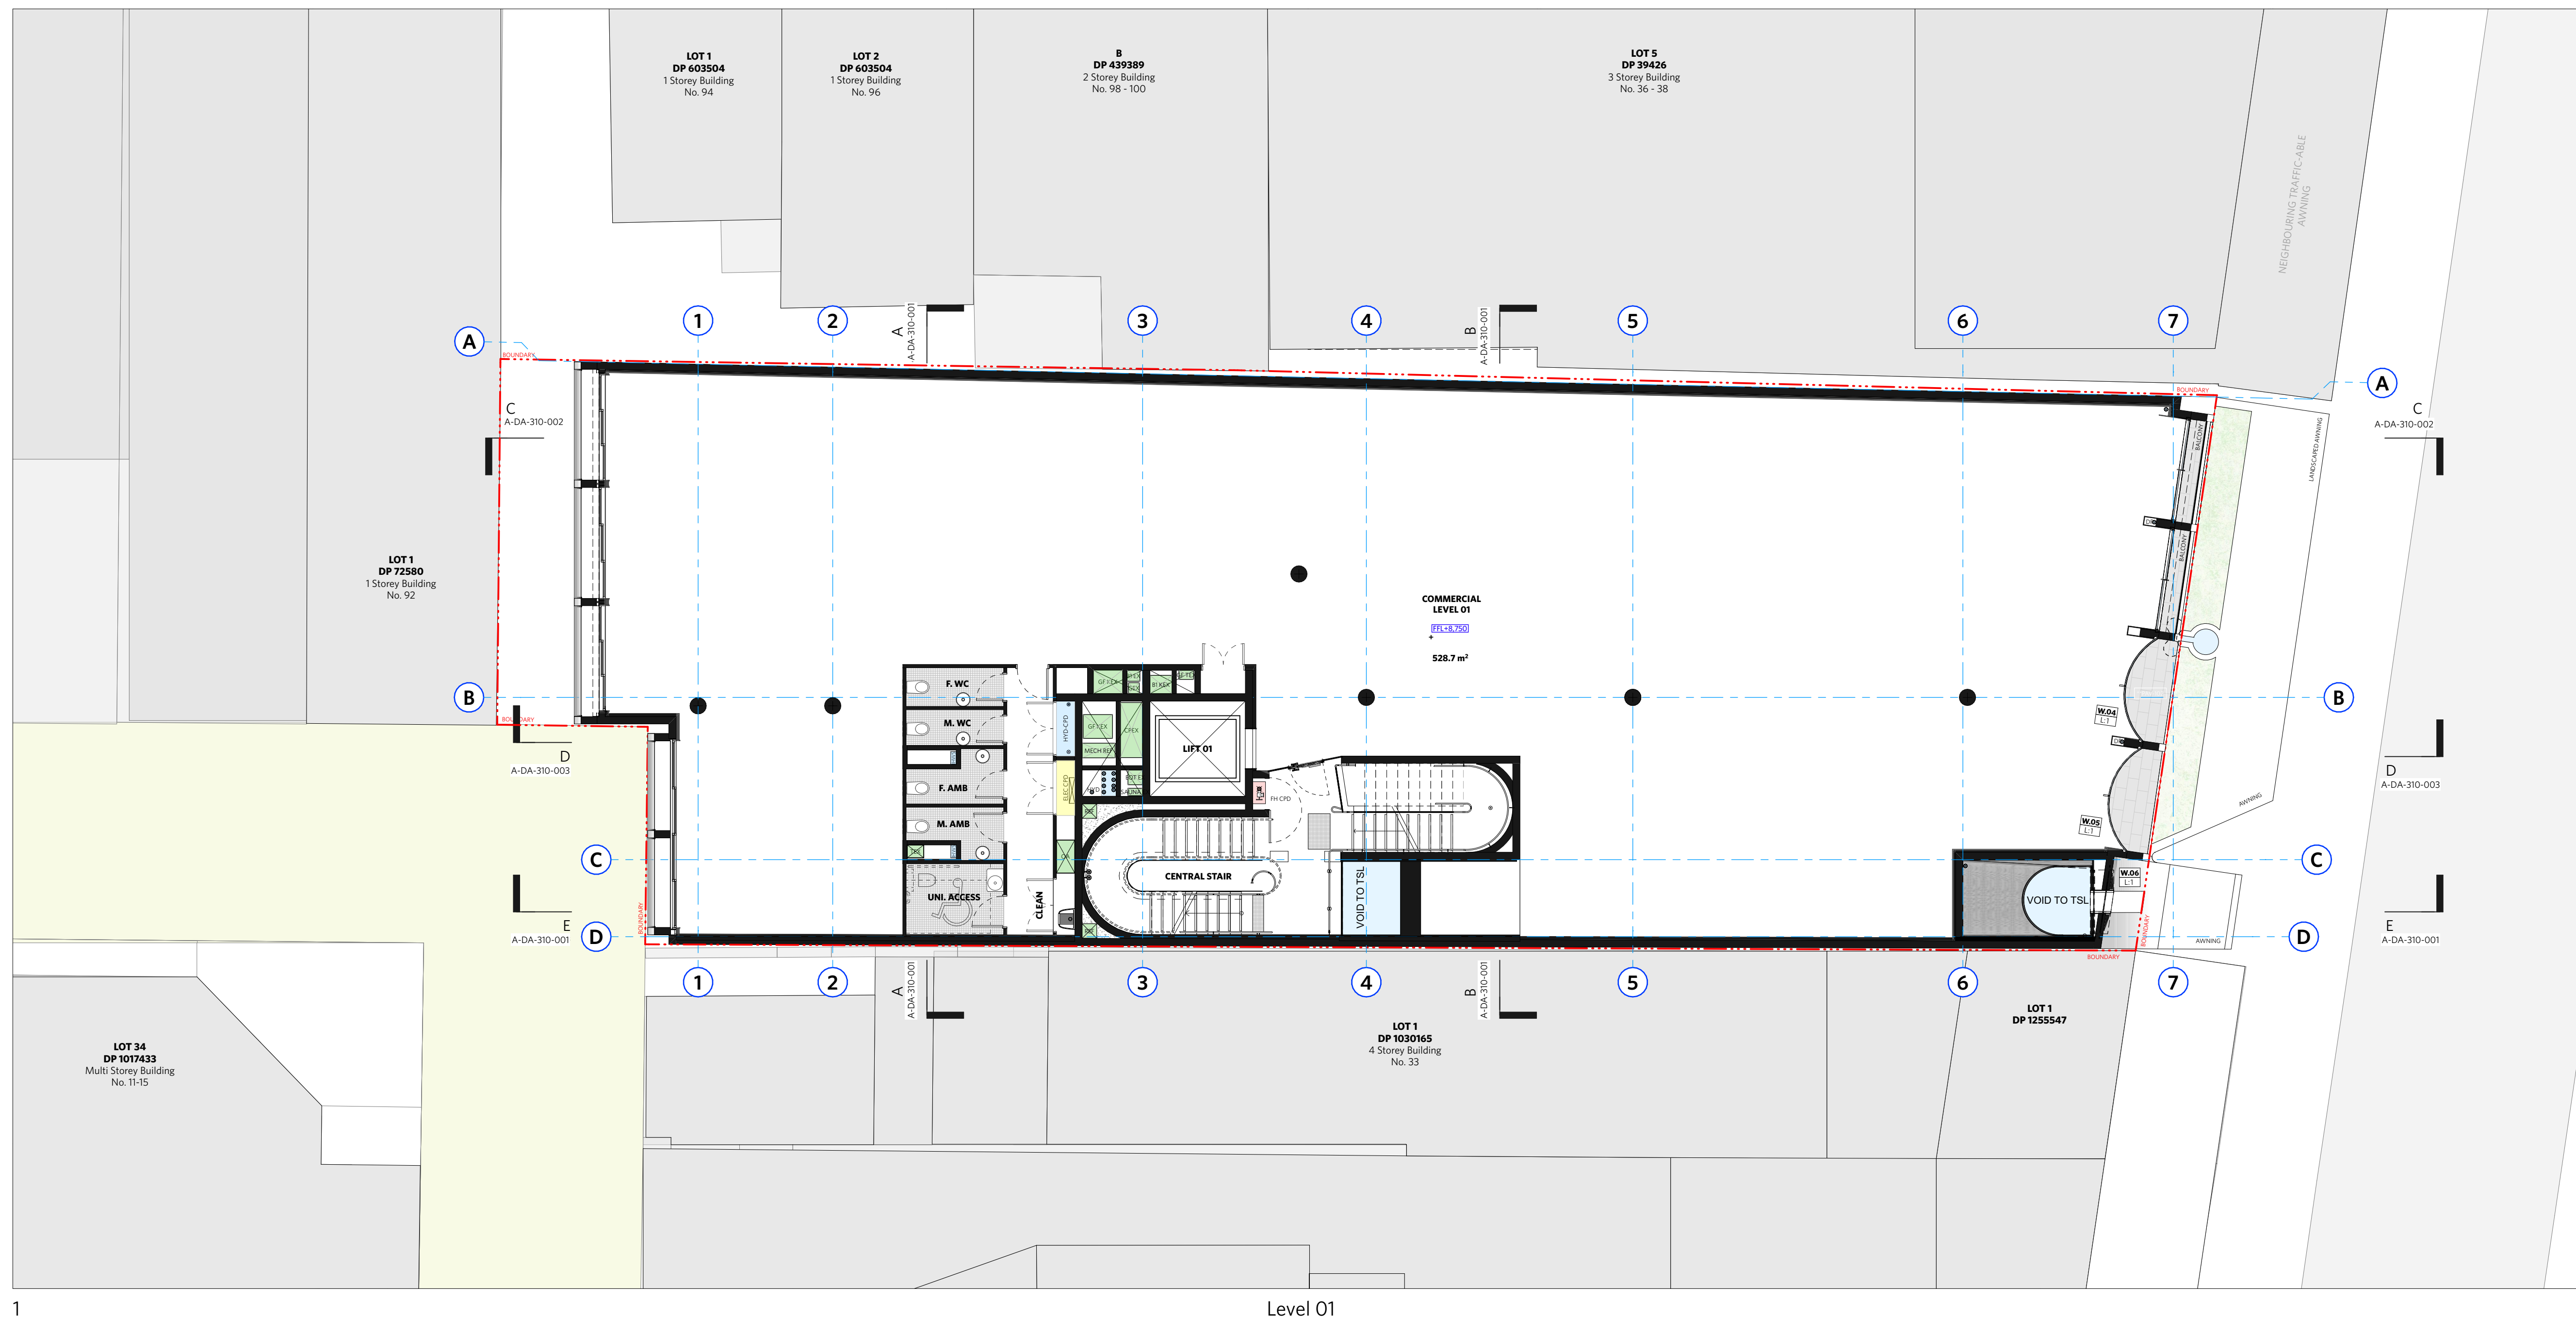

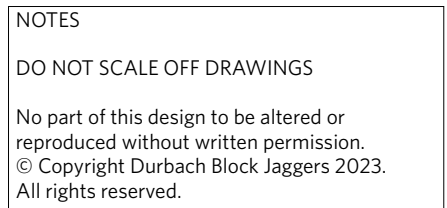

AC	AIR CONDITIONING
E	ELECTRICAL SWITCHBOARD
FH	FIRE HYDRANT
FHR	FIRE HOSE REEL
FIP	FIRE INDICATOR PANEL
DP	DOWNPIPE
OF	OVERFLOW
RD	ROLLER DOOR
DRP	DRAINAGE POINT
FG	FIXED GLAZING
LO	LOUVRES (OPERABLE)
GA	GATE
SW	SLIDING WINDOW
OW	OPENABLE WINDOW
R	RENDERED FINISH
MF	MOSAIC TILED FINISH
MR	METAL/CLAY/ELECTRICAL RISER
HR	HYDRAULIC RISER
▽	FINISHED RL
▽	STRUCTURAL RL
H	HOSETAP
G	GAS POINT

[illegible]

REV	DESCRIPTION	DATE
A	ISSUE TO CLIENT FOR REVIEW	22/4/22
B	ISSUE FOR INFORMATION	22/5/20
C	ISSUE TO CONSULTANTS	22/5/10
D	ISSUE FOR INFORMATION	22/5/20
DA	ISSUE FOR DA	26/2/29
DA-A	REVISED ISSUE FOR COORDINATION - DA RFI AMENDMENTS	23/7/12
DA-B	REVISED SUBMISSION FOR DA	23/1/20
DA-D	REVISED DA SUBMISSION - RFI AMENDMENTS	23/7/27
DA-E	REVISED DA SUBMISSION - RFI AMENDMENTS	23/1/14
DA-F	ISSUE FOR COORDINATION	24/3/08
DA-G	ISSUE FOR S455	24/04/17
DA-J	ISSUE FOR S455 02	24/07/11
DA-K	RE-ISSUE FOR S455 02	24/12/18
DA-L	ISSUE FOR S455 03 MOD	25/03/03

ARCHITECT

durbach block jagers


Level 2, 9 Roslyn Street
Potts Point NSW 2011
02 8297 3500
durbachblockjagers.com


Nominated Architects
Neil Durbach NSW Reg. No 5850
David Jagers NSW Reg. No 9999

DRAWN	CHECKED	DATE DRAWN	PRINTED
ND		27.2.25	27/3/2025 9:56 am
SCALE 1:100 @ A1 / 1:200 @ A3			
			

TITLE	
GA Plans	
Level 2 Plan	

PROJECT NO.	ISSUE	REV.
1728	S4.55	DA-L
DRAWING NO.		
A-DA-110-005		

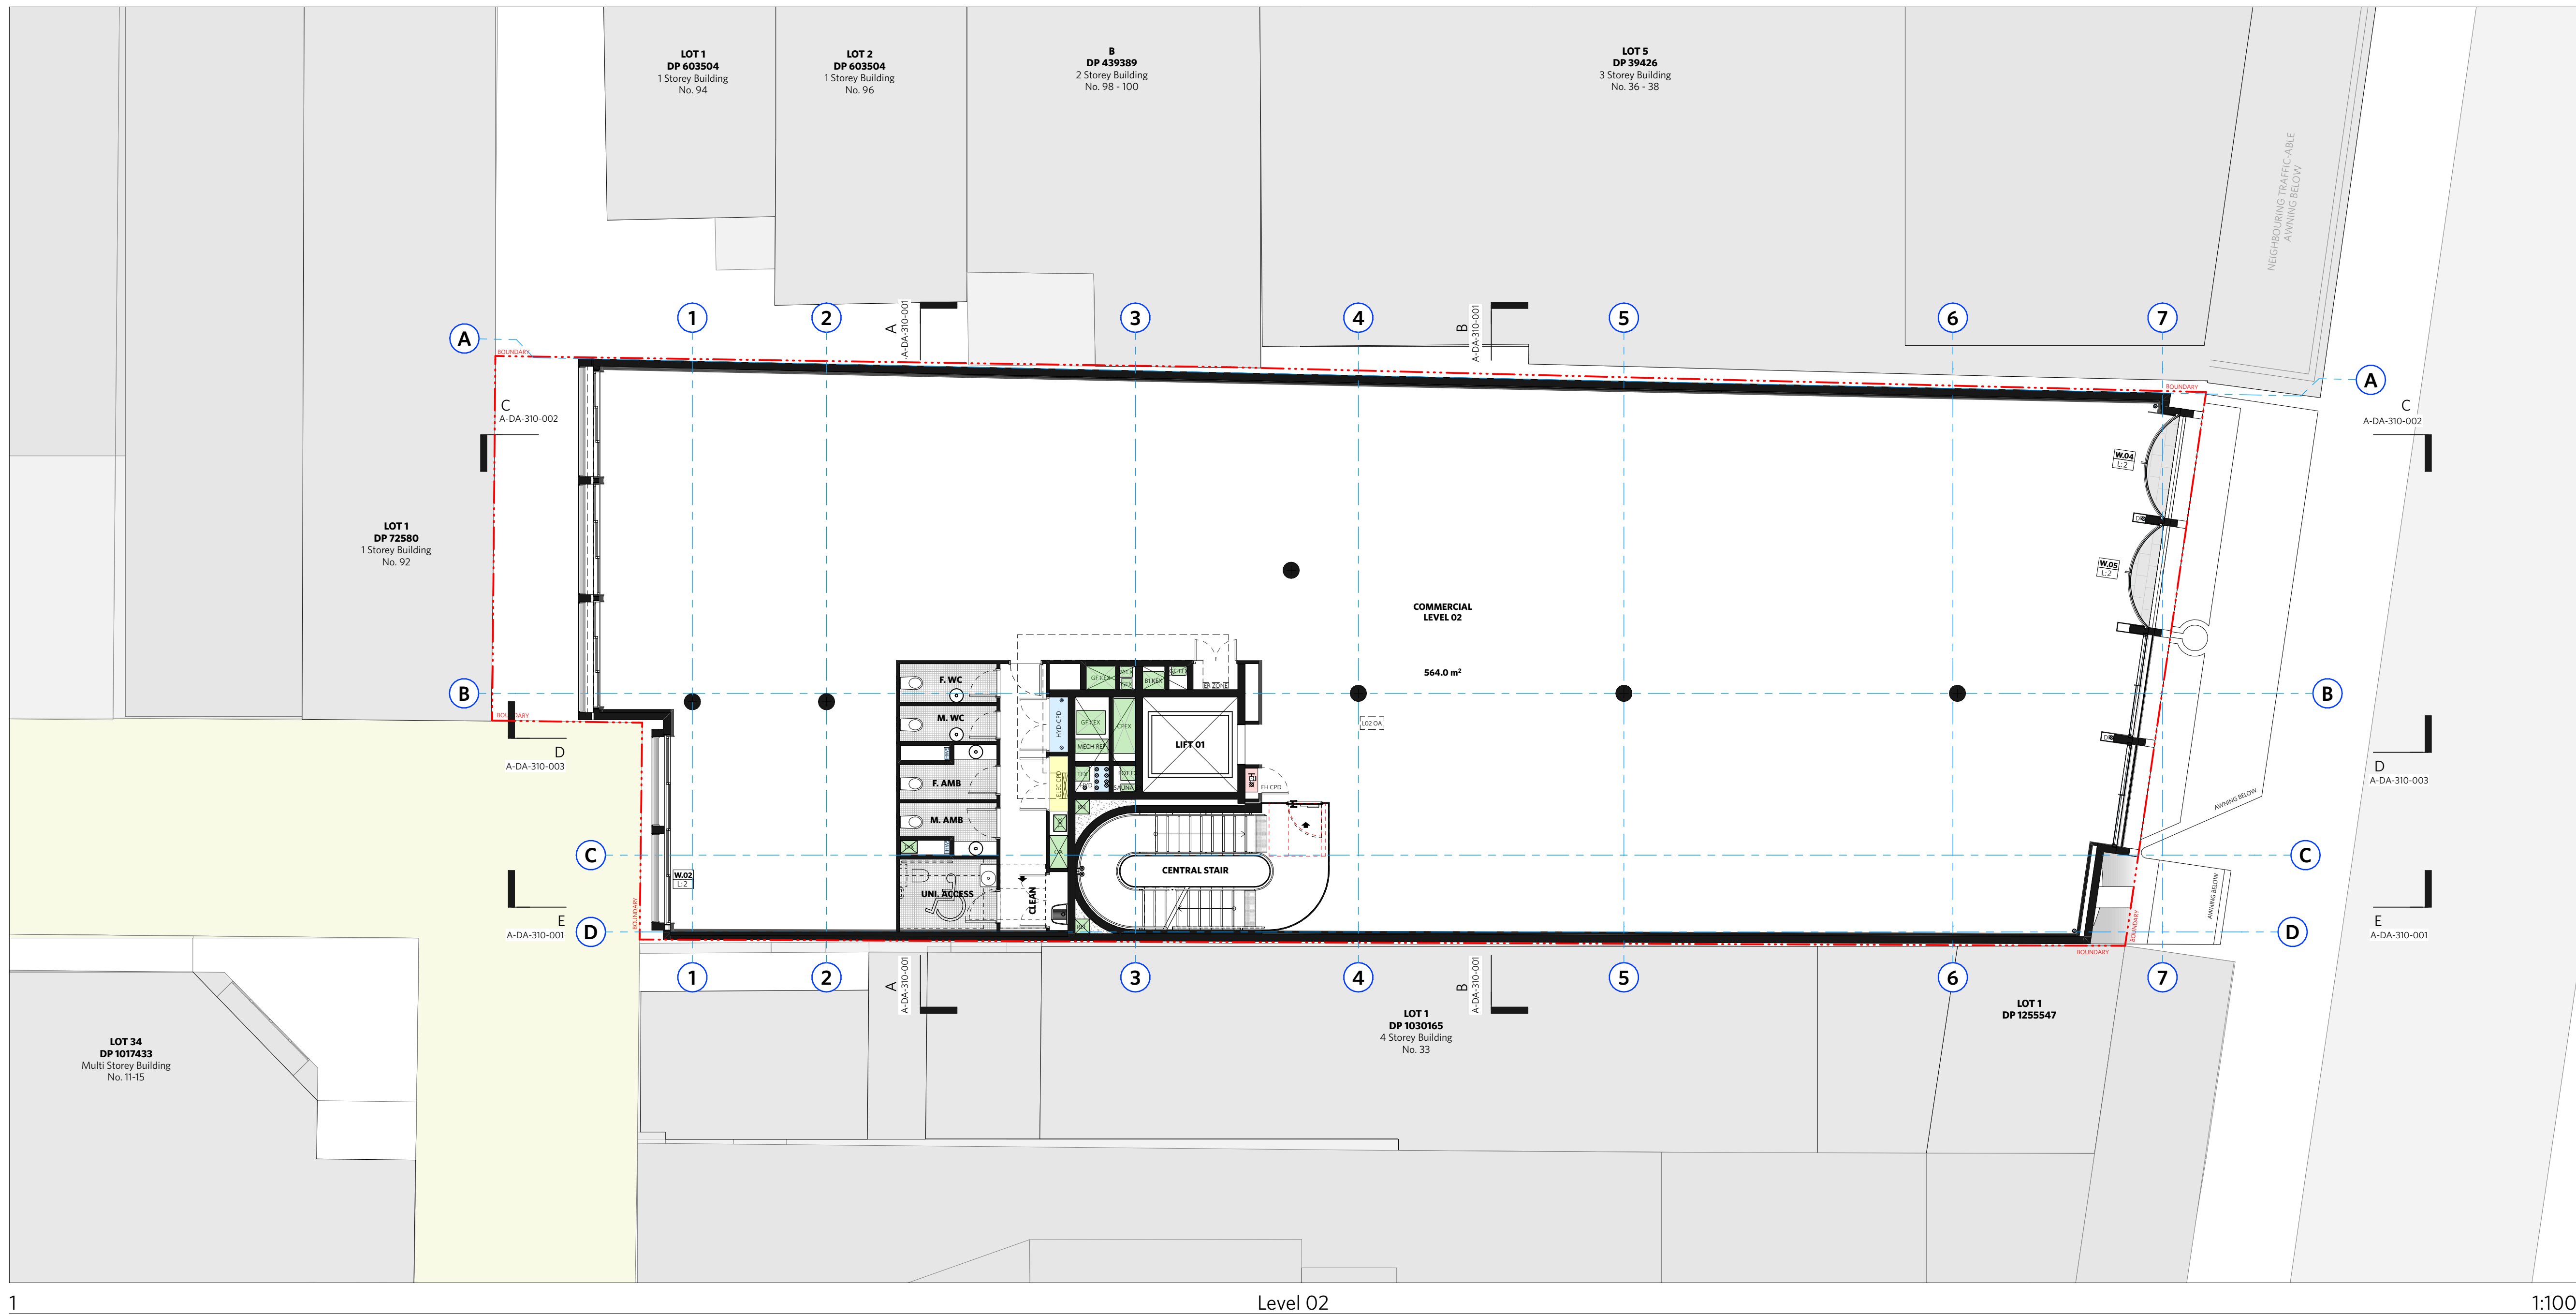

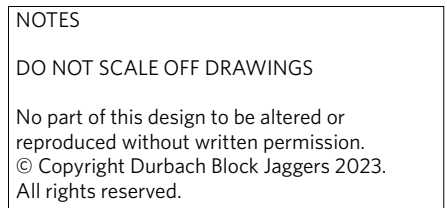

AC	AIR CONDITIONING
E	ELECTRICAL SWITCHBOARD
FH	FIRE HYDRANT
FHR	FIRE HOSE REEL
FIP	FIRE INDICATOR PANEL
DP	DOWNPIPE
OF	OVERFLOW
RD	ROLLER DOOR
DRP	DRAINAGE POINT
FG	FIXED GLAZING
LO	LOUVRES (OPERABLE)
GA	GATE
SW	SLIDING WINDOW
OW	OPENABLE WINDOW
R	RENDERED FINISH
MF	MOSAIC TILED FINISH
MR	METAL/CLAY/ELECTRICAL RISER
HR	HYDRAULIC RISER
▽	FINISHED RL
▽	STRUCTURAL RL
H	HOSETAP
G	GAS POINT

[illegible]

REV	DESCRIPTION	DATE
A	ISSUE TO CLIENT FOR REVIEW	22/4/22
B	ISSUE FOR INFORMATION	22/5/20
C	ISSUE TO CONSULTANTS	22/5/10
D	ISSUE FOR INFORMATION	22/5/20
DA	ISSUE FOR DA	26/2/29
DA-A	REVISED ISSUE FOR COORDINATION - DA RFI AMENDMENTS	23/7/12
DA-B	REVISED SUBMISSION FOR DA	23/1/20
DA-D	REVISED DA SUBMISSION - RFI AMENDMENTS	23/7/27
DA-E	REVISED DA SUBMISSION - RFI AMENDMENTS	23/1/14
DA-F	ISSUE FOR COORDINATION	24/3/08
DA-G	ISSUE FOR S455	24/04/17
DA-J	ISSUE FOR S455 02	24/07/11
DA-K	RE-ISSUE FOR S455 02	24/12/18
DA-L	ISSUE FOR S455 03 MOD	25/03/03

durbach block jagers
Level 2, 9 Roslyn Street
Potts Point NSW 2011
02 8297 3500
durbachblockjagers.com

Nominated Architects
Neil Durbach NSW Reg. No 5850
David Jagers NSW Reg. No 9999

DRAWN	CHECKED	DATE DRAWN	PRINTED
ND		27.2.25	27/3/2025 9:56 am
SCALE 1:100 @ A1 / 1:200 @ A3			
			

PROJECT NO.	ISSUE	REV.
1728	S4.55	DA-L
DRAWING NO.		
A-DA-110-006		



NOTES

DO NOT SCALE OFF DRAWINGS

No part of this design to be altered or reproduced without written permission.
© Copyright Durbach Block Jagers 2023.
All rights reserved.

LEGEND

AC	AIR CONDITIONING
E	ELECTRICAL SWITCHBOARD
FH	FIRE HYDRANT
FHR	FIRE HOSE REEL
FI	FIRE INDICATOR PANEL
DP	DOWNPIPE
OF	OVERFLOW
RD	ROLLER DOOR
DRP	DRAINAGE POINT
FG	FIXED GLAZING
LO	LOUVERES (OPERABLE)
GA	GATE
SW	SLIDING WINDOW
OW	OPENABLE WINDOW
BF	BENDER FINISH
MF	MOSAIC TILED FINISH
MR	MECHANICAL/ELECTRICAL RISER
HR	HYDRAULIC RISER
V	FINISHED RL
V	STRUCTURAL RL
H	HOSEPAINT
G	GAS POINT

CHANGE SUMMARY

[illegible]

ISSUE STATUS


REV	DESCRIPTION	DATE
A	ISSUE TO CLIENT FOR REVIEW	22/4/22
B	ISSUE FOR INFORMATION	22/5/05
C	ISSUE TO CONSULTANTS	22/5/10
D	ISSUE FOR INFORMATION	22/5/20
DA	ISSUE FOR DA	22/6/29
DA-A	REVISED ISSUE FOR COORDINATION - DA RFI AMENDMENTS	23/1/12
DA-B	REVISED SUBMISSION FOR DA	23/1/20
DA-D	REVISED DA SUBMISSION - RFI AMENDMENTS	23/7/27
DA-E	REVISED DA SUBMISSION - RFI AMENDMENTS	23/11/14
DA-F	ISSUE FOR COORDINATION	24/3/08
D-G	ISSUE FOR S455	24/04/17
DA-H	ISSUE FOR S455 - COUNCIL RFI	24/07/21
DA-J	ISSUE FOR S455 02	24/07/05
DA-K	RE-ISSUE FOR S455 02	24/12/18
DA-L	ISSUE FOR S455 03 MOD	25/03/23

CLIENT	Fortis Development Group
JOB	1728 Fortis South Steyne 34-35 South Steyne Manly NSW

ARCHITECT




DRAWN	CHECKED	DATE DRAWN	PRINTED
ND		27.2.25	27/3/2025 9:56 am

 

TITLE	GA Plans Roof Plan
-------	-----------------------


PROJECT NO.	ISSUE	REV.
1728	S4.55	DA-L
DRAWING NO.		
A-DA-110-007		

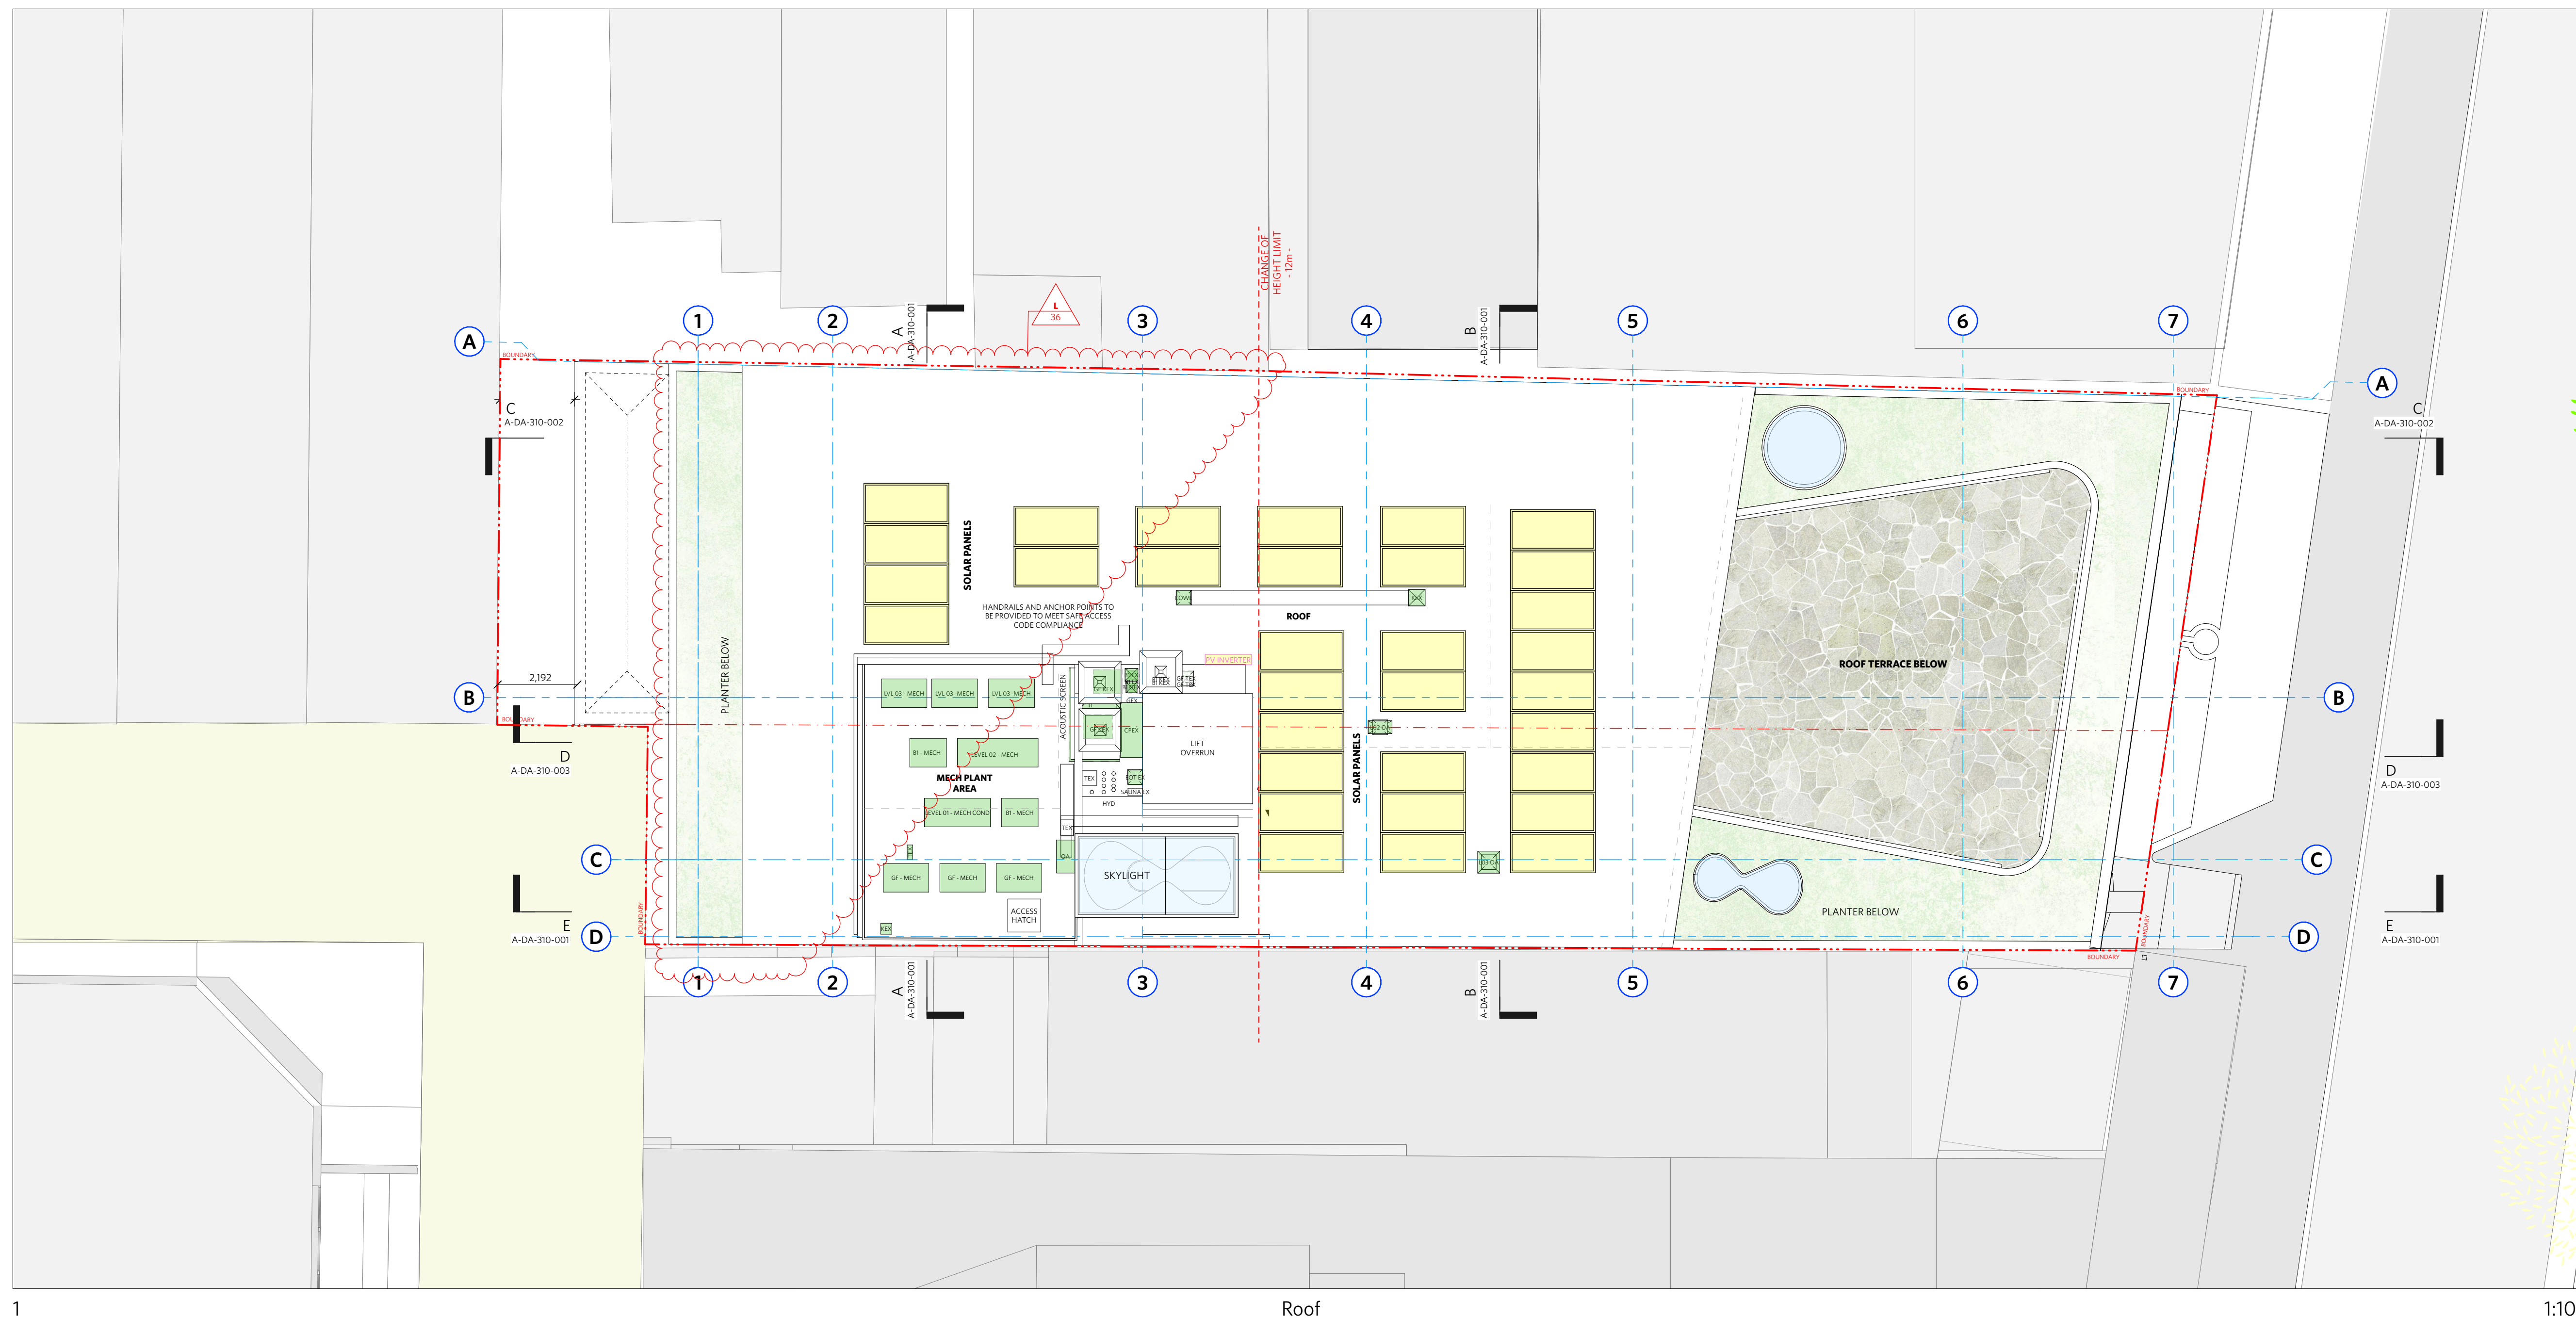

1

Roof

1:100

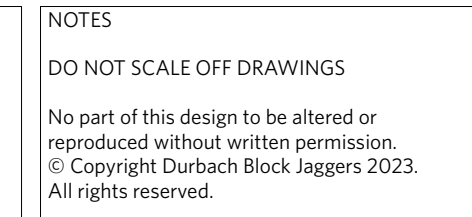

LEGEND	
AC	AIR CONDITIONING
E	ELECTRICAL SWITCHBOARD
FH	FIRE HYDRANT
FHR	FIRE HOSE REEL
FIP	FIRE INDICATOR PANEL
DP	DOWNPIPE
OF	OVERFLOW
RD	ROLLER DOOR
DRP	DRAINAGE POINT
FG	FIXED GLAZING
LO	LOUVERS (OPERABLE)
GA	GATE
SW	SLIDING WINDOW
OW	OPENABLE WINDOW
RF	RENDERED FINISH
MF	MECHANICAL FINISH
MR	MECHANICAL RISER
HR	HYDRAULIC RISER
▽	FINISHED RL
▽	STRUCTURAL RL
H	HOSEPAT
G	GAS POINT

[illegible]

ISSUE STATUS		
REV	DESCRIPTION	DATE
A	ISSUE TO CLIENT FOR REVIEW	22/4/22
B	ISSUE FOR INFORMATION	23/5/05
C	ISSUE TO CONSULTANTS	22/5/10
D	ISSUE FOR INFORMATION	22/5/20
DA	ISSUE FOR DA	26/2/29
DA-A	REVISED ISSUE FOR COORDINATION - DA RFI AMENDMENTS	23/1/12
DA-B	REVISED SUBMISSION FOR DA	23/1/20
DA-D	REVISED DA SUBMISSION- RFI AMENDMENTS	23/7/21
DA-E	REVISED DA SUBMISSION- RFI AMENDMENTS	23/11/14
DA-F	ISSUE FOR COORDINATION	24/03/18
DA-G	ISSUE FOR S455	24/04/27
DA-H	ISSUE FOR S455 - COORD RFI	24/07/21
DA-I	ISSUE FOR S455 02	24/07/05
DA-K	RE-ISSUE FOR S455 02	24/12/18
DA-L	ISSUE FOR S455 03 MOD	25/03/23

CLIENT Fortis Development Group
JOB

1728 Fortis South Steyne
34-35 South Steyne Manly NSW

ARCHITECT

durbach block jaggers

Level 2, 9 Roslyn Street
Potts Point NSW 2011
02 8297 3500
durbach@blockjaggers.com


Nominated Architects
Neil Durbach NSW Reg. No 5850
David Jaggers NSW Reg. No 9999

DRAWN	CHECKED	DATE DRAWN	PRINTED
ND		27.2.25	27/3/2025 9:56 am
SCALE 1:100 @ A1 / 1:200 @ A3			
			


TITLE
GA Elevation
North & South Elevations

PROJECT NO. 1728	ISSUE S4.55	REV. DA-L
DRAWING NO. A-DA-210-001		




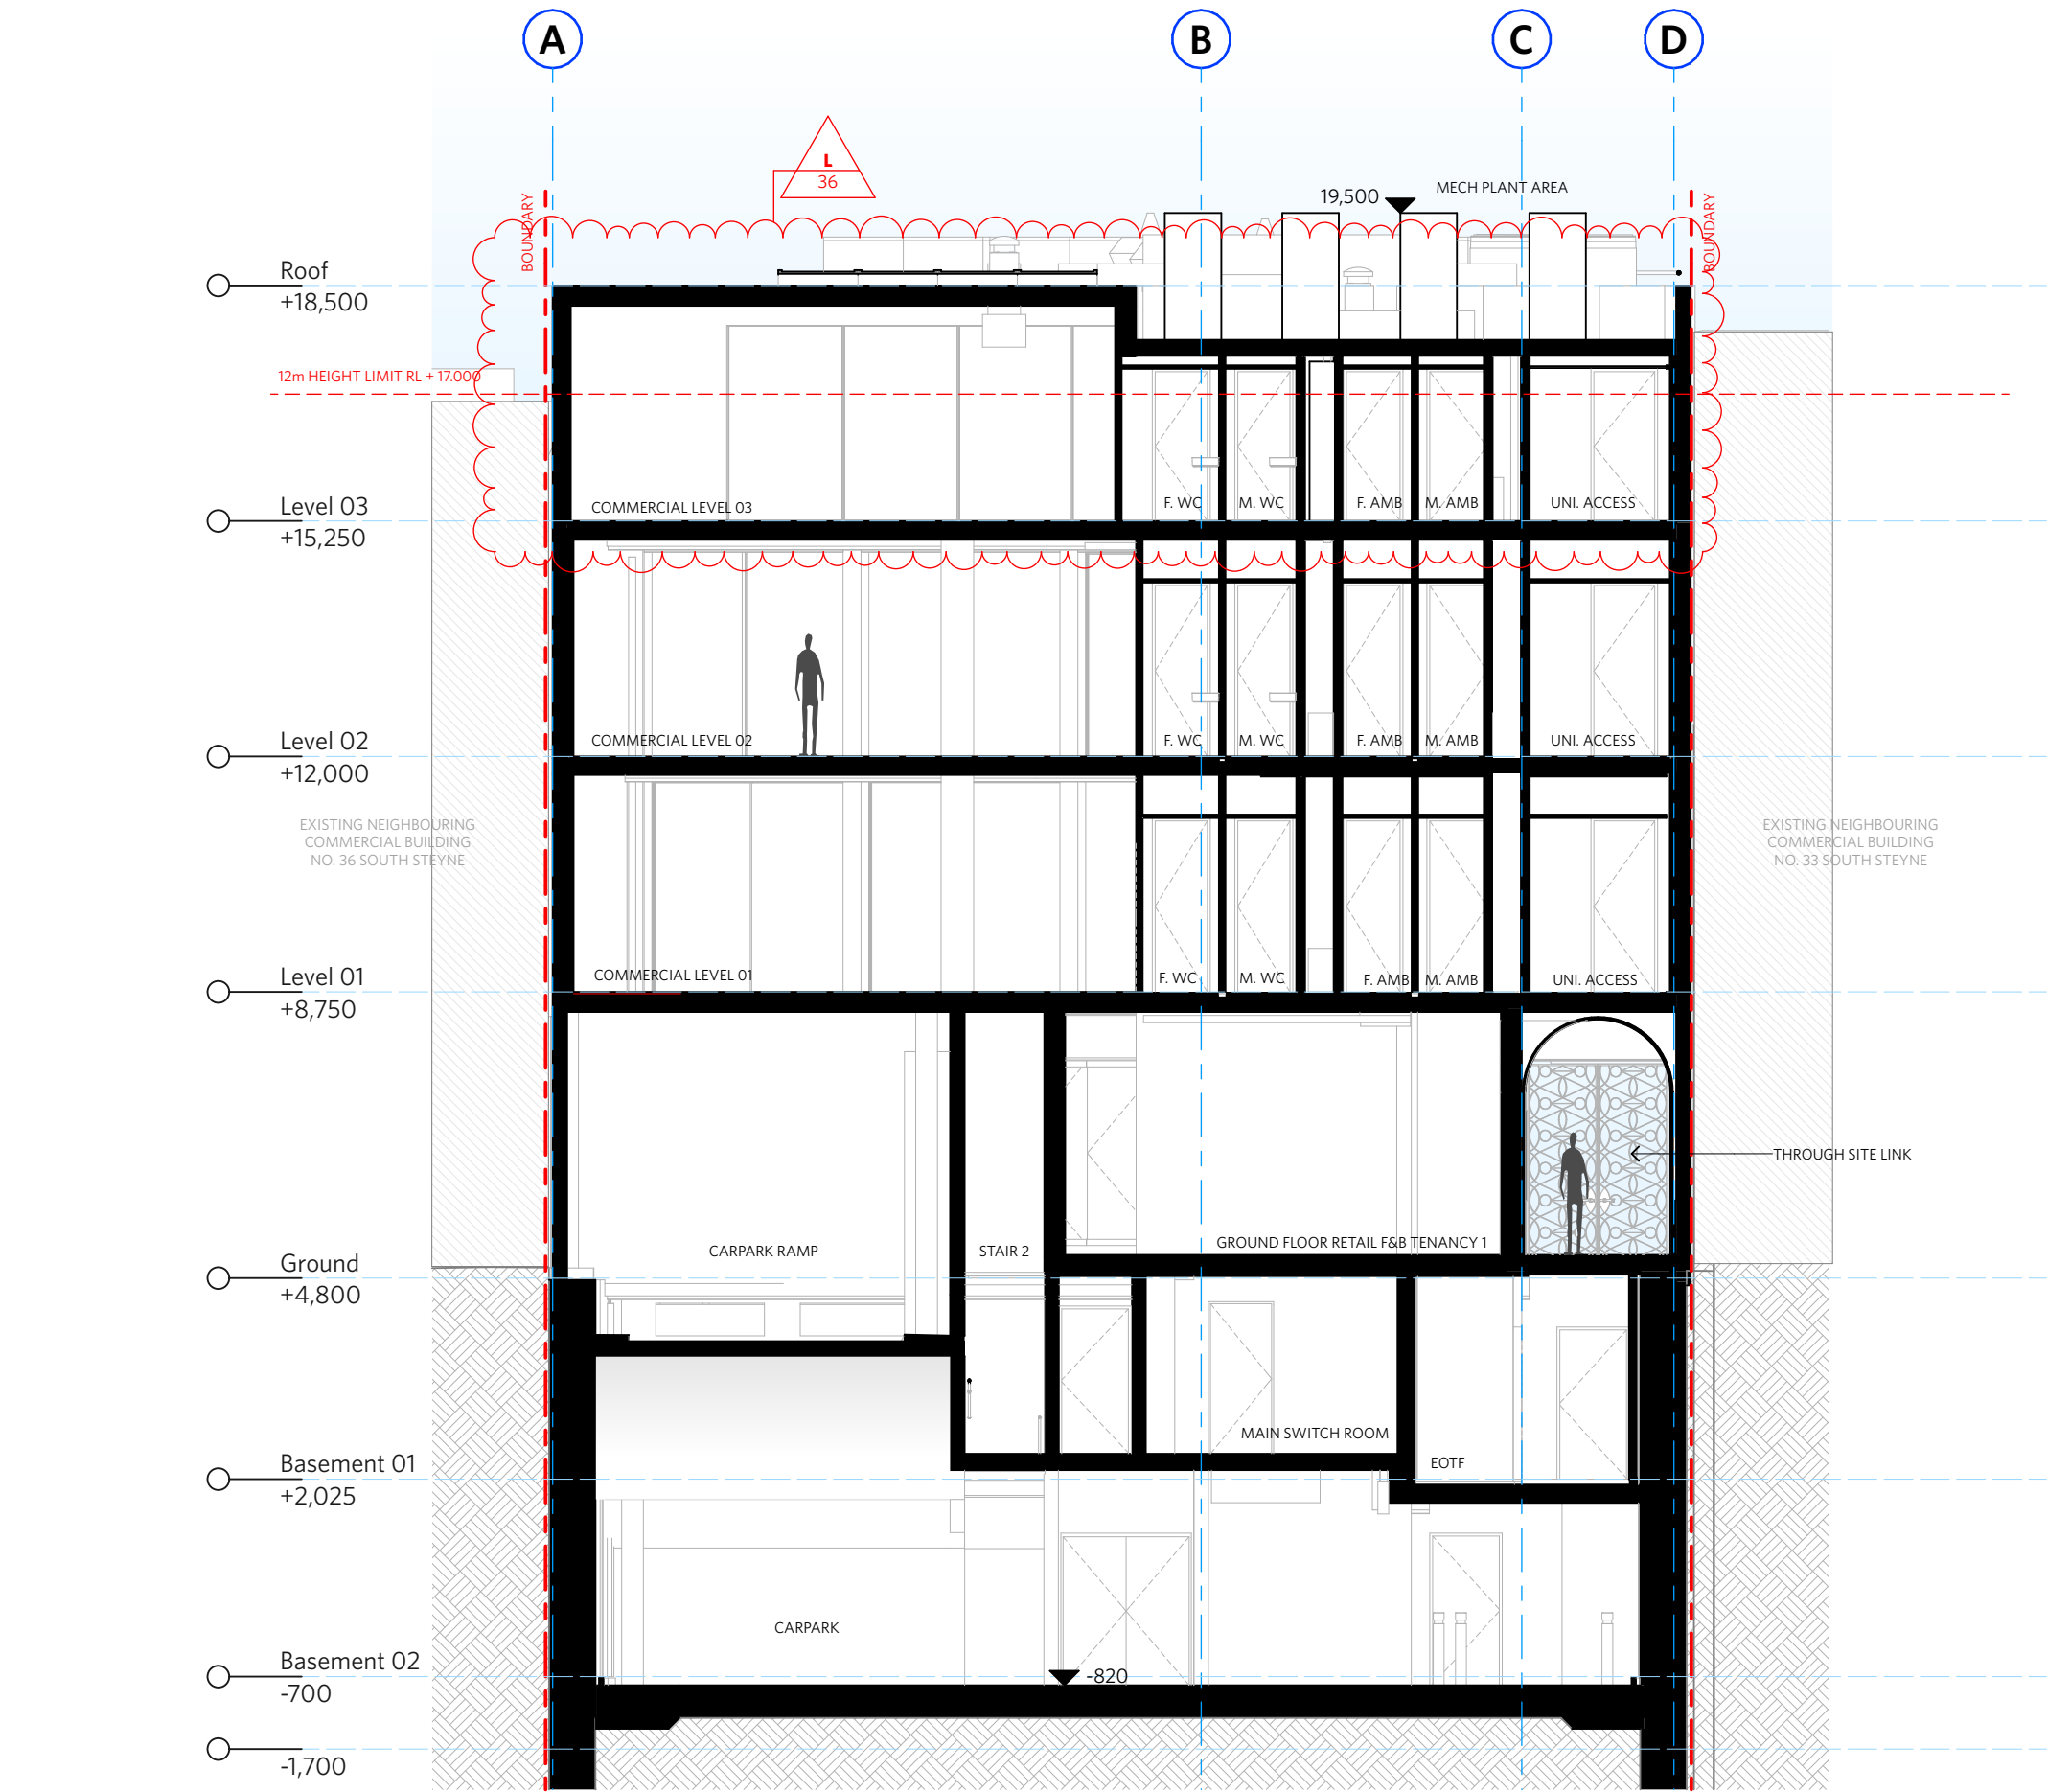

1 Section A 1:100

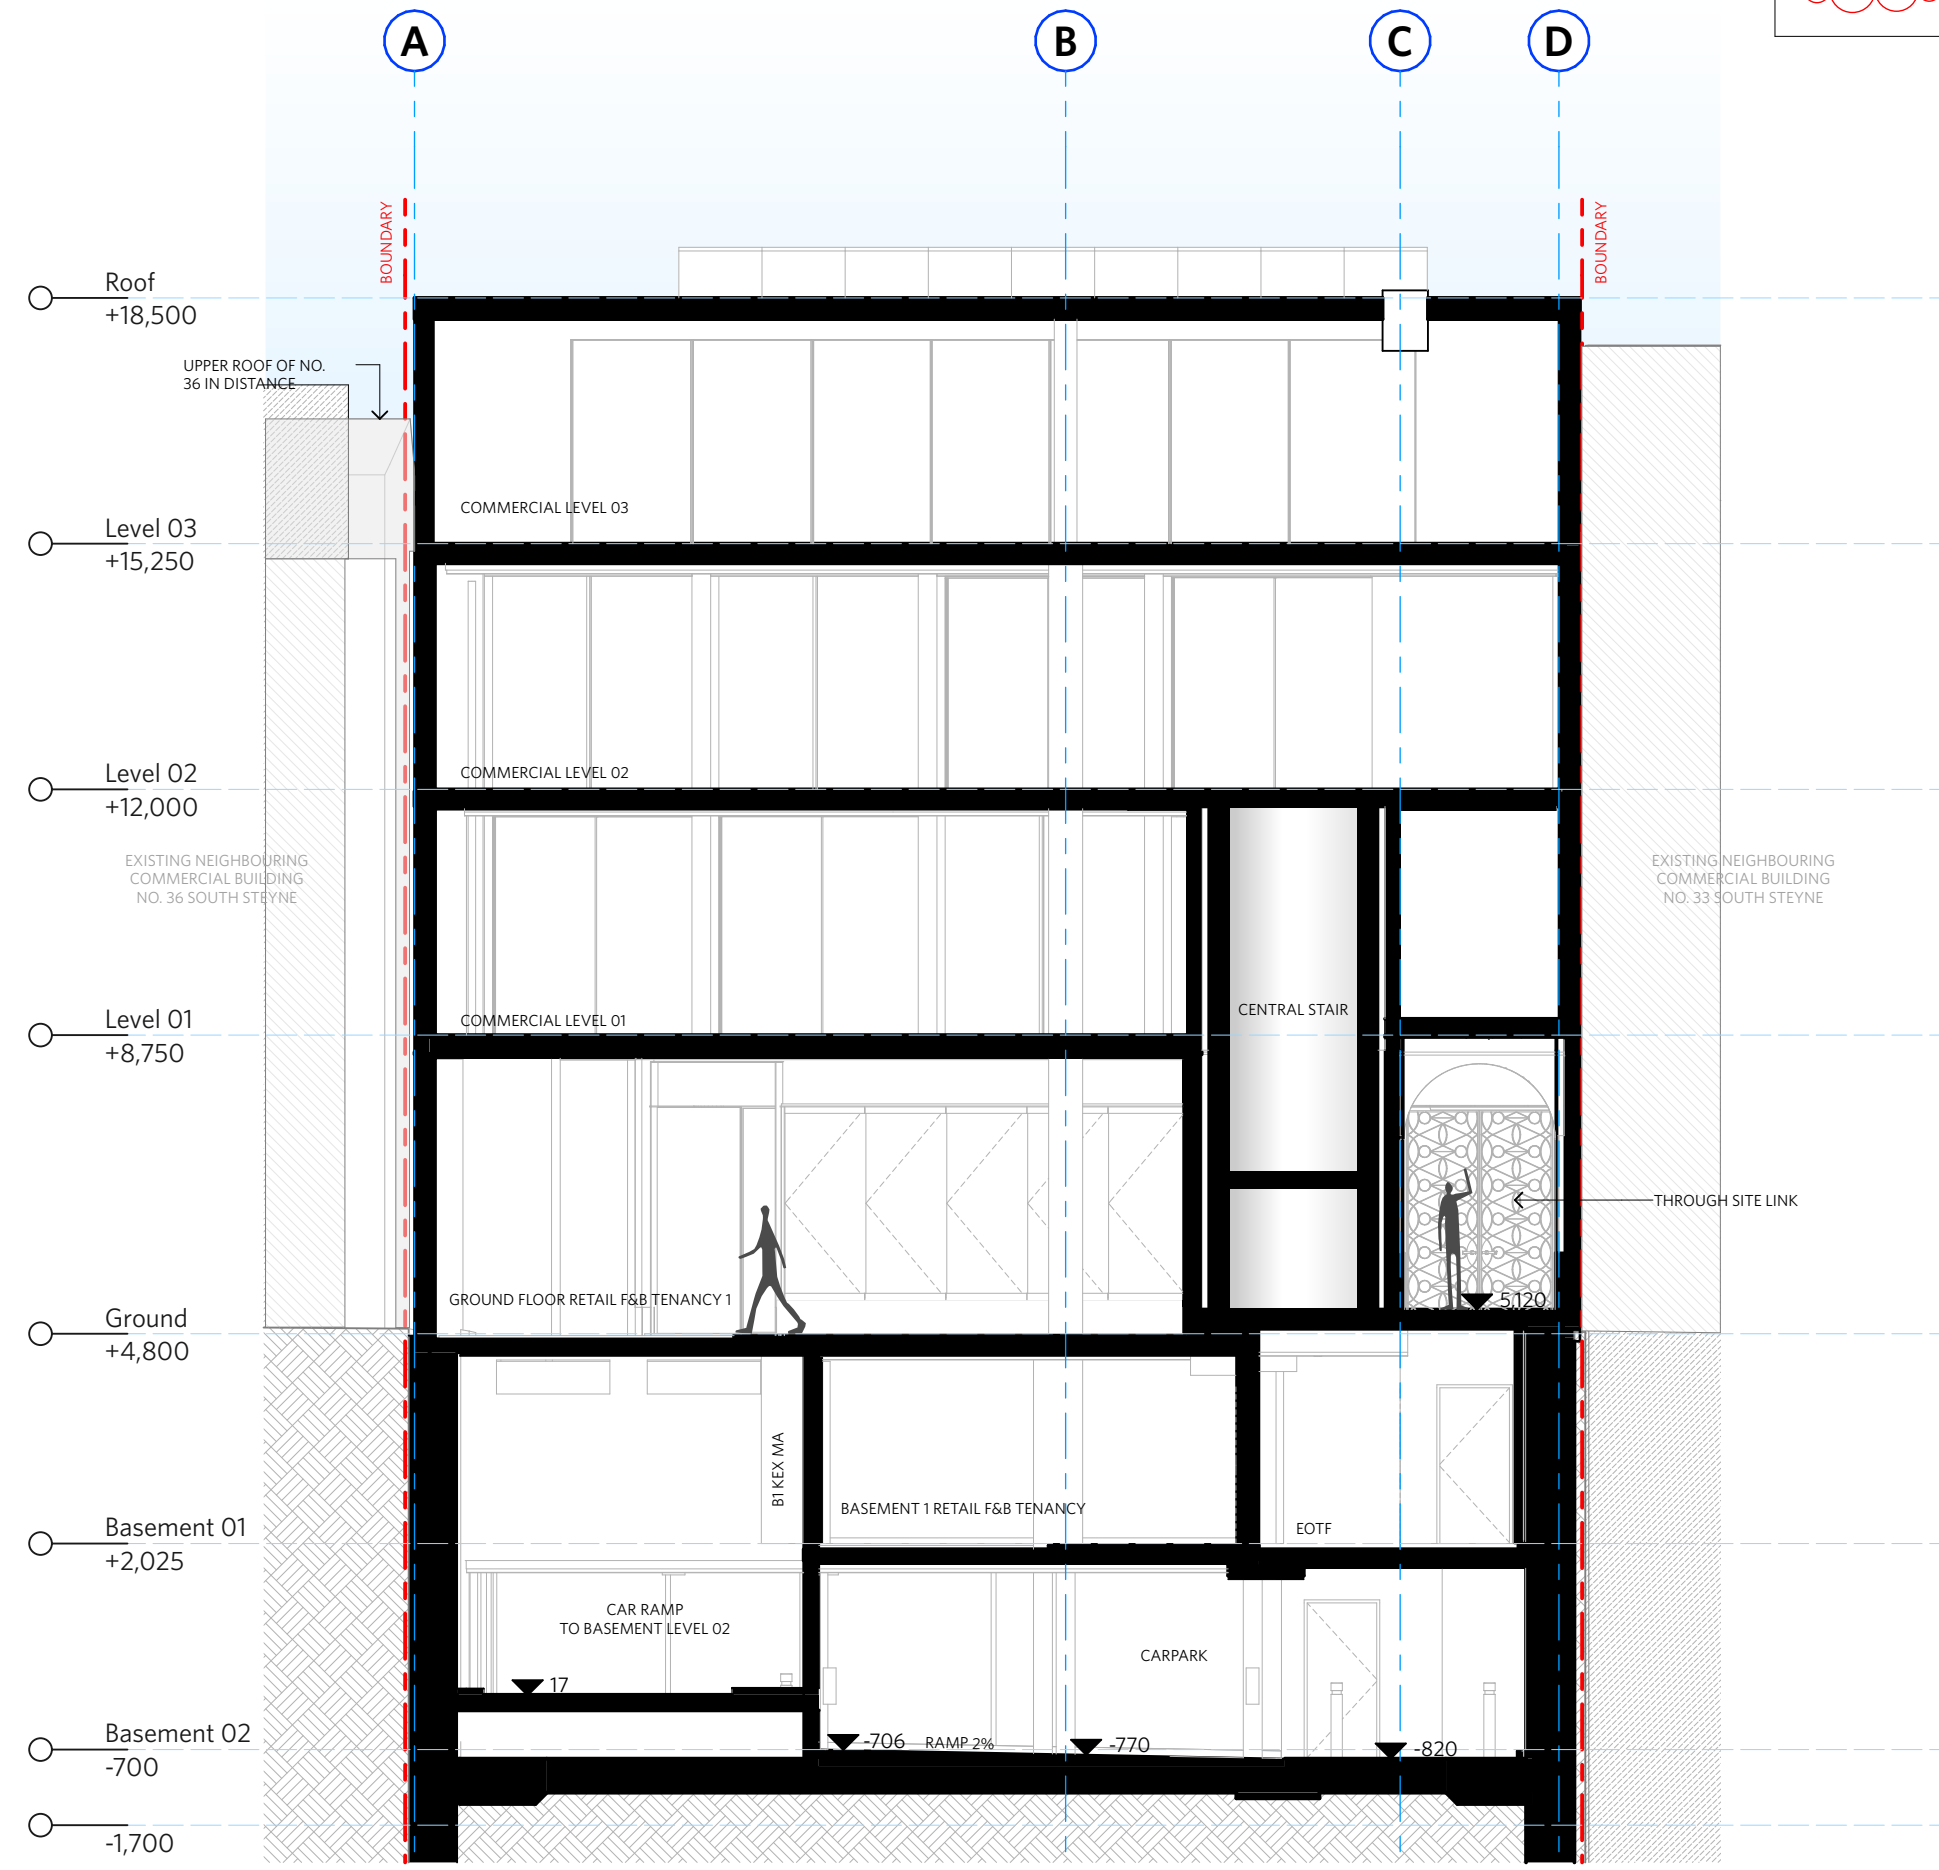

2 Section B 1:100

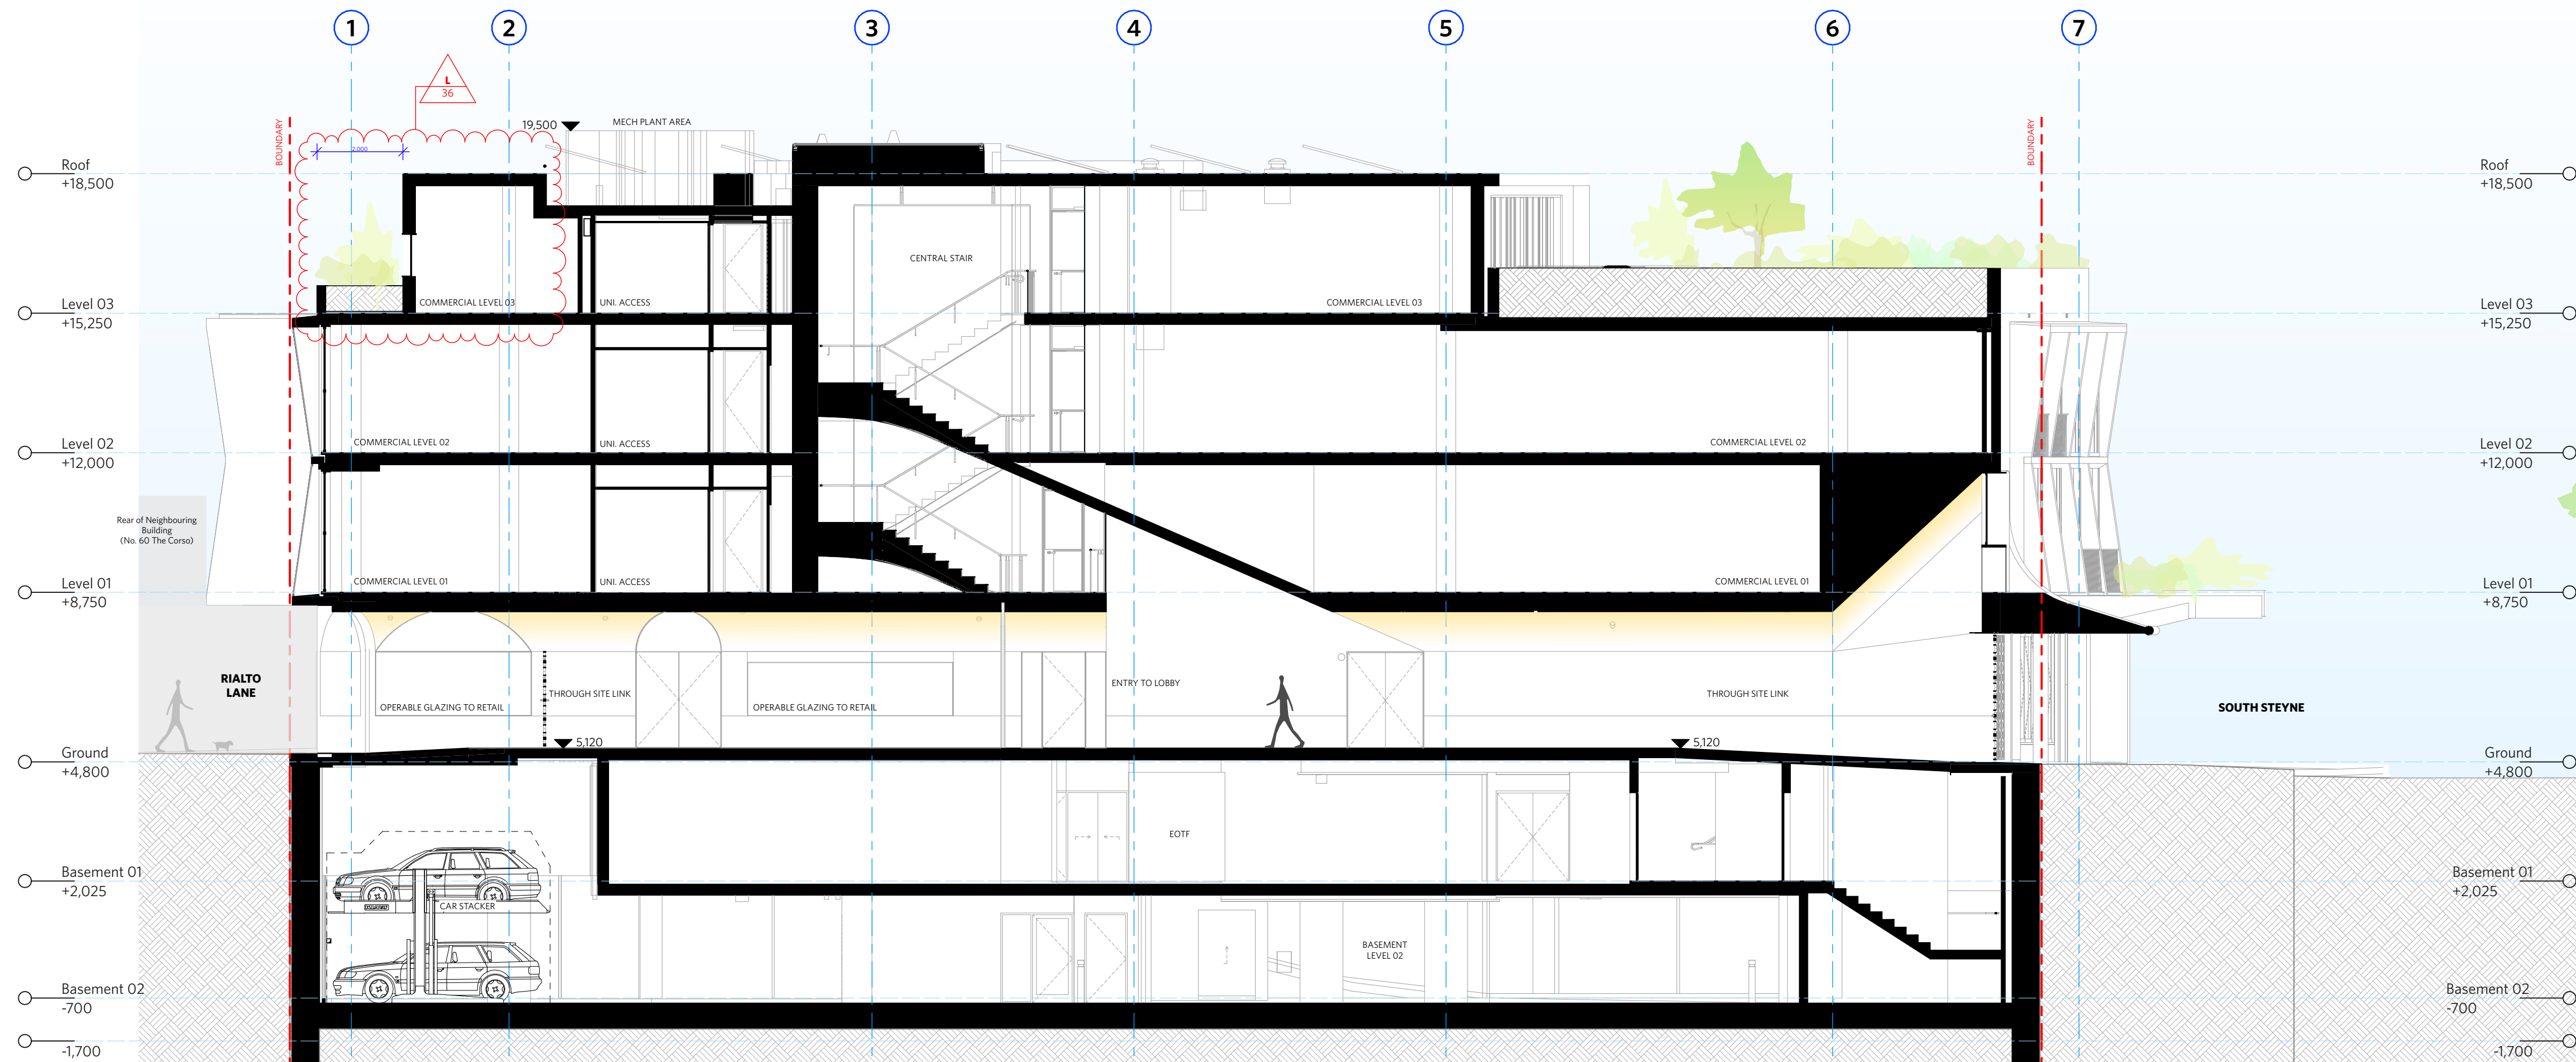

3 Section E 1:100

CHANGES RELEVANT TO THIS MODIFICATION APPLICATION

NOTES
DO NOT SCALE OFF DRAWINGS
No part of this design to be altered or reproduced without written permission.
© Copyright Durbach Block Jaggers 2023.
All rights reserved.

LEGEND

AC	AIR CONDITIONING
E	ELECTRICAL SWITCHBOARD
FH	FIRE HYDRANT
FHR	FIRE HOSE REEL
FIP	FIRE INDICATOR PANEL
DP	DOWNPIPE
OF	OVERFLOW
RD	ROLLER DOOR
DRP	DRAINAGE POINT
FG	FIXED GLAZING
LO	LOUVRES (OPERABLE)
GA	GATE
SW	SLIDING WINDOW
OW	OPENABLE WINDOW
RF	RENDERED FINISH
MF	MOSAIC TILED FINISH
MR	MECHANICAL/ELECTRICAL RISER
HR	HYDRAULIC RISER
▽	FINISHED RL
H	HOSE TAP
G	GAS POINT

CHANGE SUMMARY

REV	CHANGE	DESCRIPTION
DA-L	36	Change of Layout to Level 03 Floor

ISSUE STATUS

REV	DESCRIPTION	DATE
A	ISSUE TO CLIENT FOR REVIEW	22/4/22
B	ISSUE FOR INFORMATION	22/5/05
C	ISSUE TO CONSULTANTS	22/5/10
D	ISSUE FOR INFORMATION	22/5/20
DA	ISSUE FOR DA	22/6/29
DA-A	REVISED ISSUE FOR COORDINATION - DA RFI AMENDMENTS	23/1/12
DA-B	REVISED SUBMISSION FOR DA	23/1/20
DA-D	REVISED DA SUBMISSION - RFI AMENDMENTS	23/7/27
DA-E	REVISED DA SUBMISSION - RFI AMENDMENTS	23/11/14
DA-F	ISSUE FOR COORDINATION	24/3/08
DA-G	ISSUE FOR S455	24/04/17
DA-H	ISSUE FOR S455 - COUNCIL RFI	24/07/05
DA-J	ISSUE FOR S455 02	24/07/11
DA-K	RE-ISSUE FOR S455 02	24/12/18
DA-L	ISSUE FOR S455 03 MOD	25/03/03


CLIENT Fortis Development Group
JOB 1728 Fortis South Steyne
34-35 South Steyne Manly NSW

ARCHITECT
durbach block jaggers
Level 2, 9 Roslyn Street
Potts Point NSW 2011
02 8297 3500
durbachblockjaggers.com
Nominated Architects
Neil Durbach NSW Reg. No 5850
David Jaggers NSW Reg. No 9999

DRAWN ND
CHECKED ND
DATE DRAWN 27.2.25
PRINTED 27/3/2025 9:56 am
SCALE 1:100 @ A1 / 1:200 @ A3
2m 4m

TITLE
GA Sections
Section AA, BB & EE

PROJECT NO.	ISSUE	REV
1728	S4.55	DA-L
DRAWING NO.	A-DA-310-001	

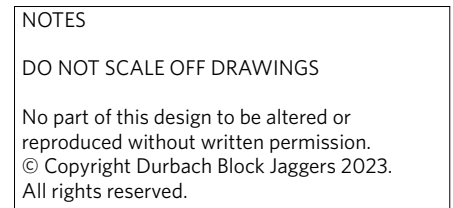

LEGEND	
AC	AIR CONDITIONING
E	ELECTRICAL SWITCHBOARD
FH	FIRE HYDRANT
FHR	FIRE HOSE REEL
FIP	FIRE INDICATOR PANEL
DF	DOWNPIPE
OF	OVERFLOW
RD	ROLLER DOOR
DRP	DRAINAGE POINT
FG	FIXED GLAZING
LO	LOUVERES (OPERABLE)
GA	GATE
SW	SLIDING WINDOW
OW	OPENABLE WINDOW
RF	RENDERED FINISH
MF	MOSAIC TILED FINISH
MR	MECHANICAL/ELECTRICAL RISER
HR	HYDRAULIC RISER
VR	FINISHED RL
▼	STRUCTURAL RL
H	HOSETAP
G	GAS POINT

NOTES:

1. FACADE WASHING SYSTEM
LOCATED IN THE SOFFIT OF EACH
OF THE 8 GLAZED EASTERN
FACADE WINDOW BAYS ON LEVEL
1 & 2.

[illegible]

ISSUE STATUS		
REV	DESCRIPTION	DATE
A	ISSUE TO CLIENT FOR REVIEW	22/04/22
B	ISSUE FOR INFORMATION	22/05/05
C	ISSUE TO CONSULTANTS	22/05/10
D	ISSUE FOR INFORMATION	22/05/20
DA	ISSUE FOR DA	22/06/29
DA-A	REVISED ISSUE FOR COORDINATION - DA RFI AMENDMENTS	23/1/12
DA-B	REVISED SUBMISSION FOR DA	23/1/20
DA-D	REVISED DA SUBMISSION - RFI AMENDMENTS	23/7/27
DA-E	REVISED DA SUBMISSION - RFI AMENDMENTS	23/11/14
DA-F	ISSUE FOR COORDINATION	24/3/08
DA-G	ISSUE FOR S455	24/04/17
DA-H	ISSUE FOR S455 - COUNCIL RFI	24/07/05
DA-I	ISSUE FOR S455 02	24/07/21
DA-K	RE-ISSUE FOR S455 02	24/12/18
DA-L	ISSUE FOR S4.55 03 MOD	25/03/03

CLIENT	Fortis Development Group
JOB	1728 Fortis South Steyne 34-35 South Steyne Manly NSW

ARCHITECT

durbach block jagers

Level 2, 9 Roslyn Street
Potts Point NSW 2011
02 8297 3500
durbachblockjagers.com

Nominated Architects
Neil Durbach NSW Reg. No 5850
David Jagers NSW Reg. No 9999







DRAWN	CHECKED	DATE DRAWN	PRINTED
ND		27.2.25	27/3/2025 9:56 am
SCALE 1:100 @ A1 / 1:200 @ A3			
			

TITLE	
GA Sections	
Section CC	

PROJECT NO. 1728	ISSUE S4.55	REV. DA-L
DRAWING NO. A-DA-310-002		



1:100

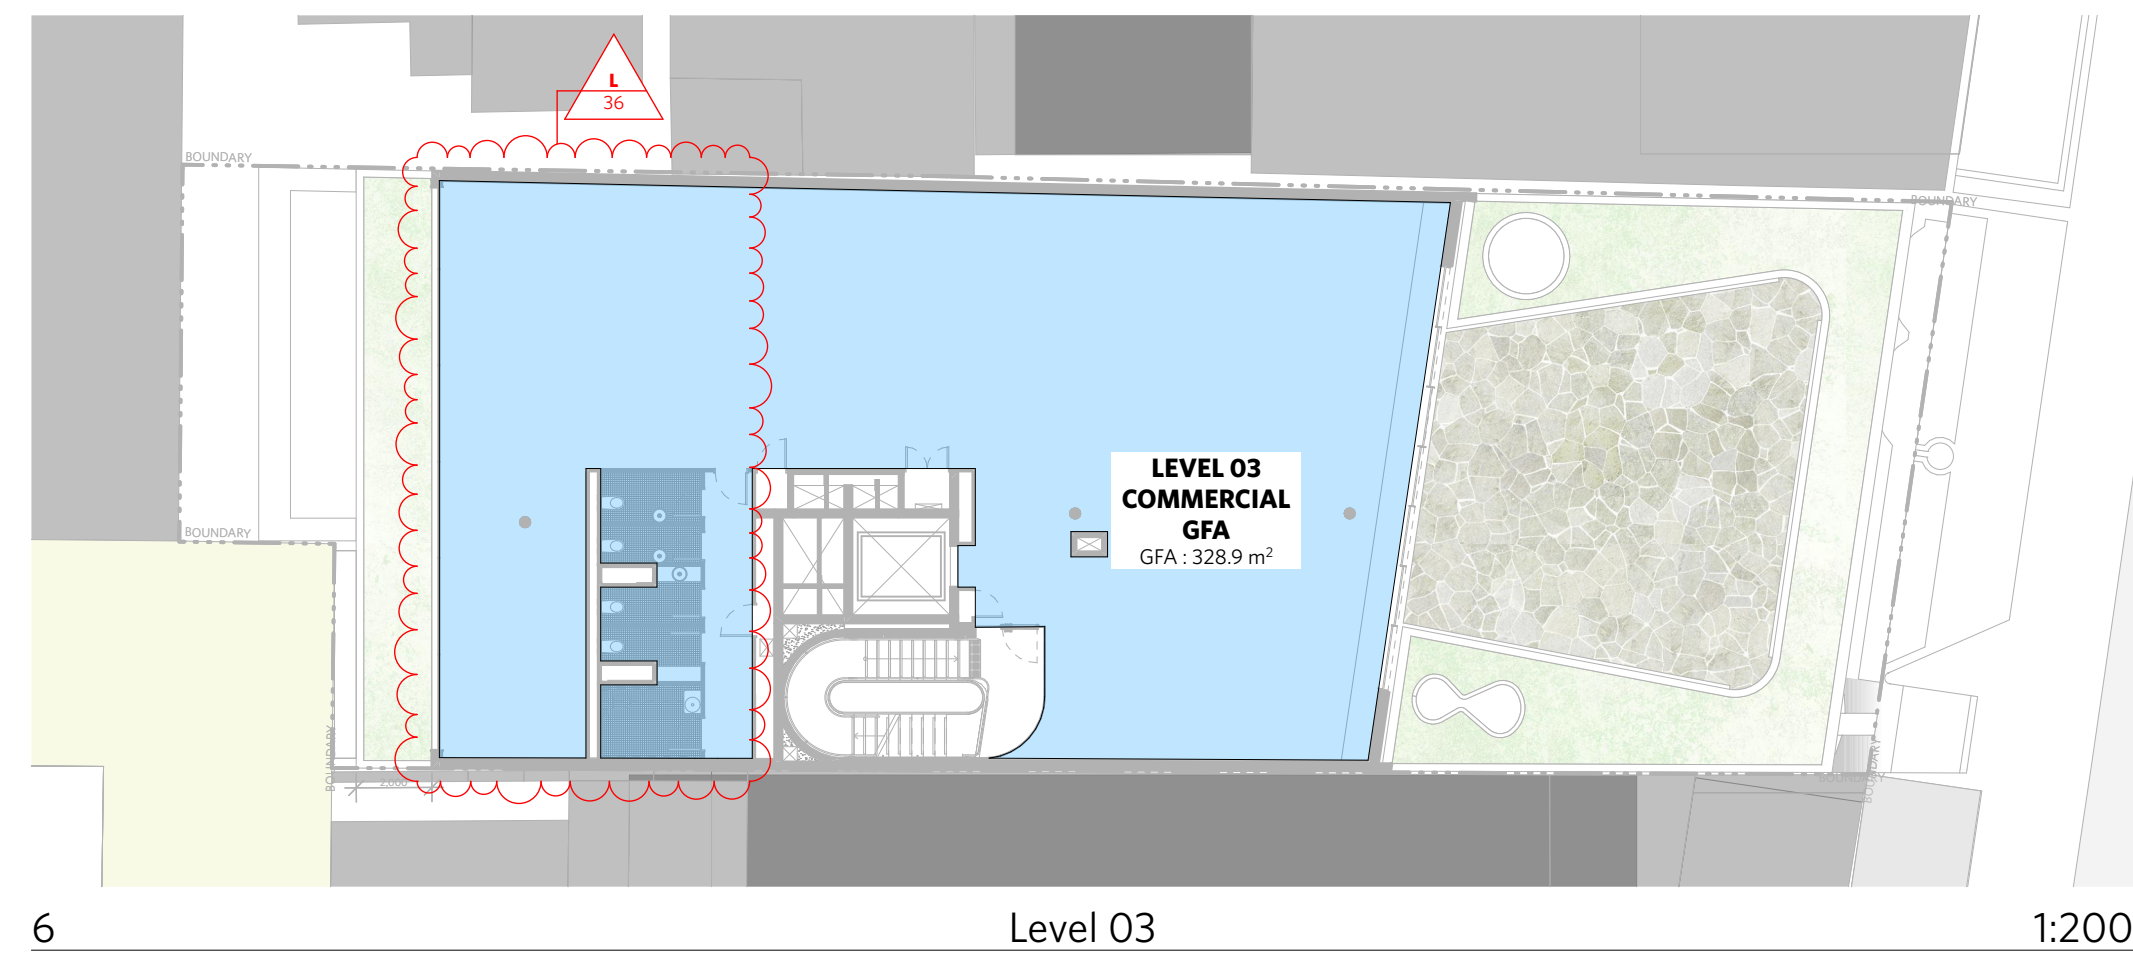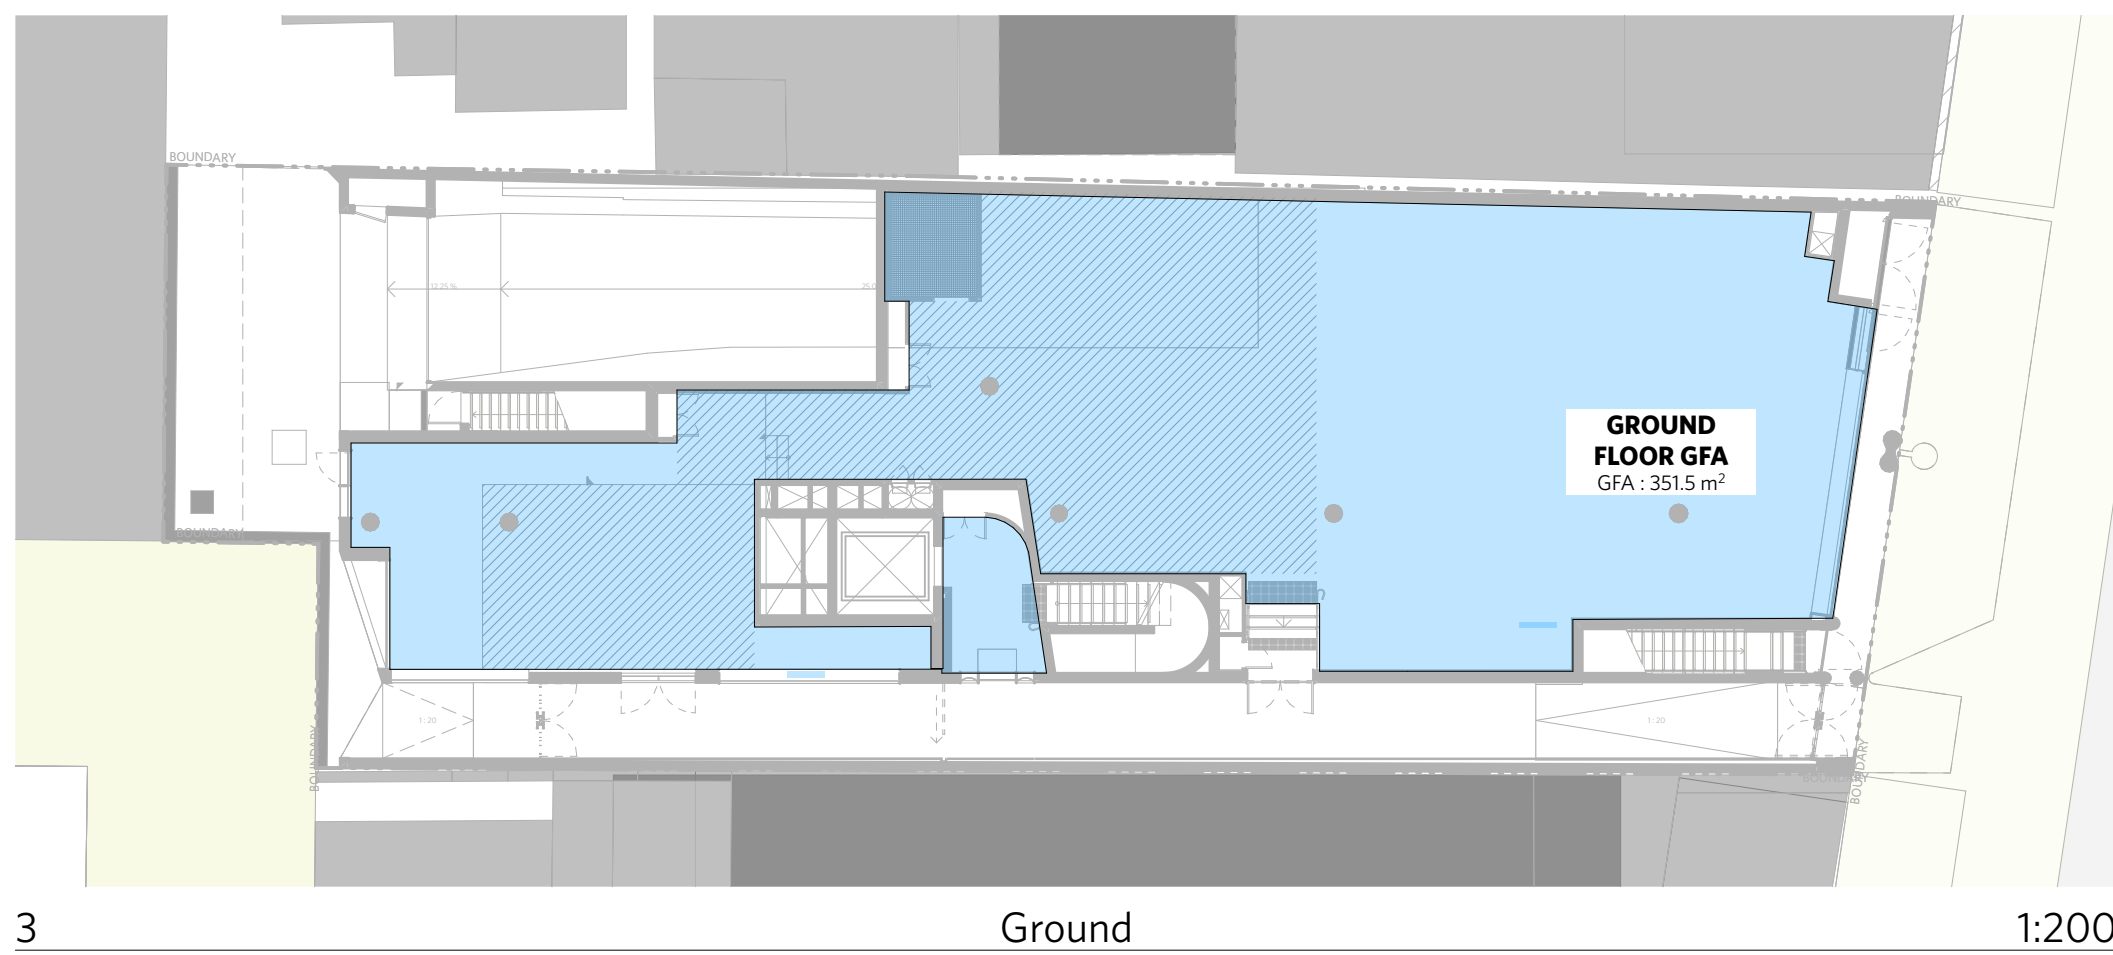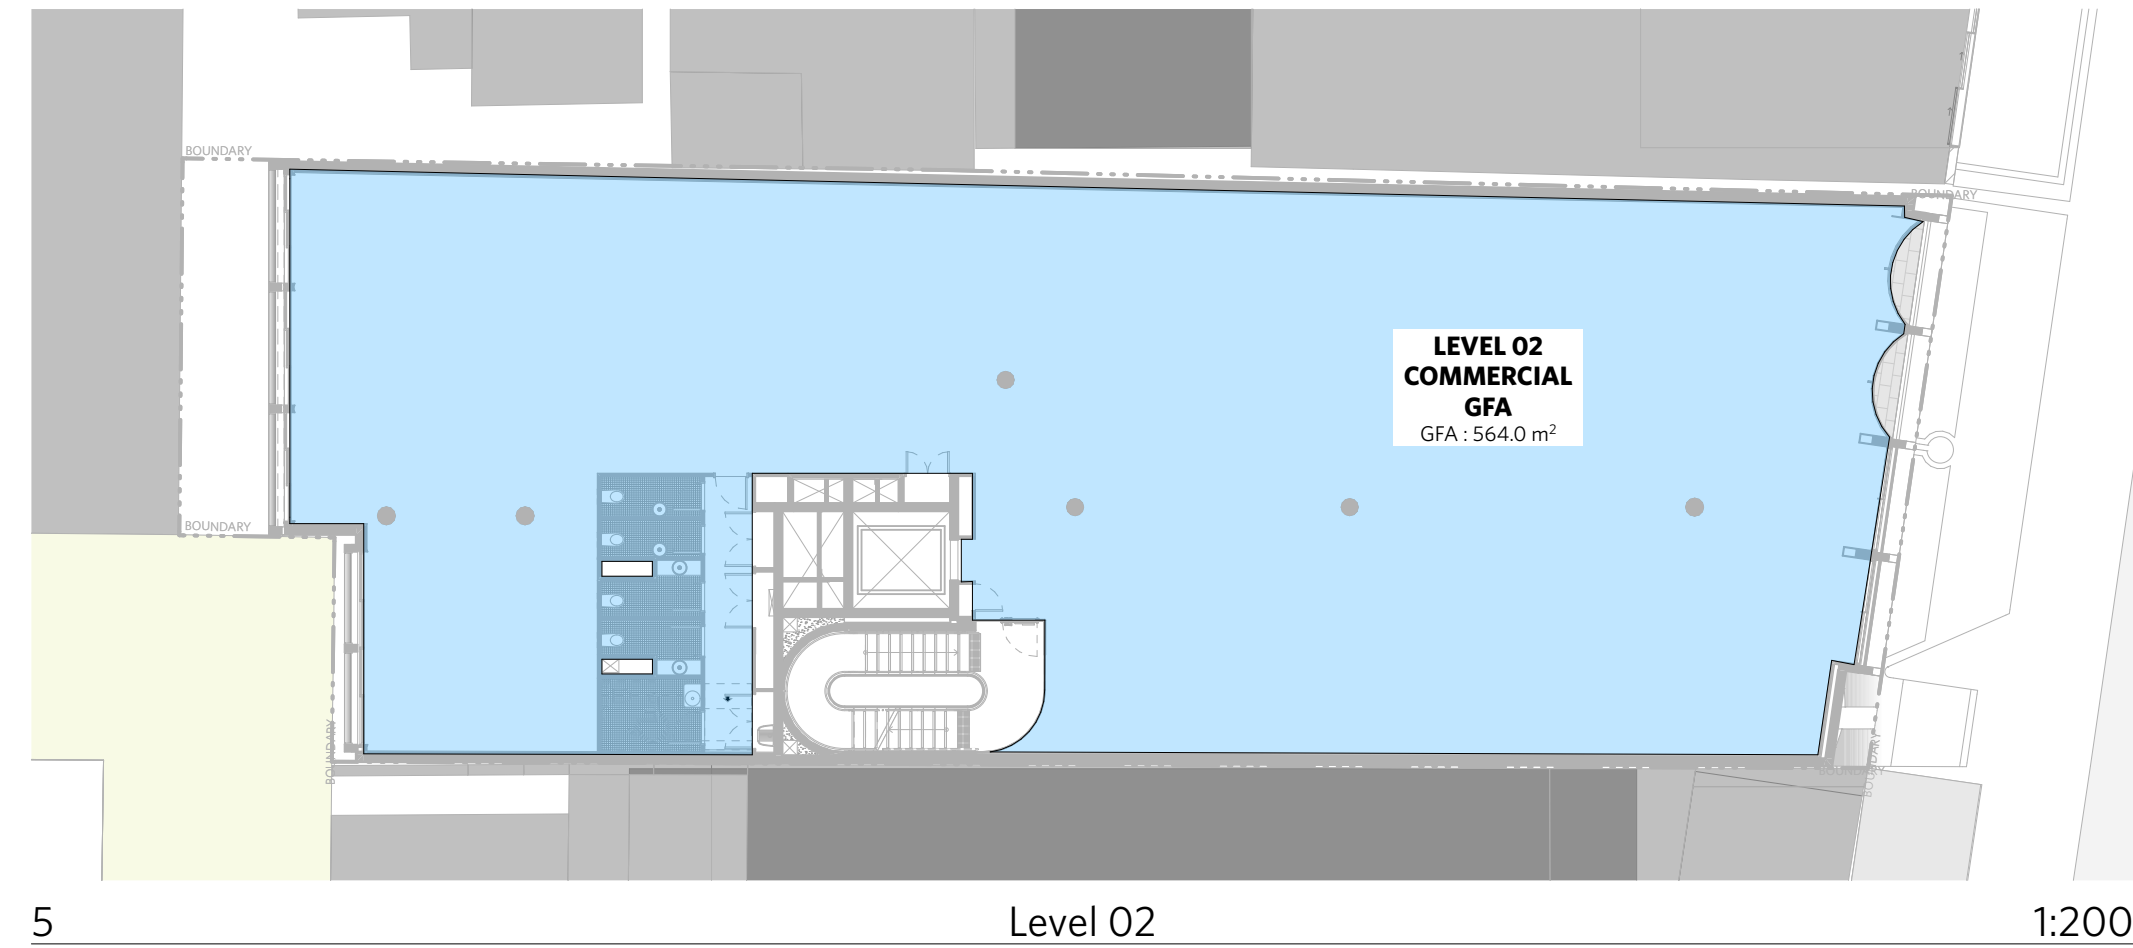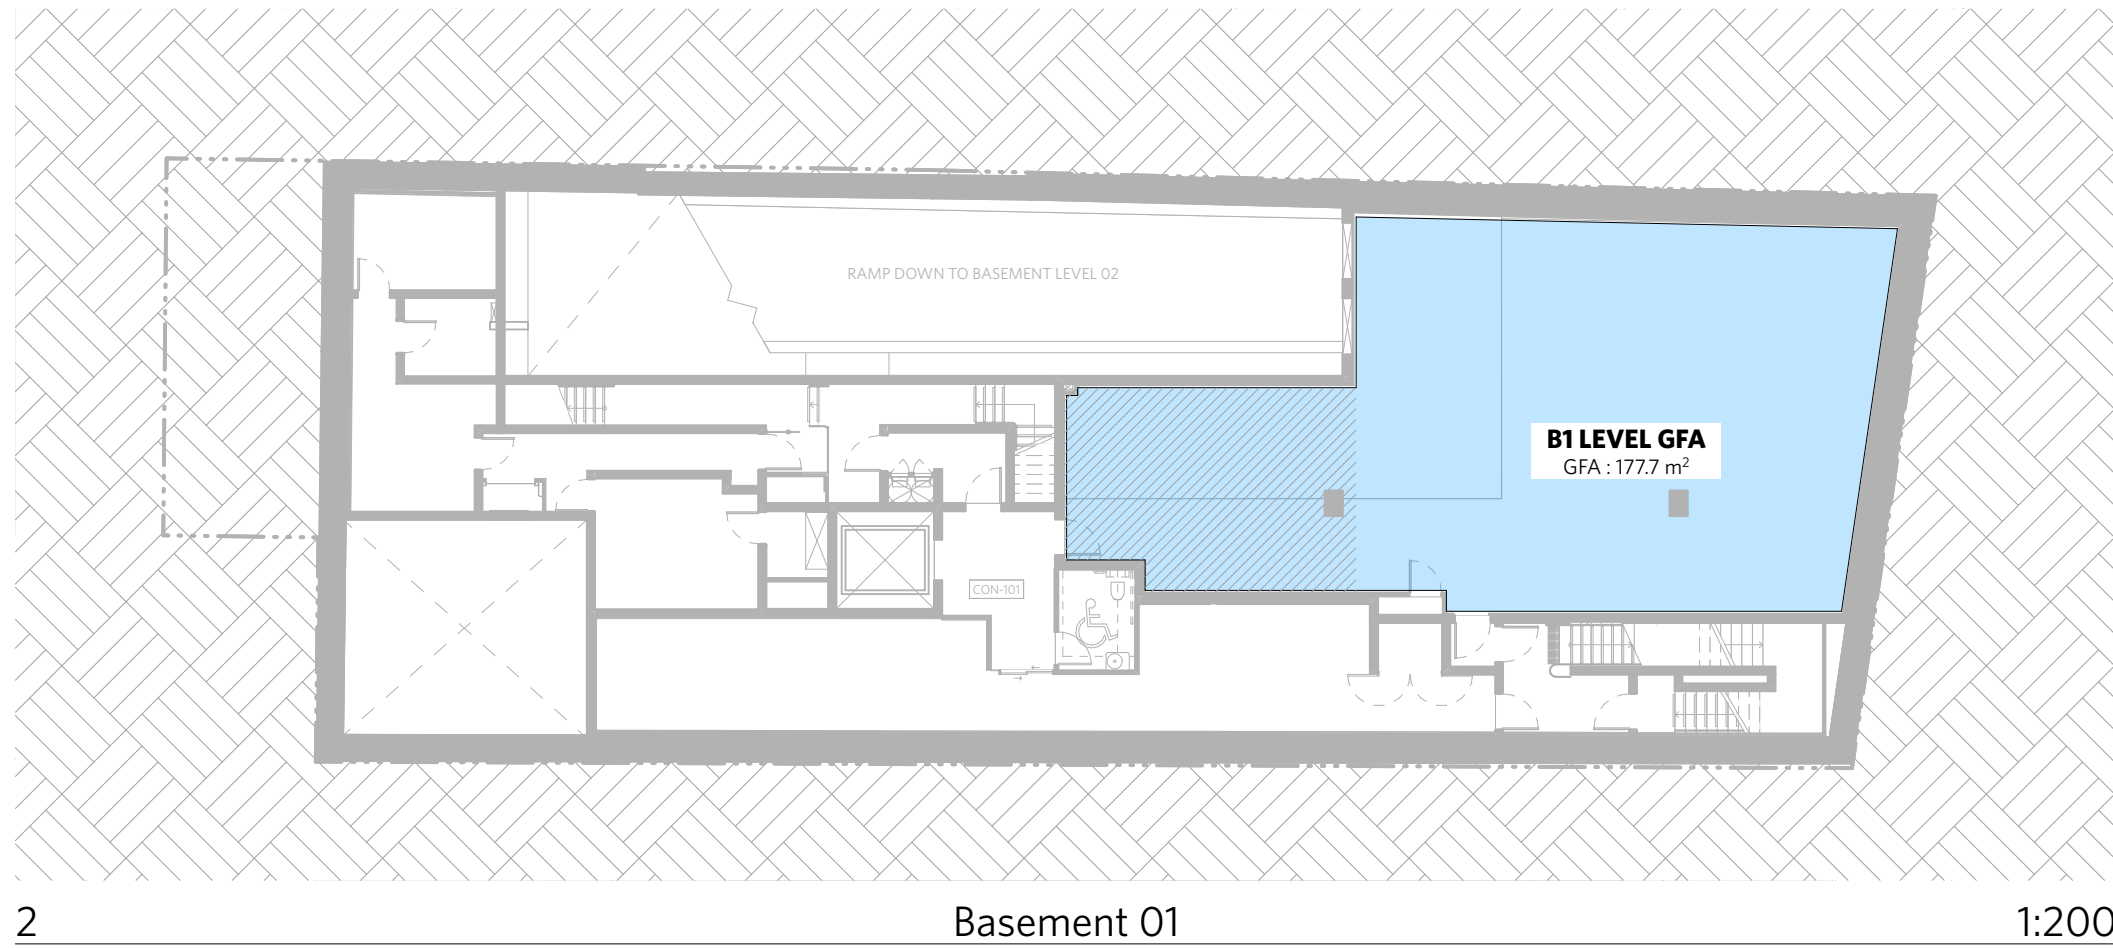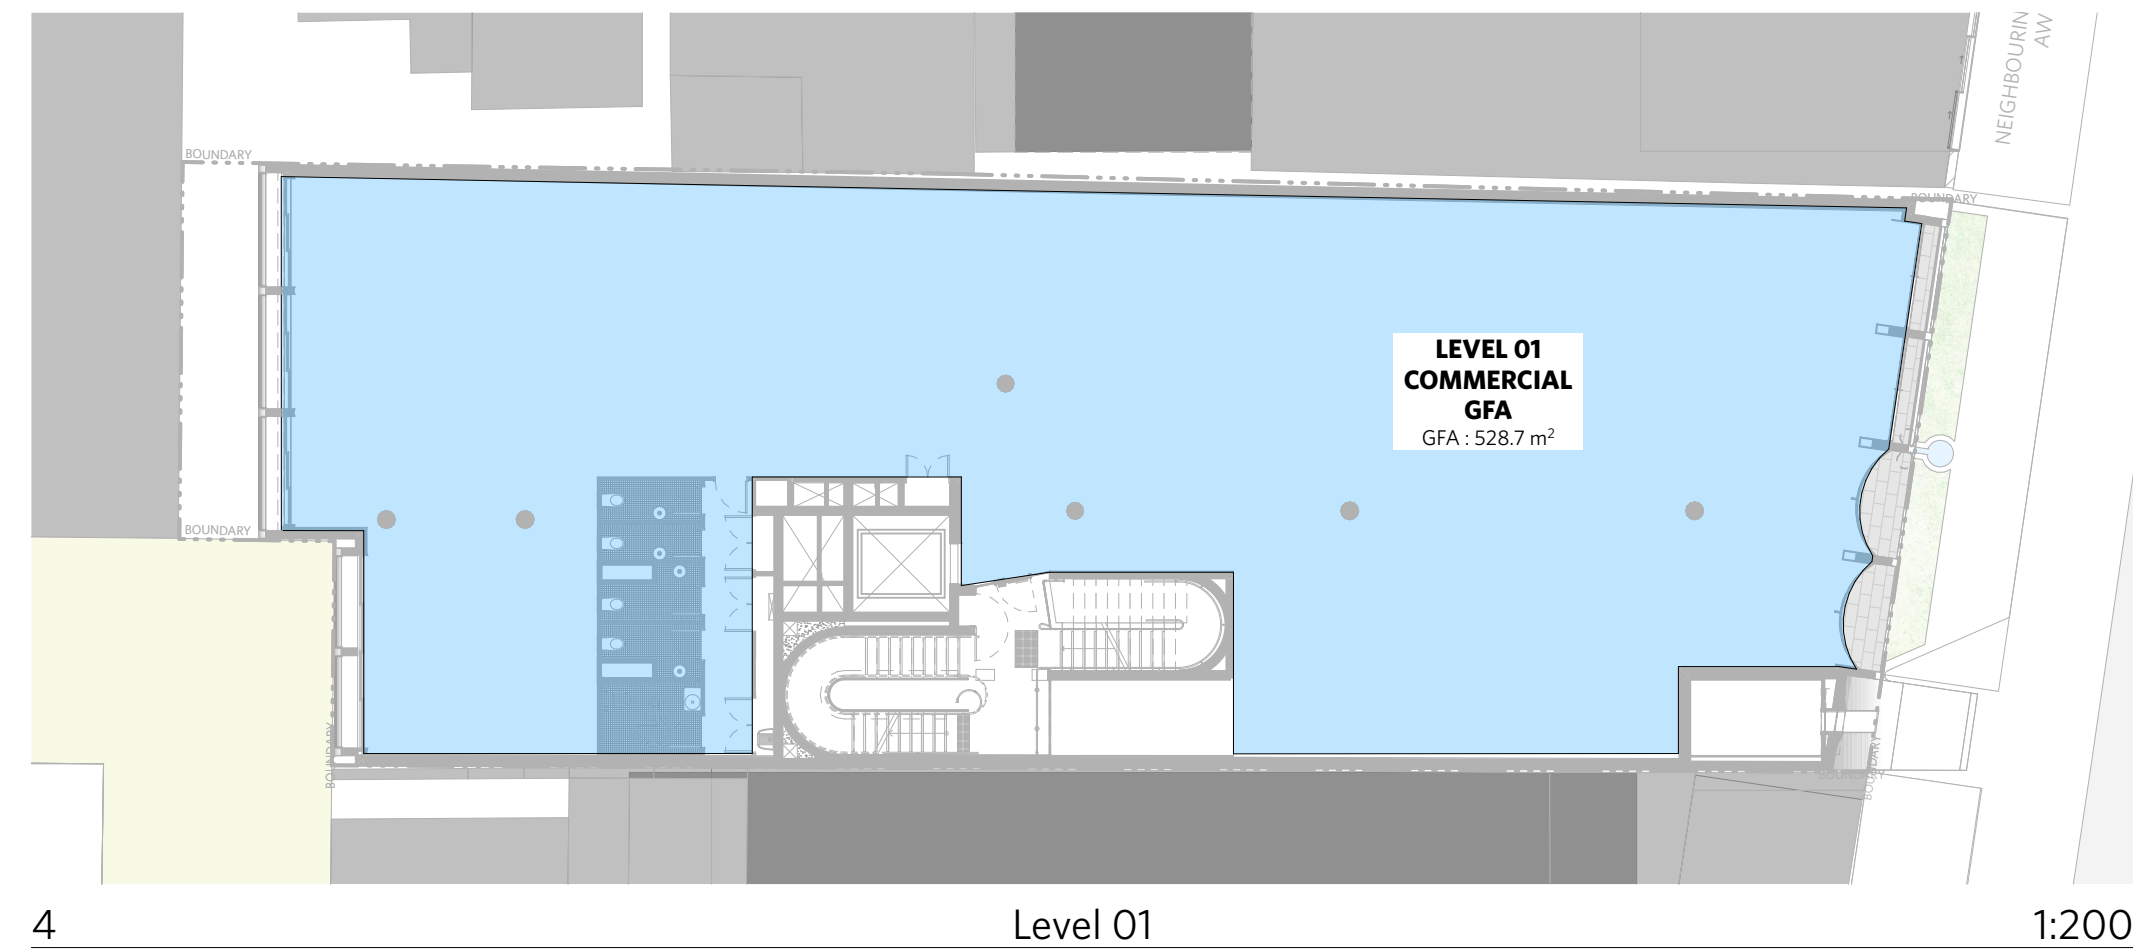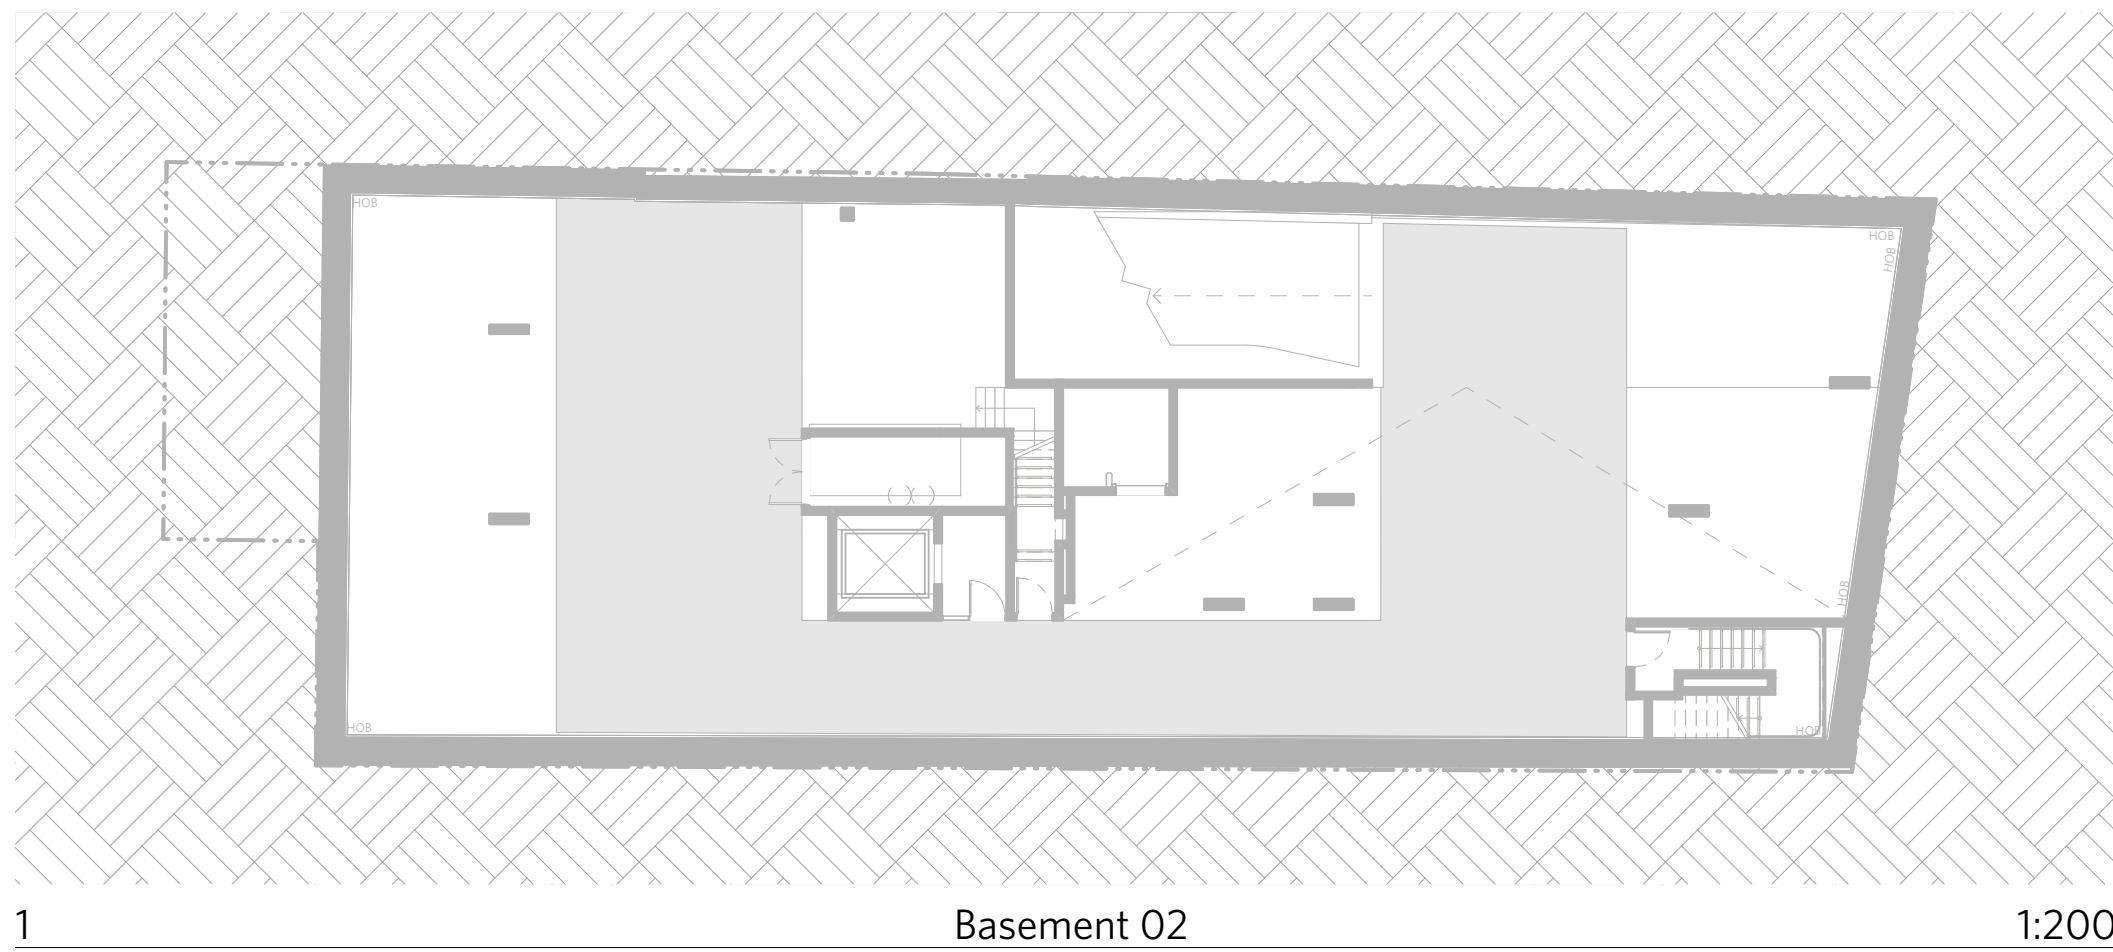

CHANGES RELEVANT TO THIS MODIFICATION APPLICATION

1728 GFA Schedule 1		
Home Story Name	Zone Name	Calculated Area (sqm)
Basement 01		
	B1 LEVEL GFA	177.7
Ground		
	GROUND FLOOR GFA	351.5
Level 01		
	LEVEL 01 COMMERCIAL GFA	528.7
Level 02		
	LEVEL 02 COMMERCIAL GFA	564.0
Level 03		
	LEVEL 03 COMMERCIAL GFA	328.9
		1,950.8 m²

NOTES	
DO NOT SCALE OFF DRAWINGS	
No part of this design to be altered or reproduced without written permission. © Copyright Durabach Block Jagers 2023. All rights reserved.	
LEGEND	
AC	ELECTRICAL SWITCHBOARD
FH	FIRE HYDRANT
FHR	FIRE HOSE REEL
FI	FIRE INDICATOR BELL
DP	DOWNPIPE
OF	OVERFLOW
RD	ROLLER DOOR
SW	DRAINAGE POINT
FG	FIXED GLAZING
LO	LOUVERES (OPERABLE)
GA	GATE
SW	SLIDING WINDOW
OW	OPENABLE WINDOW
RF	RENDERED FINISH
MF	MOSAIC TILED FINISH
MR	MECHANICAL/ELECTRICAL RISER
HR	HYDRAULIC RISER
▼	FINISHED RL
H	STRUCTURAL RL
G	HOSEPAT
G	GAS POINT

CHANGE SUMMARY		
REV	CHANGE	DESCRIPTION
DA-L	36	Change of Layout to Level 03 Floor

ISSUE STATUS		
REV	DESCRIPTION	DATE
A	ISSUE TO CLIENT FOR REVIEW	22/4/22
B	ISSUE FOR INFORMATION	25/5/05
C	ISSUE TO CONSULTANTS	22/5/10
D	ISSUE FOR INFORMATION	22/5/20
DA	ISSUE FOR DA	22/6/29
DA-A	REVISED ISSUE FOR COORDINATION - DA RFI AMENDMENTS	23/1/72
DA-B	REVISED SUBMISSION FOR DA	23/1/20
DA-C	ISSUE FOR S455	24/04/17
DA-J	ISSUE FOR S455 02	24/07/11
DA-L	ISSUE FOR S455 03 MOD	25/03/03

CLIENT	Fortis Development Group
JOB	1728 Fortis South Steyne 34-35 South Steyne Manly NSW

ARCHITECT

durbach block jagggers

Level 2, 9 Roslyn Street
Potts Point NSW 2011
02 8297 3500
durbachblockjagggers.com

Nominated Architects
Neil Durbach NSW Reg. No 5850
David Jagggers NSW Reg. No 9999

DRAWN	CHECKED	DATE DRAWN	PRINTED
ND		27.2.25	27/3/2025 9:56 am
SCALE 1:200 @ A1 / 1:400 @ A3			
			

TITLE	GFA & NLA Diagrams GFA Diagrams Sheet 1
-------	--

PROJECT NO.	ISSUE	REV.
1728	S4.55	DA-L
DRAWING NO.		
A-DA-710-001		