
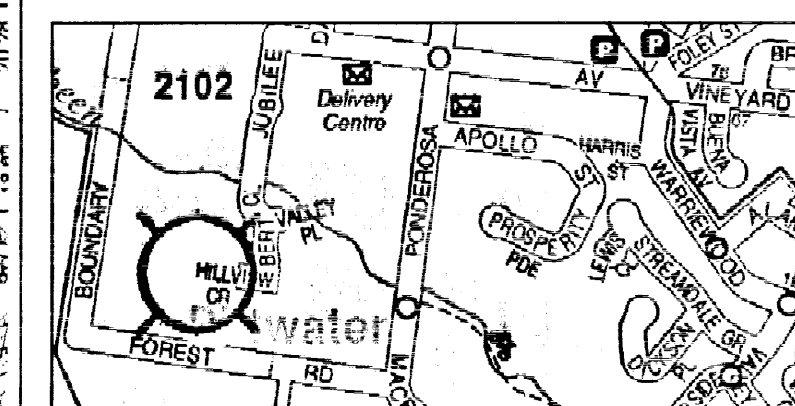


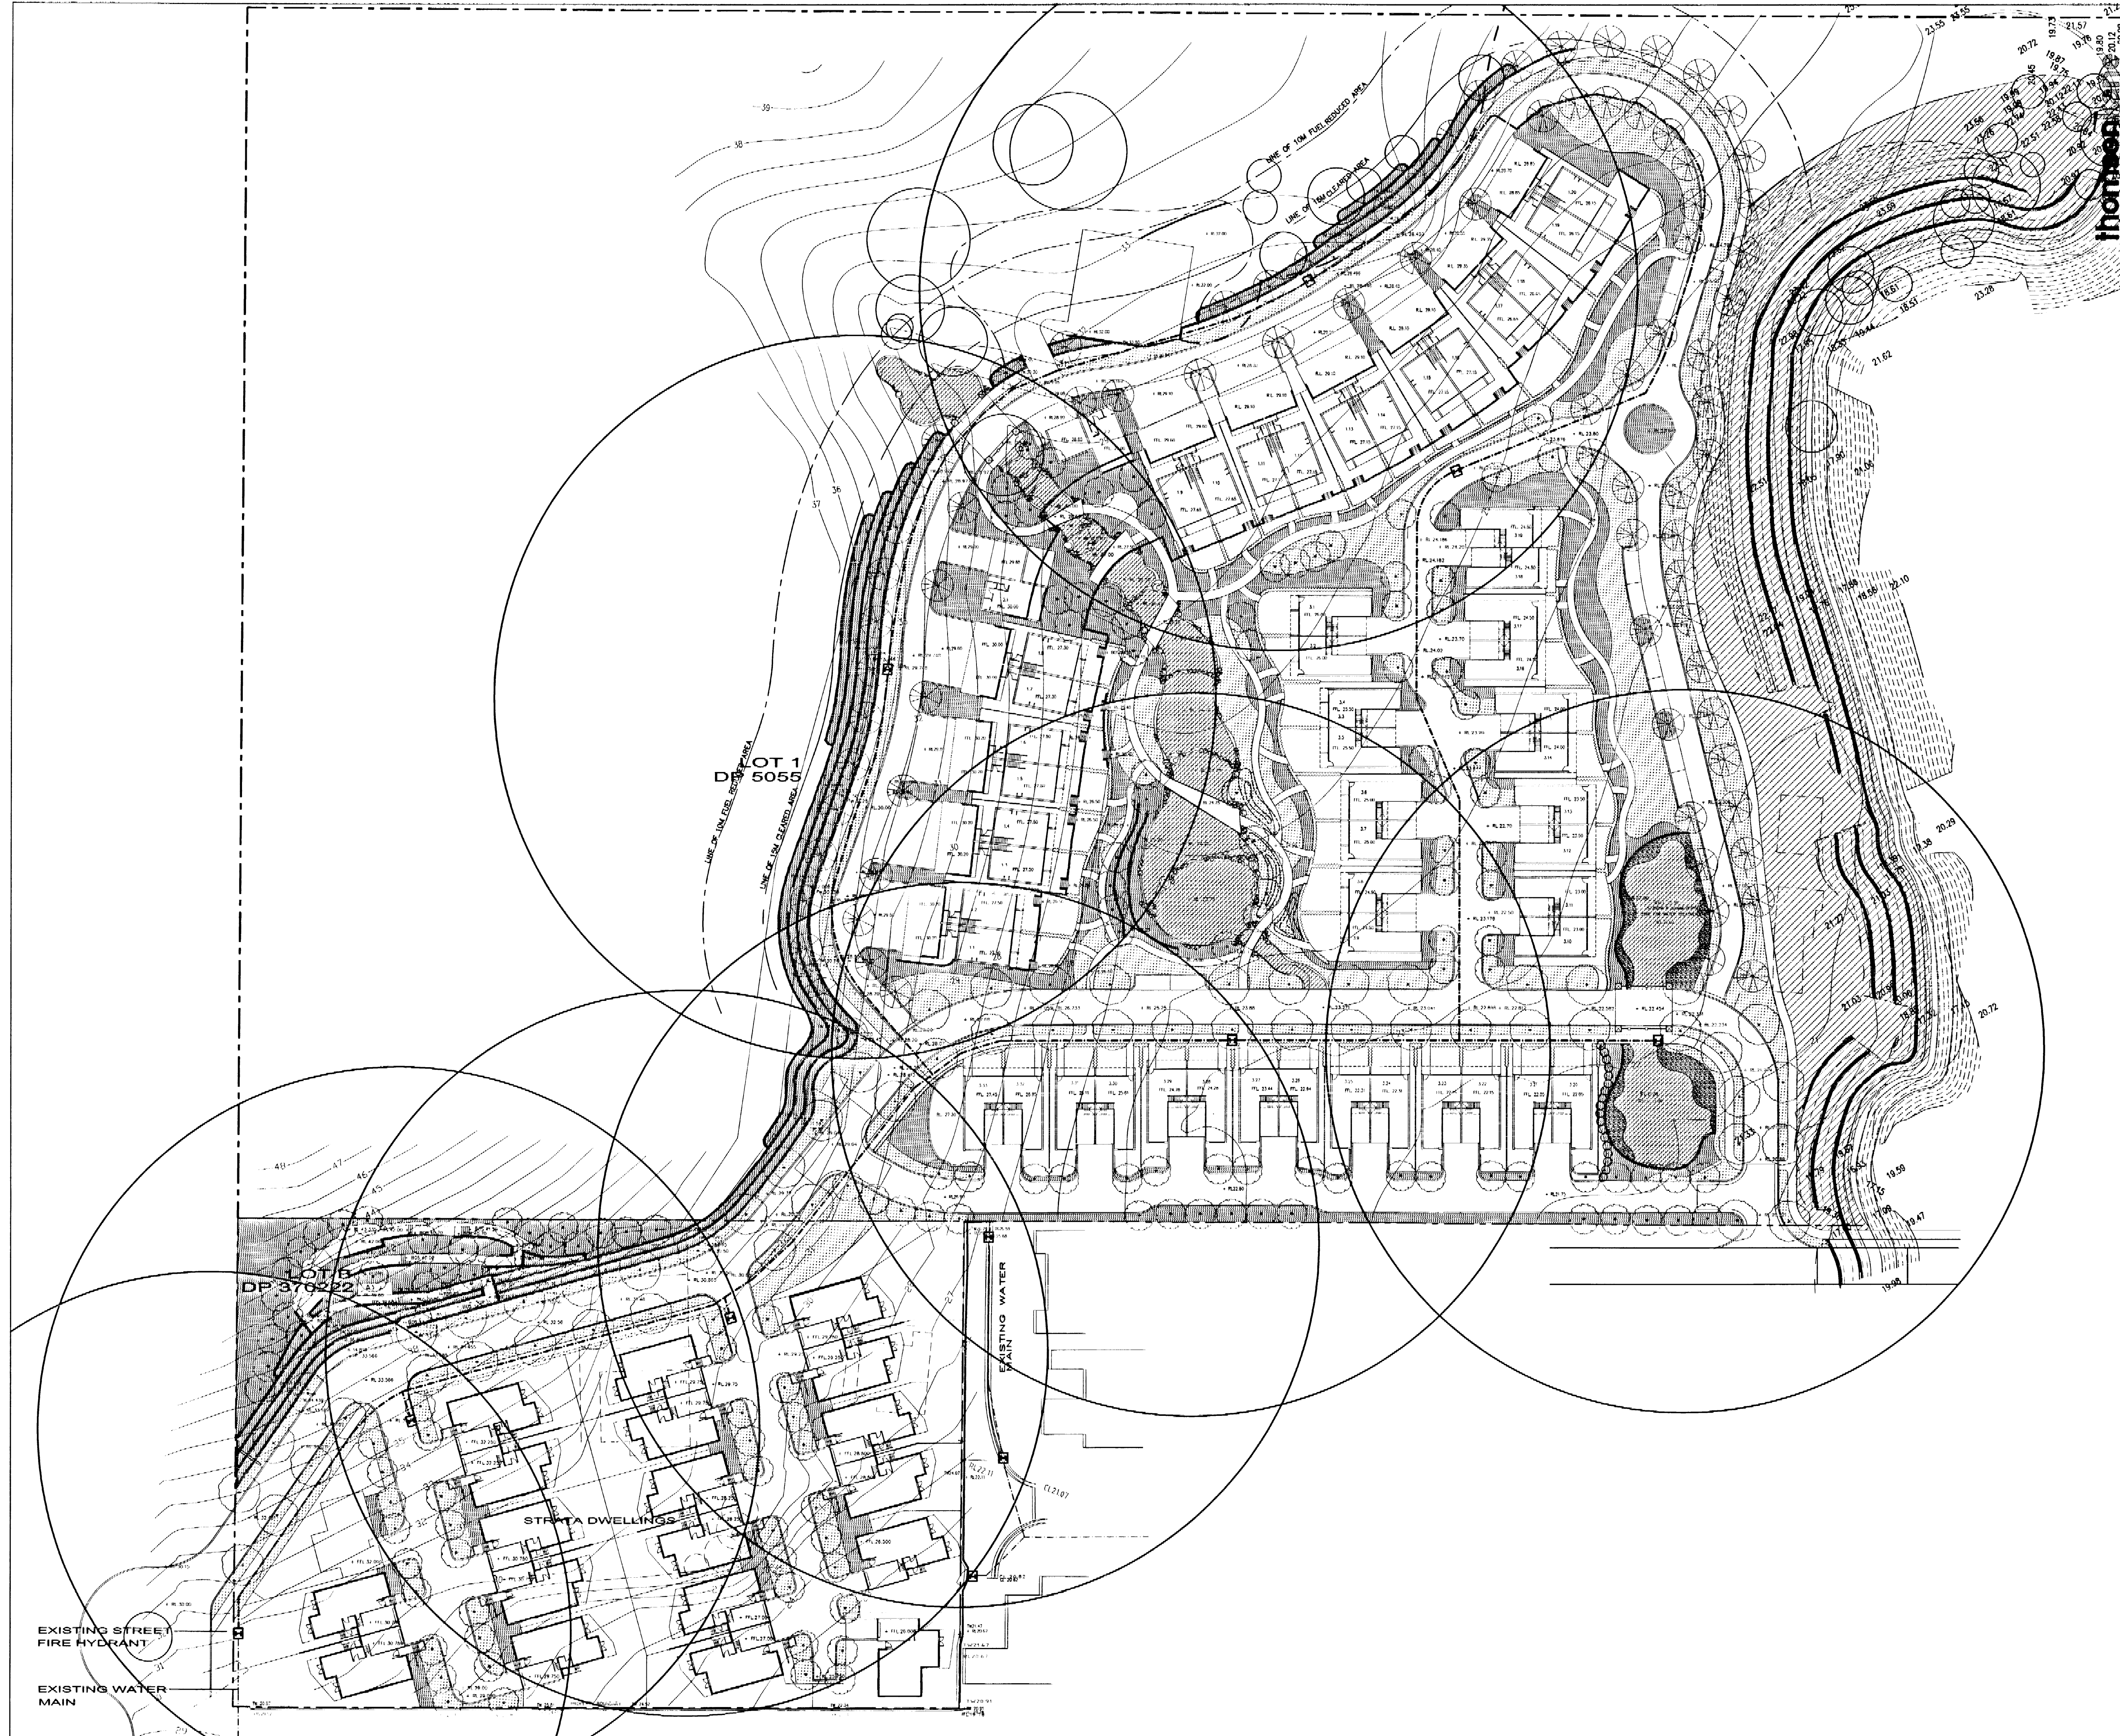

SITE LOCATION

LEGEND

- EXISTING WATER MAIN
- STREET HYDRANT
- - - - PROPOSED WATER MAIN
- COVERAGE CIRCLE OF FIRE HYDRANT

P7	REVIEW	AM	AT	08.12.04
P6	REVIEW	AM	AT	29.11.04
P5	REVIEW	AM	AT	20.10.04
P4	REVIEW	AM	AT	10.10.04
P3	REVIEW	AM	AT	10.09.04
P2	REVIEW	AM	AT	12.07.04
P1	PRELIMINARY ISSUE	AM	AT	17.08.04
REV	ISSUE	BY	CKD	DATE
SCHEDULE OF REFERENCE FILES				TK QA SYSTEM
DISCIPLINE	DRG NO.	REV	REASON FOR ISSUE	
ARCHITECTURAL	PLANS 29.10.04		AUTHORISATION	
STRUCTURAL			BY:	
LANDSCAPING	PLANS 06.12.04		VERIFICATION OF LATEST AMENDMENT	
ELECTRICAL			BY:	
CIVIL	PLANS 19.10.04			

HYDRAULIC ENGINEERS:
thomsonkane
Consulting Hydraulic and Fire Engineers
281 Pacific Highway, North Sydney NSW 2060
Phone: (02) 9955 0784 Fax: (02) 9954 6532
Email: tk@thomsonkane.com.au
WWW.THOMSONKANE.COM.AU
ACN 109 803 849
THIS DRAWING IS COPYRIGHT ©

ARCHITECTS:
Denis Leech Associates P/L
350 George Street, Sydney NSW 2000
Tel: (02) 9997 7288 Fax: (02) 9997 3164

MASTER PLANNING:
Wolski, Lyncenko & Brechnock
115 Military Road, Neutral Bay NSW 2059
Tel: (02) 9953 8477 Fax: (02) 9953 8557

ELECTRICAL:
WEBB
37 Ryde Road, Ryde NSW 2073
Tel: (02) 9418 1444 Fax: (02) 9418 1191

ENVIRONMENTAL:
WP Brown & Partners Pty Ltd
Level 2, 82 Waterloo Road
Mascot NSW 2113
Tel: (02) 9900 1000 Fax: (02) 9900 1099

LANDSCAPE:
Place Planning & Design P/L
Suite 10, Norberry Terrace, 177 Pacific Hwy
North Sydney NSW 2060
Tel: (02) 9959 5021 Fax: (02) 9959 5802

PROJECT:
PROPOSED RESIDENTIAL SUBDIVISION - 5 WARRIEWOOD VALLEY, WARRIEWOOD NSW

TITLE: HYDRAULIC SERVICES
SITE PLAN FIRE SERVICE

SCALE: 1:500	PROJECT No: 4733-1H	CAD REF: T:TKNEW/
DATE: JULY '04	DRAWING NUMBER: H-04	REVISION: P7
DRAWN BY: AT		
CKD BY: AT		

