



No part of this design to be altered or
 produced without written permission.
 Copyright Durbach Block Jaggers 2023.
 All rights reserved.

H	AIR CONDITIONING
C	ELECTRICAL SWITCHBOARD
H	FIRE HYDRANT
H	FIRE HOSE REEL
IP	FIRE INDICATOR PANEL
IP	DOWNPIPE
D	OVERFLOW
D	ROLLER DOOR
RP	DRAINAGE POINT
G	FIXED GLAZING
O	LOUVRES (OPERABLE)
A	GATE
W	SLIDING WINDOW
W	OPENABLE WINDOW
WF	FINISHED FINISH
MR	MOSAIC TILED FINISH
MR	MECHANICAL/ELECTRICAL RISER
7	HYDRAULIC RISER
7	FINISHED RL
4	STRUCTURAL RL
4	HOSETAP
5	GAS POINT

Traffic signals in Car Park will be implemented to give priority to entering traffic at all times except when exiting vehicle is detected

EV	CHANGE	DESCRIPTION
4.1		

ISSUE STATUS

B

4-35 South Steyne Manly NSW



Level 2, 9 Roslyn Street
Botts Point NSW 2011
02 8297 3500
airbachblockjaggers.com


David Jagers NSW Reg. No 9999

00 @ A1 / 1:200 @ A2


FILE			
------	--	--	--

1728	DA	DA-J
------	----	------

A-DA-110-000

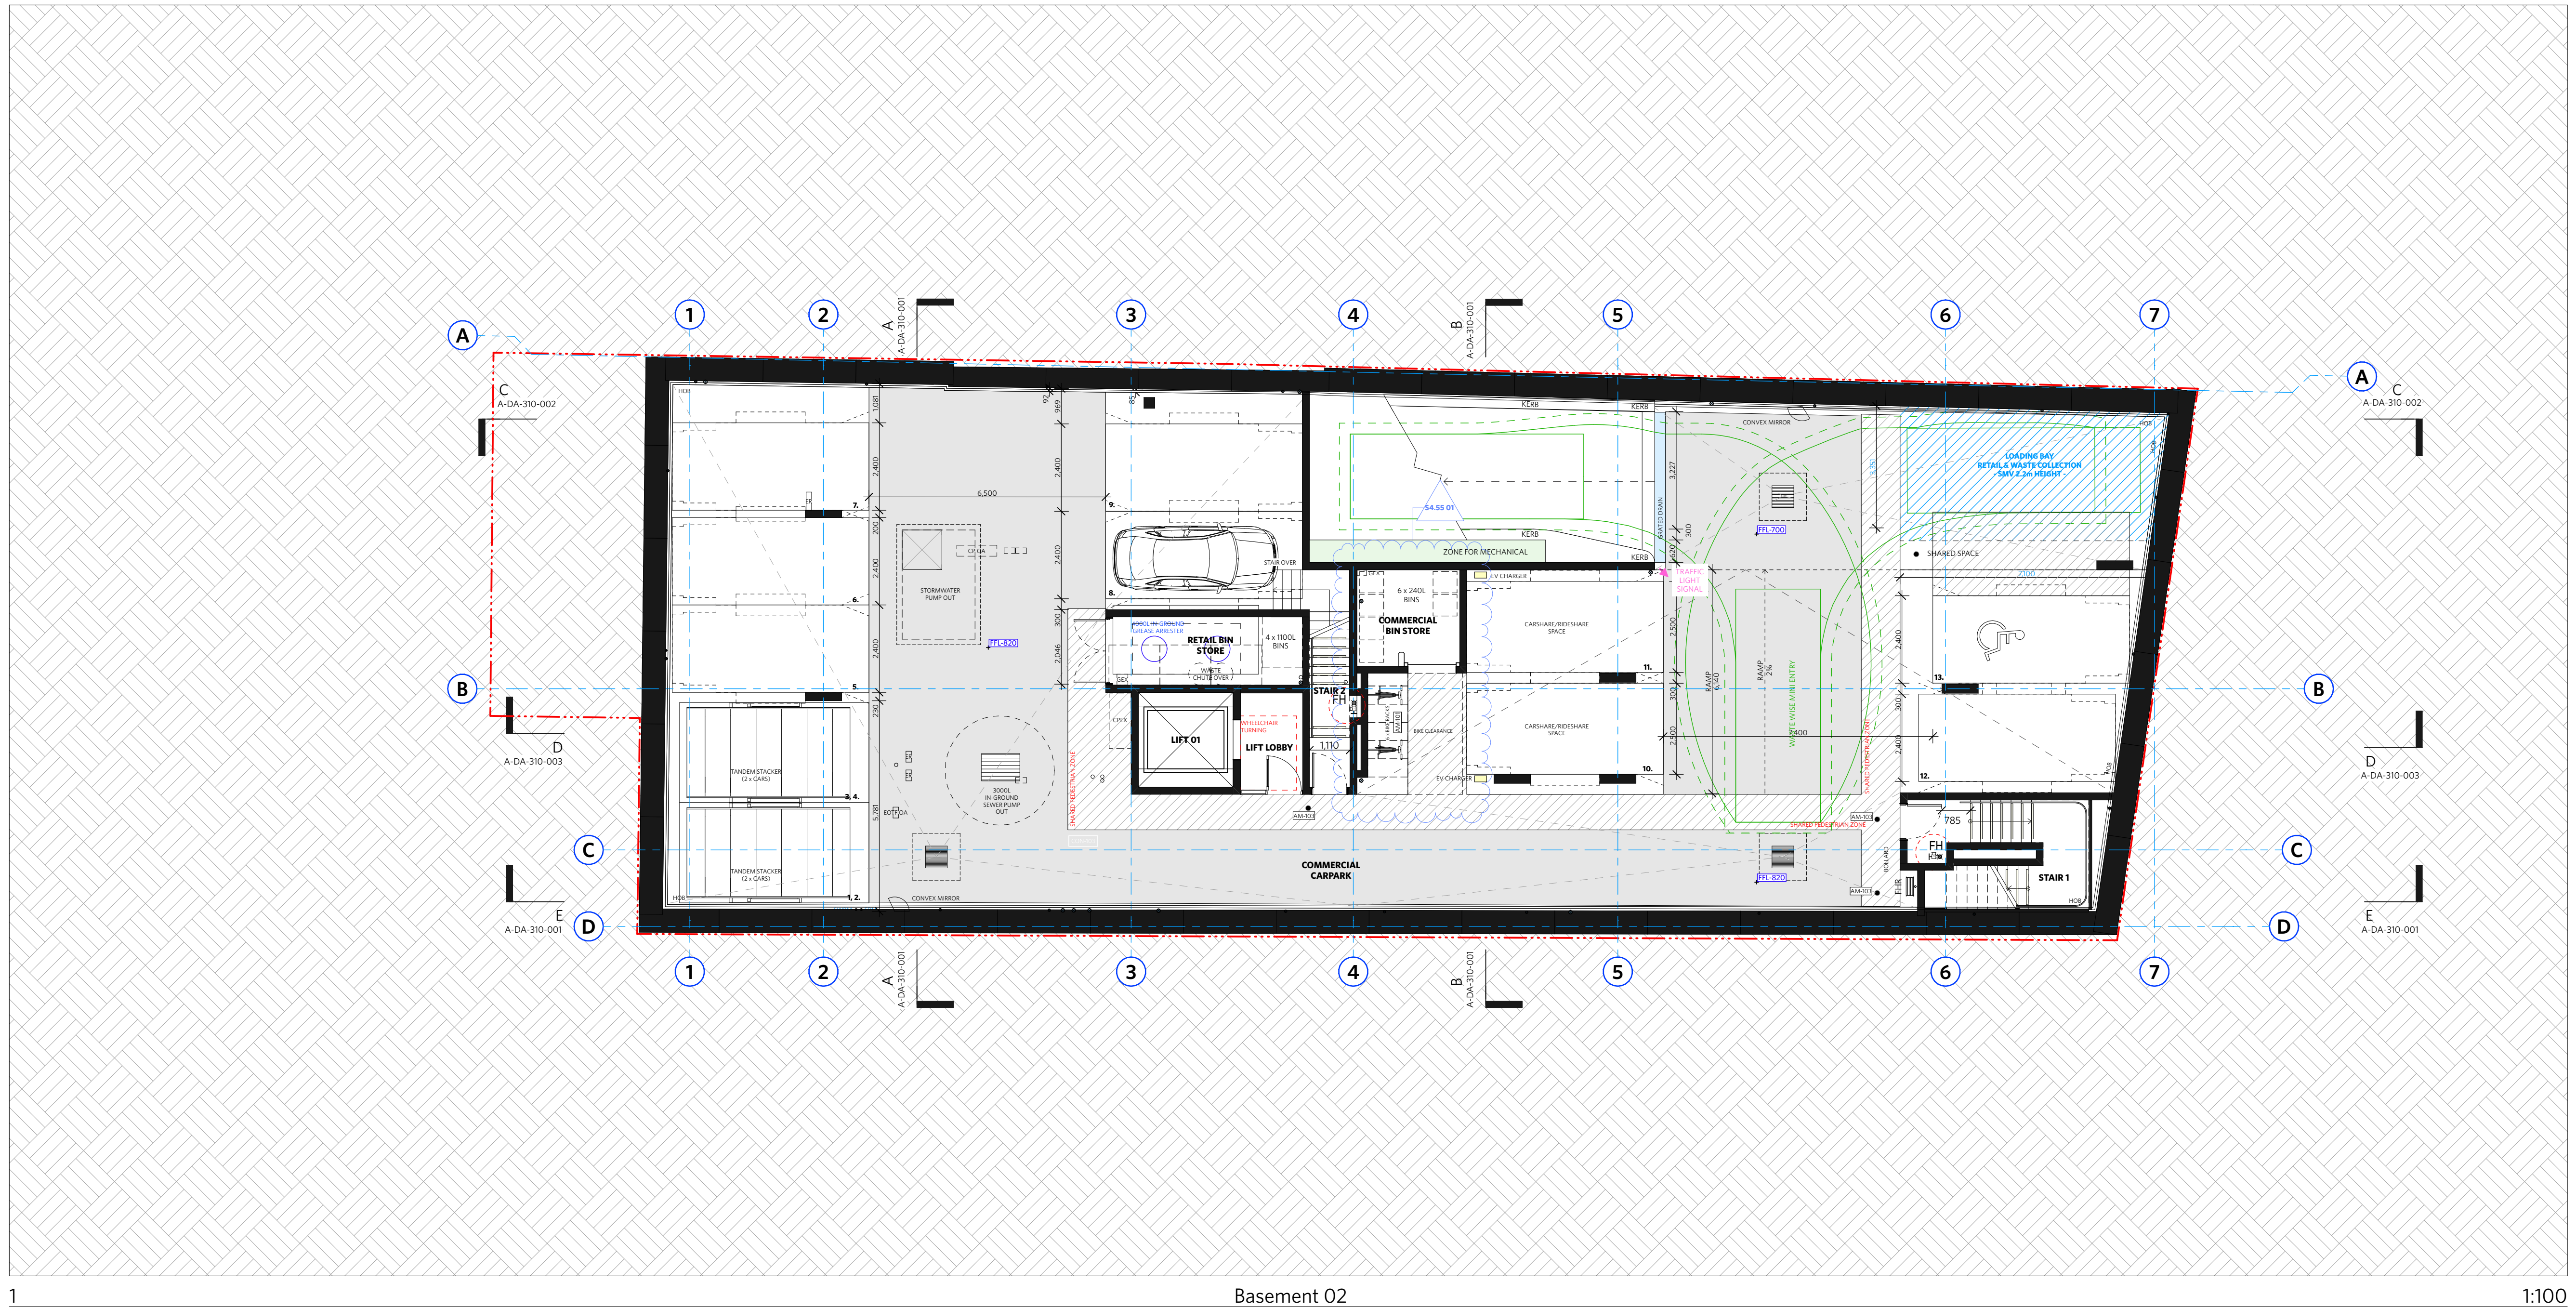


CHANGES AS SUBMITTED IN S4.55 -
UNDER REVIEW - MOD/2024/0225

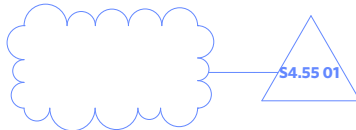

CHANGES RELEVANT TO THIS MODIFICATION
APPLICATION



CHANGES REVIEWED AND APPROVED UNDER DA/
2022/1164 - CONDITION 28

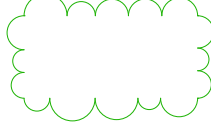

NOTES

DO NOT SCALE OFF DRAWINGS

No part of this design to be altered or reproduced without written permission.
© Copyright Durbach Block Jaggers 2023.
All rights reserved.

LEGEND

AC	AIR CONDITIONING
E	ELECTRICAL SWITCHBOARD
FH	FIRE HYDRANT
FHR	FIRE HOSE REEL
FIP	FIRE INDICATOR PANEL
DP	DOWNPIPE
OF	OVERFLOW
RD	ROLLER DOOR
DRP	DRAINAGE POINT
FG	FIXED GLAZING
LO	LOUVRES (OPERABLE)
GA	GATE
SW	SLIDING WINDOW
OW	OPENABLE WINDOW
RF	RENDERED FINISH
MF	MOSAIC TILED FINISH
MR	MECHANICAL/ELECTRICAL RISER
HR	HYDRAULIC RISER
▽	FINISHED RL
▼	STRUCTURAL RL
H	HOSETAP
G	GAS POINT

NOTE:

Traffic signals in Car Park will be implemented to give priority to entering traffic at all times except when exiting vehicle is detected

CHANGE SUMMARY

REV	CHANGE	DESCRIPTION
DA-J	20	Relocation of Sprinkler & booster alarm valves to fire stair 02

ISSUE STATUS

REV	DESCRIPTION	DATE
A	ISSUE TO CLIENT FOR REVIEW	22/4/22
B	ISSUE FOR INFORMATION	22/5/05
C	ISSUE TO CONSULTANTS	22/5/10
D	ISSUE FOR INFORMATION	22/5/20
DA	ISSUE FOR DA	22/6/29
DA-A	REVISED ISSUE FOR COORDINATION - DA RFI AMENDMENTS	23/1/12
DA-B	REVISED SUBMISSION FOR DA	23/1/20
DA-D	REVISED DA SUBMISSION - RFI AMENDMENTS	23/7/27
DA-E	REVISED DA SUBMISSION - RFI AMENDMENTS	23/11/14
DA-F	ISSUE FOR COORDINATION	24/3/08
DA-G	ISSUE FOR S455	24/04/17
DA-J	ISSUE FOR S455 02	24/07/11


CLIENT Fortis Development Group

JOB

1728 Fortis South Steyne

34-35 South Steyne Manly NSW

ARCHITECT

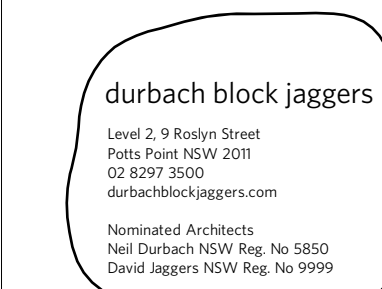

DRAWN	CHECKED	DATE DRAWN	PRINTED
[m]		24/07/01	18/7/2024 11:48 am

SCALE 1:100 @ A1 / 1:200 @ A3



TITLE

GA Plans
Basement 1 Plan


PROJECT NO. 1728

ISSUE DA

REV DA-J

DRAWING NO. A-DA-110-001


CHANGES AS SUBMITTED IN S4.55 - UNDER REVIEW - MOD/2024/0225

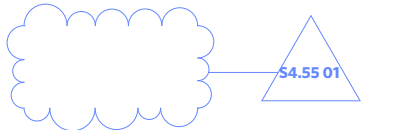

CHANGES RELEVANT TO THIS MODIFICATION APPLICATION



CHANGES REVIEWED AND APPROVED UNDER DA/2022/1164 - CONDITION 28

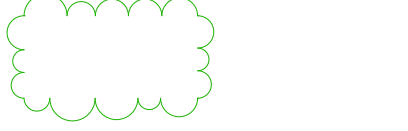

NOTES

DO NOT SCALE OFF DRAWINGS

No part of this design to be altered or reproduced without written permission.
© Copyright Durbach Block Jaggers 2023.
All rights reserved.

LEGEND

AC	AIR CONDITIONING
E	ELECTRICAL SWITCHBOARD
FH	FIRE HYDRANT
FHR	FIRE HOSE REEL
FIP	FIRE INDICATOR PANEL
DP	DOWNPIPE
OF	OVERFLOW
RD	ROLLER DOOR
DRP	DRAINAGE POINT
FG	FIXED GLAZING
LO	LOUVRES (OPERABLE)
GA	GATE
SW	SLIDING WINDOW
OW	OPENABLE WINDOW
RF	RENDERED FINISH
MF	MOSAIC TILED FINISH
MR	MECHANICAL/ELECTRICAL RISER
HR	HYDRAULIC RISER
▽	FINISHED RL
H	HOSE TAP
G	GAS POINT

NOTE:

Traffic signals in Car Park will be implemented to give priority to entering traffic at all times except when exiting vehicle is detected

CHANGE SUMMARY

REV	CHANGE	DESCRIPTION
21	DA-J	Additional openings added into Ground floor Tenancy
22	DA-J	Relocation of Sprinkler Booster to South Steyne
23	DA-J	Sliding Fire Door Added to Through Site Link
24	DA-J	Removed flood barrier & replaced with passive flood barrier

ISSUE STATUS

REV	DESCRIPTION	DATE
A	ISSUE TO CLIENT FOR REVIEW	22/4/22
B	ISSUE FOR INFORMATION	22/5/05
C	ISSUE TO CONSULTANTS	22/5/10
D	ISSUE FOR INFORMATION	22/5/20
DA	ISSUE FOR DA	22/6/29
DA-A	REVISED ISSUE FOR COORDINATION - DA RFI AMENDMENTS	23/1/12
DA-B	REVISED SUBMISSION FOR DA	23/1/20
DA-D	REVISED DA SUBMISSION - RFI AMENDMENTS	23/7/27
DA-E	REVISED DA SUBMISSION - RFI AMENDMENTS	23/11/14
DA-F	ISSUE FOR COORDINATION	24/3/08
DA-G	ISSUE FOR S455	24/04/17
DA-J	ISSUE FOR S455 02	24/07/11

CLIENT Fortis Development Group

JOB 1728 Fortis South Steyne

34-35 South Steyne Manly NSW

ARCHITECT

durbach block jaggers

Level 2, 9 Roslyn Street
Porto Point NSW 2011
02 8297 3500
durbachblockjaggers.com

Nominated Architects
Neil Durbach NSW Reg. No 5850
David Jaggers NSW Reg. No 9999

DRAWN [m] CHECKED DATE DRAWN 24/07/01 PRINTED 18/7/2024 11:48 am

SCALE 1:100 @ A1 / 1:200 @ A3



TITLE

GA Plans
Ground Plan

PROJECT NO. 1728

ISSUE DA

REV DA-J

DRAWING NO. A-DA-110-003



No part of this design to be altered or
 produced without written permission.
 Copyright Durbach Block Jaggers 2023.
 All rights reserved.

C	AIR CONDITIONING
	ELECTRICAL SWITCHBOARD
	FIRE HYDRANT
HR	FIRE HOSE REEL
	FIRE INDICATOR PANEL
P	DOWNPIPE
D	OVERFLOW
	ROLLER DOOR
RP	DRAINAGE POINT
G	FIXED GLAZING
O	LOUVRES (OPERABLE)
A	GATE
W	SLIDING WINDOW
	OPENABLE WINDOW
	RED FINISH
MF	MOSAIC TILED FINISH
MR	MECHANICAL/ELECTRICAL RISER
MR	HYDRAULIC RISER
7	FINISHED RL
	STRUCTURAL RL
4	HOSETAP
5	GAS POINT

[illegible]

REV	DESCRIPTION	DATE
A	ISSUE TO CLIENT FOR REVIEW	22/4/22
B	ISSUE FOR INFORMATION	22/5/05
C	ISSUE TO CONSULTANTS	22/5/10
D	ISSUE FOR INFORMATION	22/5/20
DA	ISSUE FOR DA	22/6/29
DA-A	REVISED ISSUE FOR COORDINATION - DA RFI AMENDMENTS	23/1/12
DA-B	REVISED SUBMISSION FOR DA	23/1/20
DA-D	REVISED DA SUBMISSION - RFI AMENDMENTS	23/7/27
DA-E	REVISED DA SUBMISSION - RFI AMENDMENTS	23/11/14
DA-F	ISSUE FOR COORDINATION	24/3/08
DA-G	ISSUE FOR S455	24/04/17
DA-H	ISSUE FOR S455 02	24/07/11

728 Fortis South Steyne
4-35 South Steyne Manly NSW

durbach block jagers

Level 2, 9 Roslyn Street
Potts Point NSW 2011
02 8297 3500
durbachblockjagers.com


Nominated Architects
Neil Durbach NSW Reg. No 5850
David Jagers NSW Reg. No 9999

ALE
00 @ A1 / 1:200 @ A3



2m 4m

A-DA-110-004

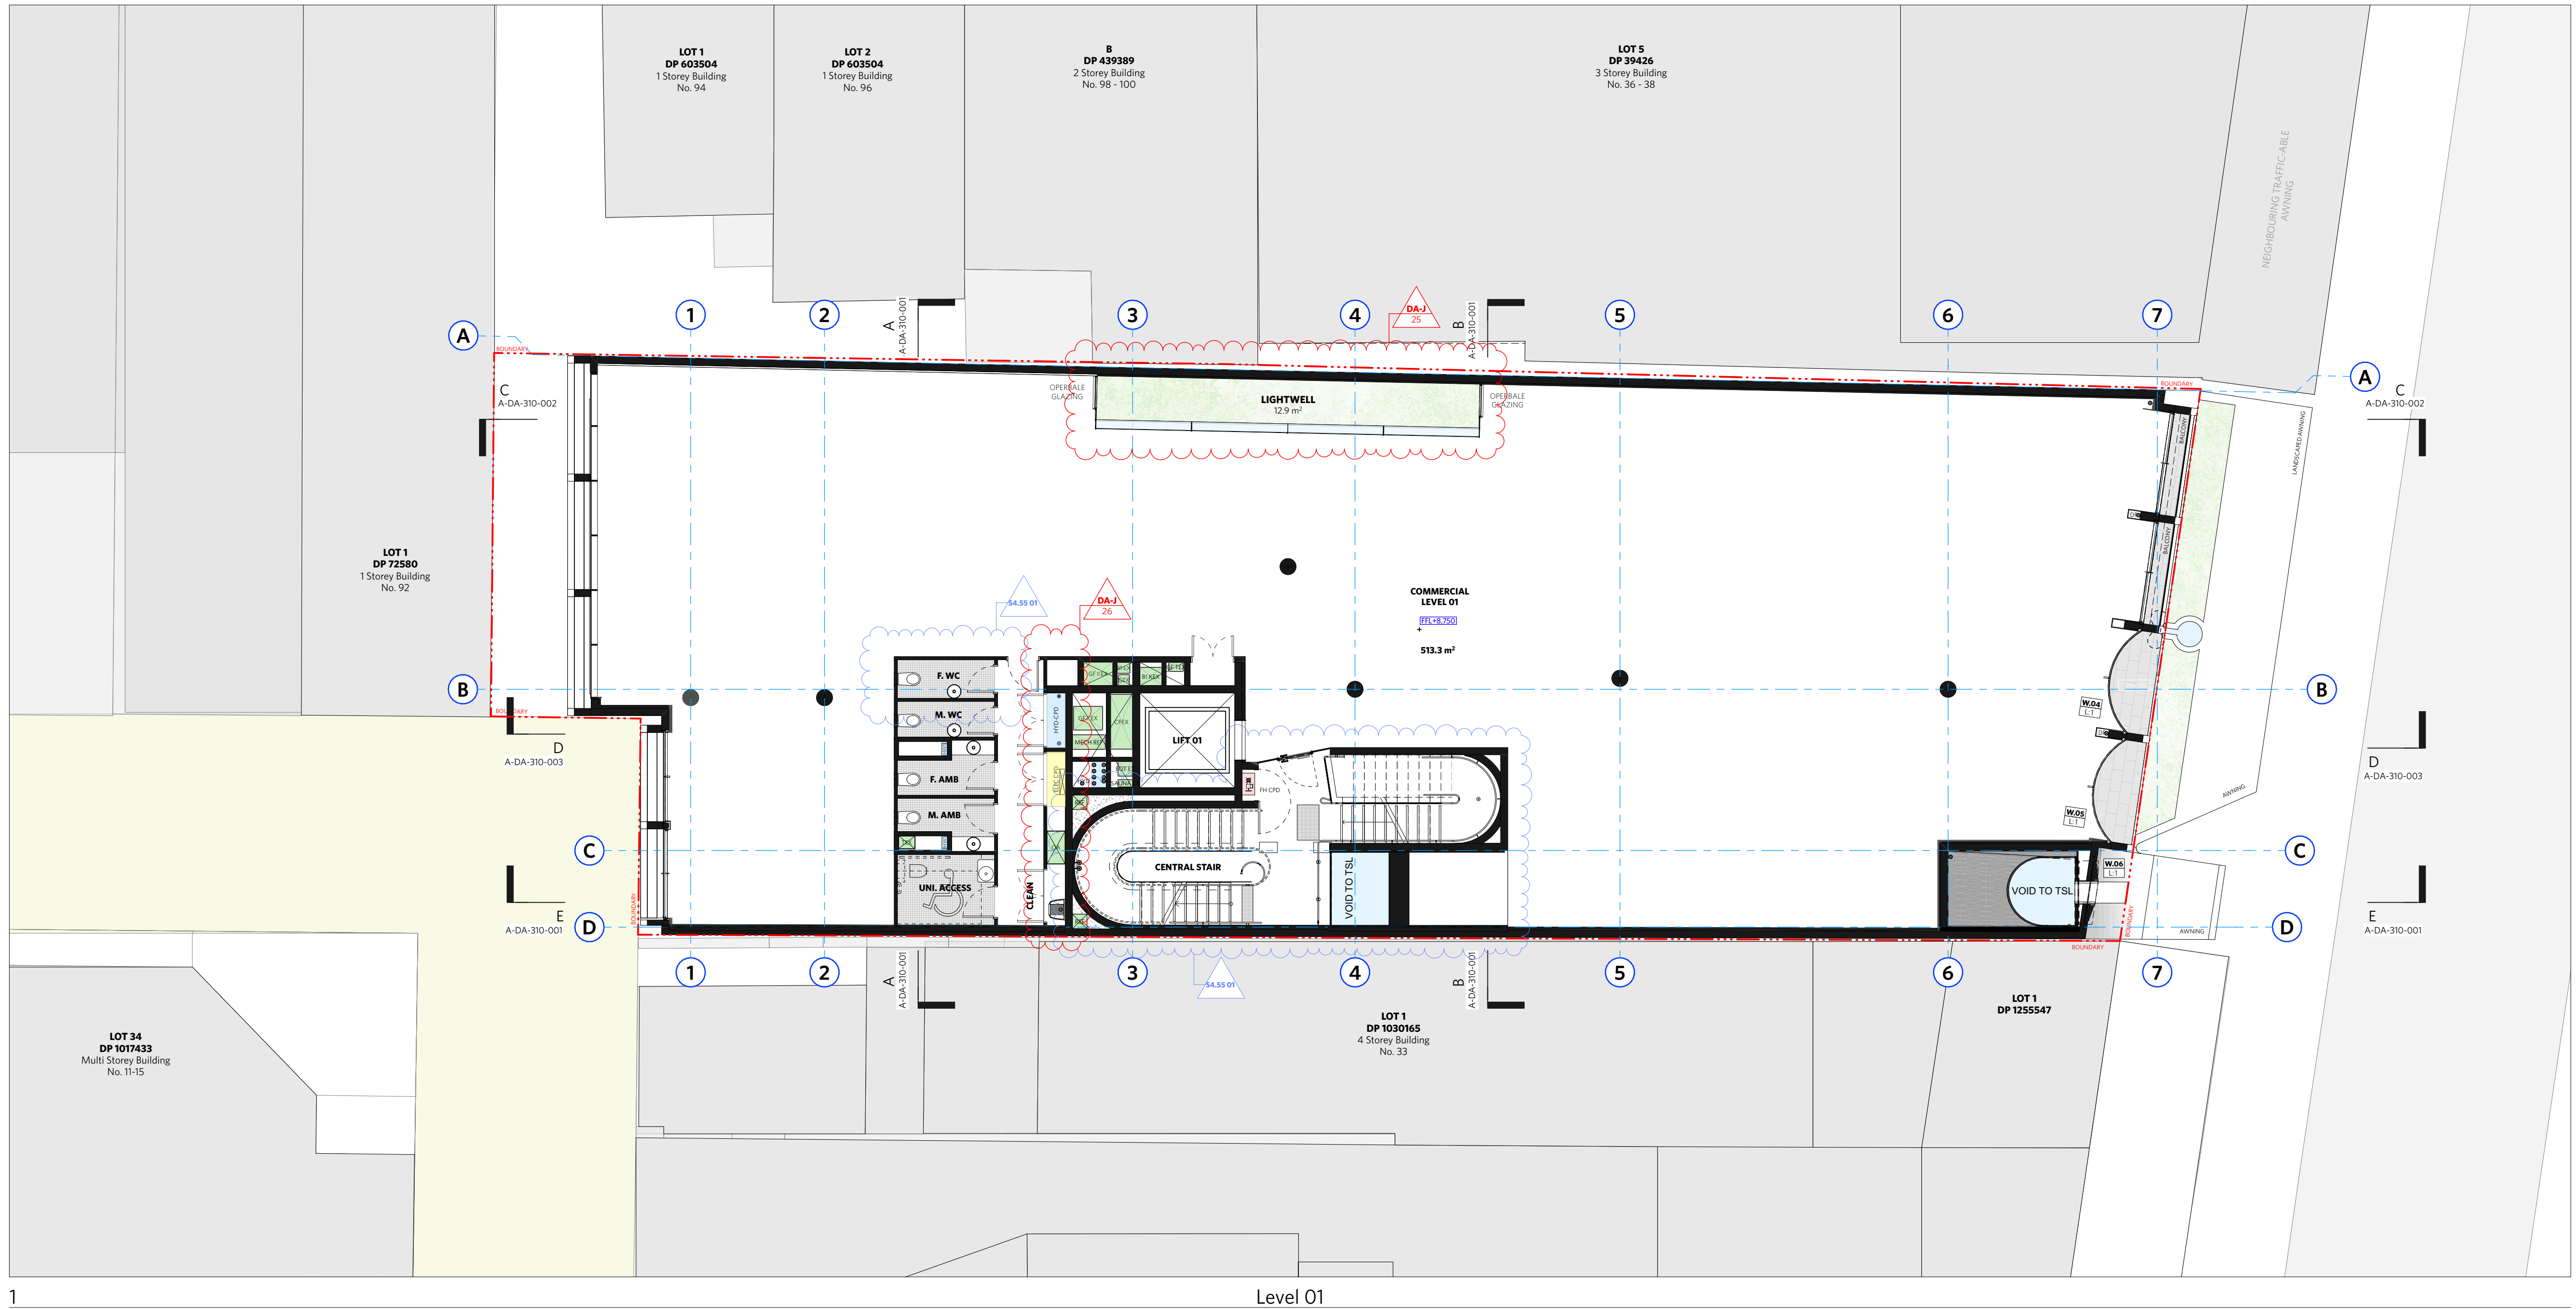



No part of this design to be altered or
 produced without written permission.
 Copyright Durbach Block Jaggers 2023.
 All rights reserved.

- H AIR CONDITIONING
- H ELECTRICAL SWITCHBOARD
- H FIRE HYDRANT
- HR FIRE HOSE REEL
- IP FIRE INDICATOR PANEL
- IP DOWNPIPE
- OF OVERFLOW
- D ROLLER DOOR
- RP DRAINAGE POINT
- G FIXED GLAZING
- O LOUVRES (OPERABLE)
- IA GATE
- W SLIDING WINDOW
- W OPENING WINDOW
- WF RENDERED FINISH
- MF MOSAIC TILED FINISH
- MR MECHANICAL/ELECTRICAL RISER
- MR FIRE HYDRAULIC RISER
- 7 FINISHED RL
- 7 STRUCTURAL RL
- H HOSETAP
- H GAS POINT

[illegible]

REV	DESCRIPTION	DATE
A	ISSUE TO CLIENT FOR REVIEW	22/4/22
B	ISSUE FOR INFORMATION	22/5/05
C	ISSUE TO CONSULTANTS	22/5/10
D	ISSUE FOR INFORMATION	22/5/20
DA	ISSUE FOR DA	22/6/29
DA-A	REVISED ISSUE FOR COORDINATION - DA RFI AMENDMENTS	23/1/12
DA-B	REVISED SUBMISSION FOR DA	23/1/20
DA-D	REVISED DA SUBMISSION - RFI AMENDMENTS	23/7/27
DA-E	REVISED DA SUBMISSION - RFI AMENDMENTS	23/1/14
DA-F	ISSUE FOR COORDINATION	24/3/08
DA-G	ISSUE FOR S455	24/07/17
DA-I	ISSUE FOR S455 02	24/04/21

4-35 South Steyne Manly NSW

durbach block jagers

Level 2, 9 Roslyn Street
Potts Point NSW 2011
02 8297 3500
durbachblockjagers.com

Nominated Architects
Neil Durbach NSW Reg. No 5850
David Jagers NSW Reg. No 9999


ALE
00 @ A1 / 1:200 @ A3

2m 4m

The drawing shows a cross-section of a road with a 2m wide central section and a 4m wide side section. To the right, a circular plan view shows a road layout with a central section and a side section, with a north arrow pointing towards the top right.

OBJECT NO.	ISSUE	REV.
1728	DA	DA-J

DRAWING NO.
A-DA-110-005

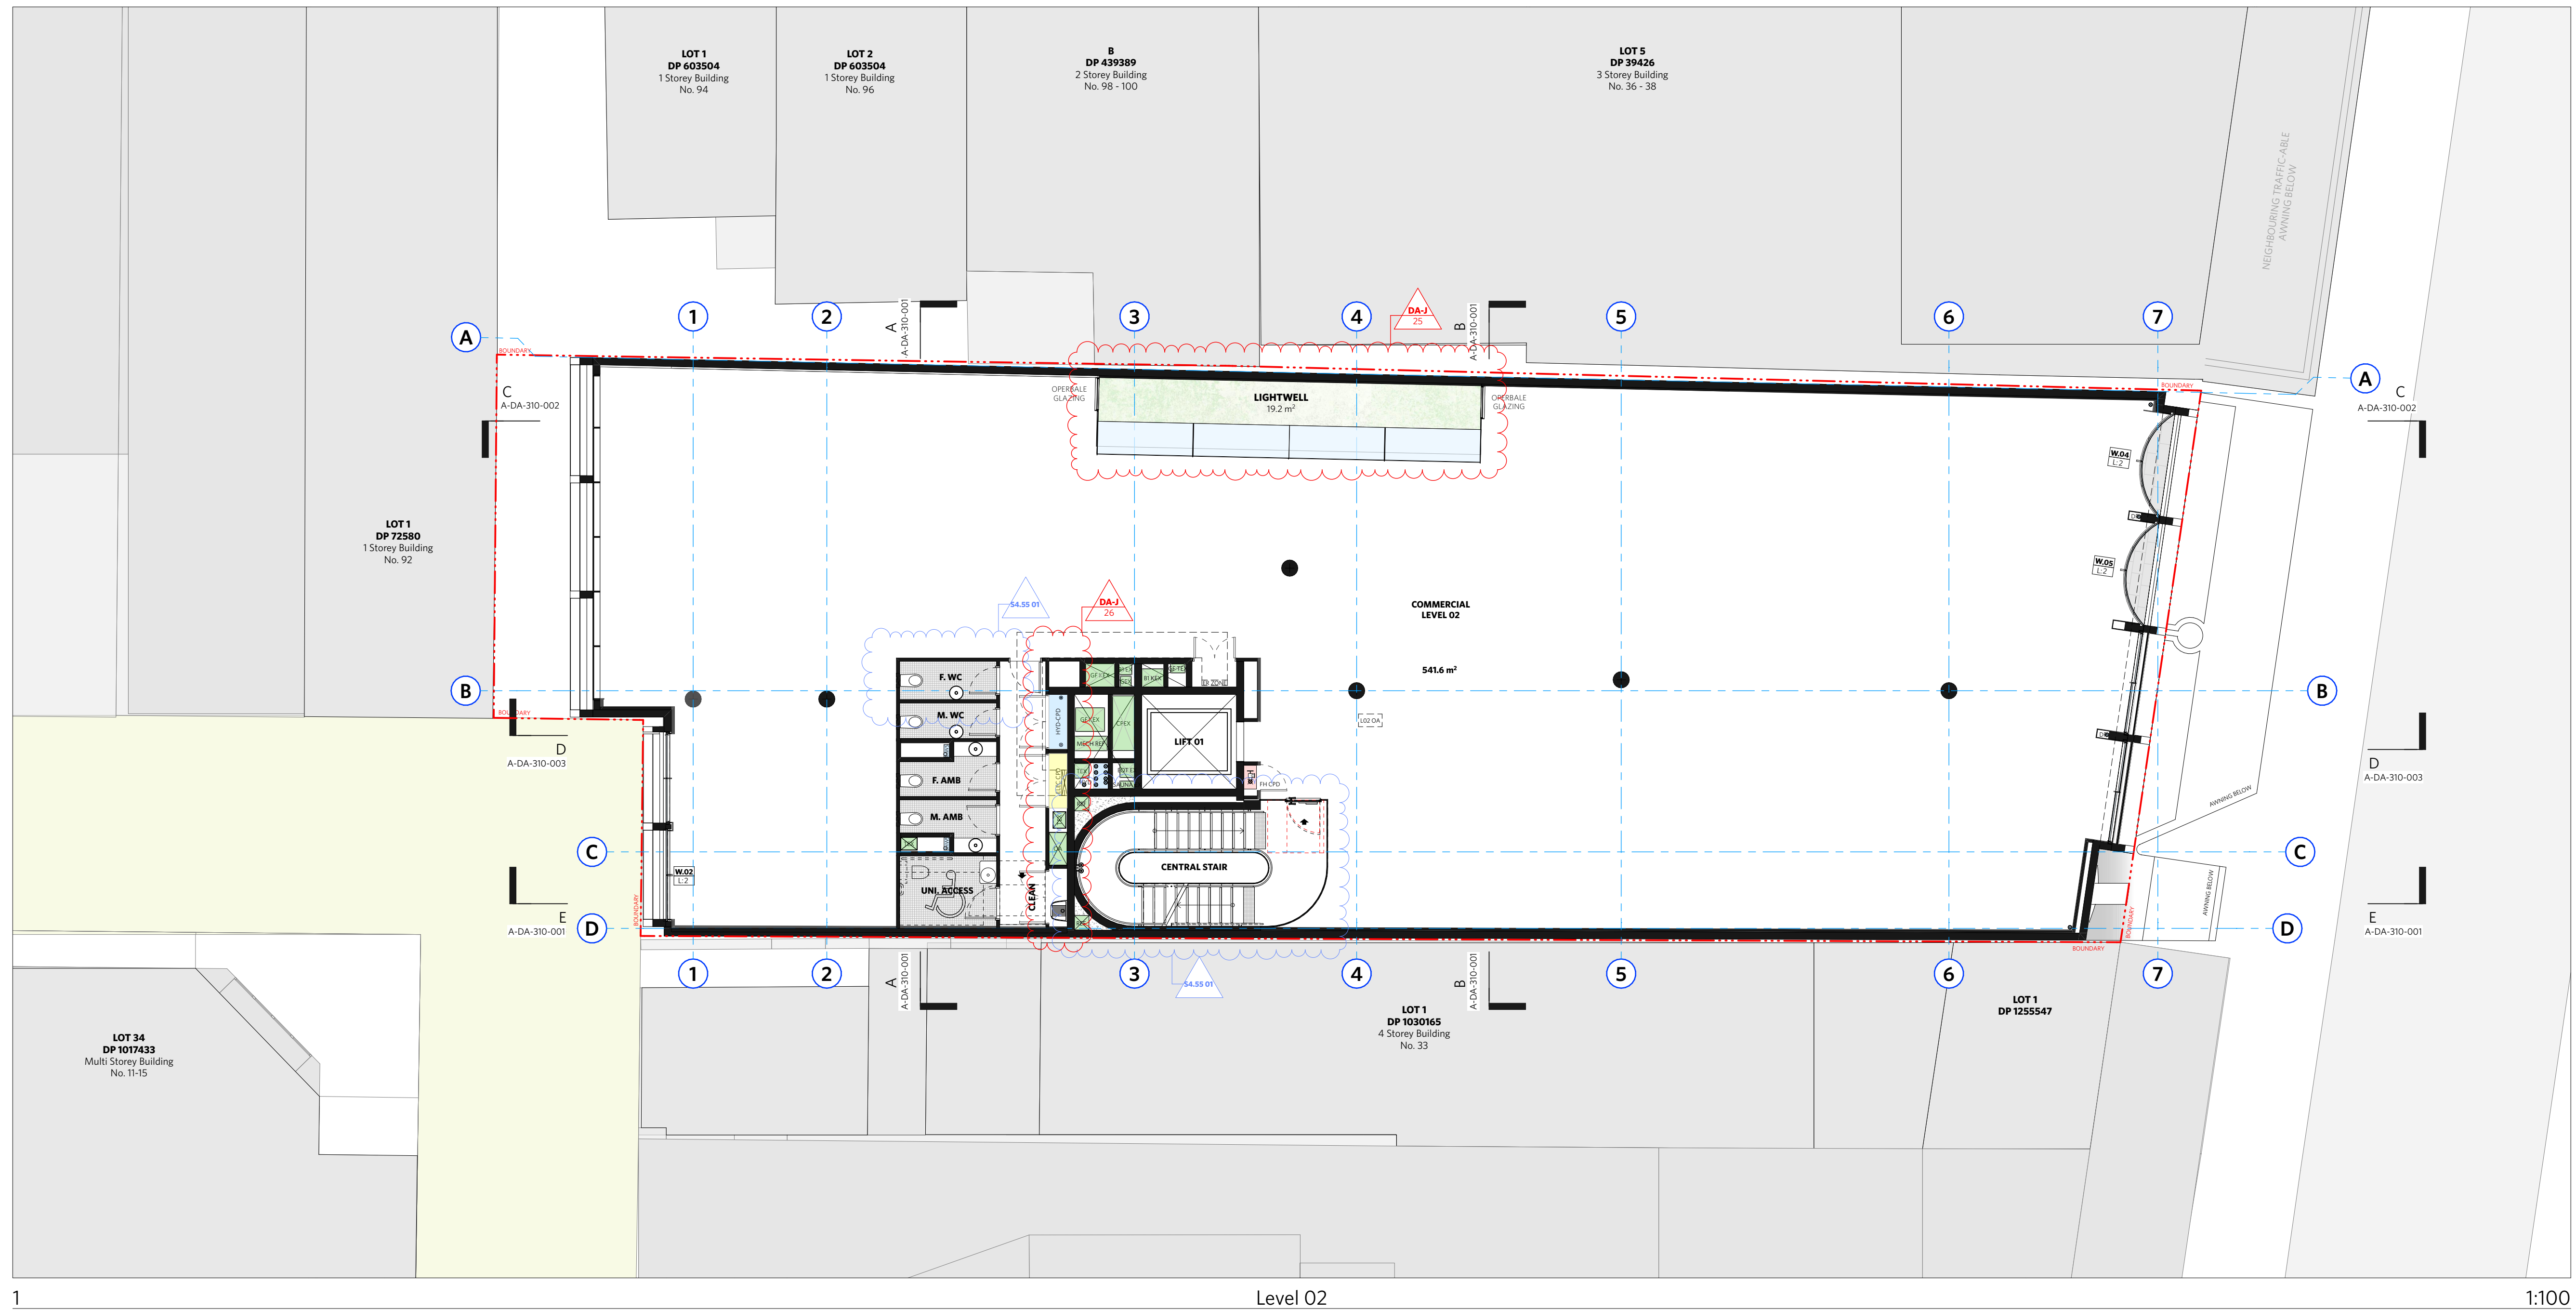

CHANGES AS SUBMITTED IN S4.55 - UNDER REVIEW - MOD/2024/0225

CHANGES RELEVANT TO THIS MODIFICATION APPLICATION


CHANGES REVIEWED AND APPROVED UNDER DA/2022/1164 - CONDITION 28

DO NOT SCALE OFF DRAWINGS

No part of this design to be altered or reproduced without written permission.
© Copyright Durbach Block Jaggers 2023.
All rights reserved.

LEGEND

AC AIR CONDITIONING
E ELECTRICAL SWITCHBOARD
FH FIRE HYDRANT
FHR FIRE HOSE REEL
FIP FIRE INDICATOR PANEL
DP DOWNPIPE
OF OVERFLOW
RD ROLLER DOOR
DRP DRAINAGE POINT
FG FIXED GLAZING
LO LOUVRES (OPERABLE)
GA GATE
SW SLIDING WINDOW
OW OPENABLE WINDOW
RF RENDERED FINISH
MF MOSAIC TILED FINISH
MR MECHANICAL/ELECTRICAL RISER
HR HYDRAULIC RISER
▽ FINISHED RL
H STRUCTURAL RL
G HOSETAP
G GAS POINT

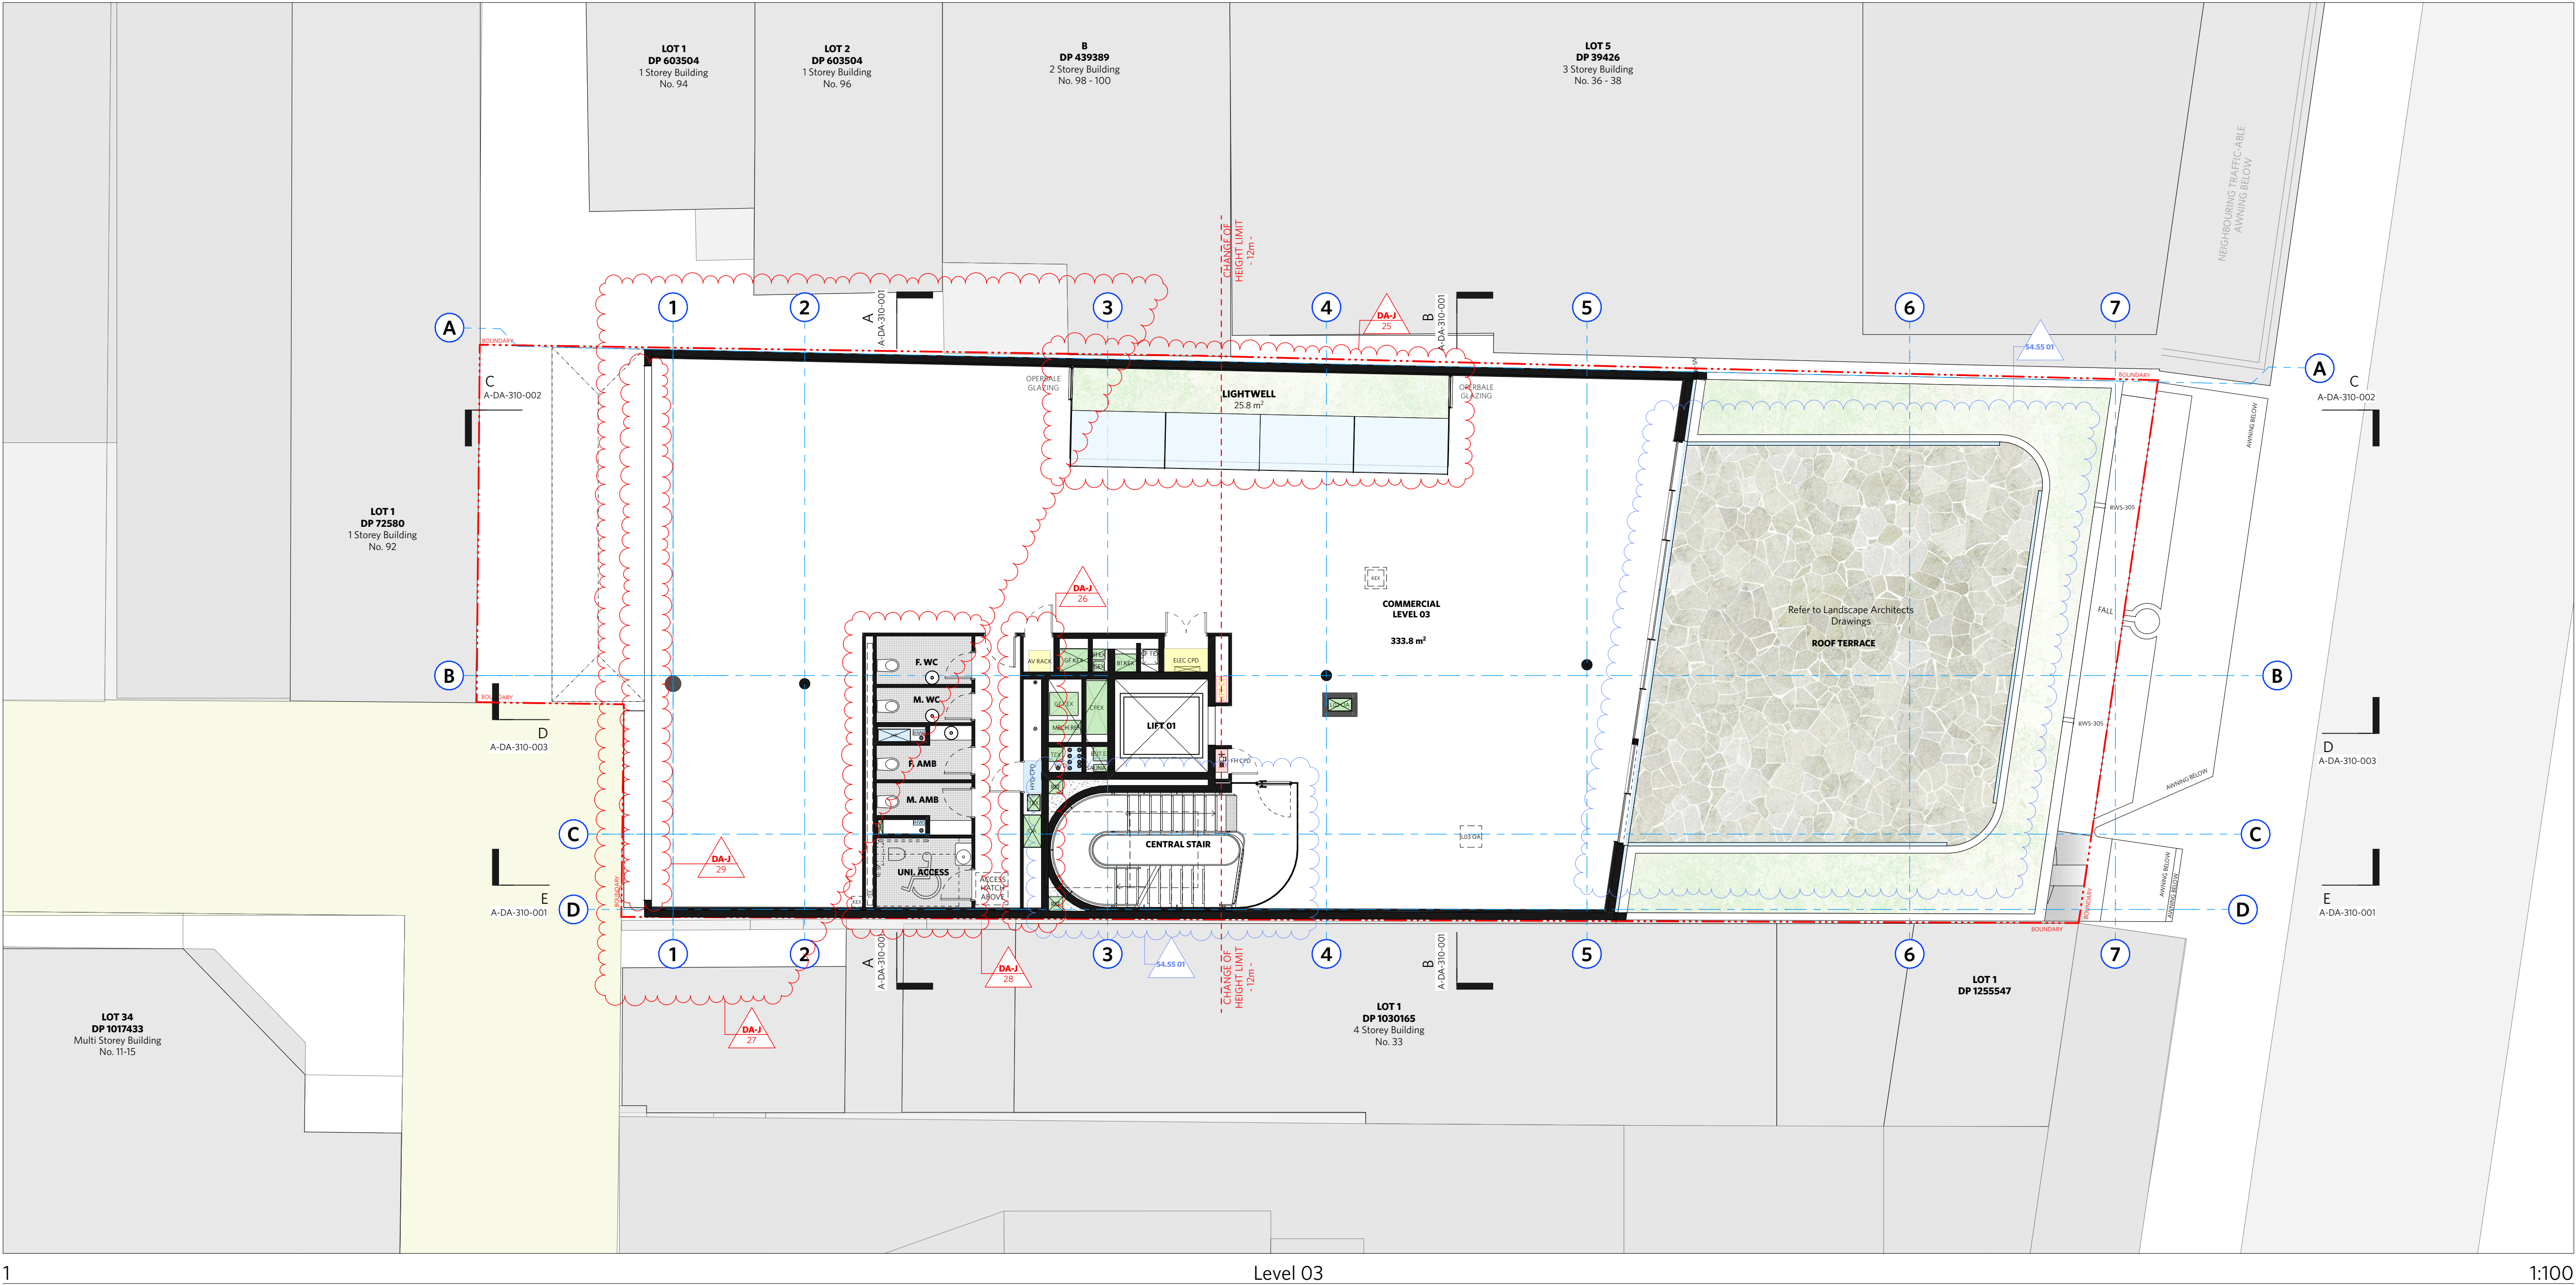

CHANGE SUMMARY		
REV	CHANGE	DESCRIPTION
25		Changes to the Central Courtyard
26		Minor Modifications to Core Layout
27	DA-J	Increase in Floor Space to the west
28		Changes to the Amenities to suit revised floor plate
29		Changes to window openings to the west to suit new form

ISSUE STATUS		
REV	DESCRIPTION	DATE
A	ISSUE TO CLIENT FOR REVIEW	22/4/22
B	ISSUE FOR INFORMATION	22/5/05
C	ISSUE TO CONSULTANTS	22/5/10
D	ISSUE FOR INFORMATION	22/5/20
DA	ISSUE FOR DA	22/6/29
DA-A	REVISED ISSUE FOR COORDINATION - DA RFI AMENDMENTS	23/1/12
DA-B	REVISED SUBMISSION FOR DA	23/1/20
DA-D	REVISED DA SUBMISSION - RFI AMENDMENTS	23/7/27
DA-E	REVISED DA SUBMISSION - RFI AMENDMENTS	23/11/14
DA-F	ISSUE FOR COORDINATION	24/3/08
DA-G	ISSUE FOR S455	24/04/17
DA-J	ISSUE FOR S455 02	24/07/11

CLIENTFortis Development Group

JOB1728 Fortis South Steyne
34-35 South Steyne Manly NSW

ARCHITECT

durbach block jaggers

Level 2, 9 Roslyn Street
Porto Point NSW 2011
02 8297 3500
durbachblockjaggers.com

Nominated Architects
Neil Durbach NSW Reg. No 5850
David Jaggers NSW Reg. No 9999

DRAWN	CHECKED	DATE DRAWN	PRINTED
		24/07/01	18/7/2024 11:48 am
SCALE			
1:100 @ A1 / 1:200 @ A3			
TITLE			
GA Plans Level 3 Plan			
PROJECT NO.			
1728			
ISSUE			
DA			
REV			
DA-J			
DRAWING NO.			
A-DA-110-006			



no part of this design to be altered or
produced without written permission.
Copyright Durbach Block Jagers 2023.
All rights reserved.

H	AIR CONDITIONING
C	ELECTRICAL SWITCHBOARD
H	FIRE HYDRANT
H	FIRE HOSE REEL
IP	FIRE INDICATOR PANEL
IP	DOWNPIPE
D	OVERFLOW
D	ROLLER DOOR
RP	DRAINAGE POINT
G	FIXED GLAZING
O	LOUVRES (OPERABLE)
A	GATE
W	SLIDING WINDOW
W	OPENABLE WINDOW
WF	FINISHED FINISH
MR	MOSAIC TILED FINISH
MR	MECHANICAL/ELECTRICAL RISER
7	HYDRAULIC RISER
7	FINISHED RL
4	STRUCTURAL RL
4	HOSETAP
5	GAS POINT

[illegible]


REV	DESCRIPTION	DATE
A	ISSUE TO CLIENT FOR REVIEW	22/4/22
B	ISSUE FOR INFORMATION	22/5/05
C	ISSUE TO CONSULTANTS	22/5/10
D	ISSUE FOR INFORMATION	22/5/20
DA	ISSUE FOR DA	22/6/29
DA-A	REVISED ISSUE FOR COORDINATION - DA RFI AMENDMENTS	23/6/12
DA-B	REVISED SUBMISSION FOR DA	23/1/20
DA-D	REVISED DA SUBMISSION - RFI AMENDMENTS	23/7/27
DA-E	REVISED DA SUBMISSION - RFI AMENDMENTS	23/11/14
DA-F	ISSUE FOR COORDINATION	24/3/08
DA-G	ISSUE FOR S455	24/04/17
DA-H	ISSUE FOR S455 - COUNCIL RFI	24/07/05
DA-J	ISSUE FOR S455 02	24/07/21


4-35 South Steyne Manly NSW

Nominated Architects
Neil Durbach NSW Reg. No 5850
David Jagers NSW Reg. No 9999

DRAWING NO. **A DA 110 007**

A-DA-110-007

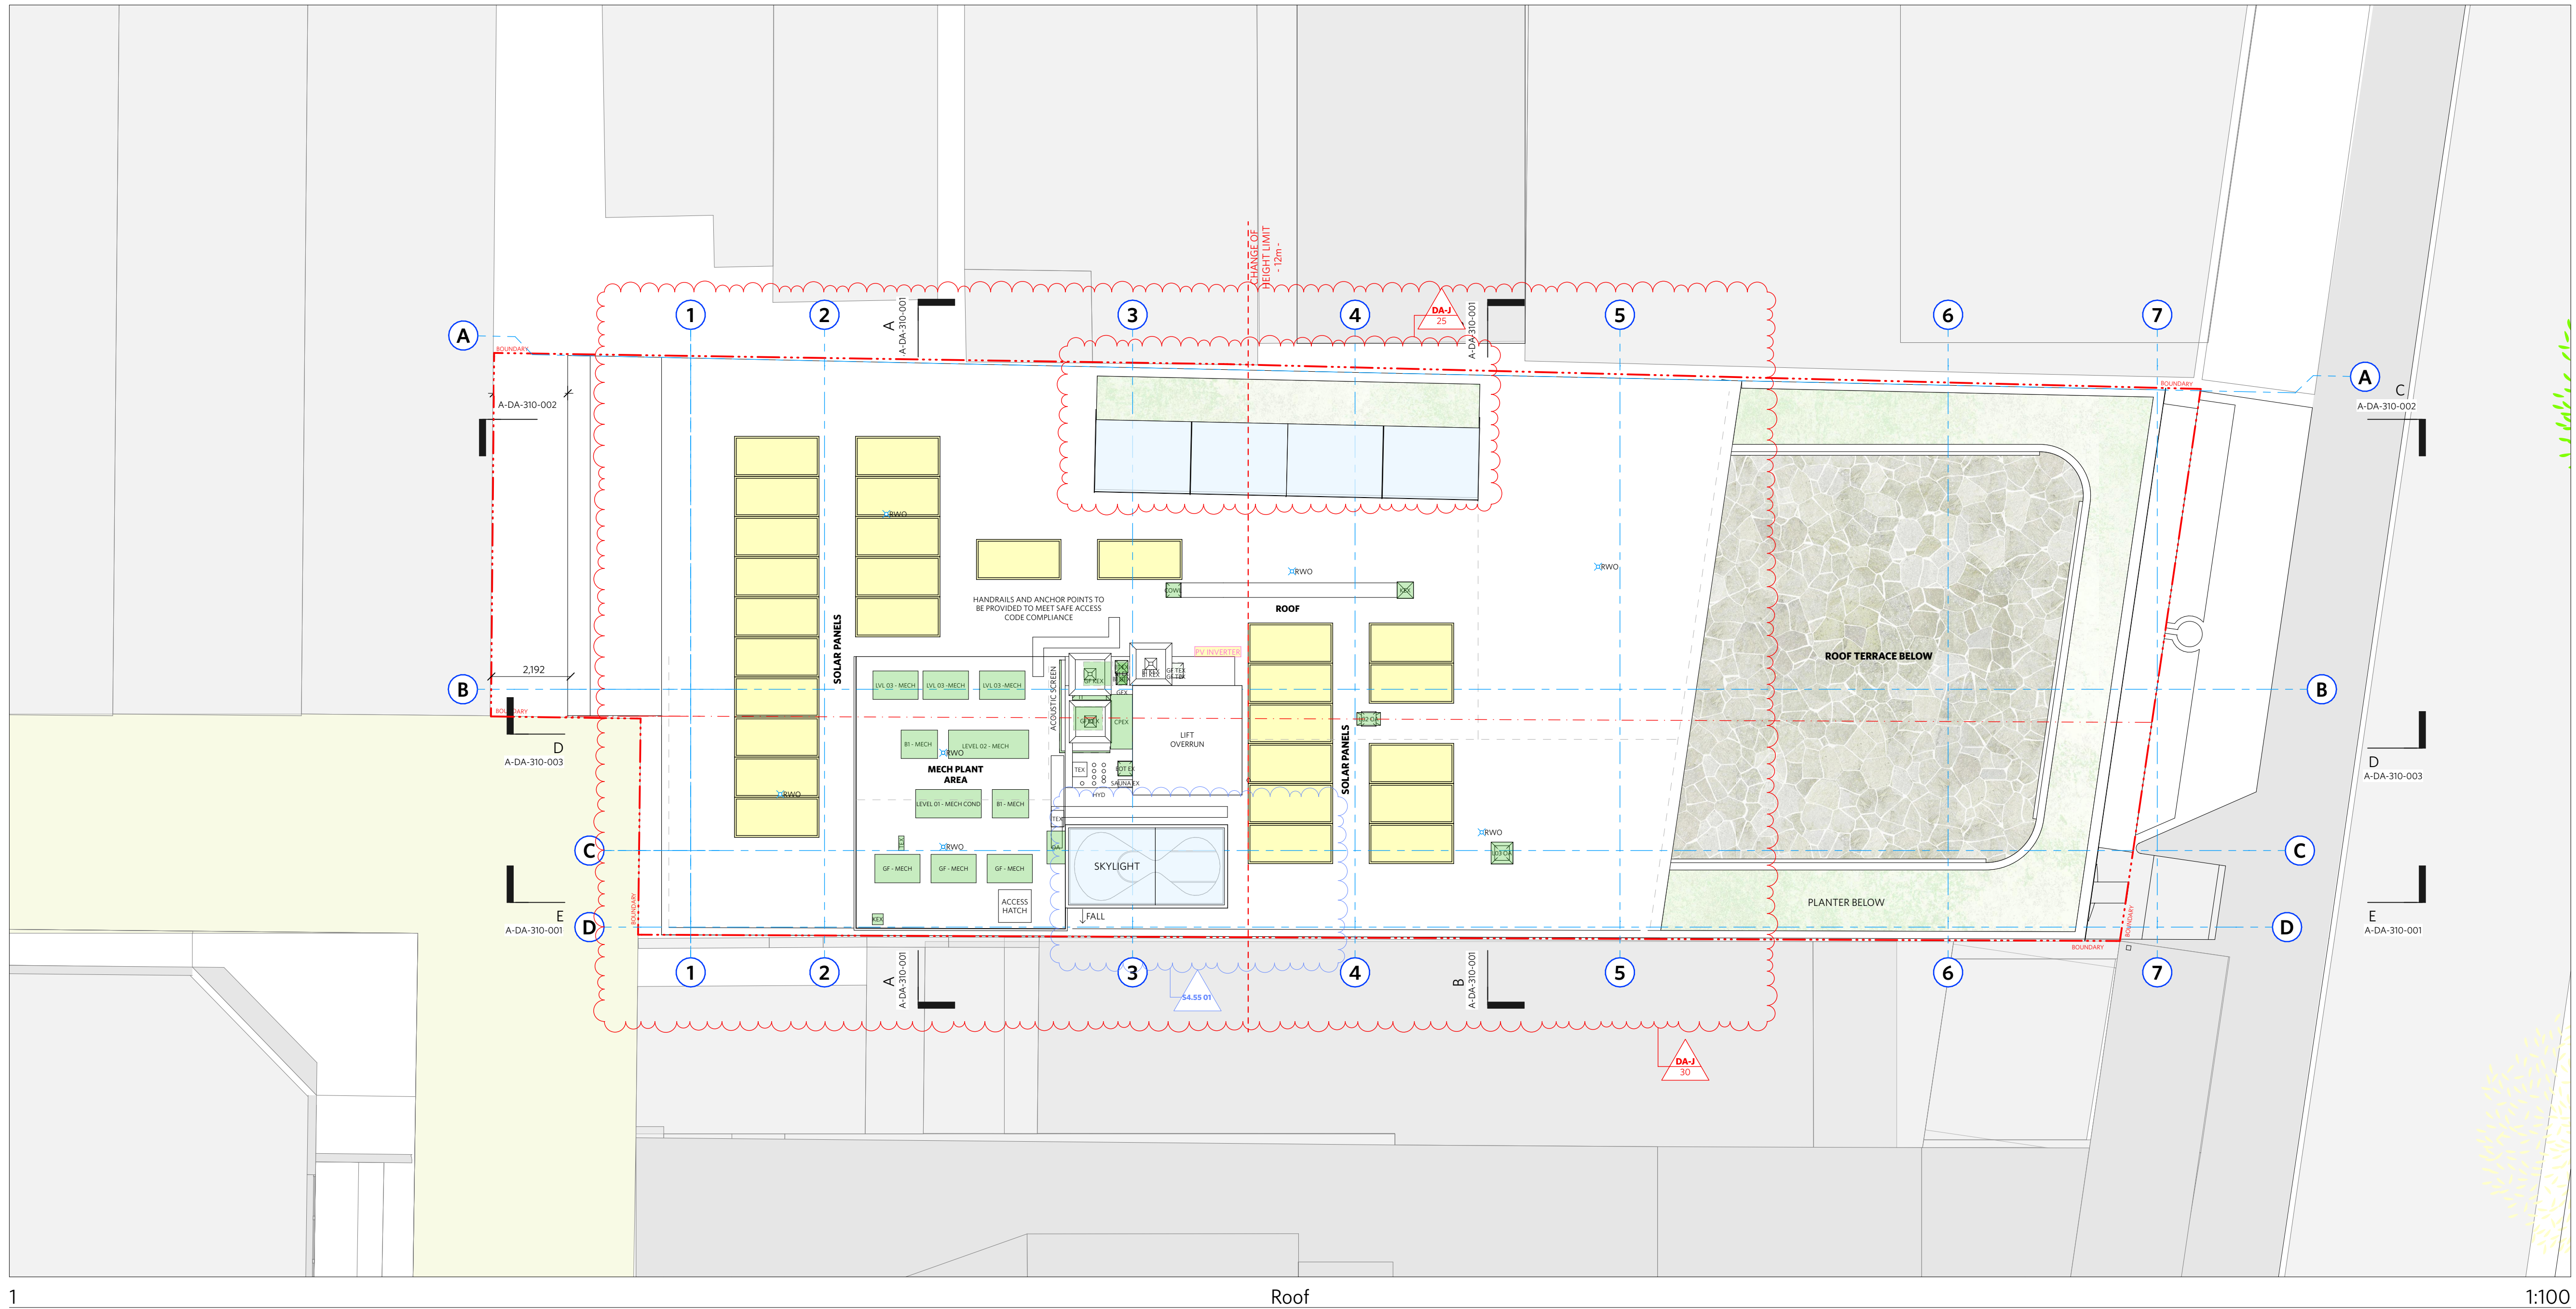

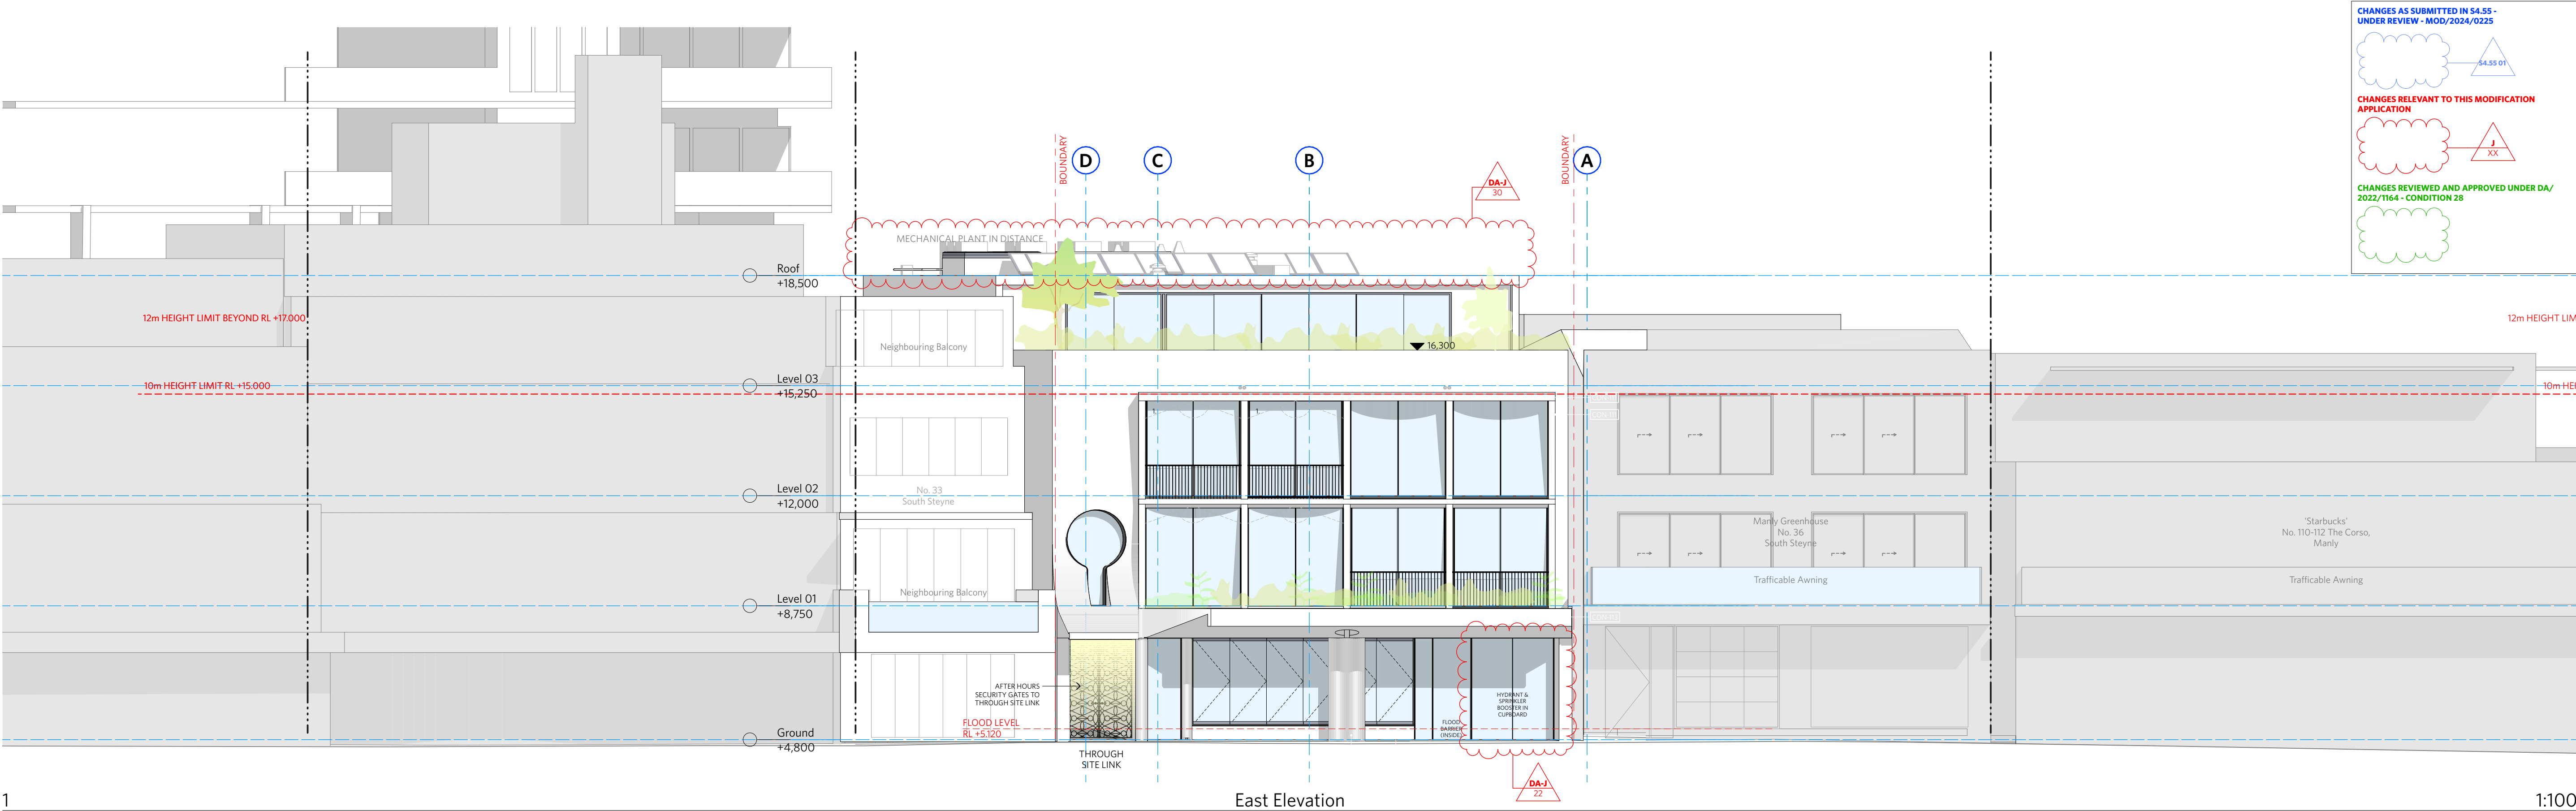

1

NOTES

DO NOT SCALE OFF DRAWINGS

No part of this design to be altered or reproduced without written permission.
© Copyright Durbach Block Jaggers 2023.
All rights reserved.

LEGEND


AC AIR CONDITIONING
E ELECTRICAL SWITCHBOARD
FH FIRE HYDRANT
FHR FIRE HOSE REEL
FIP FIRE INDICATOR PANEL
DP DOWNPIPE
OF OVERFLOW
RD ROLLER DOOR
DRP DRAINAGE POINT
FG FIXED GLAZING
LO LOUVRES (OPERABLE)
GA GATE
SW SLIDING WINDOW
OW OPENABLE WINDOW
RF RENDERED FINISH
MF MOSAIC TILED FINISH
MR MECHANICAL/ELECTRICAL RISER
HR HYDRAULIC RISER
▽ FINISHED RL
▽ STRUCTURAL RL
H HOSETAP
G GAS POINT

NOTES:

1. FACADE WASHING SYSTEM LOCATED IN THE SOFFIT OF EACH OF THE 8 GLAZED EASTERN FACADE WINDOW BAYS ON LEVEL 1 & 2.

CHANGE SUMMARY

REV	CHANGE	DESCRIPTION
21		Additional openings added into Ground floor Tenancy
22		Relocation of Sprinkler Booster to South Steyne
29		Changes to window openings to the west to suit new form
30		Revised Roof Layout to suit new form, including Revised Mechanical, Solar & other Equipment

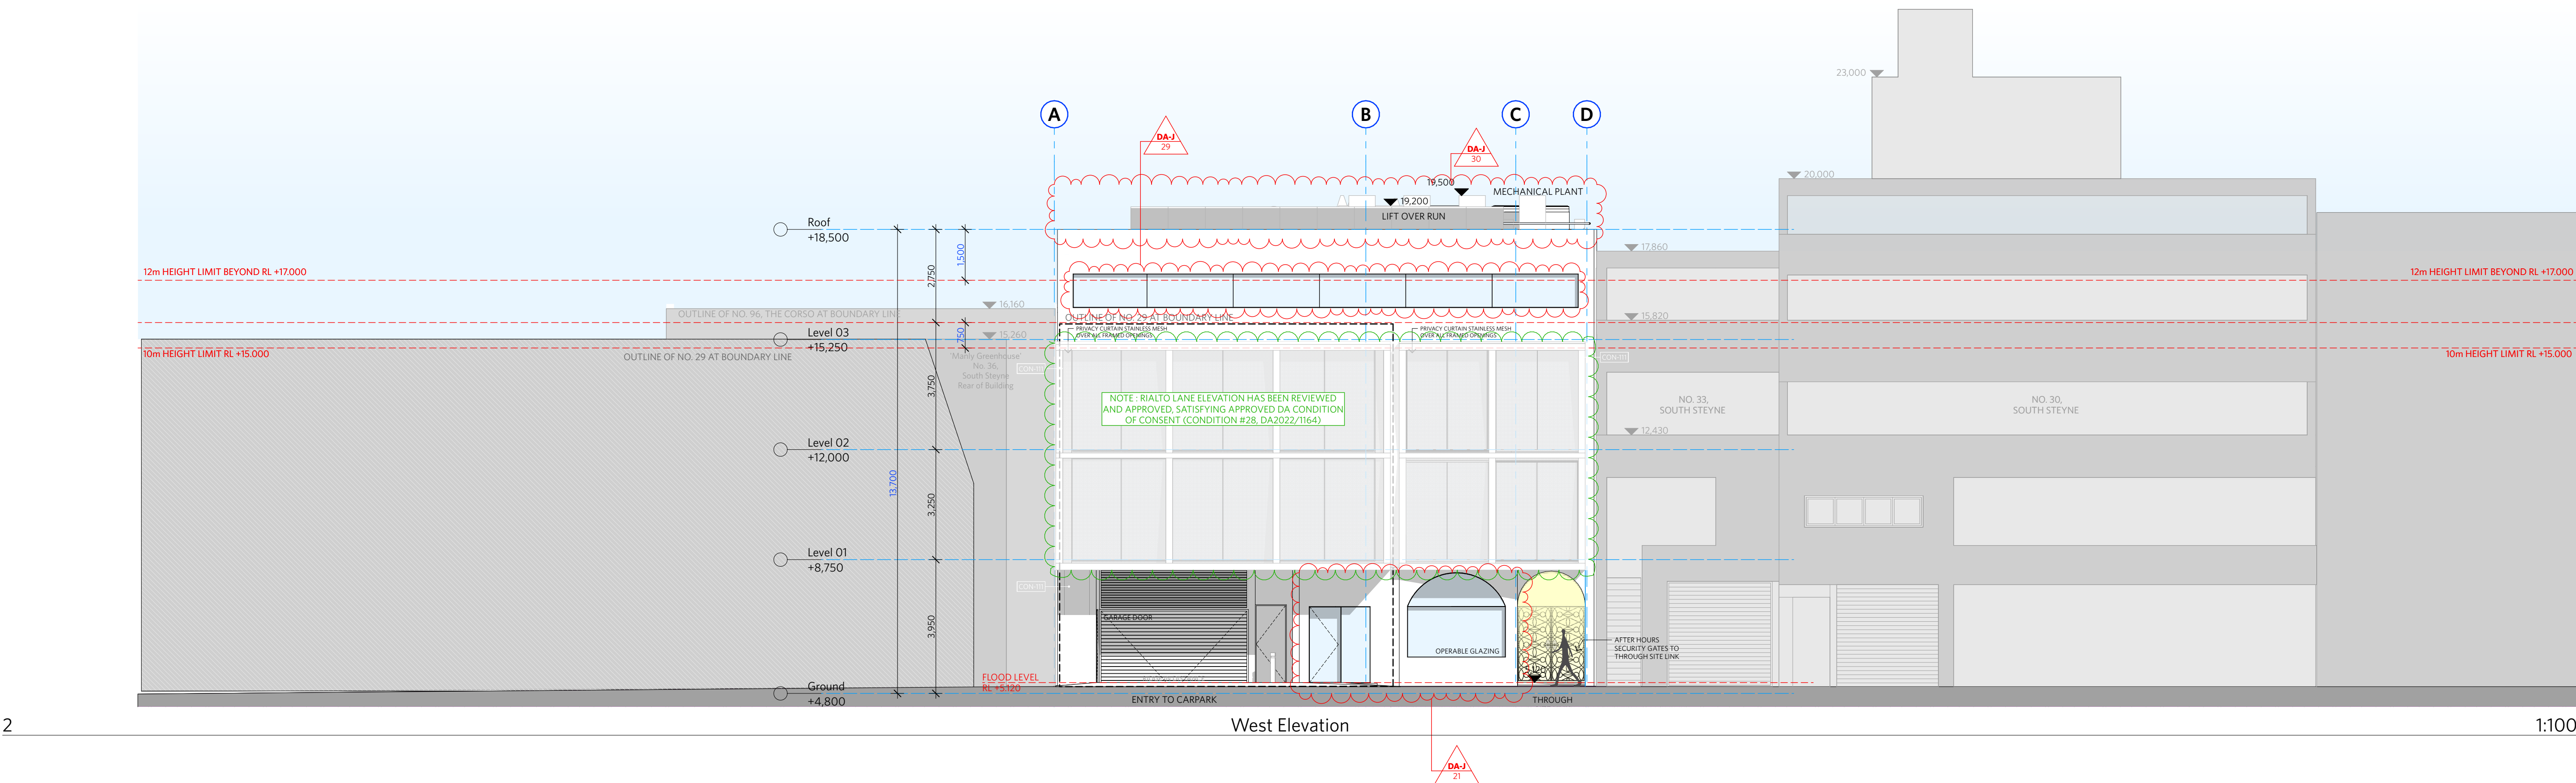

2

ISSUE STATUS

REV	DESCRIPTION	DATE
A	ISSUE TO CLIENT FOR REVIEW	22/4/22
B	ISSUE FOR INFORMATION	22/5/05
C	ISSUE TO CONSULTANTS	22/5/10
D	ISSUE FOR INFORMATION	22/5/20
DA	ISSUE FOR DA	22/6/29
DA-A	REVISED ISSUE FOR COORDINATION - DA RFI AMENDMENTS	23/1/12
DA-B	REVISED SUBMISSION FOR DA	23/1/20
DA-D	REVISED DA SUBMISSION - RFI AMENDMENTS	23/7/27
DA-E	REVISED DA SUBMISSION - RFI AMENDMENTS	23/11/14
DA-F	ISSUE FOR COORDINATION	24/3/08
DA-G	ISSUE FOR S455	24/04/17
DA-H	ISSUE FOR S455 - COUNCIL RFI	24/07/05
DA-J	ISSUE FOR S455 02	24/07/11

CLIENT

Fortis Development Group

JOB

1728 Fortis South Steyne
34-35 South Steyne Manly NSW

ARCHITECT

durbach block jaggers

Level 2, 9 Roslyn Street
Potts Point NSW 2011
02 8297 3500
durbachblockjaggers.com

Nominated Architects
Neil Durbach NSW Reg. No 5850
David Jaggers NSW Reg. No 9999

DRAWN

CHECKED

DATE DRAWN

PRINTED

[m]

24/07/01

SCALE

1:100 @ A1 / 1:200 @ A3

2m 4m

TITLE

GA Elevation
East & West Elevation

PROJECT NO.

1728

ISSUE


DA

REV


DA-J

DRAWING NO.


A-DA-210-002

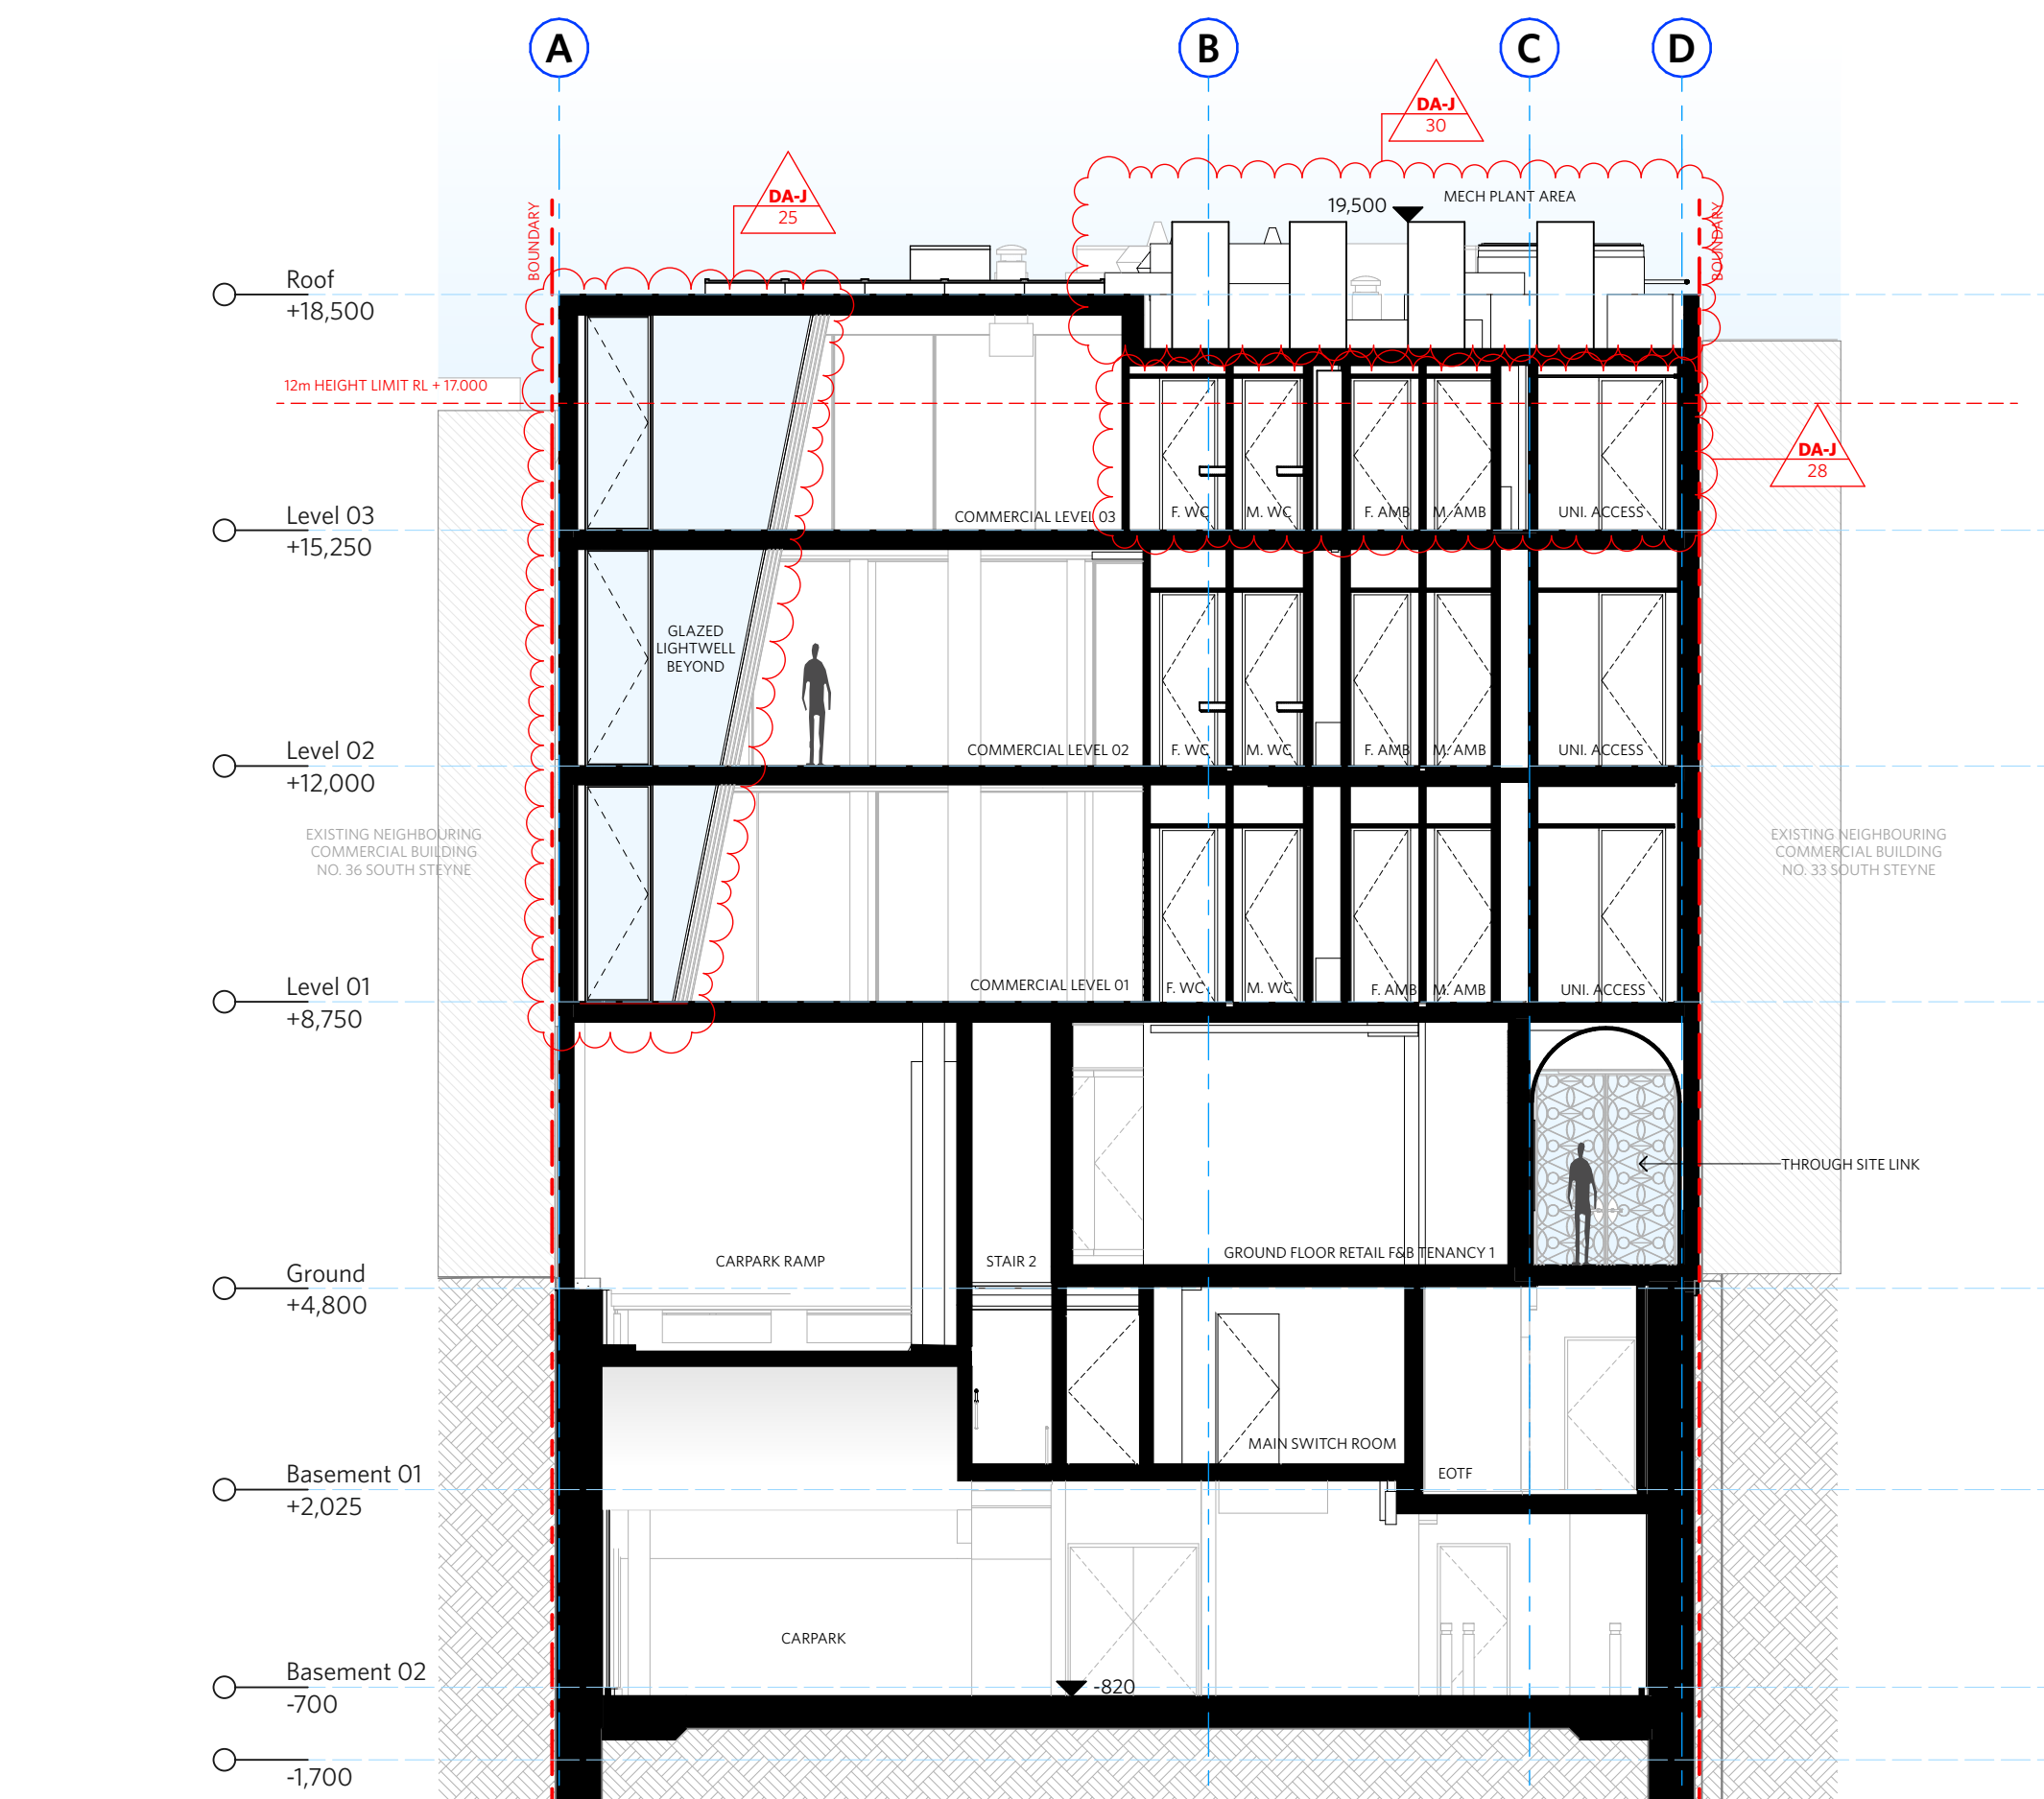

1 Section A 1:100

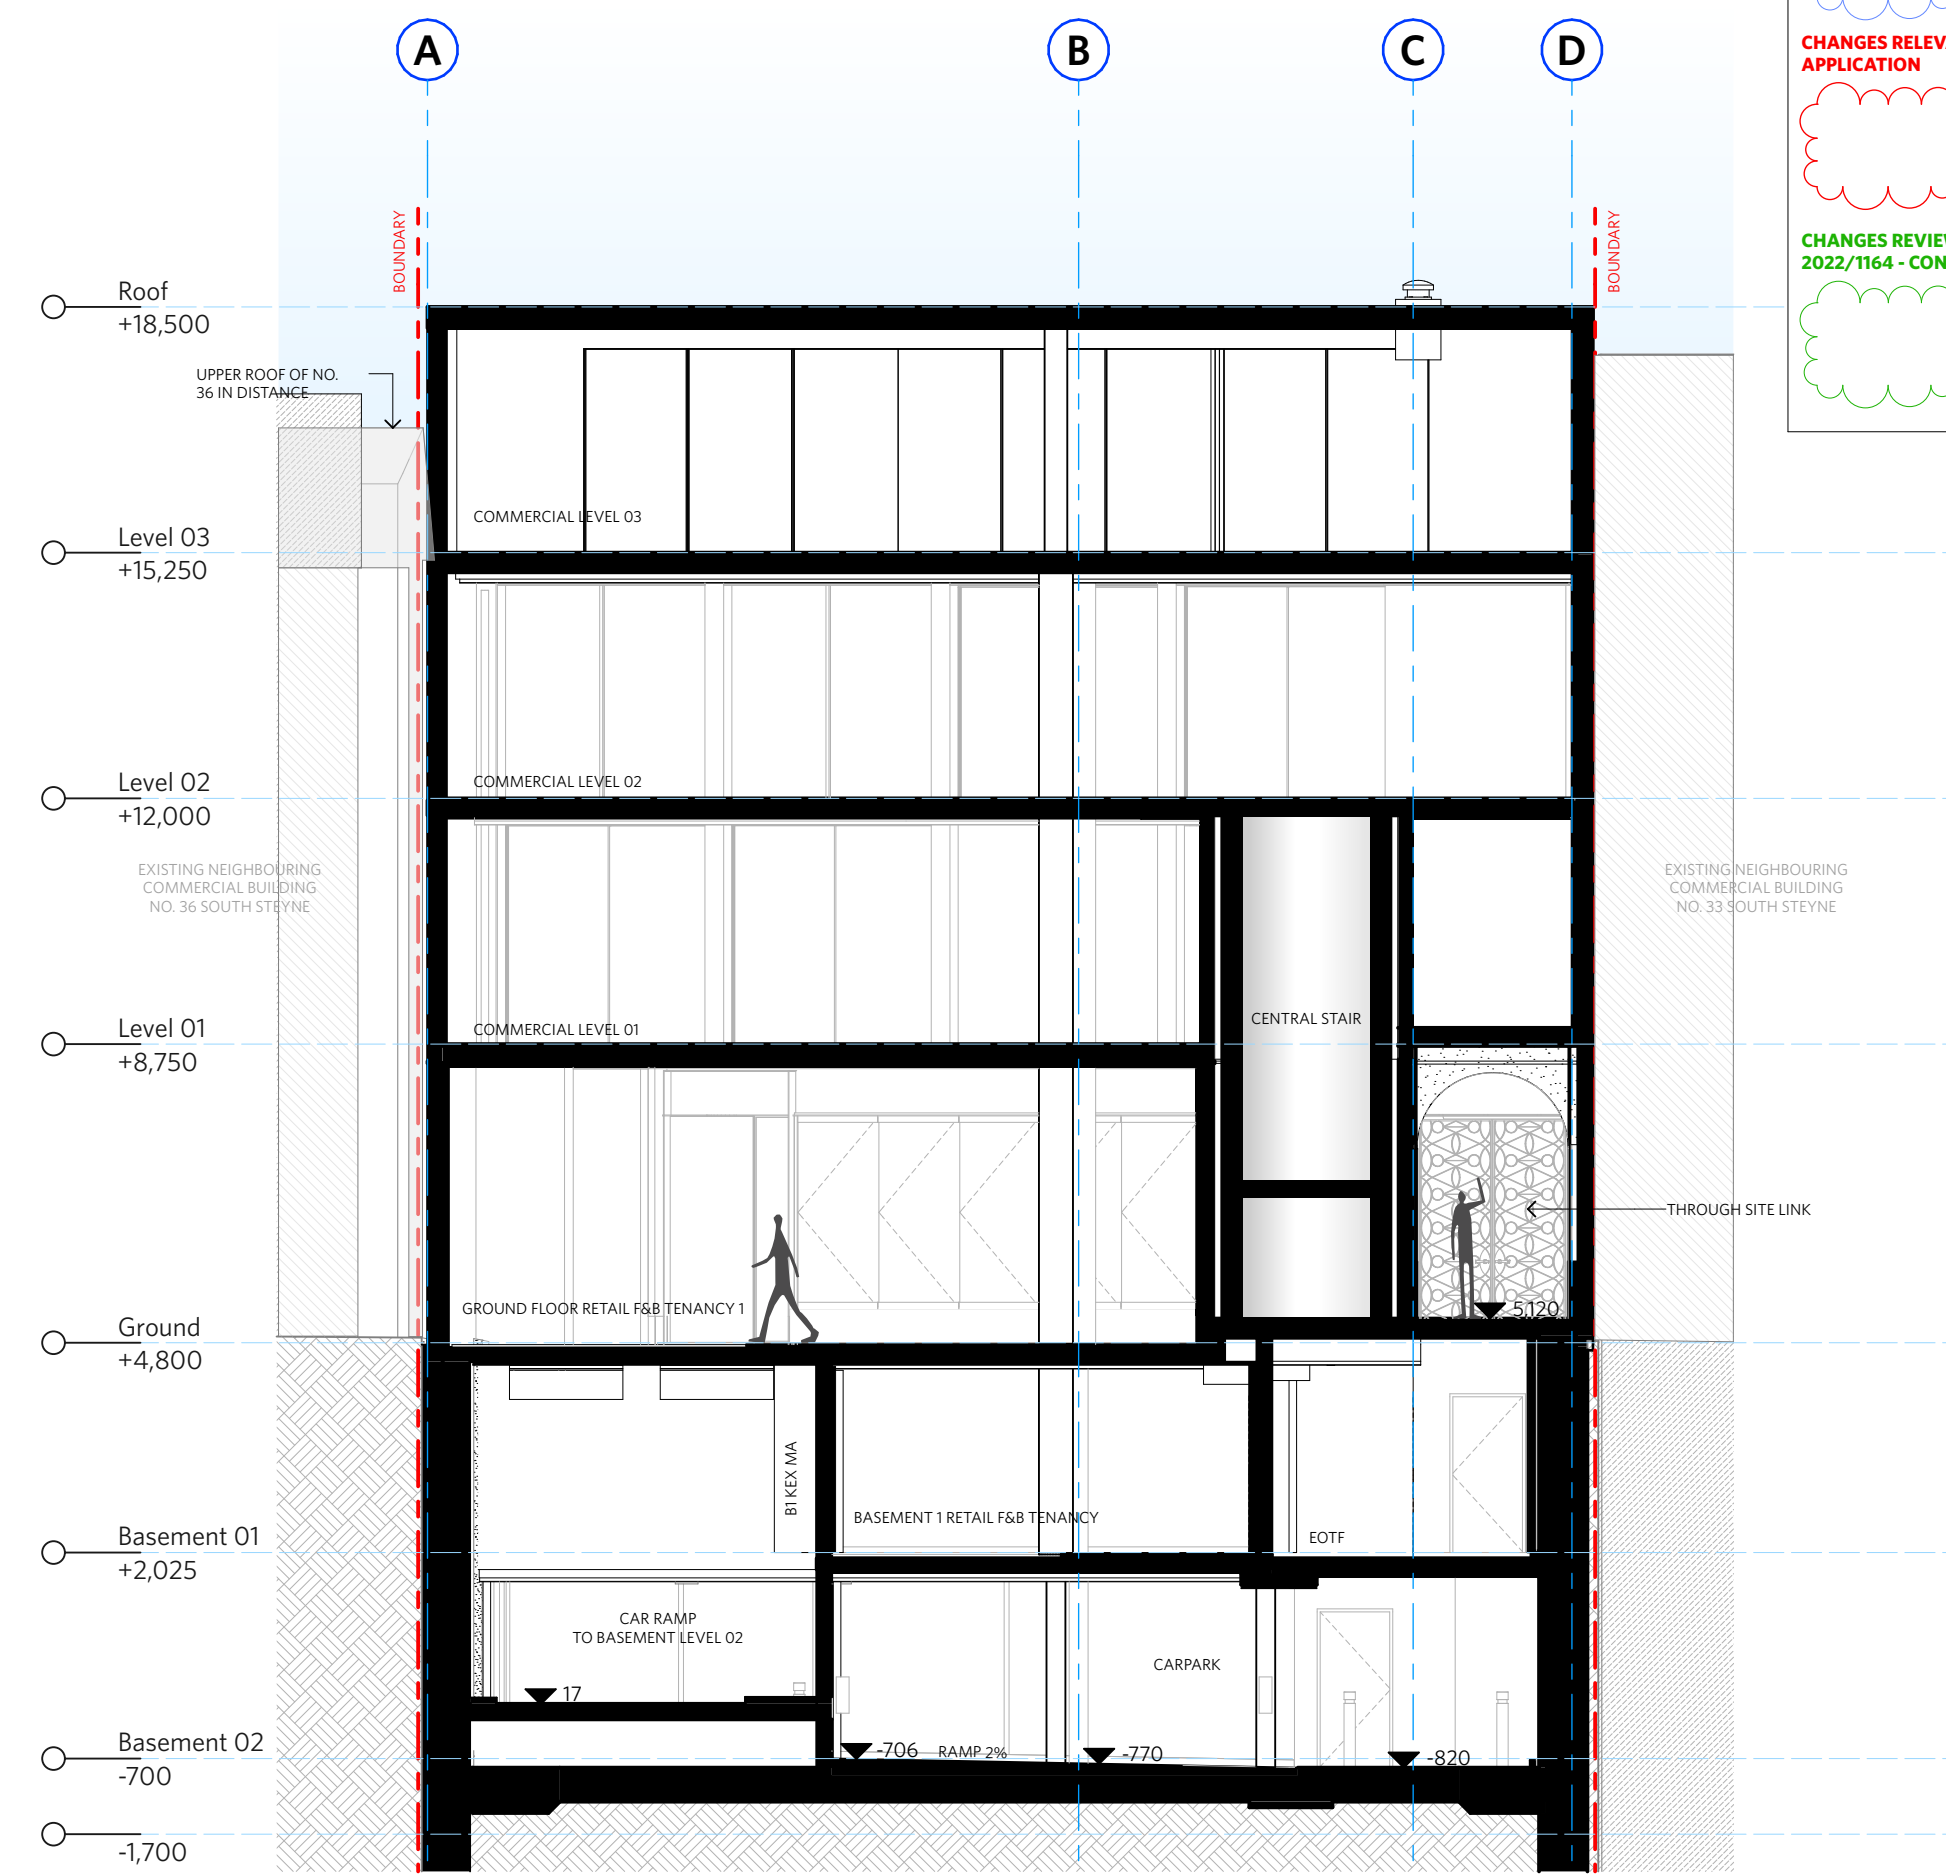

2 Section B 1:100

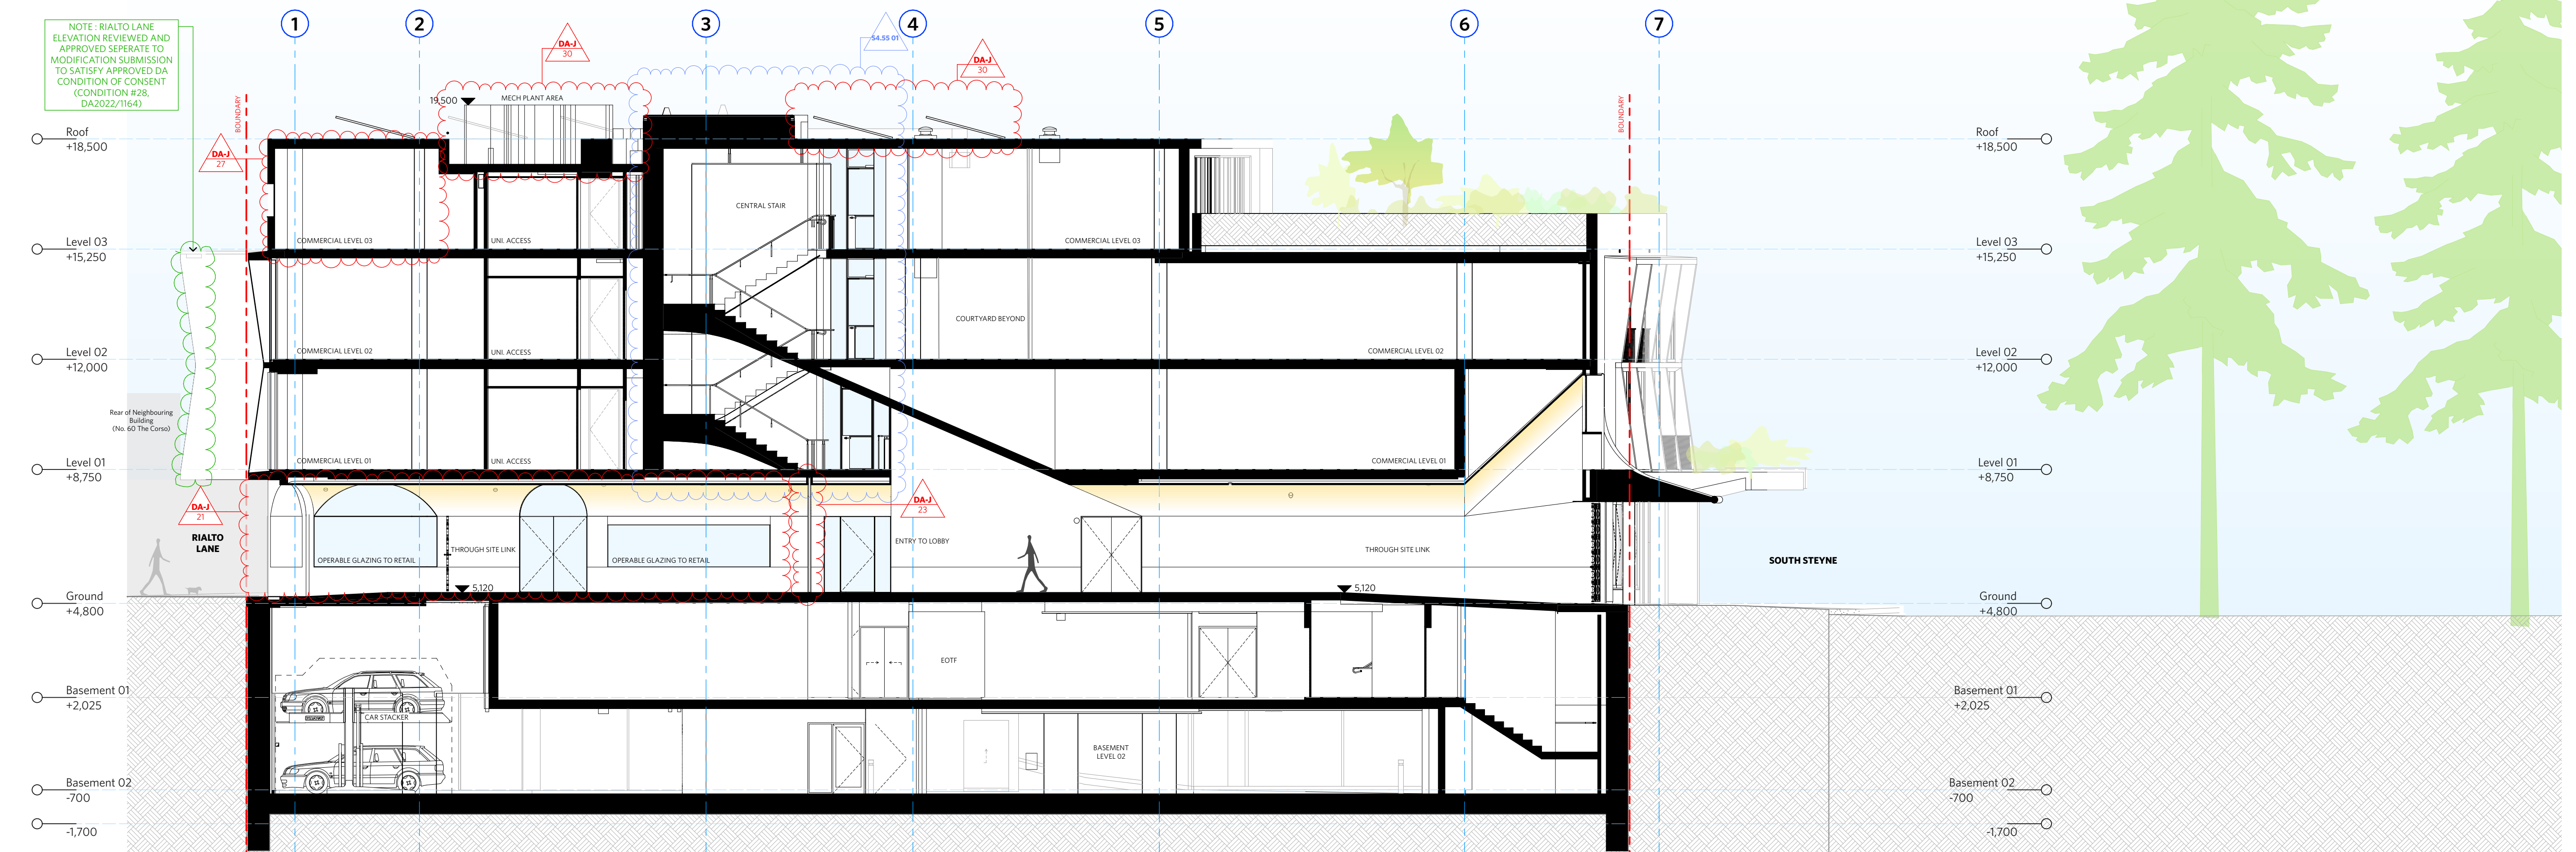

Section E 1:00

CHANGES AS SUBMITTED IN S4.55 -
UNDER REVIEW - MOD/2024/0225

CHANGES RELEVANT TO THIS MODIFICATION APPLICATION

**CHANGES REVIEWED AND APPROVED UNDER DA/
2022/1164 - CONDITION 28**

NOTES

DO NOT SCALE OFF DRAWINGS

No part of this design to be altered or
 produced without written permission.
 Copyright Durbach Block Jagers 2023.
 All rights reserved.

LEGEND

C	AIR CONDITIONING
	ELECTRONIC SWITCHBOARD
H	FIRE HYDRANT
R	FIRE HOSE REEL
IP	FIRE INDICATOR PANEL
IP	DOWNPipe
OF	OVERFLOW
D	ROLLER DOOR
PRP	DRAINAGE POINT
G	FIXED GLAZING
O	LOUVERES (OPERABLE)
GA	GATE
W	SLIDING WINDOW
OW	OPENABLE WINDOW
	RENDERED FINISH
EF	MOSAIC TILED FINISH
MR	MECHANICAL ELECTRICAL RISER
MR	HYDRAULIC RISER
7	FINISHED RL
7	STRUCTURAL RL
H	HOSETAP
S	GAS POINT

CHANGE SUMMARY

REV	CHANGE	DESCRIPTION
	17	Amendments to Central Stair
	21	Additional openings added into Ground Floor Tenancy
	23	Sliding Fire Door Added to Through Site Link
A-1	25	Changes to the Central Courtyard
	27	Increase in Floor Space to the west
	28	Changes to the Amenities to suit revised floor plate
	30	Revised Roof Layout to suit new form, including Revised Mechanical, Solar & other Equipment

QUE STATUS

REV	DESCRIPTION	DATE
A	ISSUE TO CLIENT FOR REVIEW	22/4/22
B	ISSUE FOR INFORMATION	22/5/05
C	ISSUE TO CONSULTANTS	22/5/10
D	ISSUE FOR INFORMATION	22/5/20
DA	ISSUE FOR DA	22/6/29
DA-A	REVISED ISSUE FOR COORDINATION - DA RFI AMENDMENTS	23/1/12
DA-B	REVISED SUBMISSION FOR DA	23/1/20
DA-D	REVISED DA SUBMISSION - RFI AMENDMENTS	23/7/27
DA-E	REVISED DA SUBMISSION - RFI AMENDMENTS	23/11/14
DA-F	ISSUE FOR COORDINATION	24/3/08
DA-G	ISSUE FOR S455	24/04/17
DA-H	ISSUE FOR S455 - COUNCIL RFI	24/07/05
DA-J	ISSUE FOR S455 02	24/07/11

Fortis Development Group

728 Fortis South Steyne

4-35 South Steyne Manly NSW

ARCHITECT

durbach block jagers

Level 2, 9 Roslyn Street
Potts Point NSW 2011
02 8297 3500
durbachblockjaggers.com

Nominated Architects
Neil Durbach NSW Reg. No 5850
David Jaggers NSW Reg. No 9999

DRAWN	CHECKED	DATE DRAWN	PRINTED
n]		24/07/01	18/7/2024 11:48 am

00 @ A1 / 1:200 @ A3

2m 4m



GA Sections

Section AA, BB & EE

PROJECT NO.	ISSUE	REV.
1728	DA	DA-J

DRAWING NO.
A-DA-310-001



NOTES	
DO NOT SCALE OFF DRAWINGS	
No part of this design to be altered or reproduced without written permission. © Copyright Durbach Block Jagers 2023. All rights reserved.	
LEGEND	
AC	AIR CONDITIONING
E	ELECTRICAL SWITCHBOARD
FH	FIRE HYDRANT
FHR	FIRE HOSE REEL
FIP	FIRE INDICATOR PANEL
DP	DOWNPIPE
OF	OVERFLOW
RD	ROLLER DOOR
DRP	DRAINAGE POINT
FG	FIXED GLAZING
LO	LOUVRES (OPERABLE)
GA	GATE
SW	SLIDING WINDOW
OW	OPENABLE WINDOW
RF	RENDERED FINISH
MF	MOSAIC TILED FINISH
MR	MECHANICAL/ELECTRICAL RISER
HR	HYDRAULIC RISER
▽	FINISHED RL
▼	STRUCTURAL RL
H	HOSESTEP
G	GAS POINT

1. FACADE WASHING SYSTEM LOCATED IN THE SOFFIT OF EACH OF THE 8 GLAZED EASTERN FACADE WINDOW BAYS ON LEVEL 1 & 2.

[illegible]

ISSUE STATUS		
REV	DESCRIPTION	DATE
A	ISSUE TO CLIENT FOR REVIEW	22/4/22
B	ISSUE FOR INFORMATION	22/5/05
C	ISSUE TO CONSULTANTS	22/5/10
D	ISSUE FOR INFORMATION	22/5/20
DA	ISSUE FOR DA	22/6/29
DA-A	REVISED ISSUE FOR COORDINATION - DA RFI AMENDMENTS	23/1/12
DA-B	REVISED SUBMISSION FOR DA	23/1/20
DA-D	REVISED DA SUBMISSION - RFI AMENDMENTS	23/7/27
DA-E	REVISED DA SUBMISSION - RFI AMENDMENTS	23/11/14
DA-F	ISSUE FOR COORDINATION	24/3/08
DA-G	ISSUE FOR S455	24/04/17
DA-H	ISSUE FOR S455 - COUNCIL RFI	24/07/05
DA-I	ISSUE FOR S455 O2	24/07/21

CLIENT	Fortis Development Group
JOB	1728 Fortis South Steyne 34-35 South Steyne Manly NSW

durbach block jagers

Level 2, 9 Roslyn Street
Potts Point NSW 2011
02 8297 3500
durbachblockjagers.com

Nominated Architects
Neil Durbach NSW Reg. No 5850
David Jagers NSW Reg. No 9999

DRAWN	CHECKED	DATE DRAWN	PRINTED
[m]		24/07/01	18/7/2024 11:48 am


SCALE
1:100 @ A1 / 1:200 @ A3

2m 4m



TITLE	GA Sections Section CC
-------	---------------------------

PROJECT NO. 1728	ISSUE DA	REV. DA-J
DRAWING NO. A-DA-310-002		

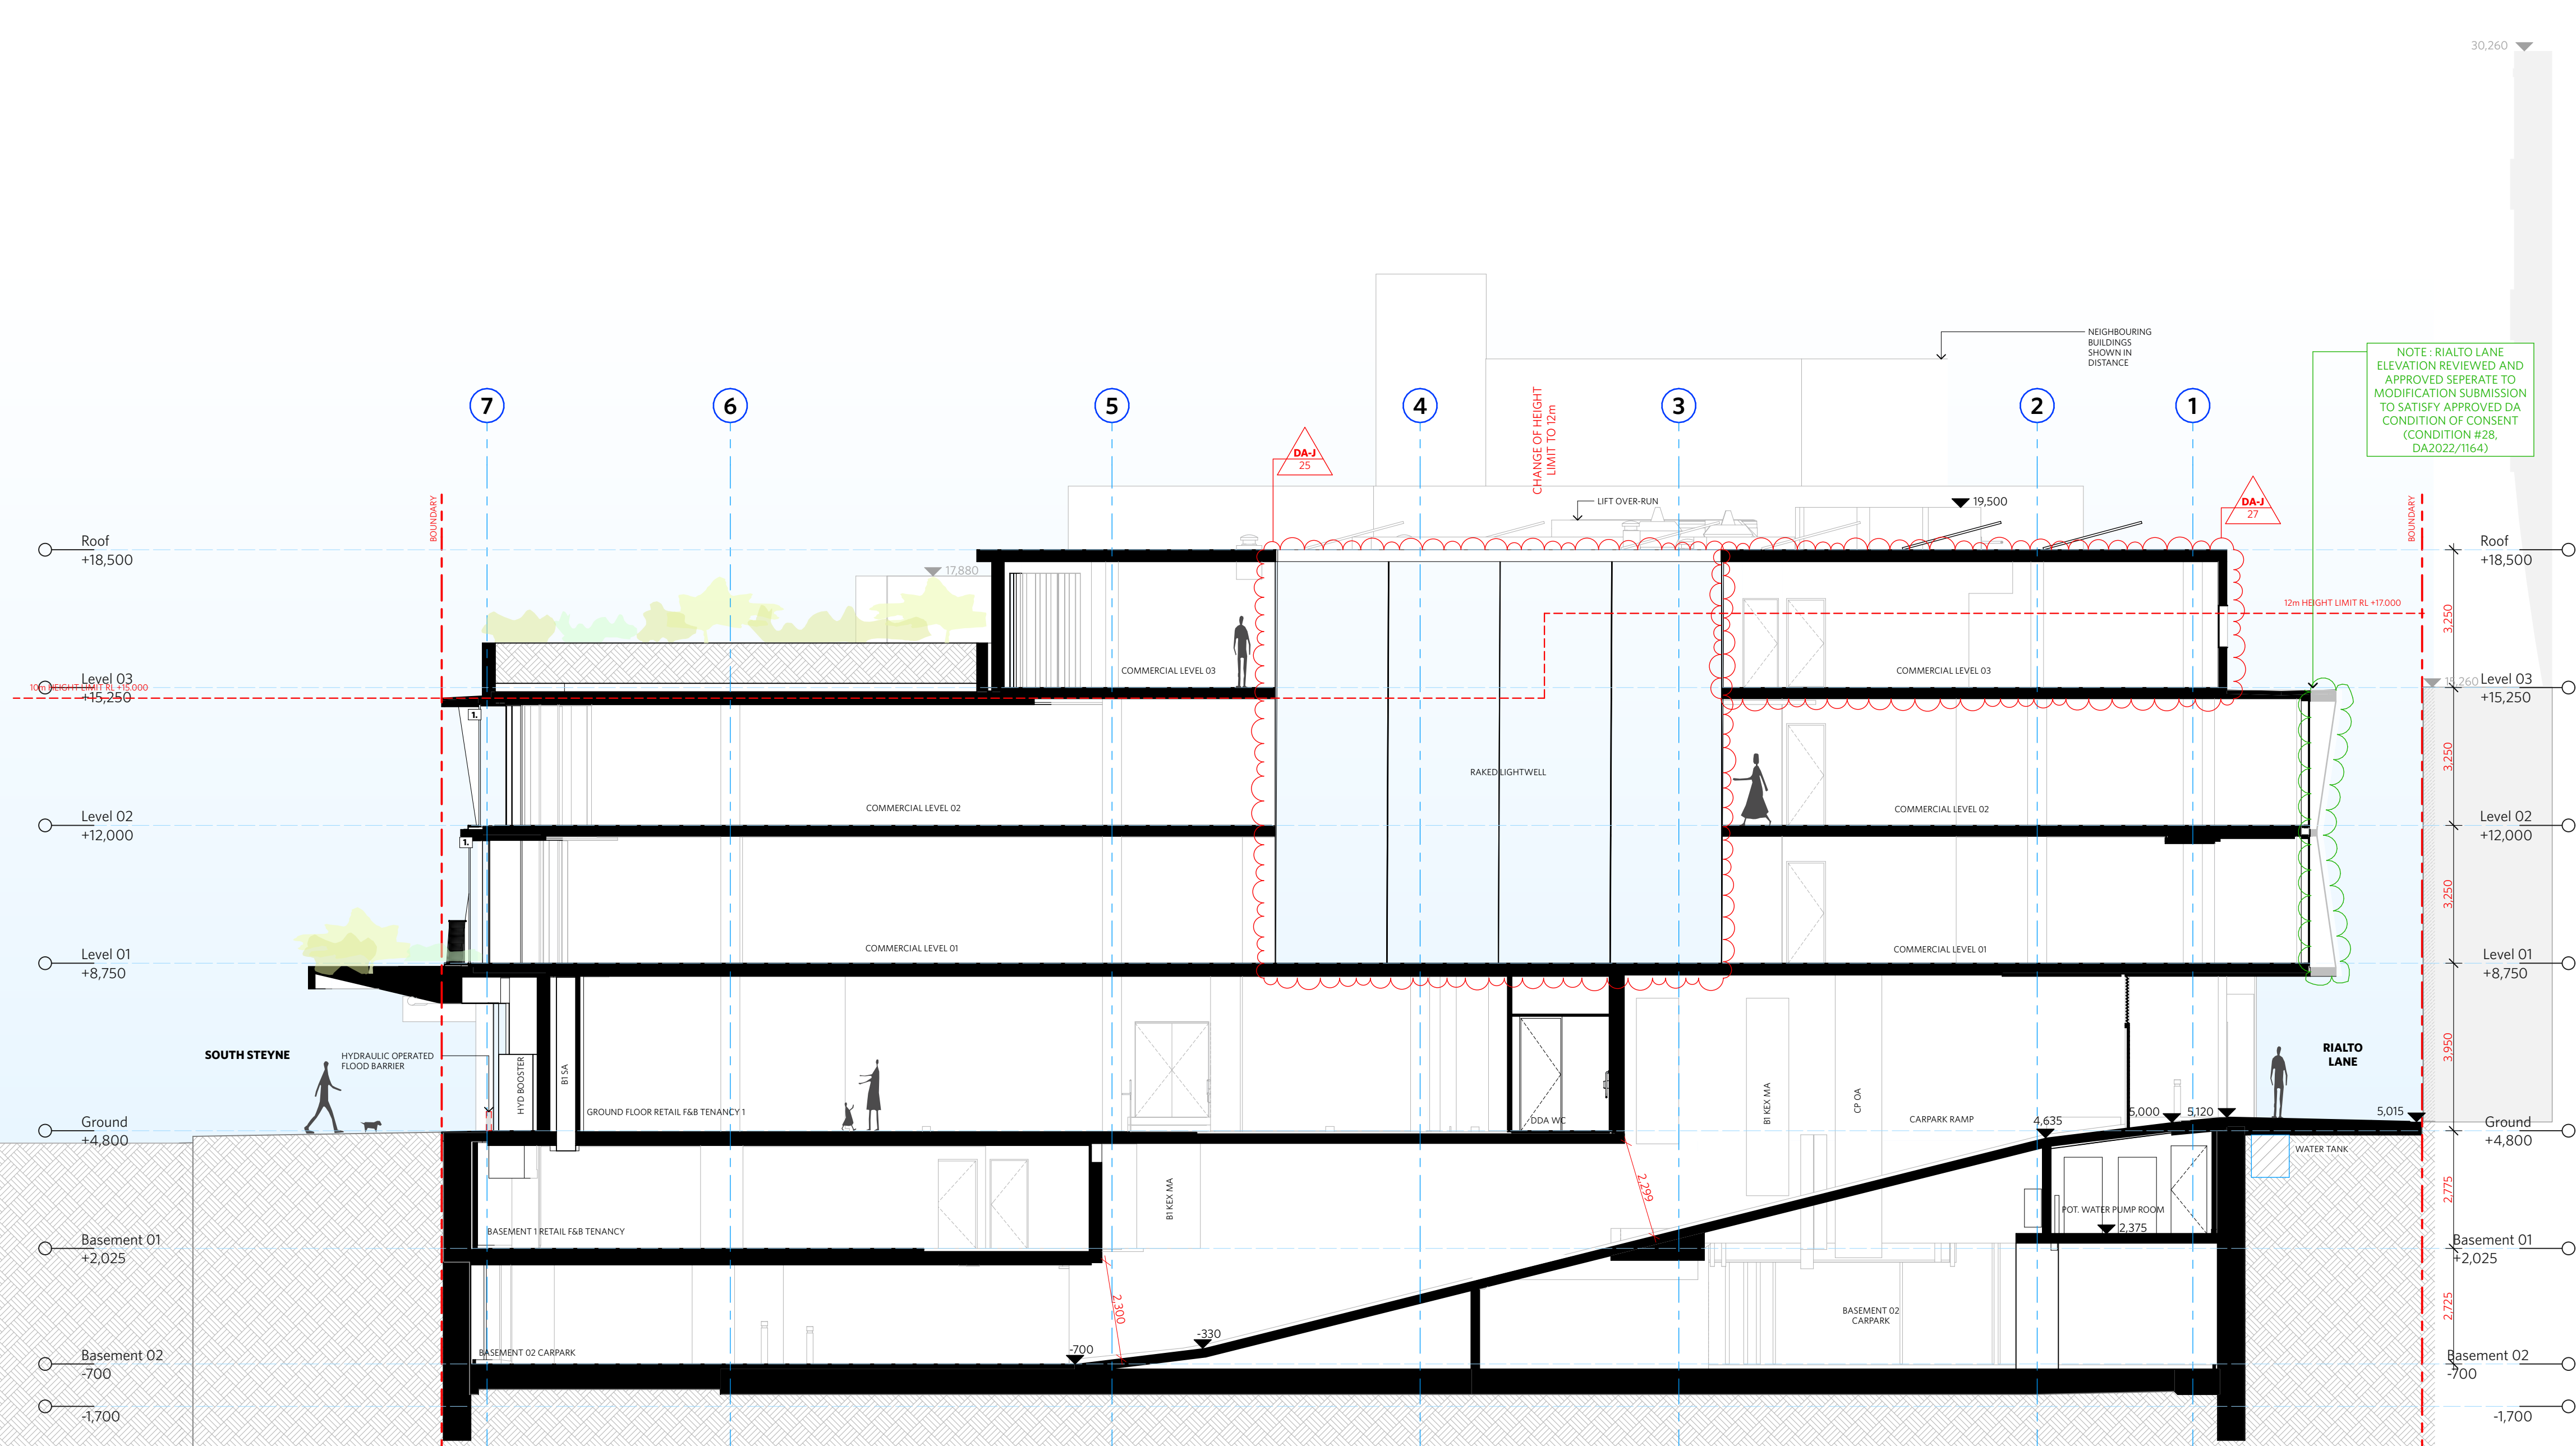

1:100

CHANGES AS SUBMITTED IN S4.55 - UNDER REVIEW - MOD/2024/0225

44.55 01

CHANGES RELEVANT TO THIS MODIFICATION APPLICATION

J XX

CHANGES REVIEWED AND APPROVED UNDER DA/2022/1164 - CONDITION 28

NOTES

DO NOT SCALE OFF DRAWINGS

No part of this design to be altered or reproduced without written permission.
© Copyright Durbach Block Jaggers 2023.
All rights reserved.

LEGEND

AC AIR CONDITIONING

E ELECTRICAL SWITCHBOARD

FH FIRE HYDRANT

FHR FIRE HOSE REEL

FIP FIRE INDICATOR PANEL

DP DOWNPIPE

OF OVERFLOW

RD ROLLER DOOR

DRP DRAINAGE POINT

FG FIXED GLAZING

LO LOUVRES (OPERABLE)

GA GATE

SW SLIDING WINDOW

OW OPENABLE WINDOW

RF RENDERED FINISH

MF MOSAIC TILED FINISH

MR MECHANICAL/ELECTRICAL RISER

HR HYDRAULIC RISER

▽ FINISHED RL

▼ STRUCTURAL RL

H HOSETAP

G GAS POINT

CHANGE SUMMARY		
REV	CHANGE	DESCRIPTION
DA-J	27	Increase in Floor Space to the west
	28	Changes to the Amenities to suit revised floor plate
	30	Revised Roof Layout to suit new form, including Revised Mechanical Solar & other Equipment

ISSUE STATUS		
REV	DESCRIPTION	DATE
A	ISSUE TO CLIENT FOR REVIEW	22/4/22
B	ISSUE FOR INFORMATION	22/5/05
C	ISSUE TO CONSULTANTS	22/5/10
D	ISSUE FOR INFORMATION	22/5/20
DA	ISSUE FOR DA	22/6/29
DA-A	REVISED ISSUE FOR COORDINATION - DA RFI AMENDMENTS	23/1/12
DA-B	REVISED SUBMISSION FOR DA	23/1/20
DA-D	REVISED DA SUBMISSION - RFI AMENDMENTS	23/7/27
DA-E	REVISED DA SUBMISSION - RFI AMENDMENTS	23/11/14
DA-F	ISSUE FOR COORDINATION	24/3/08
DA-G	ISSUE FOR S455	24/04/17
DA-H	ISSUE FOR S455 - COUNCIL RFI	24/07/05
DA-J	ISSUE FOR S455 02	24/07/11

CLIENTFortis Development Group

JOB1728 Fortis South Steyne
34-35 South Steyne Manly NSW

ARCHITECT

durbach block jaggers

Level 2, 9 Roslyn Street
Potts Point NSW 2011
02 8297 3500
durbachblockjaggers.com

Nominated Architects
Neil Durbach NSW Reg. No 5850
David Jaggers NSW Reg. No 9999


DRAWN	CHECKED	DATE DRAWN	PRINTED
		24/07/01	18/7/2024 11:48 am
SCALE			
1:100 @ A1 / 1:200 @ A3			
2m 4m			


TITLE

GA Sections


Section DD

PROJECT NO.	ISSUE	REV
1728	DA	DA-J
DRAWING NO.		
A-DA-310-003		

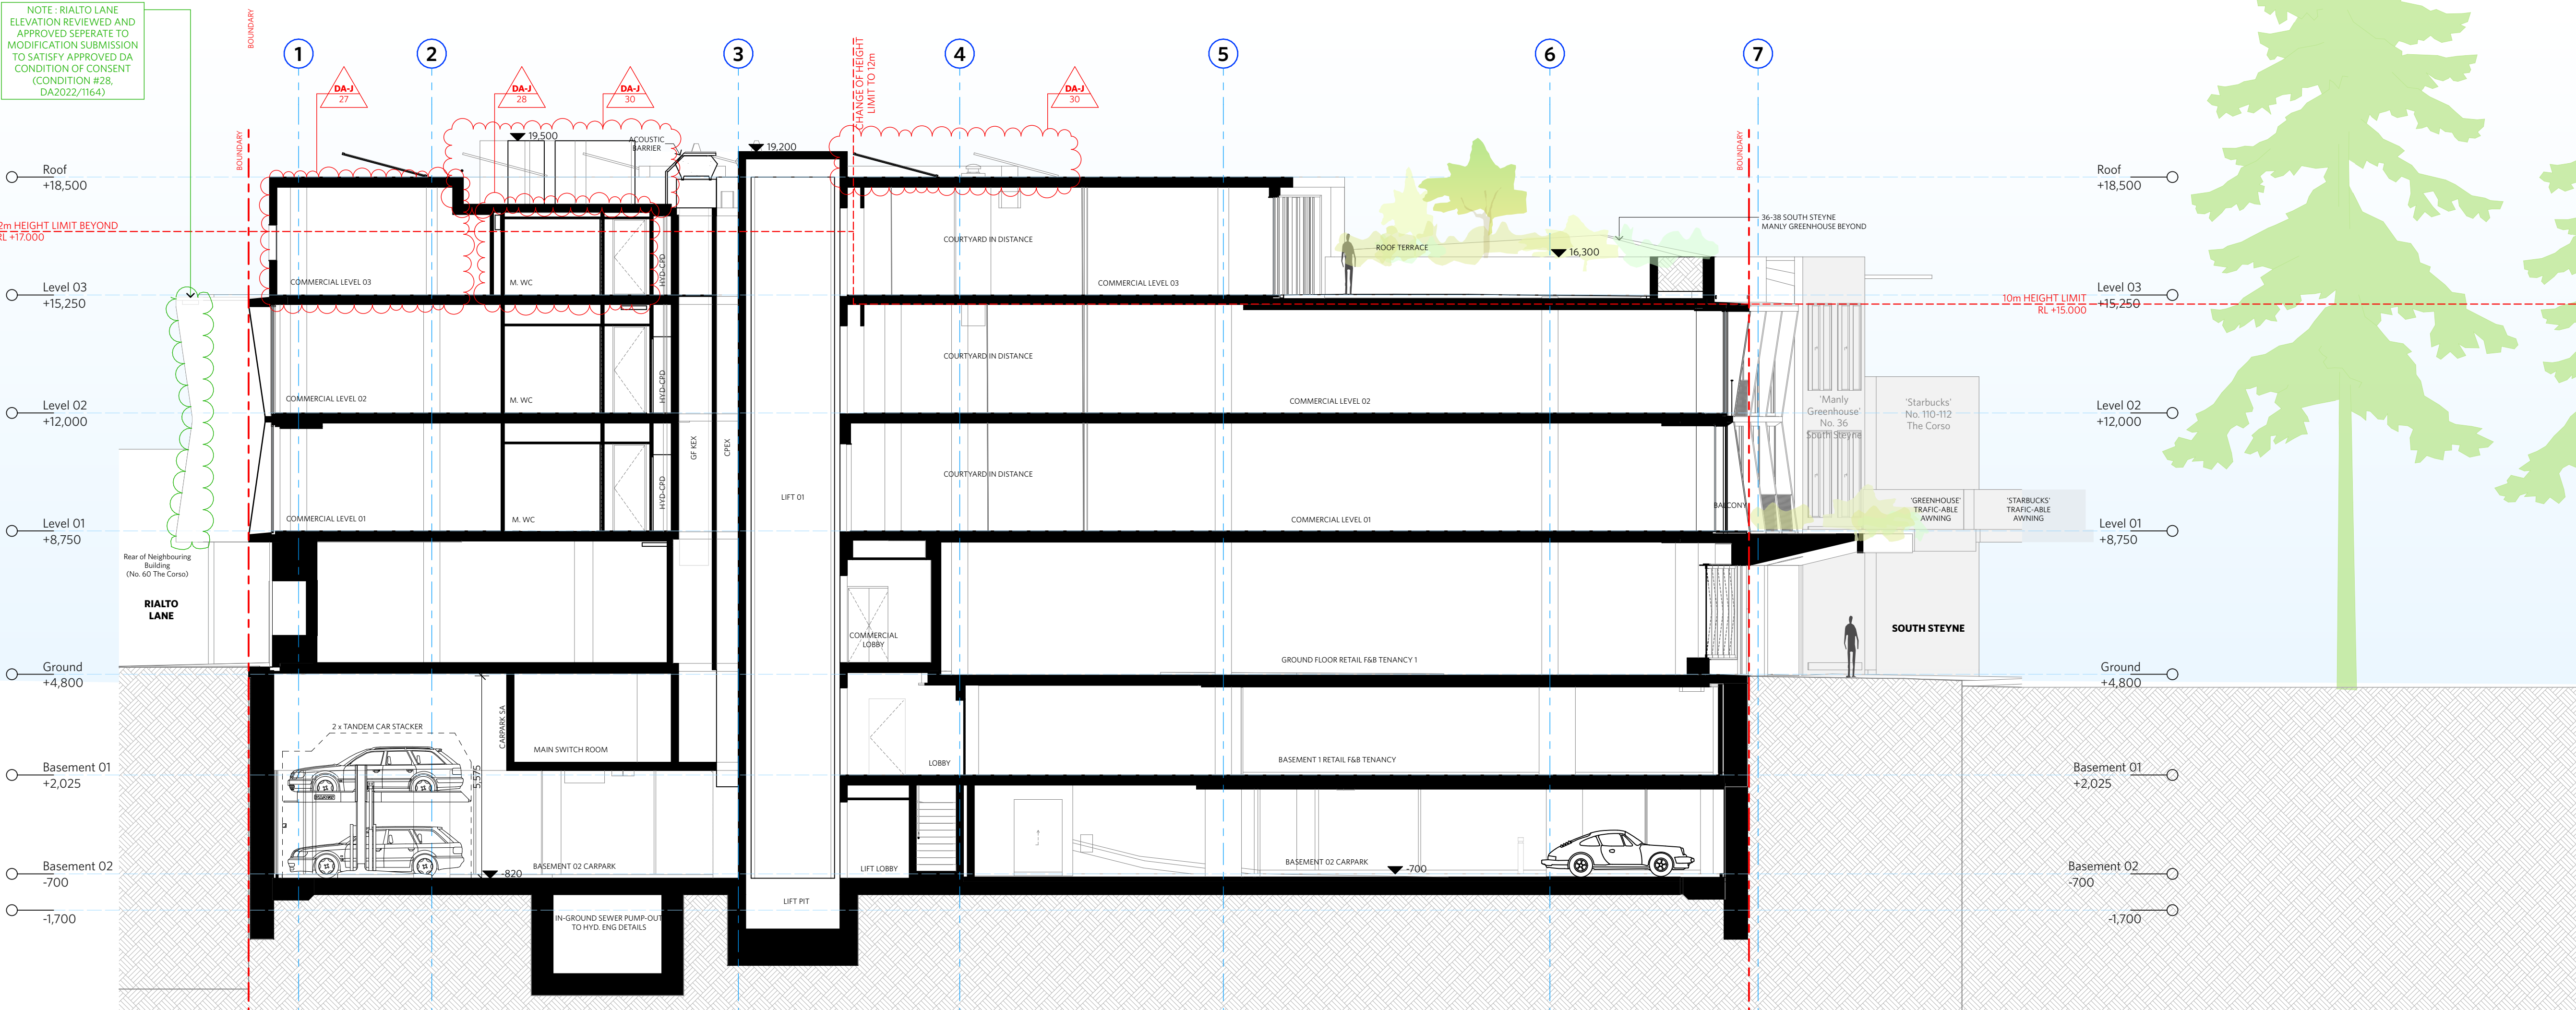


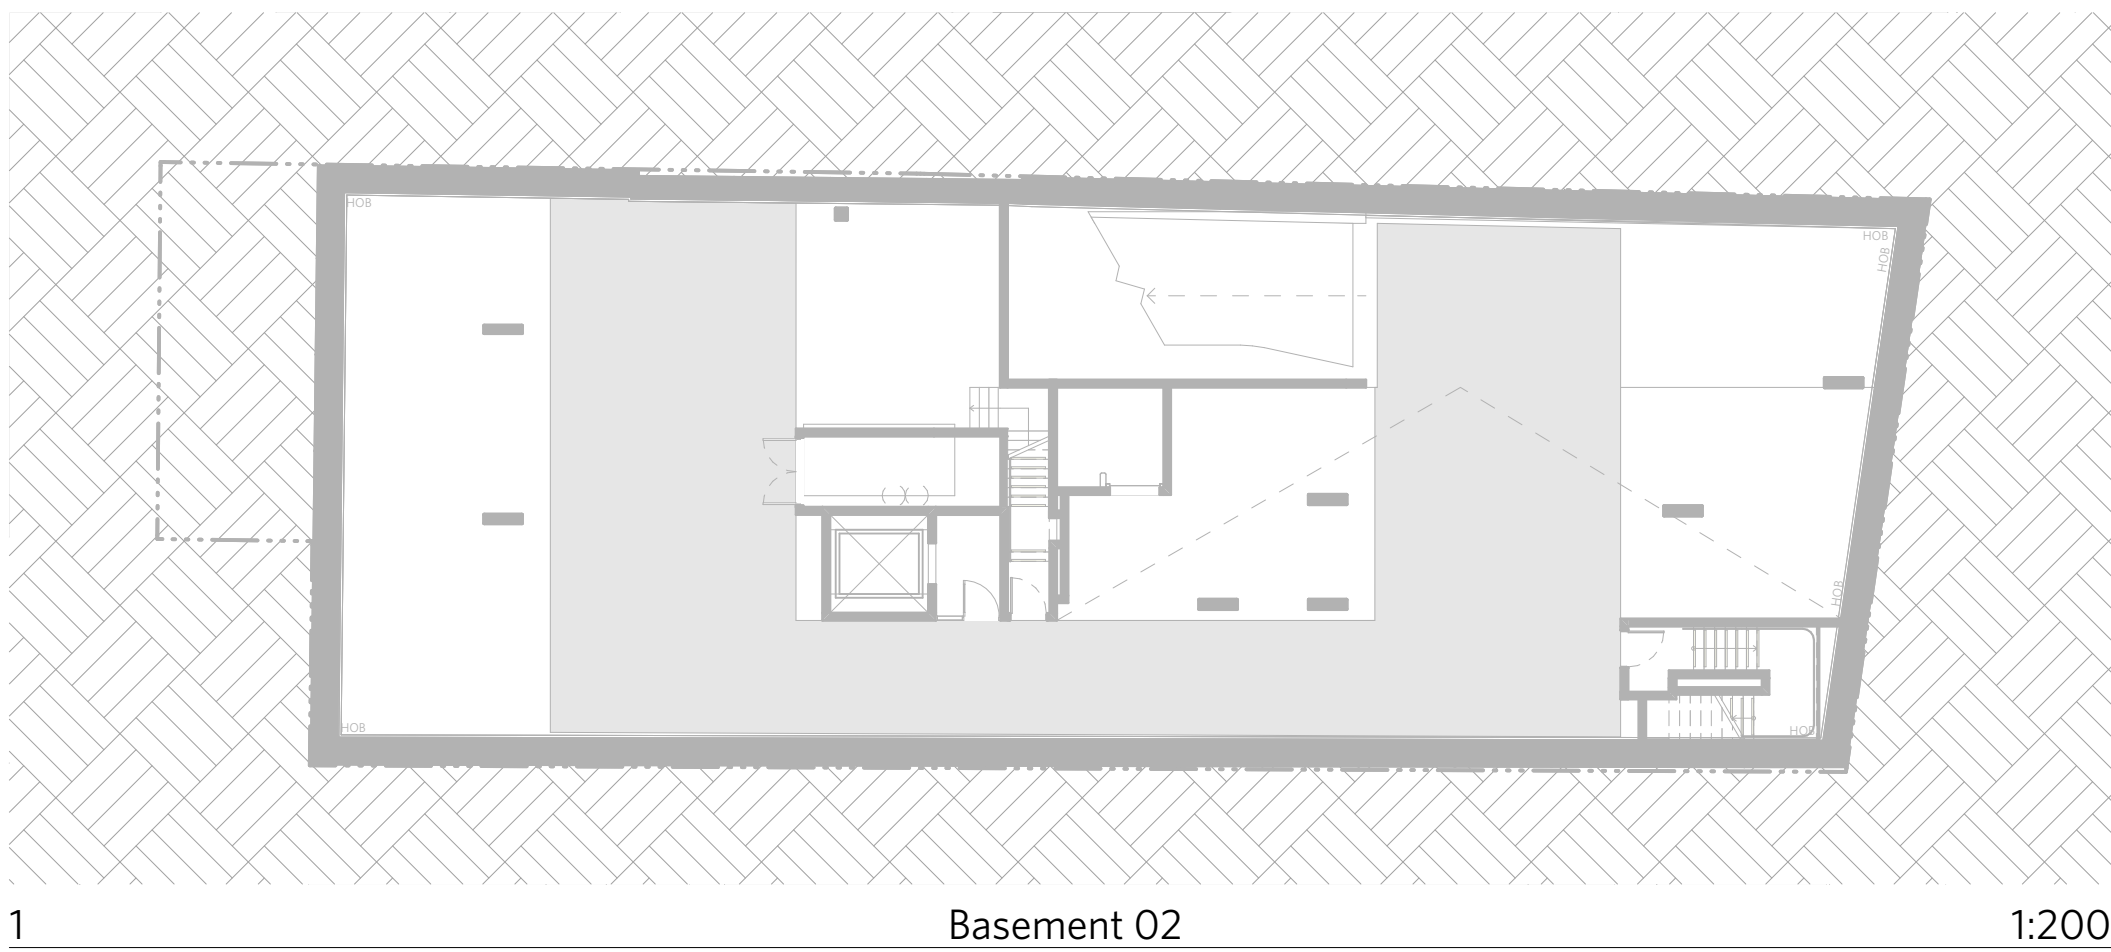


1 Basement 02 1:200

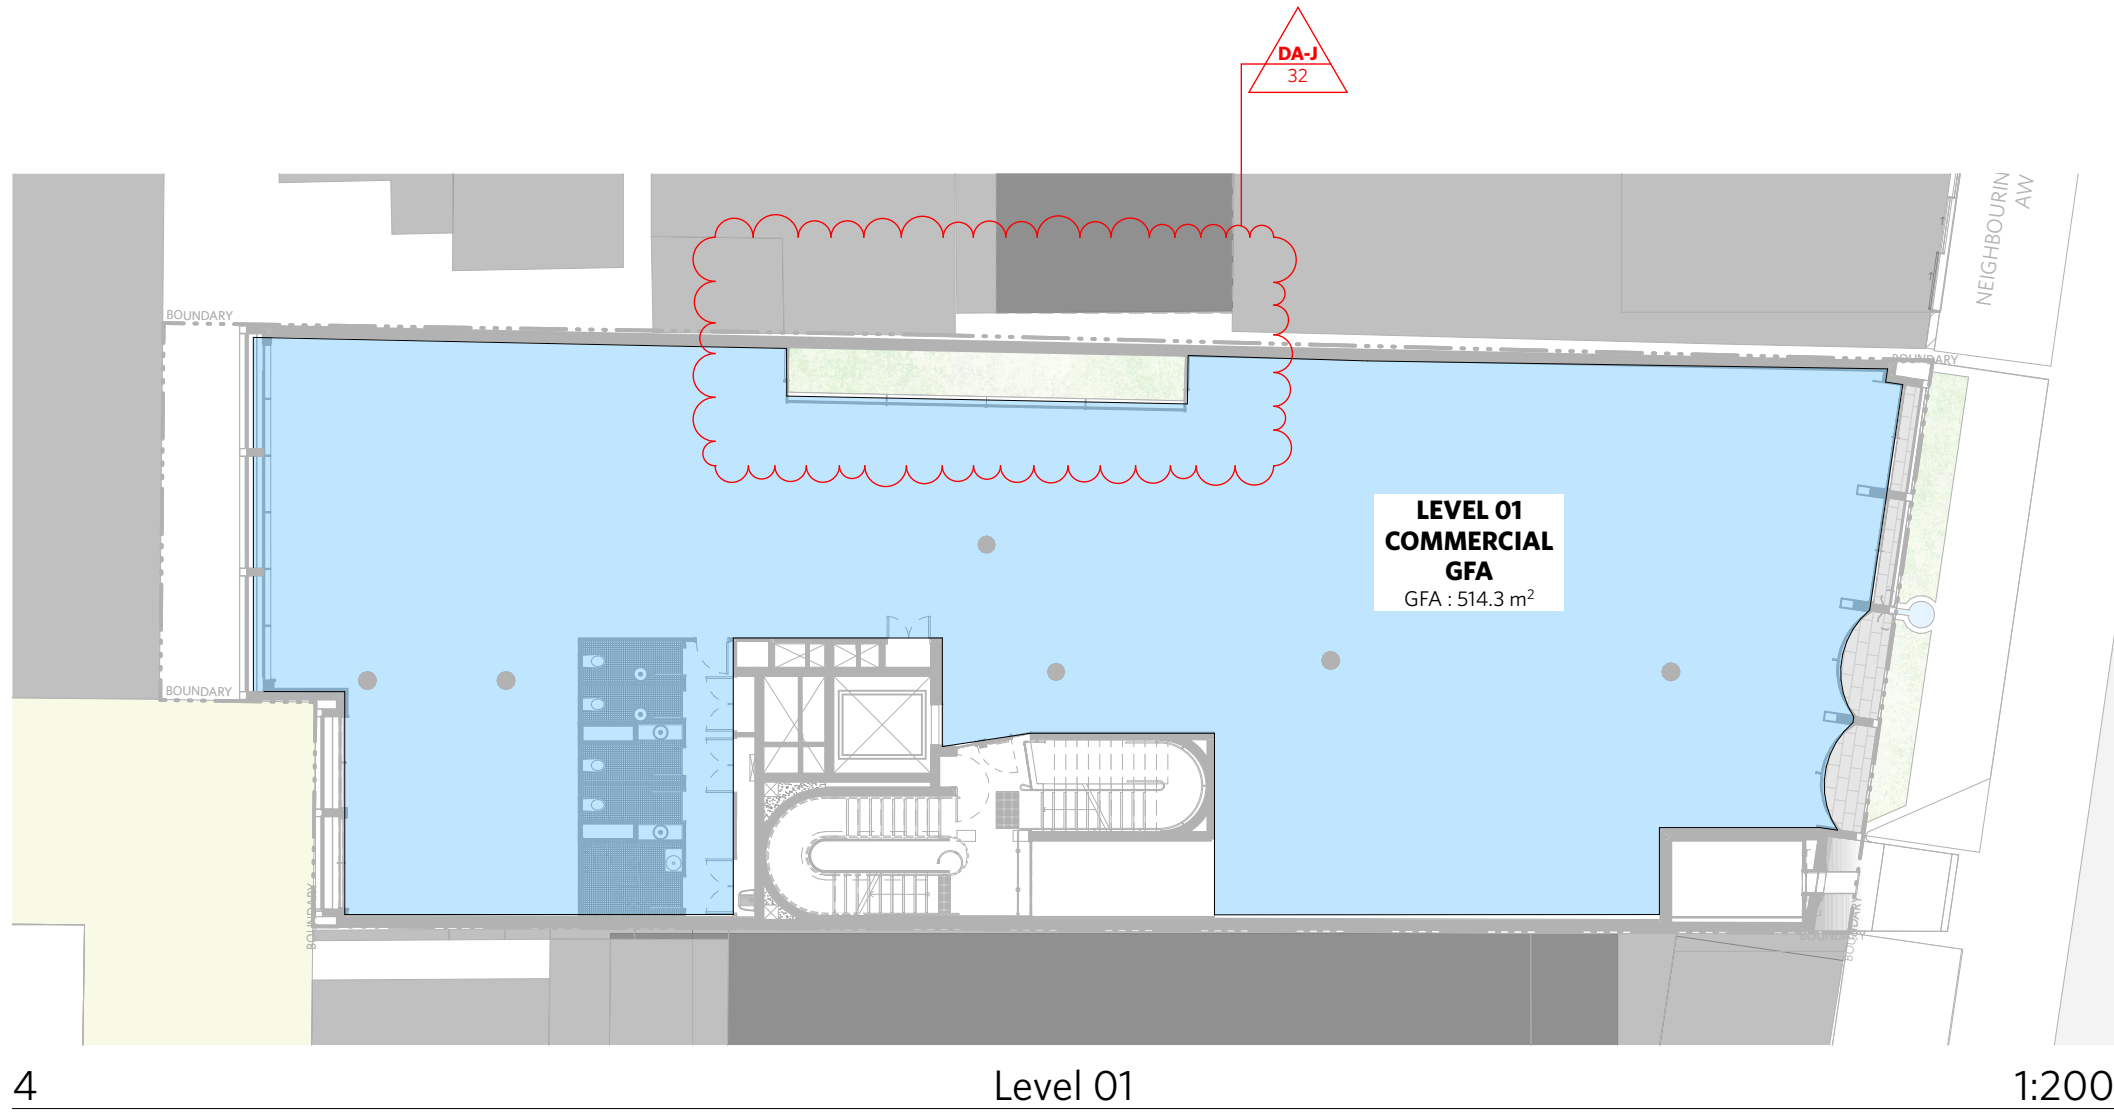


4 Level 01 1:200

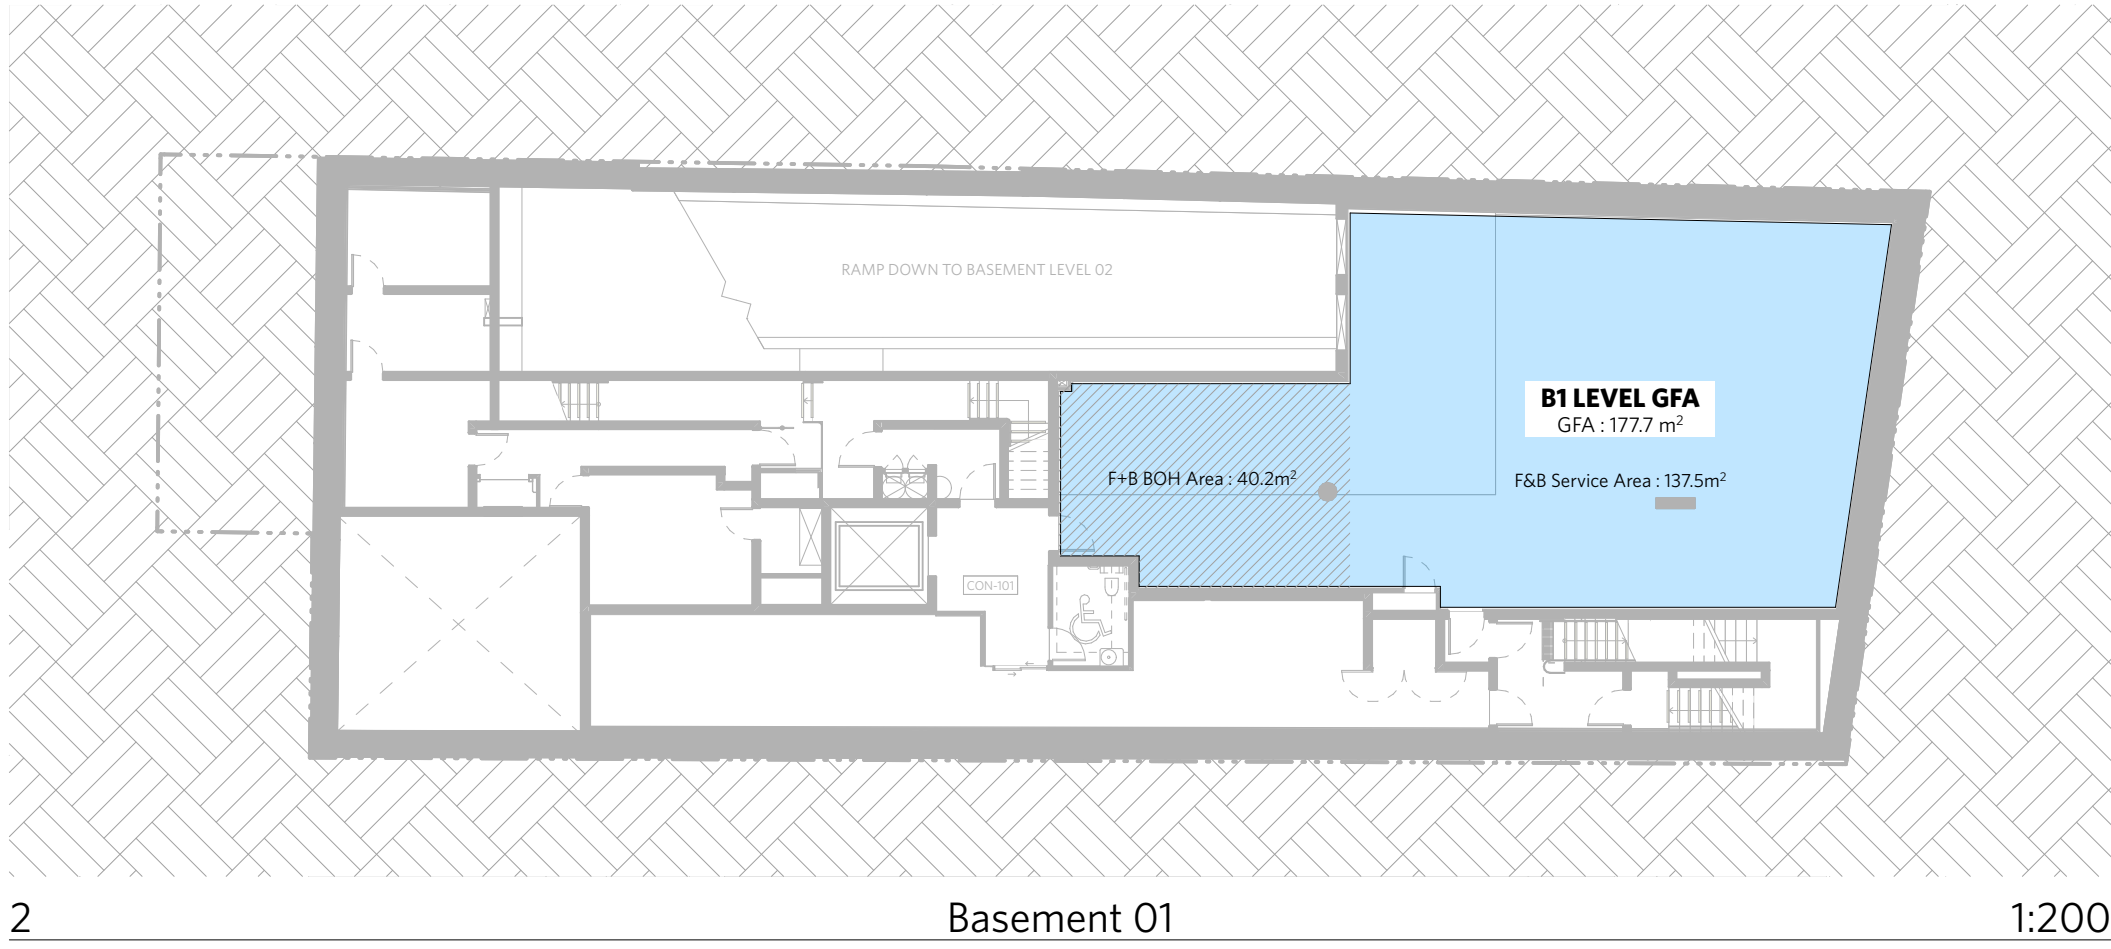


2 Basement 01 1:200

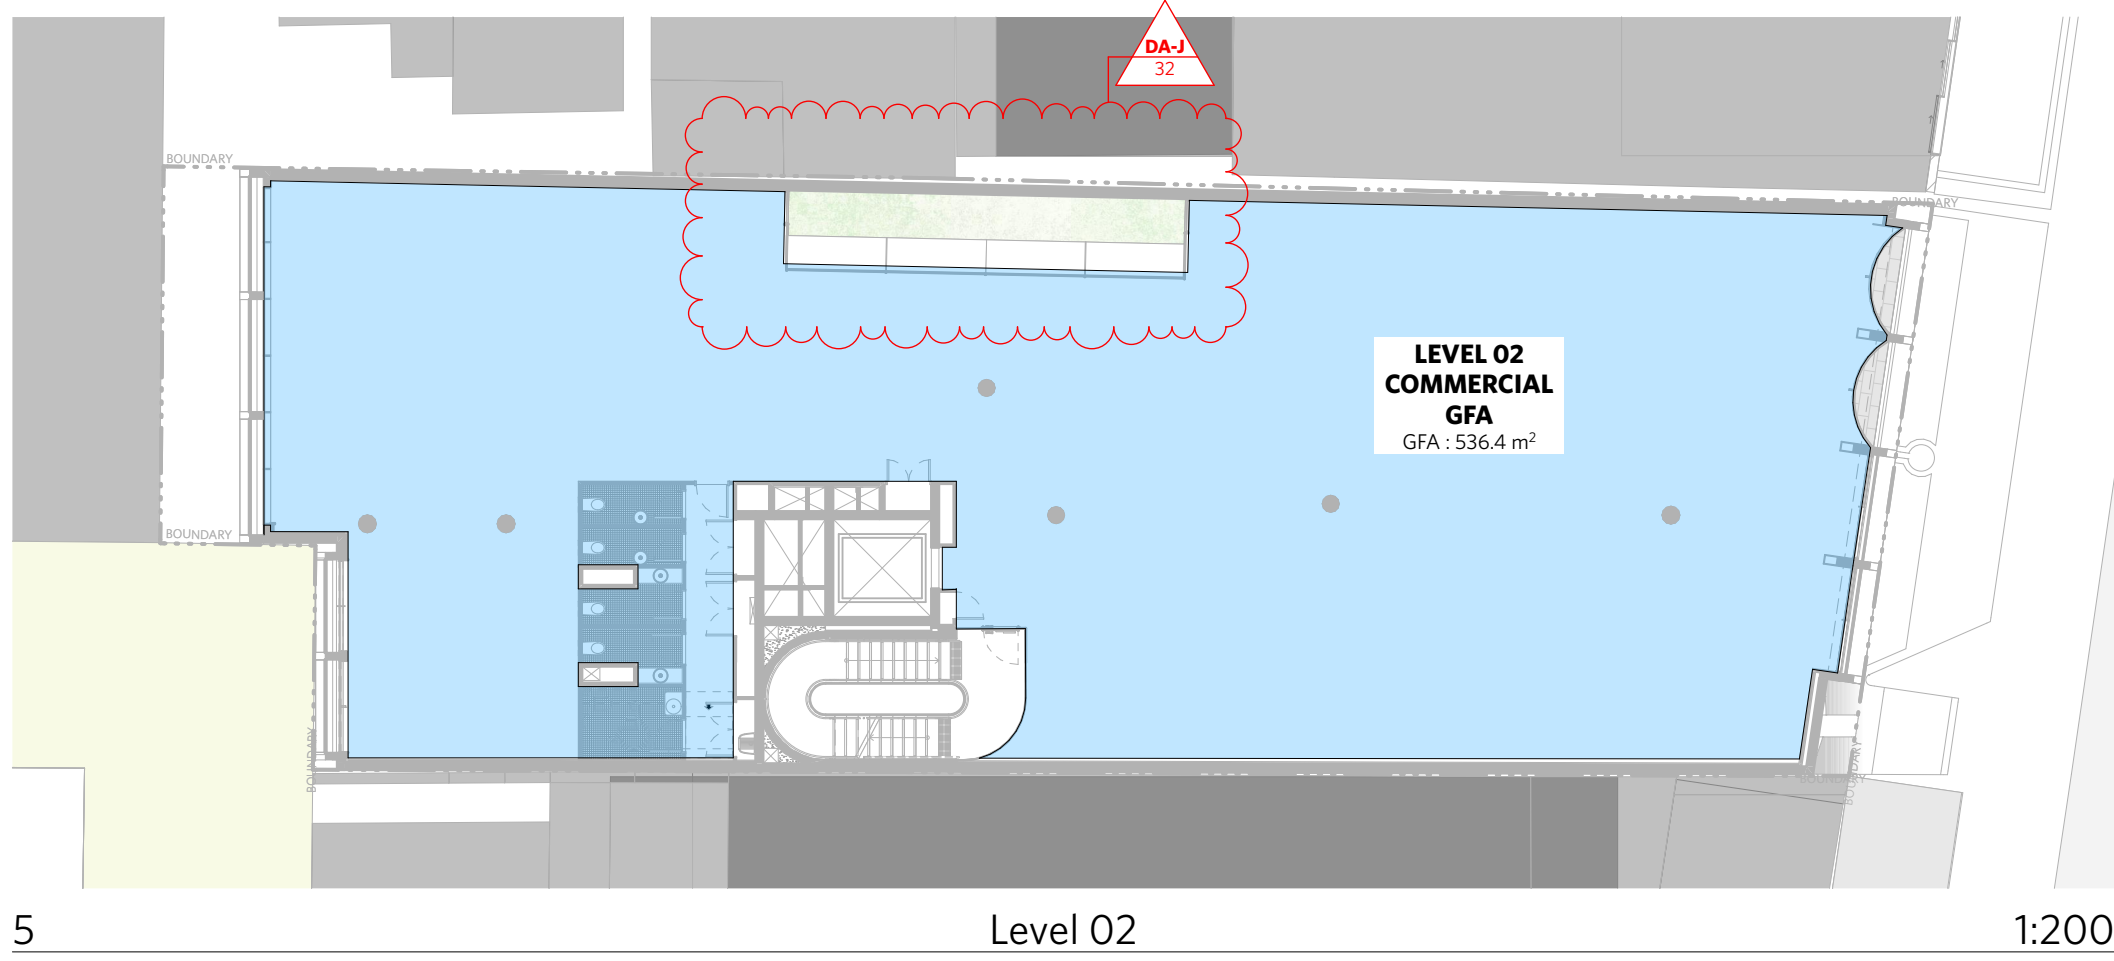

5 Level 02 1:200

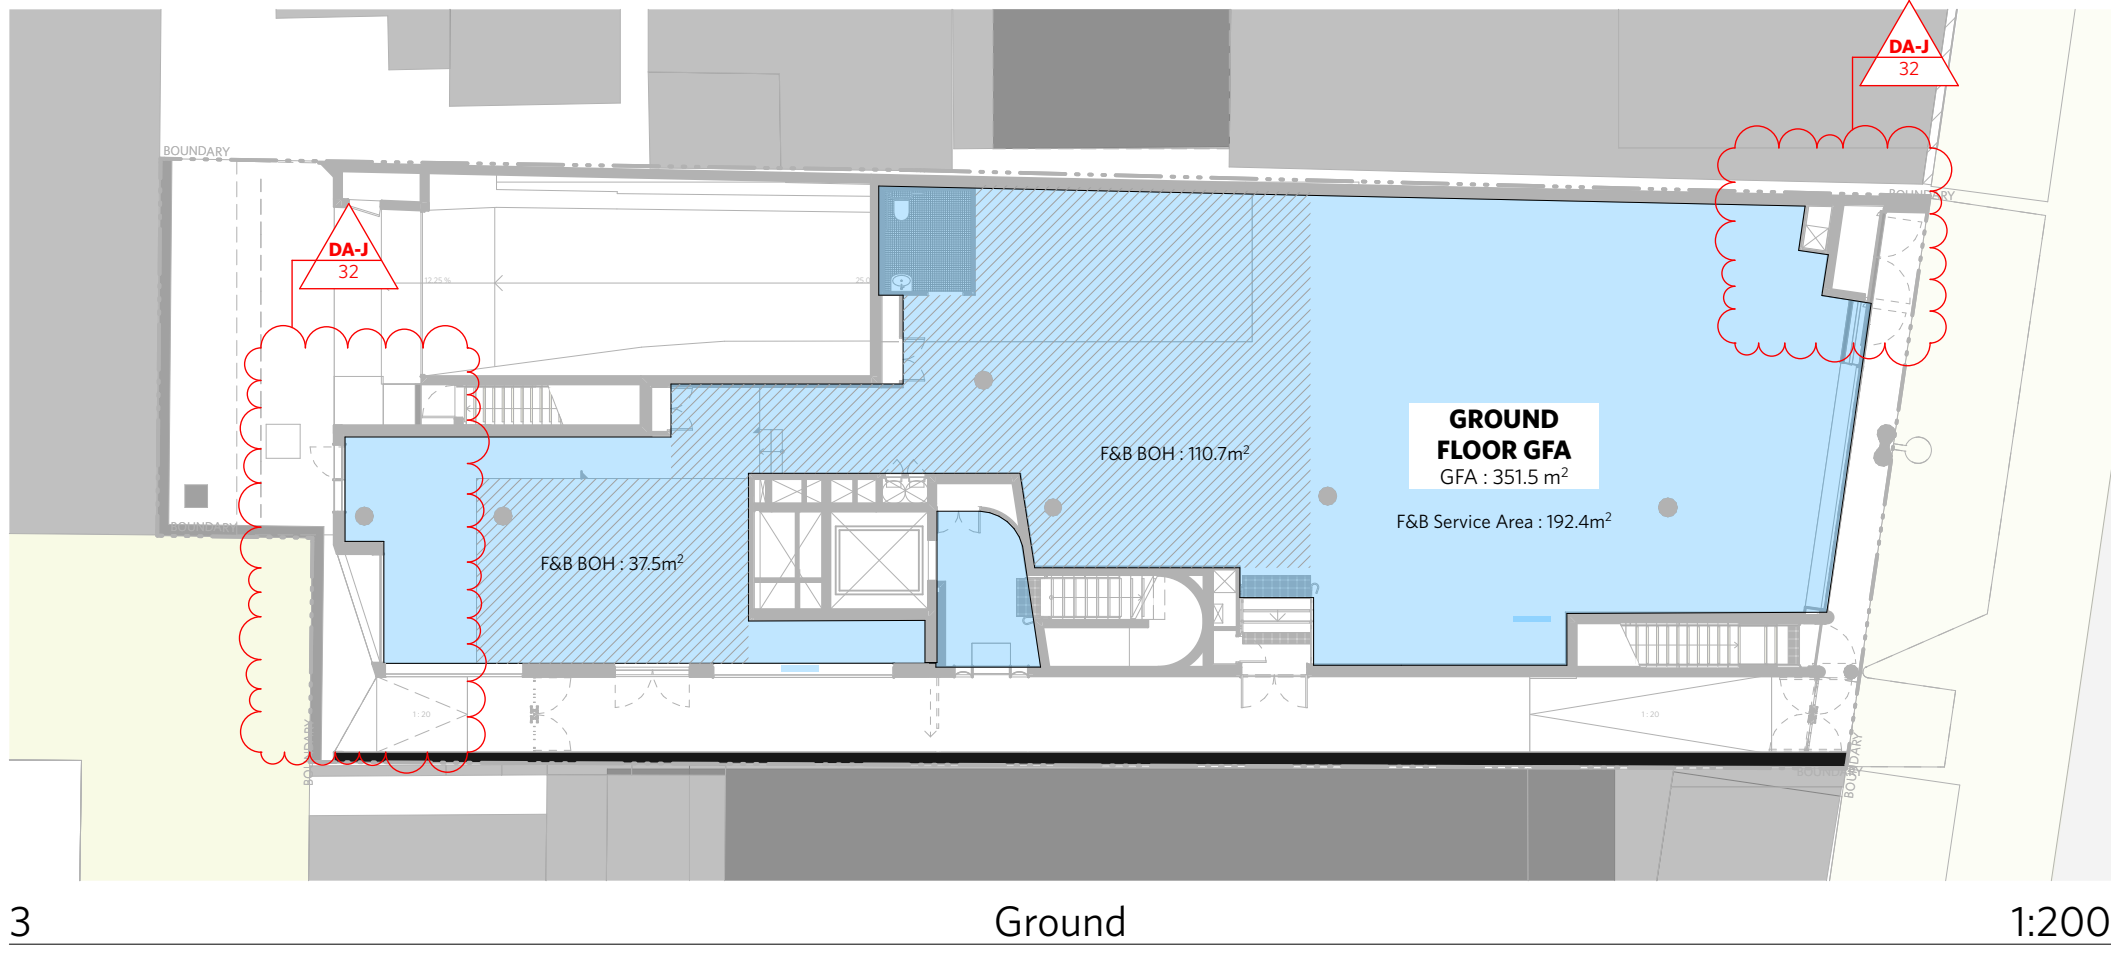

3 Ground 1:200

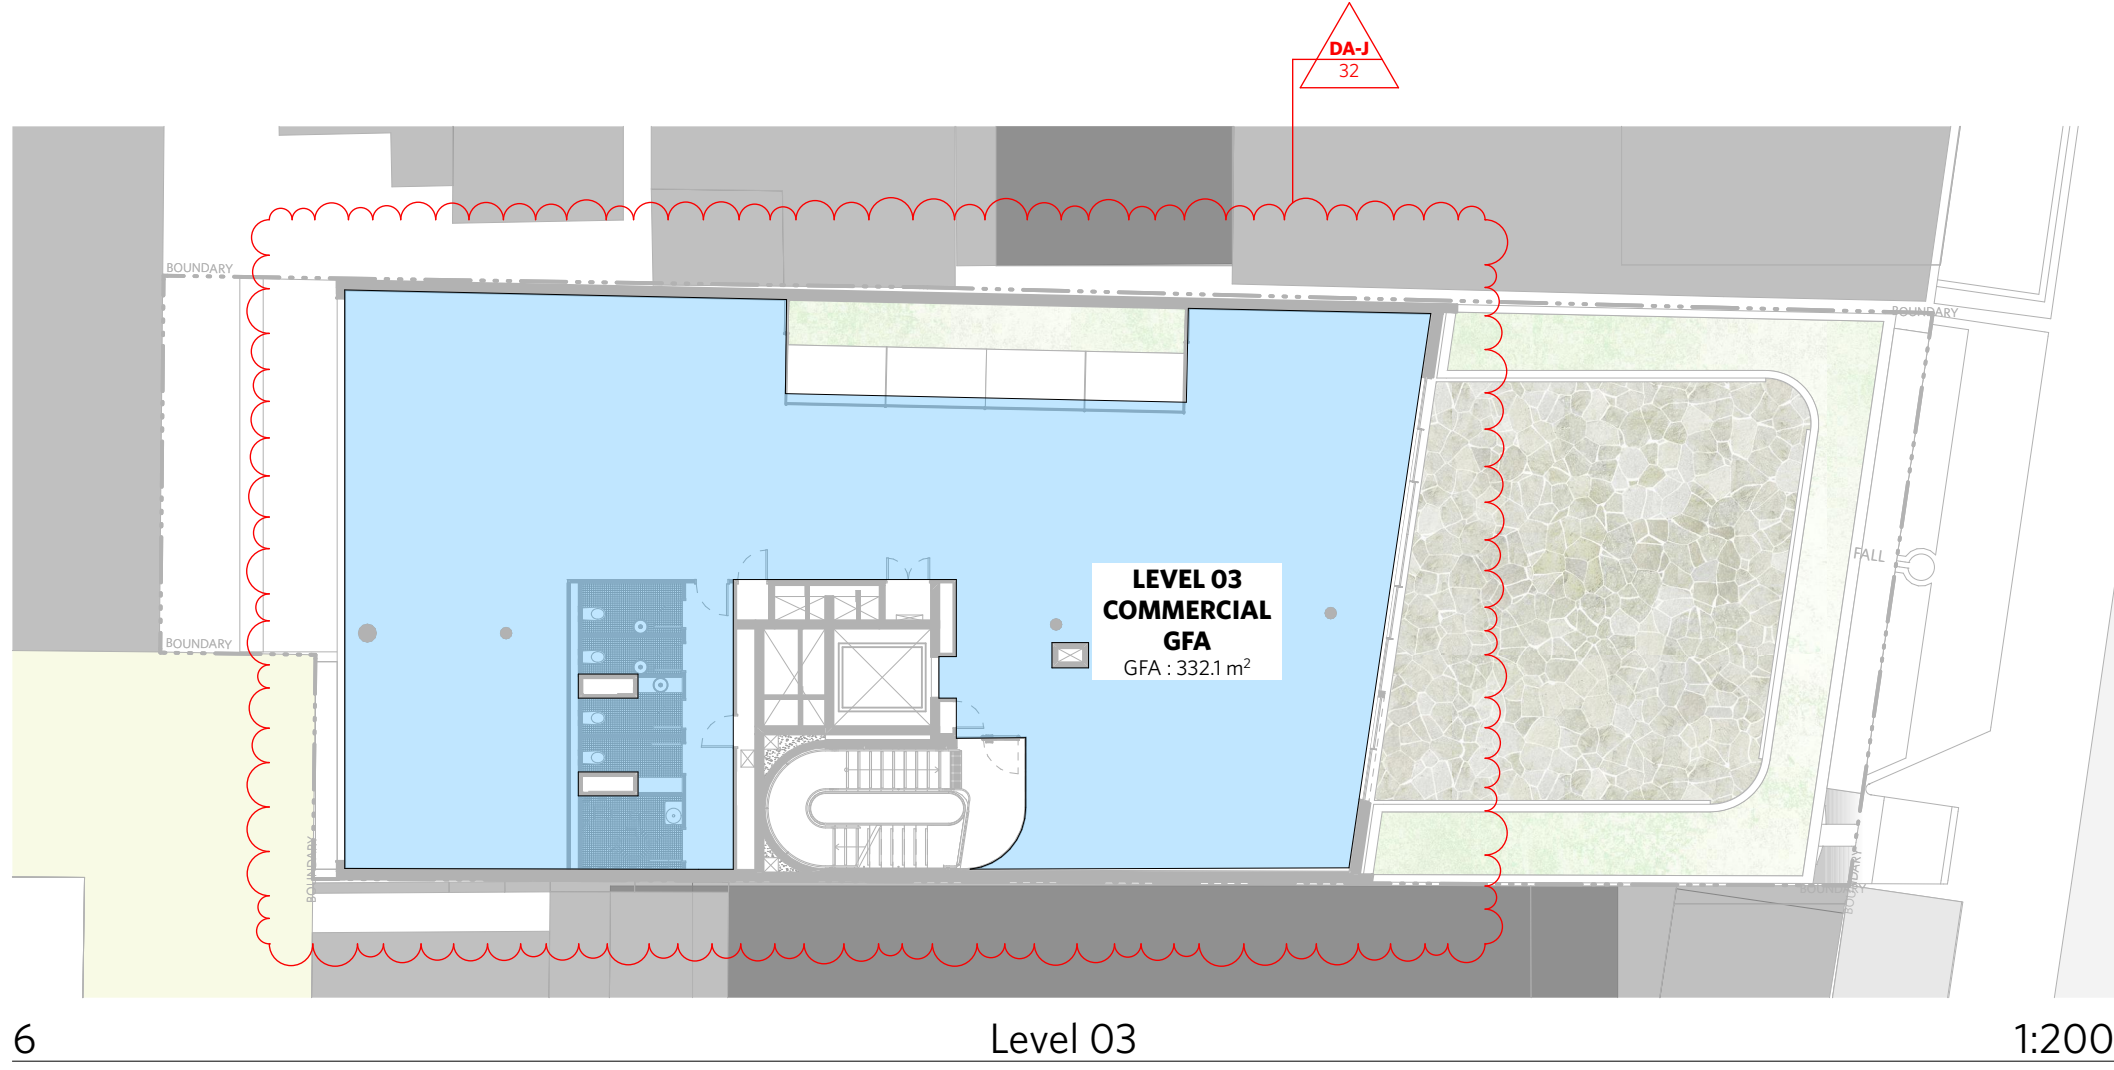

6 Level 03 1:200

1728 GFA Schedule 1		
Home Story Name	Zone Name	Calculated Area (sqm)
Basement 01		
	B1 LEVEL GFA	177.7
Ground		
	GROUND FLOOR GFA	351.5
Level 01		
	LEVEL 01 COMMERCIAL GFA	514.3
Level 02		
	LEVEL 02 COMMERCIAL GFA	536.4
Level 03		
	LEVEL 03 COMMERCIAL GFA	332.1
		1,912.0 m²

LEGEND	
AC	AIR CONDITIONING
E	ELECTRICAL SWITCHBOARD
FH	FIRE HYDRANT
FHR	FIRE HOSE REEL
FIP	FIRE INDICATOR PANEL
DP	DOWNPIPE
OF	OVERFLOW
RD	ROLLER DOOR
DRP	DRAINAGE POINT
FG	FIXED GLAZING
LO	LOUVRES (OPERABLE)
GA	GATE
SW	SLIDING WINDOW
OW	OPENABLE WINDOW
RF	RENDERED FINISH
MF	MOSAIC TILED FINISH
MR	MECHANICAL/ELECTRICAL RISER
HR	HYDRAULIC RISER
▽	FINISHED RL
▼	STRUCTURAL RL
H	HOSE TAP
G	GAS POINT

CHANGE SUMMARY		
REV	CHANGE	DESCRIPTION
DA-J	27	Increase in Floor Space to the west
	32	GFA Adjustment due to changes

ISSUE STATUS		
REV	DESCRIPTION	DATE
A	ISSUE TO CLIENT FOR REVIEW	22/4/22
B	ISSUE FOR INFORMATION	22/5/05
C	ISSUE TO CONSULTANTS	22/5/10
D	ISSUE FOR INFORMATION	22/5/20
DA	ISSUE FOR DA	22/6/29
DA-A	REVISED ISSUE FOR COORDINATION - DA RFI AMENDMENTS	23/1/12
DA-B	REVISED SUBMISSION FOR DA	23/1/20
DA-C	ISSUE FOR S455	24/04/17
DA-J	ISSUE FOR S455 02	24/07/11

CLIENT Fortis Development Group
JOB 1728 Fortis South Steyne
34-35 South Steyne Manly NSW

ARCHITECT
durbach block jagers
Level 2, 9 Roslyn Street
Porto Point NSW 2011
02 8297 3500
durbachblockjagers.com
Nominated Architects
Neil Durbach NSW Reg. No 5850
David Jagers NSW Reg. No 9999

DRAWN [m] CHECKED DATE DRAWN 24/07/01 PRINTED 18/7/2024 11:48 am

SCALE 1:200 @ A1 / 1:400 @ A3
2m 4m 6m 8m

TITLE
GFA & NLA Diagrams
GFA Diagrams Sheet 1

PROJECT NO. 1728
ISSUE TD
REV DA-J
DRAWING NO. A-DA-710-001

CHANGES AS SUBMITTED IN S4.55 - UNDER REVIEW - MOD/2024/0225

CHANGES RELEVANT TO THIS MODIFICATION APPLICATION

CHANGES REVIEWED AND APPROVED UNDER DA/2022/1164 - CONDITION 28