


Rev. No.	Date	Revision	Amended
A	20.08.10	ISSUED FOR DA APPROVAL	GH
B	23.09.10	CALCULATIONS AMENDED	GH
C	19.09.13	RETENDER ISSUE	GH

HYDRAULIC ENGINEER
GLENN HAIG & PARTNERS

ENERGY ASSESSOR

LANDSCAPE ARCHITECT

CLIENT
GEORGE TSVIS

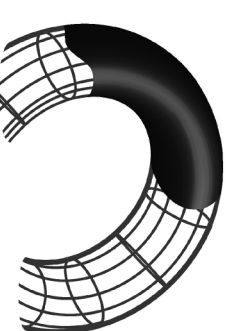

GLENN HAIG
& Partners

Hydraulic + Fire Consultants

7/70 First Avenue
Sawell NSW 2452
E-mail: office@gehmg.com.au

Phone: (02) 6658 2444
Fax: (02) 6658 2455
Mobile: 0413 308 660



www.quattrodesign.com.au

Quattro Design Pty Limited
ACN 094 615 8653

Sydney 61 2 9839 9881
Studio Level 1, 35 Buckingham Street
Surrey Hills NSW 2010
Canberra 61 6251 2016
Suite 2, Level 1, 53 Bowman Street
PO Box 816 Macquarie ACT 2614

Project
PROPOSED NEW HOUSES
136 ANZAC AVENUE
COLLAROY NSW

Drawing title
SITE PLAN

Scale at A1 1:200
Scale at A3 1:400

Figured dimensions shall take precedence over words. Contractors must verify all dimensions on job before commencing any work or making shop drawings.


Y:\Projects\101726\Drawing Files\101726-H101

Drawn By
Checked By
Project Number
Drawing Number
Rev

101726 H-001


C

This drawing is protected by copyright.

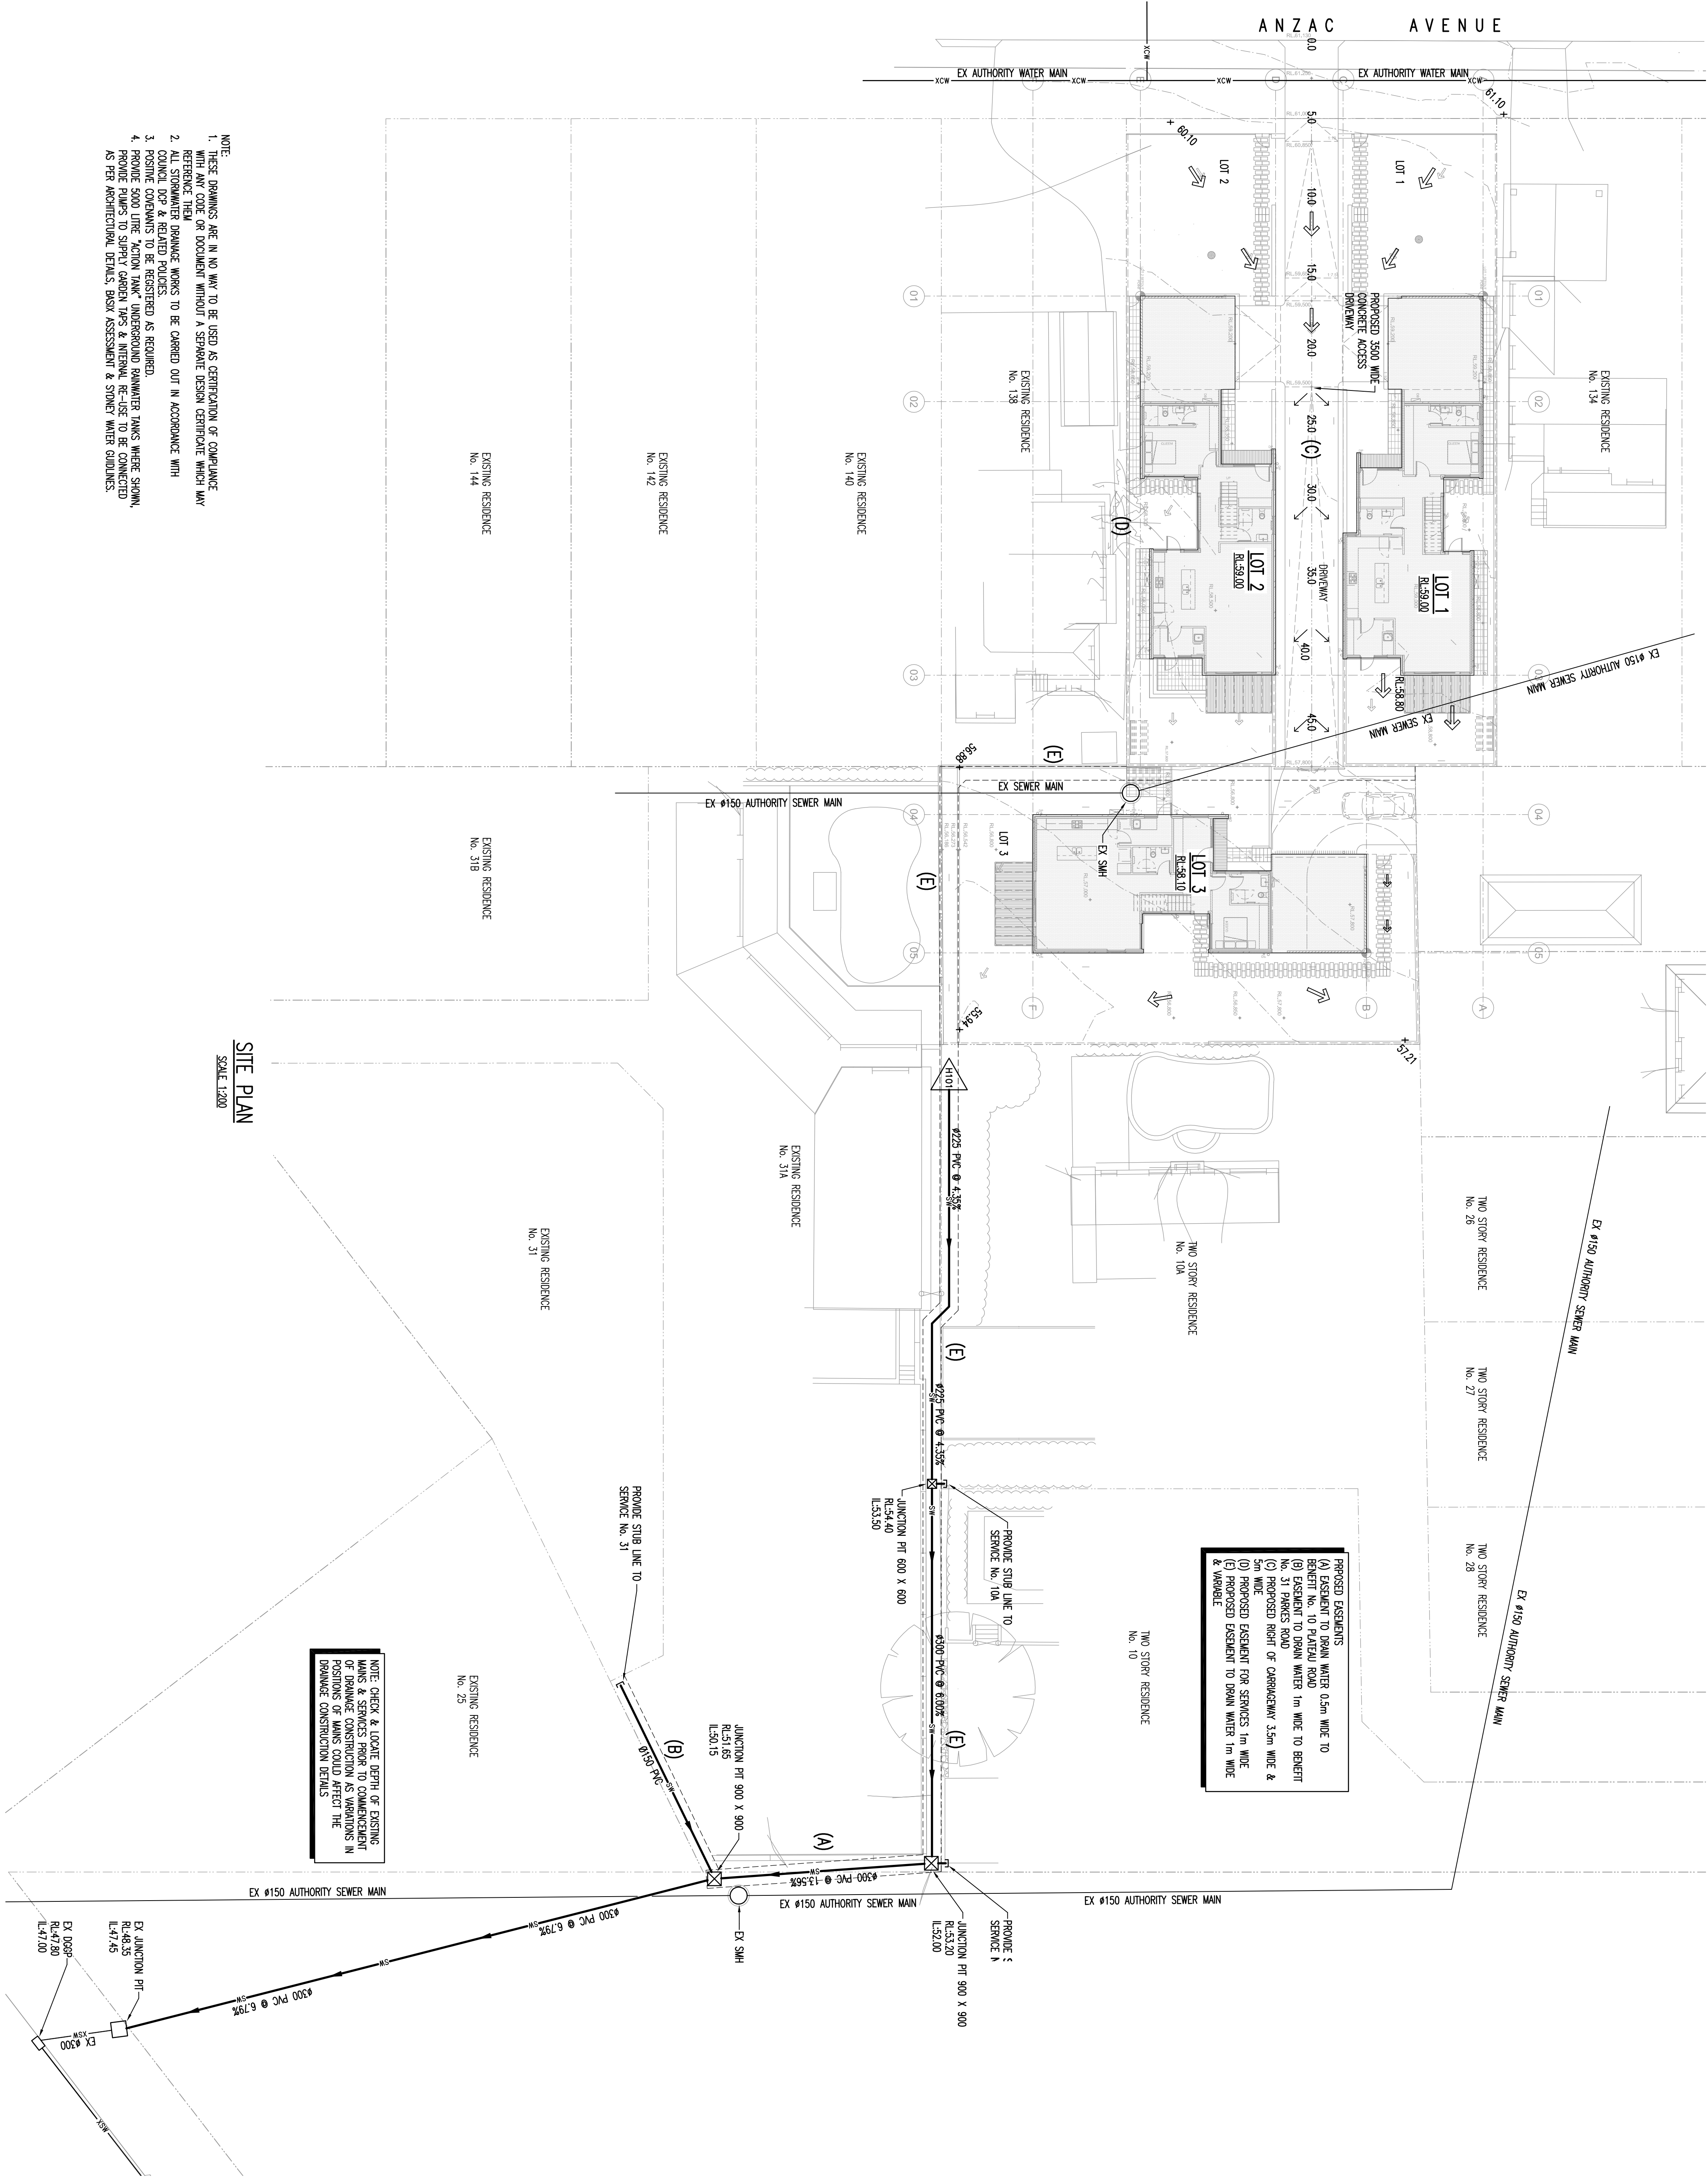

SITE PLAN
SCALE 1:200

- NOTE:
1. THESE DRAWINGS ARE IN NO WAY TO BE USED AS CERTIFICATION OF COMPLIANCE WITH ANY CODE OR DOCUMENT WITHOUT A SEPARATE DESIGN CERTIFICATE WHICH MAY REFERENCE THEM.
 2. ALL STORMWATER DRAINAGE WORKS TO BE CARRIED OUT IN ACCORDANCE WITH COUNCIL DCP & RELATED POLICIES.
 3. POSITIVE COVERS TO BE REGISTERED AS REQUIRED.
 4. PROVIDE 5000 LITRE "ACTION TANK" UNDERGROUND RAINWATER TANKS WHERE SHOWN. PROVIDE PUMPS TO SUPPLY GARDEN TAPS & INTERNAL RE-USE TO BE CONNECTED AS PER ARCHITECTURAL DETAILS, BASIX ASSESSMENT & STORMY WATER GUIDELINES.

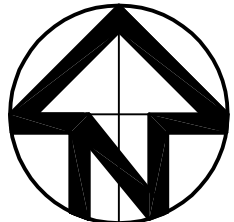

Rev. No.	Date	Revision	Author
A	11.02.21	TENDER ISSUE	GH
B	16.03.21	FOR CONSTRUCTION	GH
C	04.04.21	TENDER ISSUE	GH
D	19.09.23	RENDER ISSUE	GH


HYDRAULIC ENGINEER

GLENN HAIG & PARTNERS

ENERGY ASSESSOR

LANDSCAPE ARCHITECT

CLIENT
GEORGE TSVIS

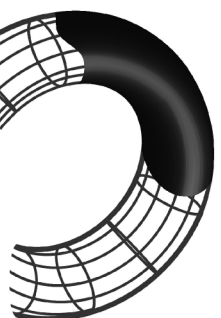

GLENN HAIG & PARTNERS

Hydraulic & Fire Consultants

7/70 First Avenue
Surrey Hills NSW 2162
E-mail: office@glennhaig.com.au
Phone: (02) 6658 2444
Fax: (02) 6658 2455
Mobile: 0413 308 660



www.quattrodesign.com.au

Quattro Design Pty Limited
ACN 094 615 853

Sydney 61 2 9899 9881
Studio Level 1, 55 Buckingham Street
Surrey Hills NSW 2010
Canberra 61 6251 2016
Suite 2, Level 1, 53 Bowman Street
PO Box 816 Macquarie ACT 2614

PROPOSED NEW HOUSES 136 ANZAC AVENUE COLLAROY NSW

Drawing title


SITE /GROUND FLOOR PLAN DRAINAGE SERVICES

Scale as A1 1:100
Scale as A3 1:200

Figured dimensions shall take precedence over words. Contractors must verify all dimensions on job before commencing any work or making shop drawings.

File: Y:\Projects\101726\Drawing Files\101726-H101


Project Number
101726
Drawing Number
H-101
Rev
D

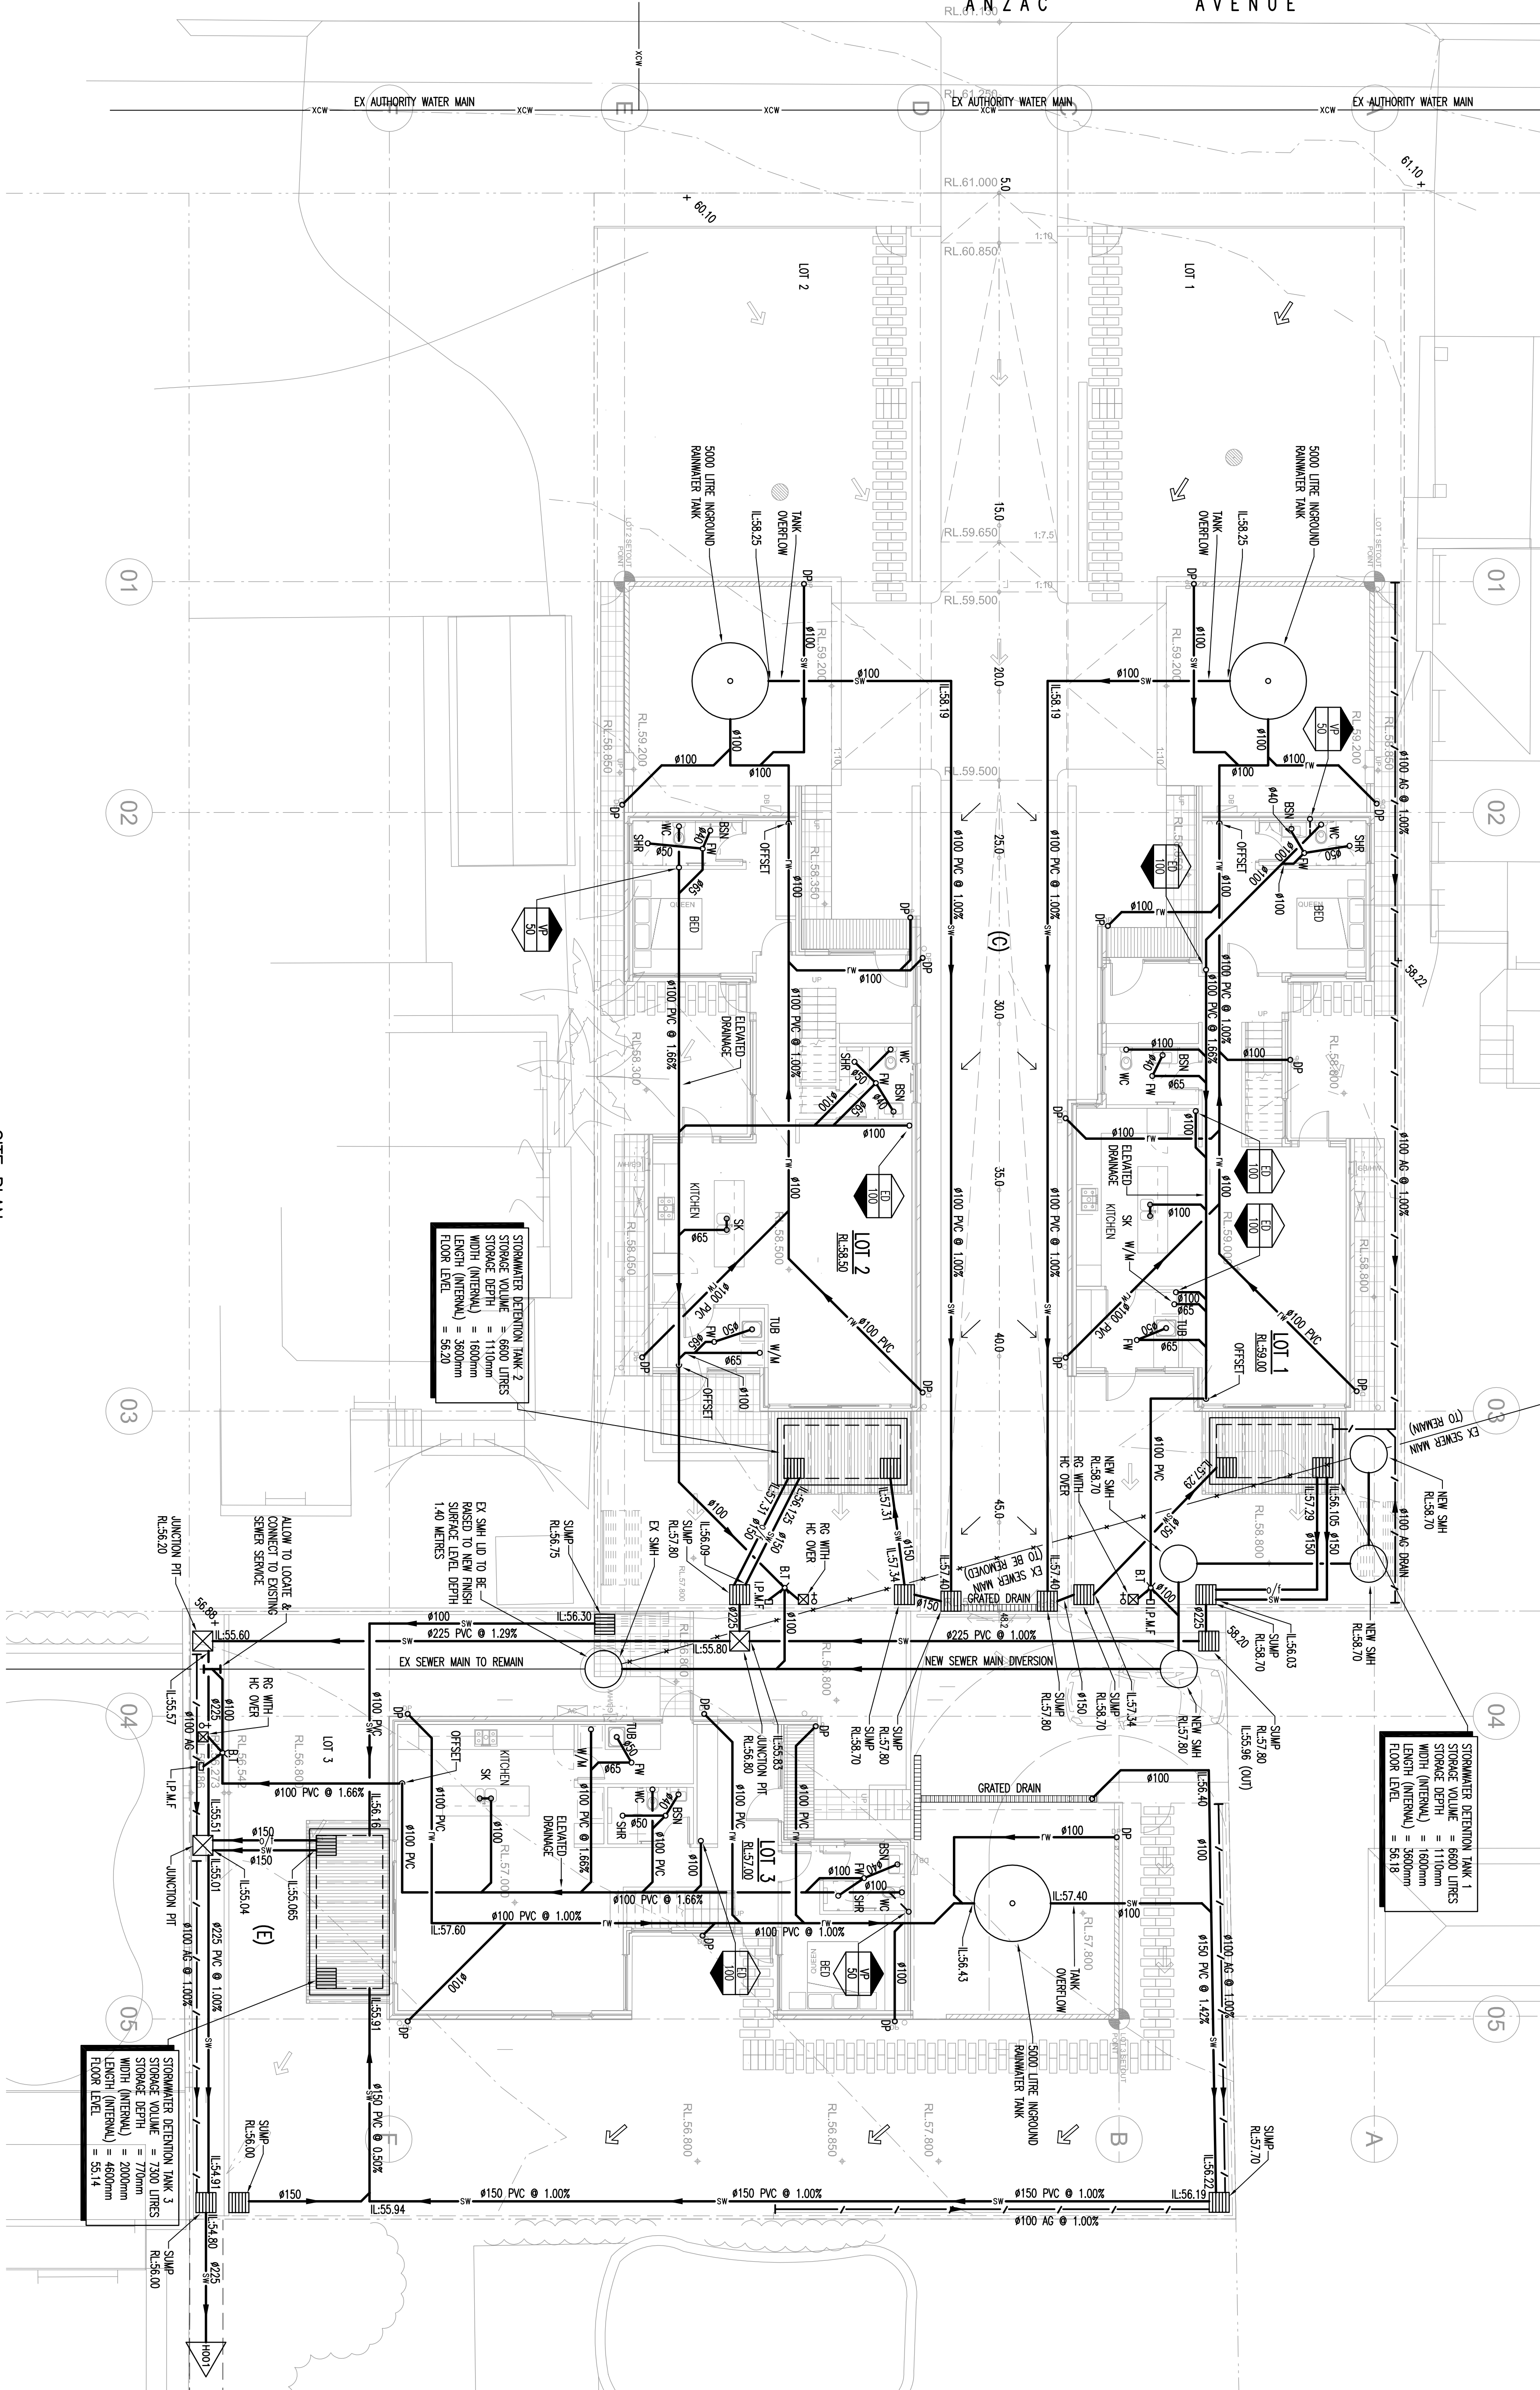

- NOTE:
1. THESE DRAWINGS ARE IN NO WAY TO BE USED AS CERTIFICATION OF COMPLIANCE WITH ANY CODE OR DOCUMENT WITHOUT A SEPARATE DESIGN CERTIFICATE WHICH MAY REFERENCE THEM
 2. ALL STORMWATER DRAINAGE WORKS TO BE CARRIED OUT IN ACCORDANCE WITH COUNCIL DCP & RELATED POLICIES
 3. POSITIVE COVENANTS TO BE REGISTERED AS REQUIRED.
 4. PROVIDE 5000 LITRE 'THAMES RAINBARD SYSTEM' UNDERGROUND RAINWATER TANKS WHERE SHOWN. PROVIDE PUMPS TO SUPPLY GARDEN TAPS & INTERNAL RE-USE TO BE CONNECTED AS PER ARCHITECTURAL DETAILS, BASIX ASSESSMENT & STONEY WATER GUIDELINES.

SITE PLAN

SCALE 1:100

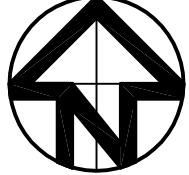


Rev. No.	Date	Revision	Author
A	15.02.11	TENDER ISSUE	GH
B	16.03.11	FOR CONSTRUCTION	GH
C	04.04.11	CERTIFICATE	GH
D	19.05.13	RENDER ISSUE	GH

HYDRAULIC ENGINEER
GLENN HAIG & PARTNERS
ENERGY ASSESSOR

LANDSCAPE ARCHITECT

CLIENT
GEORGE TSIVIS

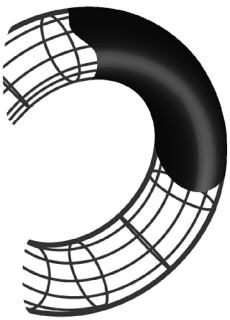

GLENN HAIG
& Partners

 
Hydraulic + Fire Consultants
7/70 First Avenue
Surrey Hills NSW 2152
E-mail: office@gehnhg.com.au
Phone: (02) 6658 2444
Fax: (02) 6658 2455
Mobile: 0413 308 660



www.quattrodesign.com.au
Quattro Design Pty Limited
ACN 094 615 853
Sydney 61 2 9639 9881
Studio / Level 1, 53 Buckingham Street
Surrey Hills NSW 2010
Canberra 61 6251 2016
Suite 2, Level 1, 53 Bowman Street
PO Box 816 Macquarie ACT 2614

Project
PROPOSED NEW HOUSES
136 ANZAC AVENUE
COLLARROY NSW


Drawing title
LEVEL 1 FLOOR PLAN
DRAINAGE SERVICES



Figured dimensions shall take precedence over words. Contractors must verify all dimensions on site before commencing any work or making shop drawings.

File: Y:\Projects\101726\Drawing Files\101726-H102

Drawn By
GH/HB
Checked By
DH
Project Number
101726 H-102
Drawing Number
D

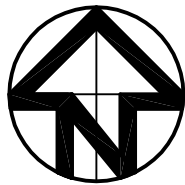

Rev. No.	Date	Revision	Amended
A	11.02.11	TENDER ISSUE	GH
B	16.03.11	FOR CONSTRUCTION	GH
C	04.04.11	CERTIFICATE	GH
D	19.05.13	RENDER ISSUE	GH


HYDRAULIC ENGINEER
GLENN HAIG & PARTNERS

ENERGY ASSESSOR

LANDSCAPE ARCHITECT

CLIENT

GEORGE TSIVIS

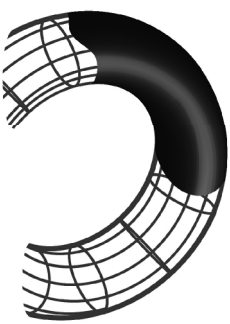

GLENN HAIG
& Partners

Hydraulic + Fire Consultants

7/70 First Avenue
Smyth NSW 2162
E-mail: office@glennhaig.com.au
Phone: (02) 6658 2444
Fax: (02) 6658 2455
Mobile: 0413 308 660



www.quattrodesign.com.au

Quattro Design Pty Limited
ACN 094 615 863

Sydney 61 2 9839 9881
Studio / Level 1, 35 Buckingham Street
Smyth NSW 2010
Canberra 61 6251 2016
Suite 2, Level 1, 53 Bowman Street
PO Box 816 Macquarie ACT 2614

Project

PROPOSED NEW HOUSES
136 ANZAC AVENUE
COLLAROY NSW

Drawing title

ROOF PLAN

Scale as A1 1:100
Scale as A3 1:200


Figured dimensions shall take precedence over words. Contractors must verify all dimensions on job before commencing any work or making shop drawings.

Y:\Projects\101726\Drawing Files\101726-H103

Drawn By
Checked By
Project Number
Drawing Number

101726 H-103 D

This drawing is protected by copyright.

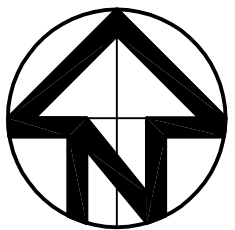

Rev. No.	Date	Revision	Author
A	11.02.11	TENDER ISSUE	GH
B	16.03.11	FOR CONSTRUCTION	GH
C	04.04.11	CERTIFICATE	GH
D	19.05.13	TENDER ISSUE	GH


HYDRAULIC ENGINEER

GLENN HAIG & PARTNERS

ENERGY ASSESSOR

LANDSCAPE ARCHITECT

CLIENT
GEORGE TSVIS

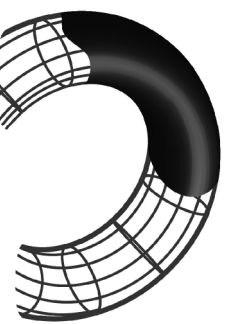

GLENN HAIG & PARTNERS

Hydraulic + Fire Consultants

7/70 Trail Avenue
Surrey Hills NSW 2152
E-mail: office@glennhaig.com.au
Phone: (02) 6658 2444
Fax: (02) 6658 2455
Mobile: 041 3 308 660



www.quattrodesign.com.au

Quattro Design Pty Limited
ACN 094 615 853

Sydney 61 2 9839 9881
Studio Level 1, 53 Buckingham Street
Surrey Hills NSW 2010
Canberra 61 6251 2016
Suite 2, Level 1, 53 Bowman Street
PO Box 816 Macquarie ACT 2614

Project
PROPOSED NEW HOUSES
136 ANZAC AVENUE
COLLAROY NSW

Drawing title
SITE /GROUND FLOOR PLAN
WATER & GAS RETICULATION

Scale as A1 1:100
Scale as A3 1:200

Figured dimensions shall take precedence over words. Contractors must verify all dimensions on job before commencing any work or making shop drawings.

This drawing is the property of Quattro Design Pty Limited. It is to be used for the project only and is not to be reproduced or used for any other purpose without the written consent of Quattro Design Pty Limited.

Y:\Projects\101726\Drawing Files\101726-H201


Drawn By
GH/UD

Checked By
DH

Project Number
101726


Drawing Number
H-201

Rev
D

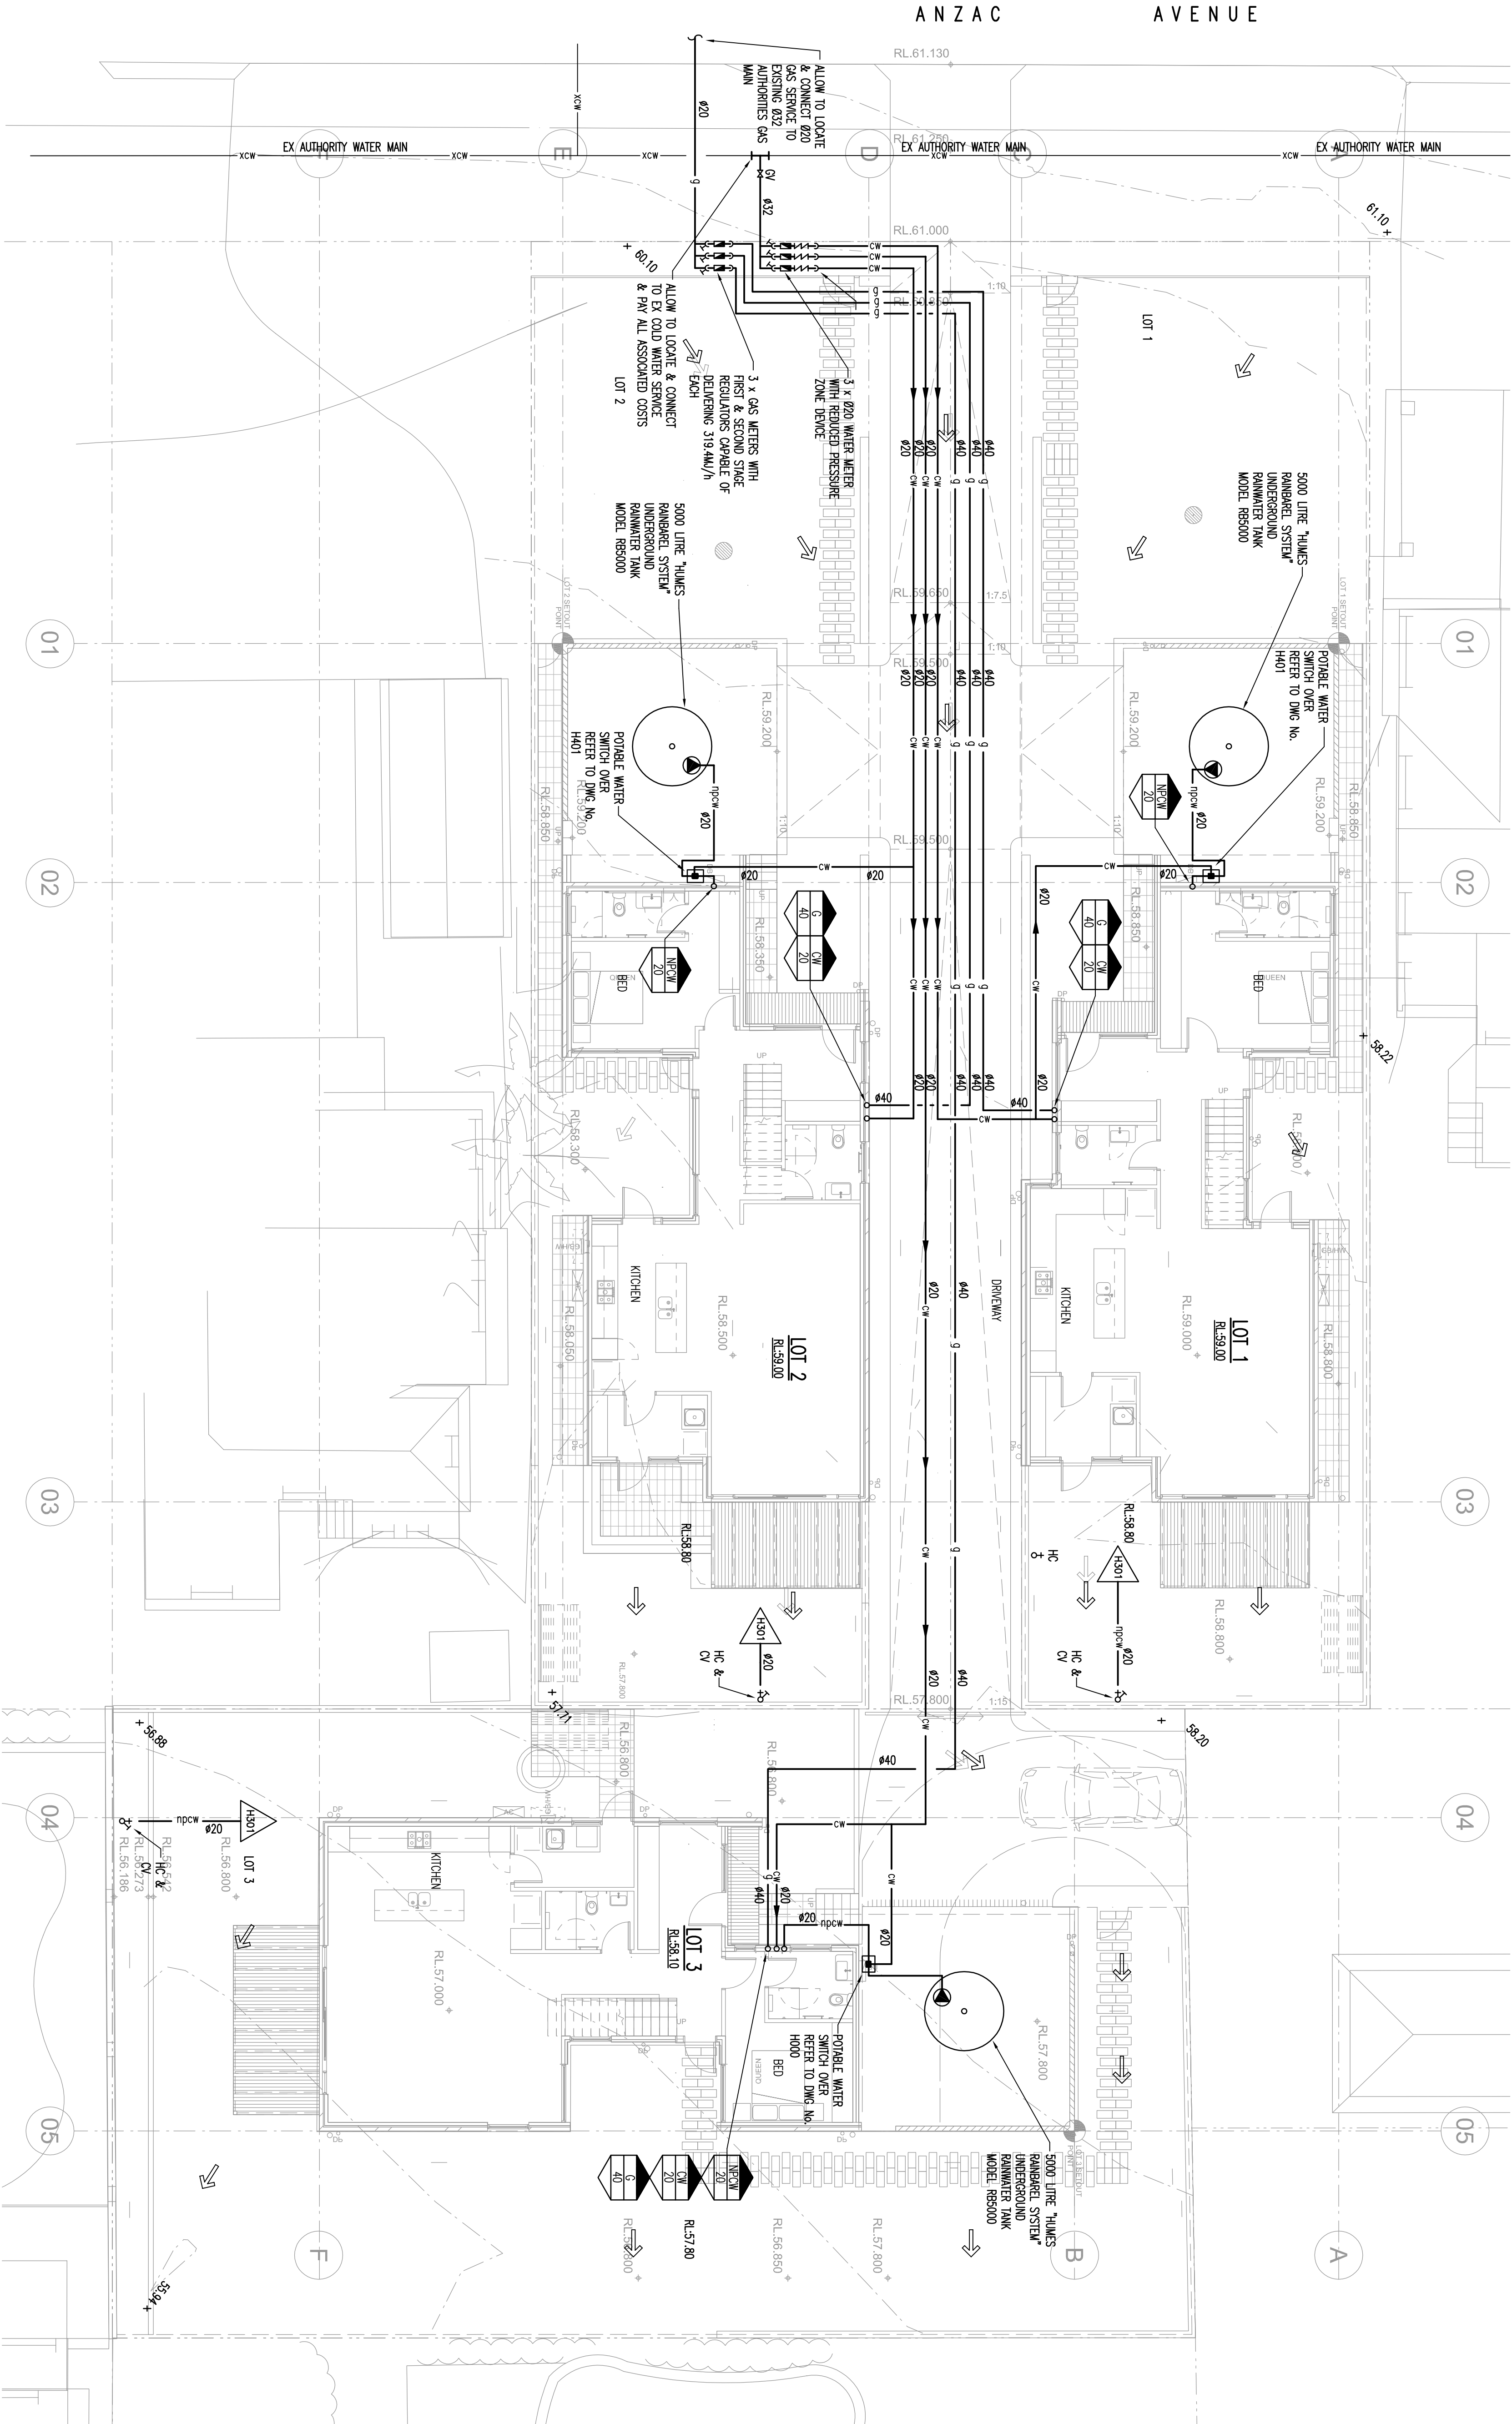

SITE PLAN
SCALE 1:100

- NOTE:
1. THESE DRAWINGS ARE IN NO WAY TO BE USED AS CERTIFICATION OF COMPLIANCE WITH ANY CODE OR DOCUMENT WITHOUT A SEPARATE DESIGN CERTIFICATE WHICH MAY BE OBTAINED FROM THE LOCAL COUNCIL.
 2. POSITIVE COMMENTS TO BE REGISTERED AS REQUIRED.
 3. WHERE 5000 LITRE 'HUMES' RAINWATER TANKS ARE USED, THE TANKS MUST BE CONNECTED TO THE EXISTING WATER MAINS AS PER ARCHITECTURAL DETAILS, BSNV ASSESSMENT & STONES WATER GUIDELINES.

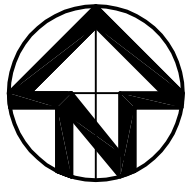


Rev. No.	Date	Revision	Amend
A	11.02.11	TENDER ISSUE	
B	16.03.11	FOR CONSTRUCTION	GH
C	04.04.11	CERTIFICATE	GH
D	19.09.13	TENDER ISSUE	GH

HYDRAULIC ENGINEER
GLENN HAIG & PARTNERS

ENERGY ASSESSOR

LANDSCAPE ARCHITECT

CLIENT
GEORGE TSIVIS

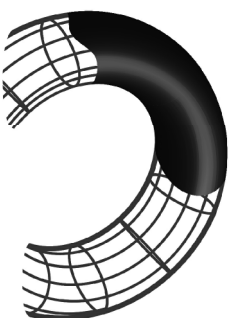

GLENN HAIG
& Partners

Hydraulic + Fire Consultants
7/70 First Avenue
Surrey Hills NSW 2152
E-mail: office@gehnng.com.au
Phone: (02) 6658 2444
Fax: (02) 6658 2455
Mobile: 0413 308 660



www.quattrodigital.com.au
Quattro Design Pty Limited
ACN 094 615 853
Sydney 61 2 9839 9881
Studio Level 1, 35 Buckingham Street
Surrey Hills NSW 2010
Canberra 61 6251 2016
Suite 2, Level 1, 53 Bowman Street
PO Box 816 Macquarie ACT 2614


Project
PROPOSED NEW HOUSES
136 ANZAC AVENUE
COLLAROY NSW

Drawing title
LEVEL 1
HOT & COLD WATER DETAILS


Scale as A1 1:50
Scale as A3 1:100
0m 1m 2m 3m 4m 5m 6m 7m 8m 9m 10m

Y:\Projects\101726\Drawing Files\101726-H302
Drawn By
Checked By
Project Number
Drawing Number
Rev
101726 H-302 D


This drawing is protected by copyright.

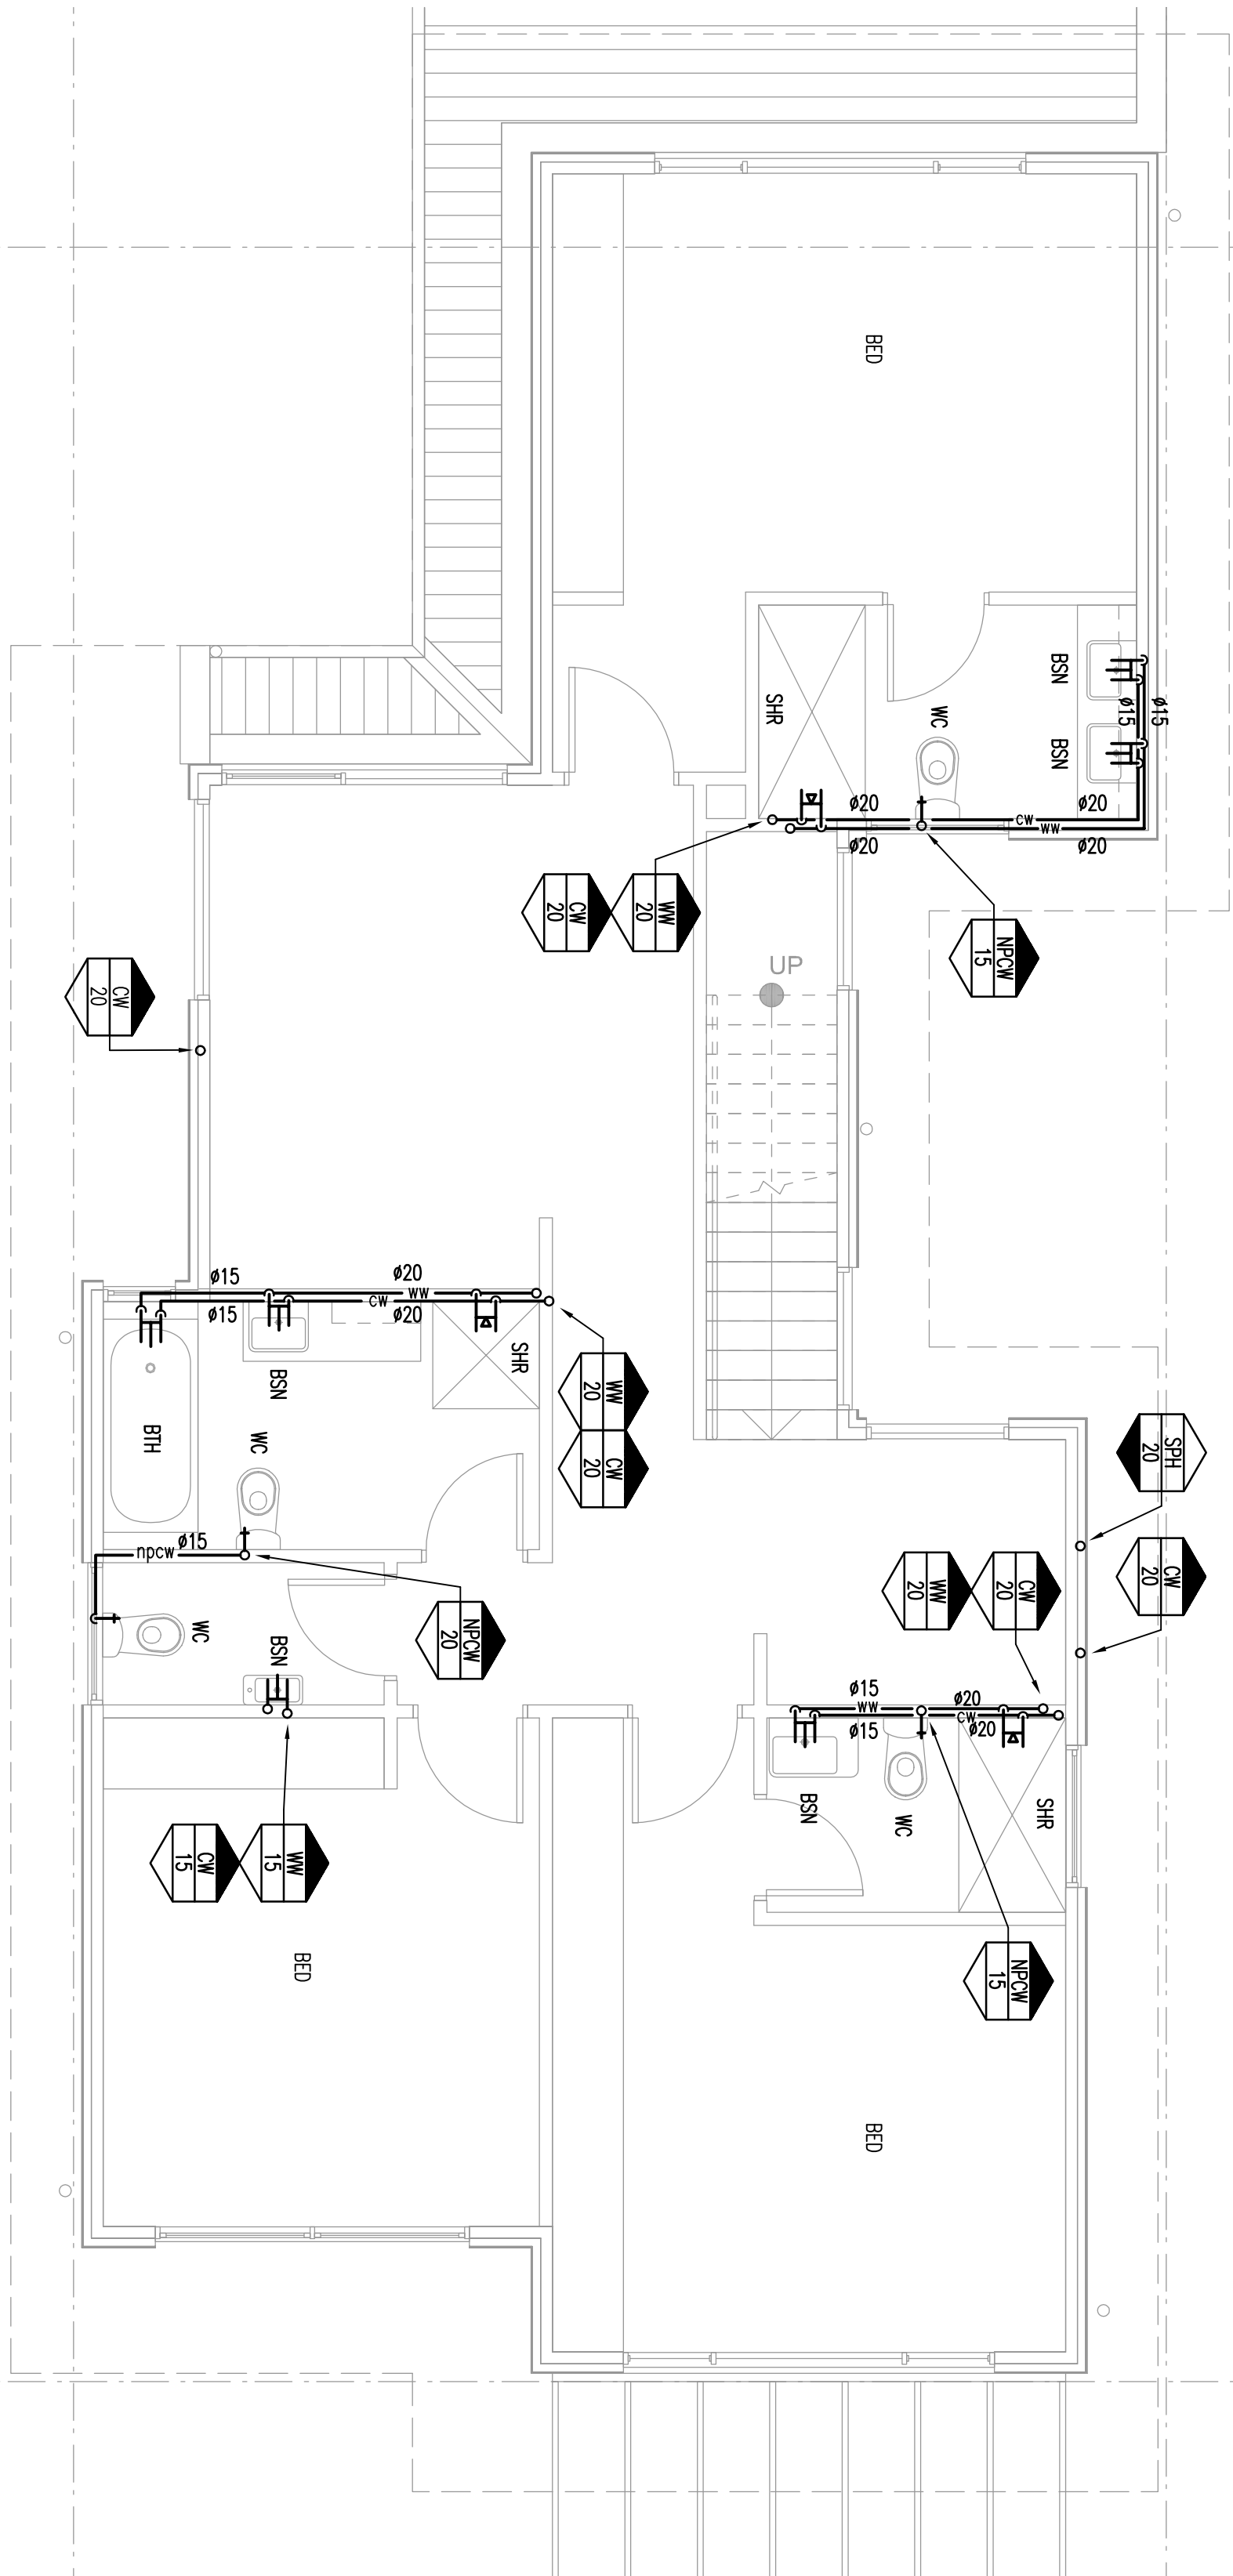


LOT 1 FIRST FLOOR
HOT & COLD WATER DETAILS
SCALE:1:50

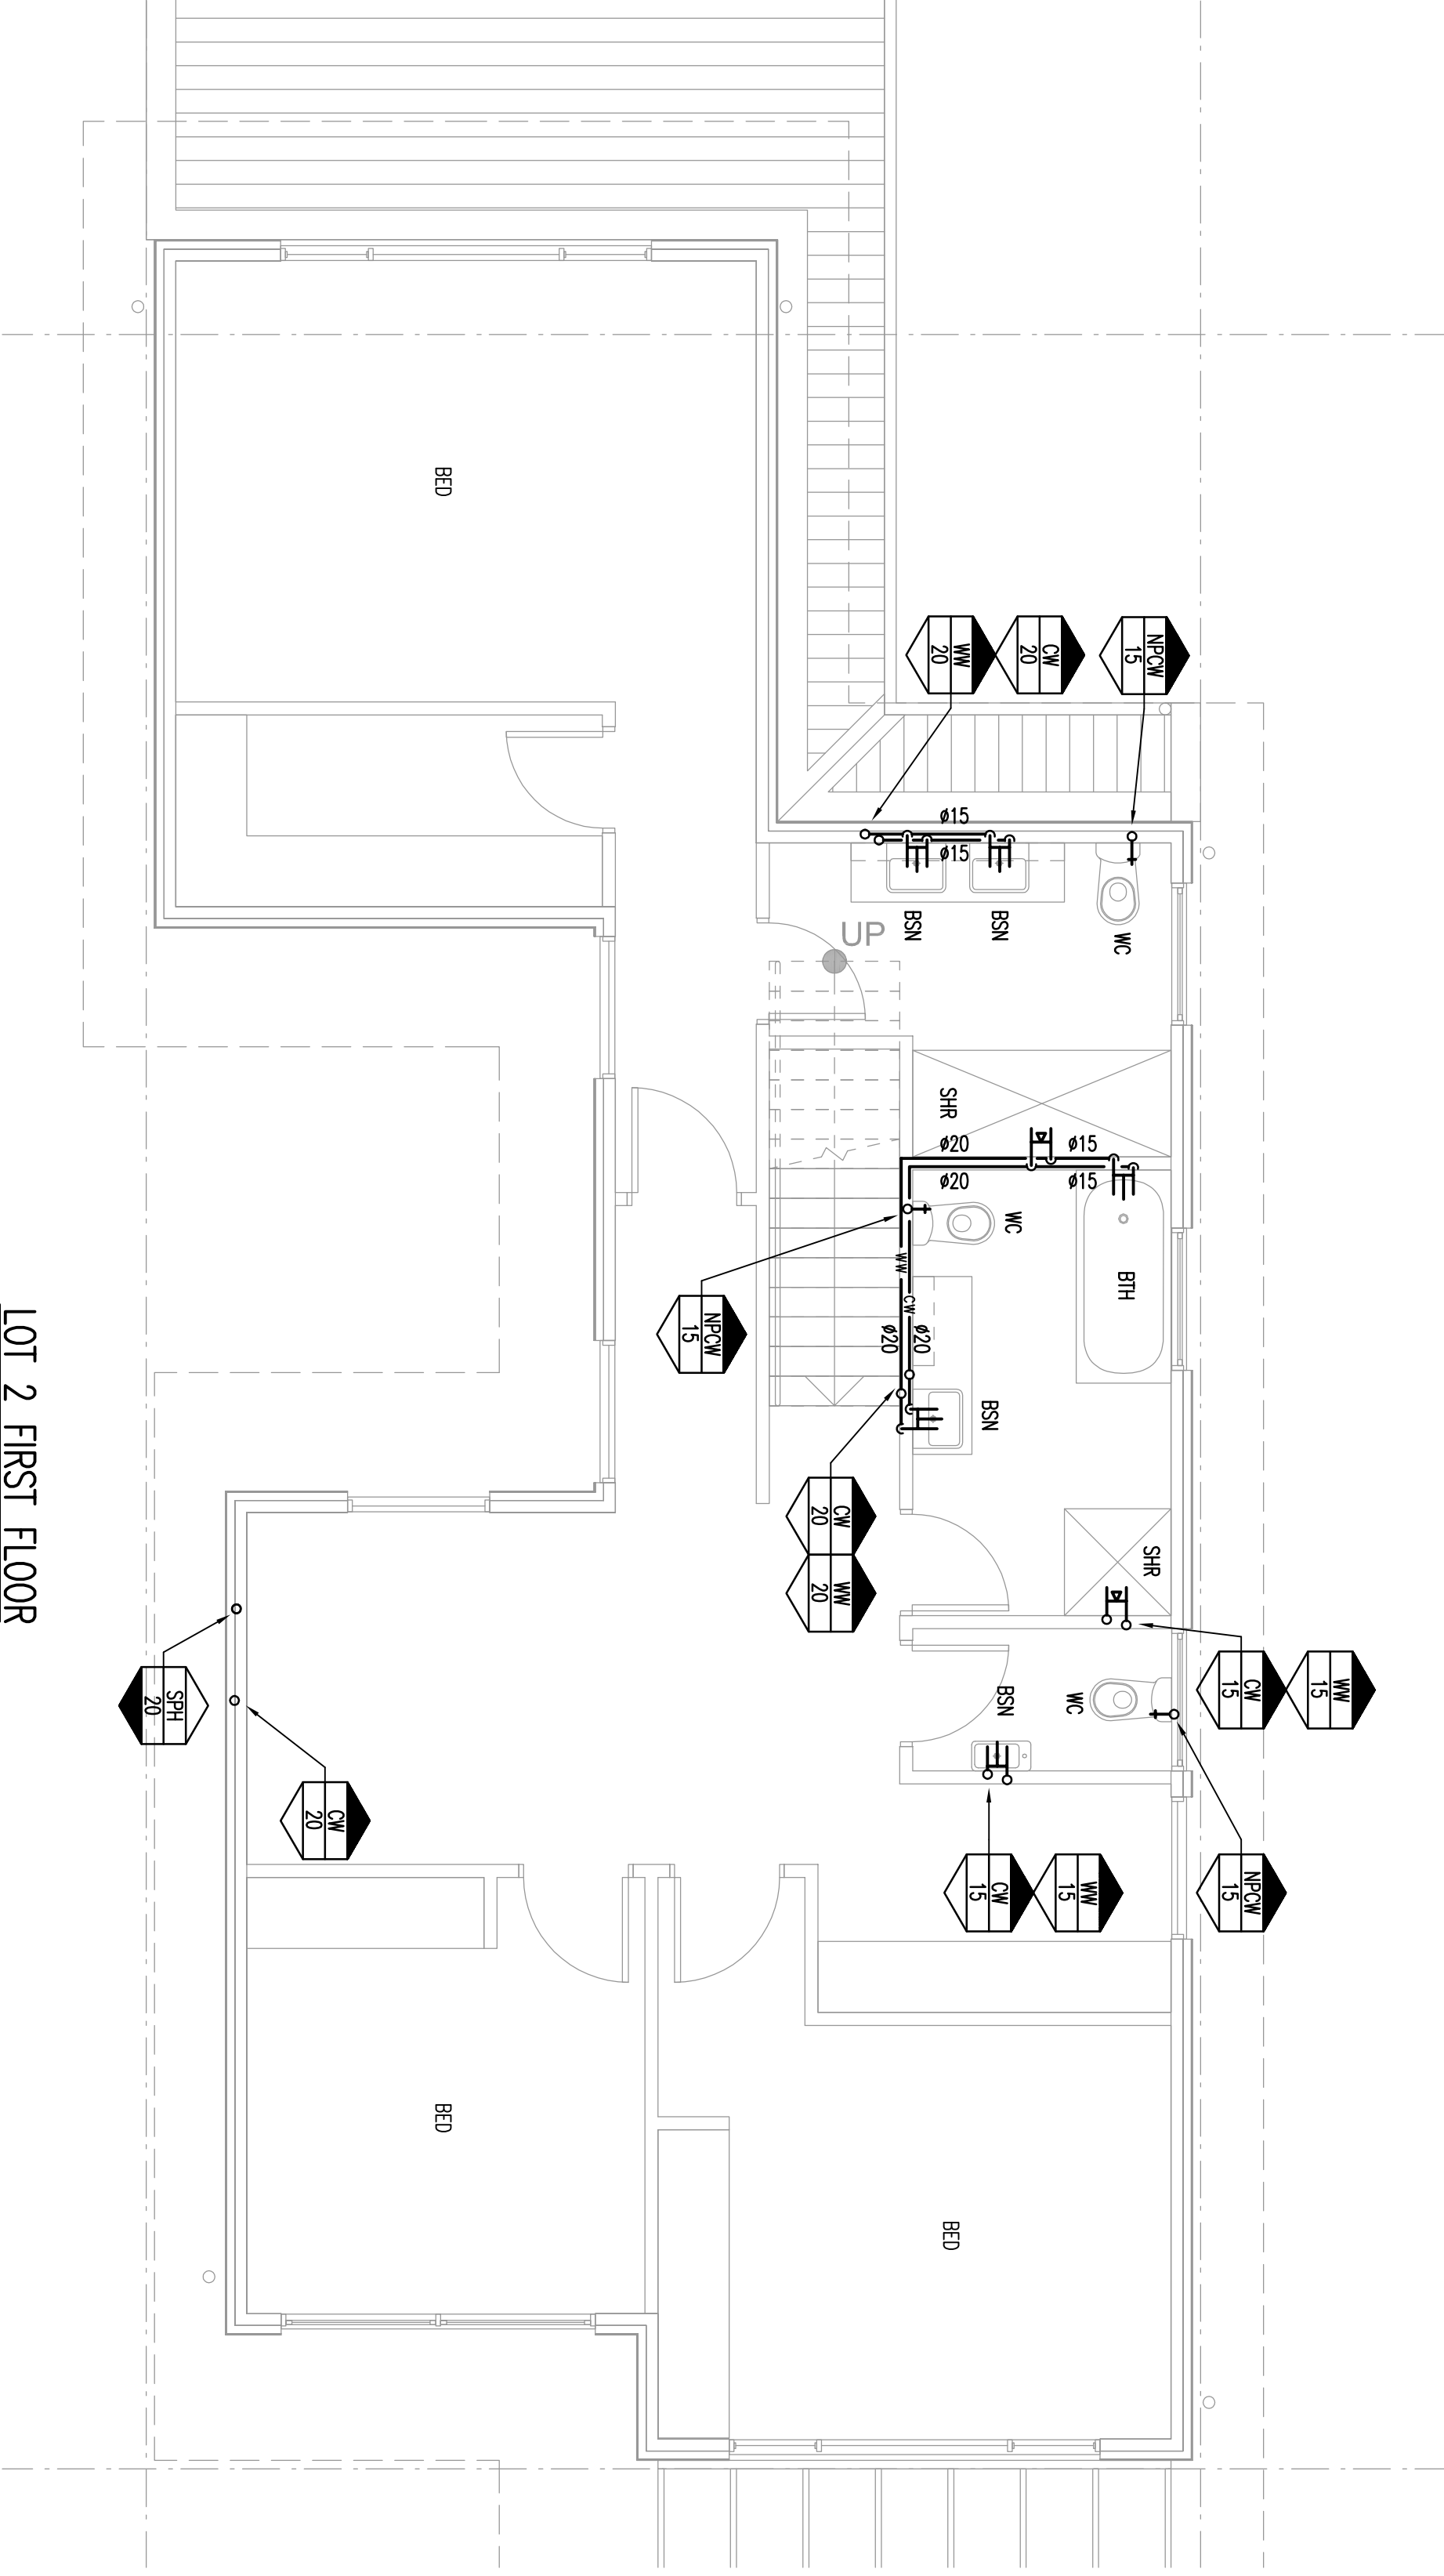

LOT 2 FIRST FLOOR
HOT & COLD WATER DETAILS
SCALE:1:50

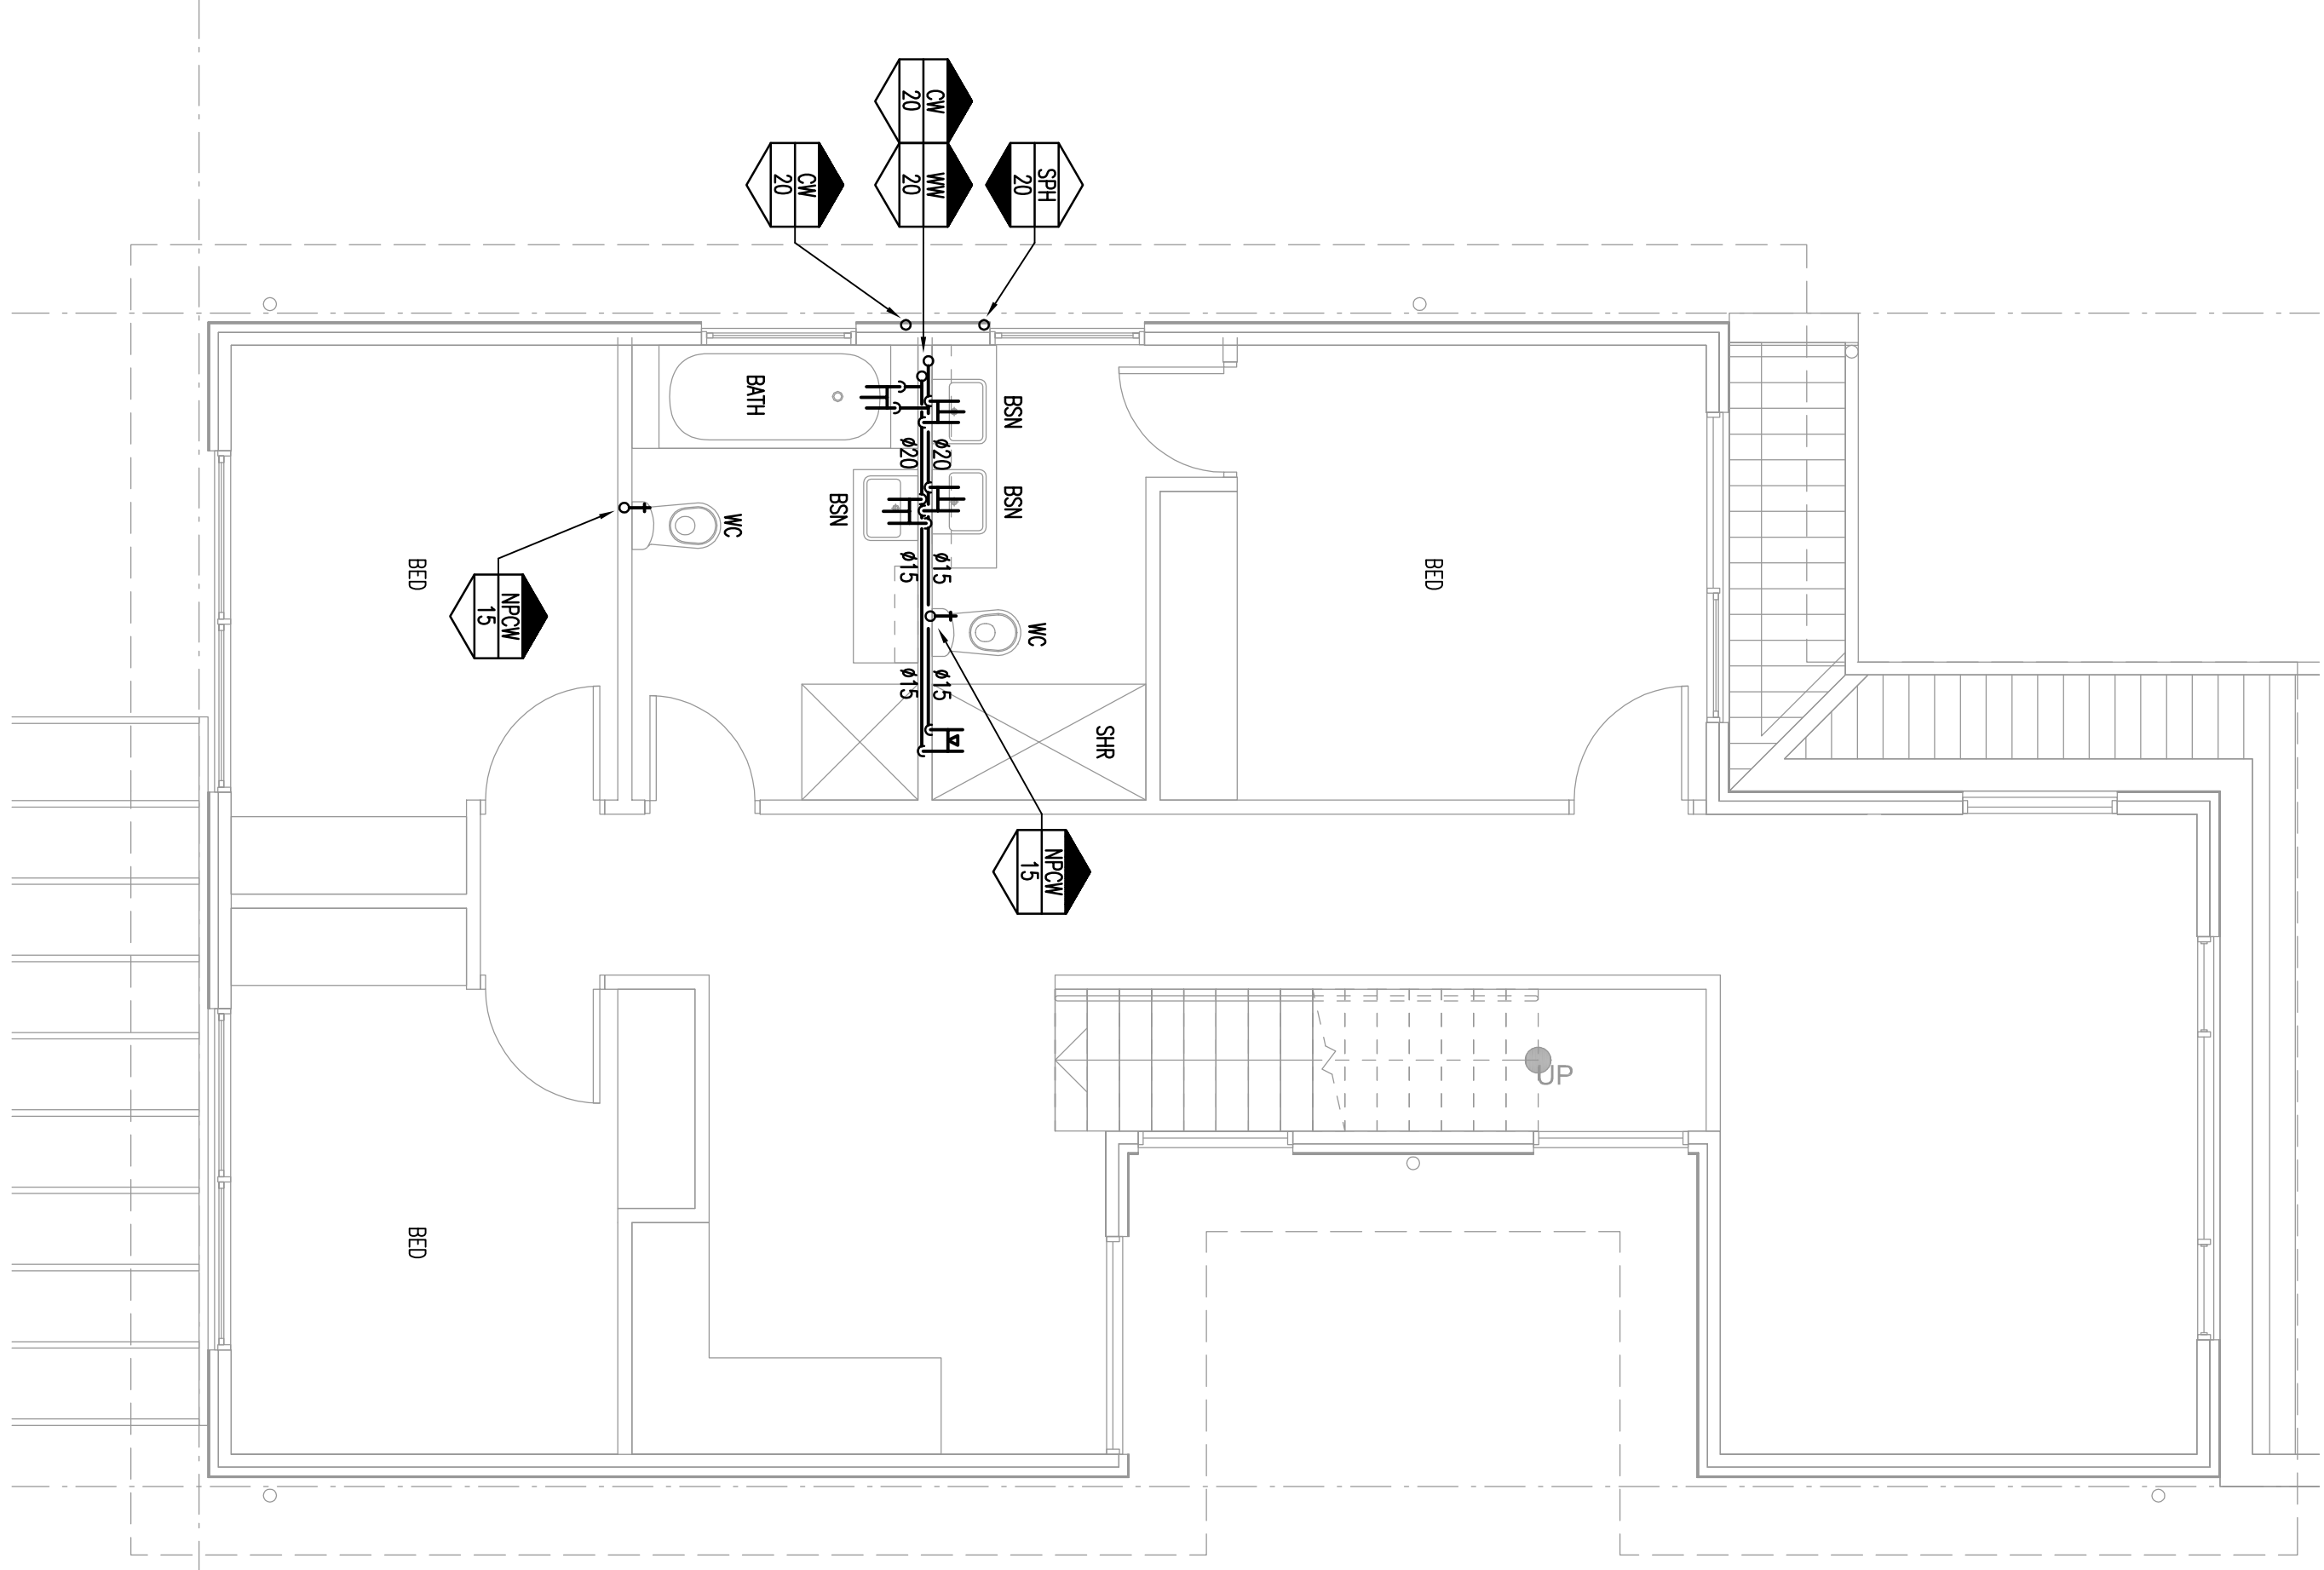


LOT 3 FIRST FLOOR
HOT & COLD WATER DETAILS
SCALE:1:50

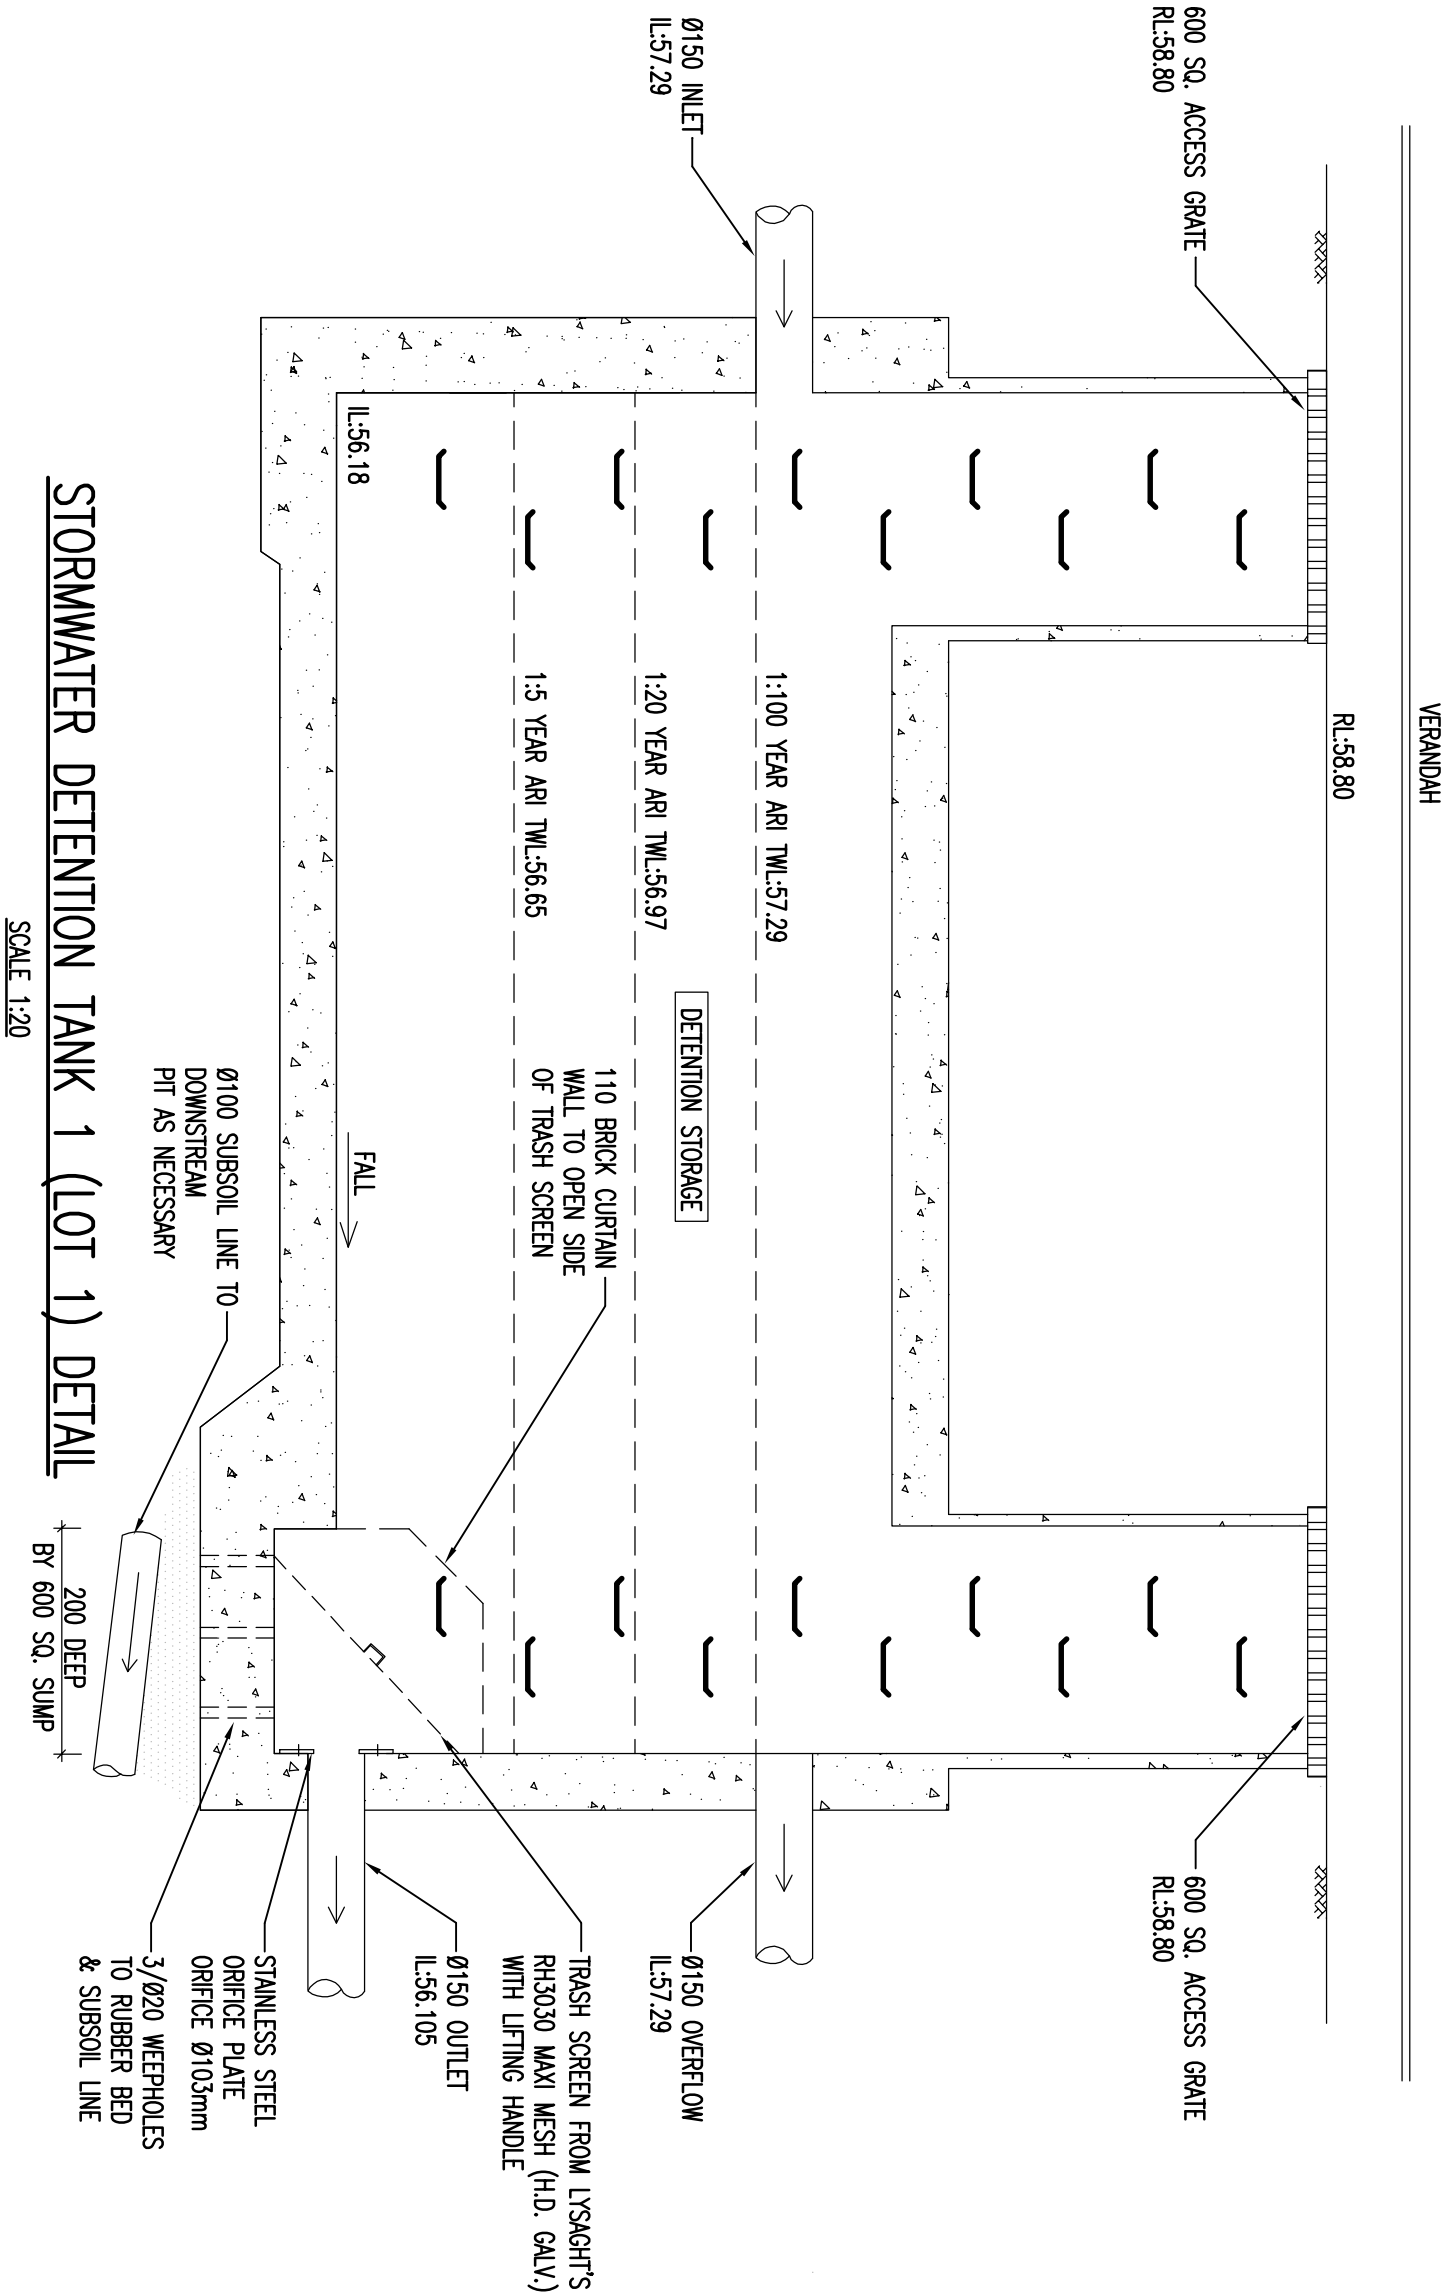


SCALE 1:20

STORMWATER DETENTION TANK 1 (LOT 1) DETAIL

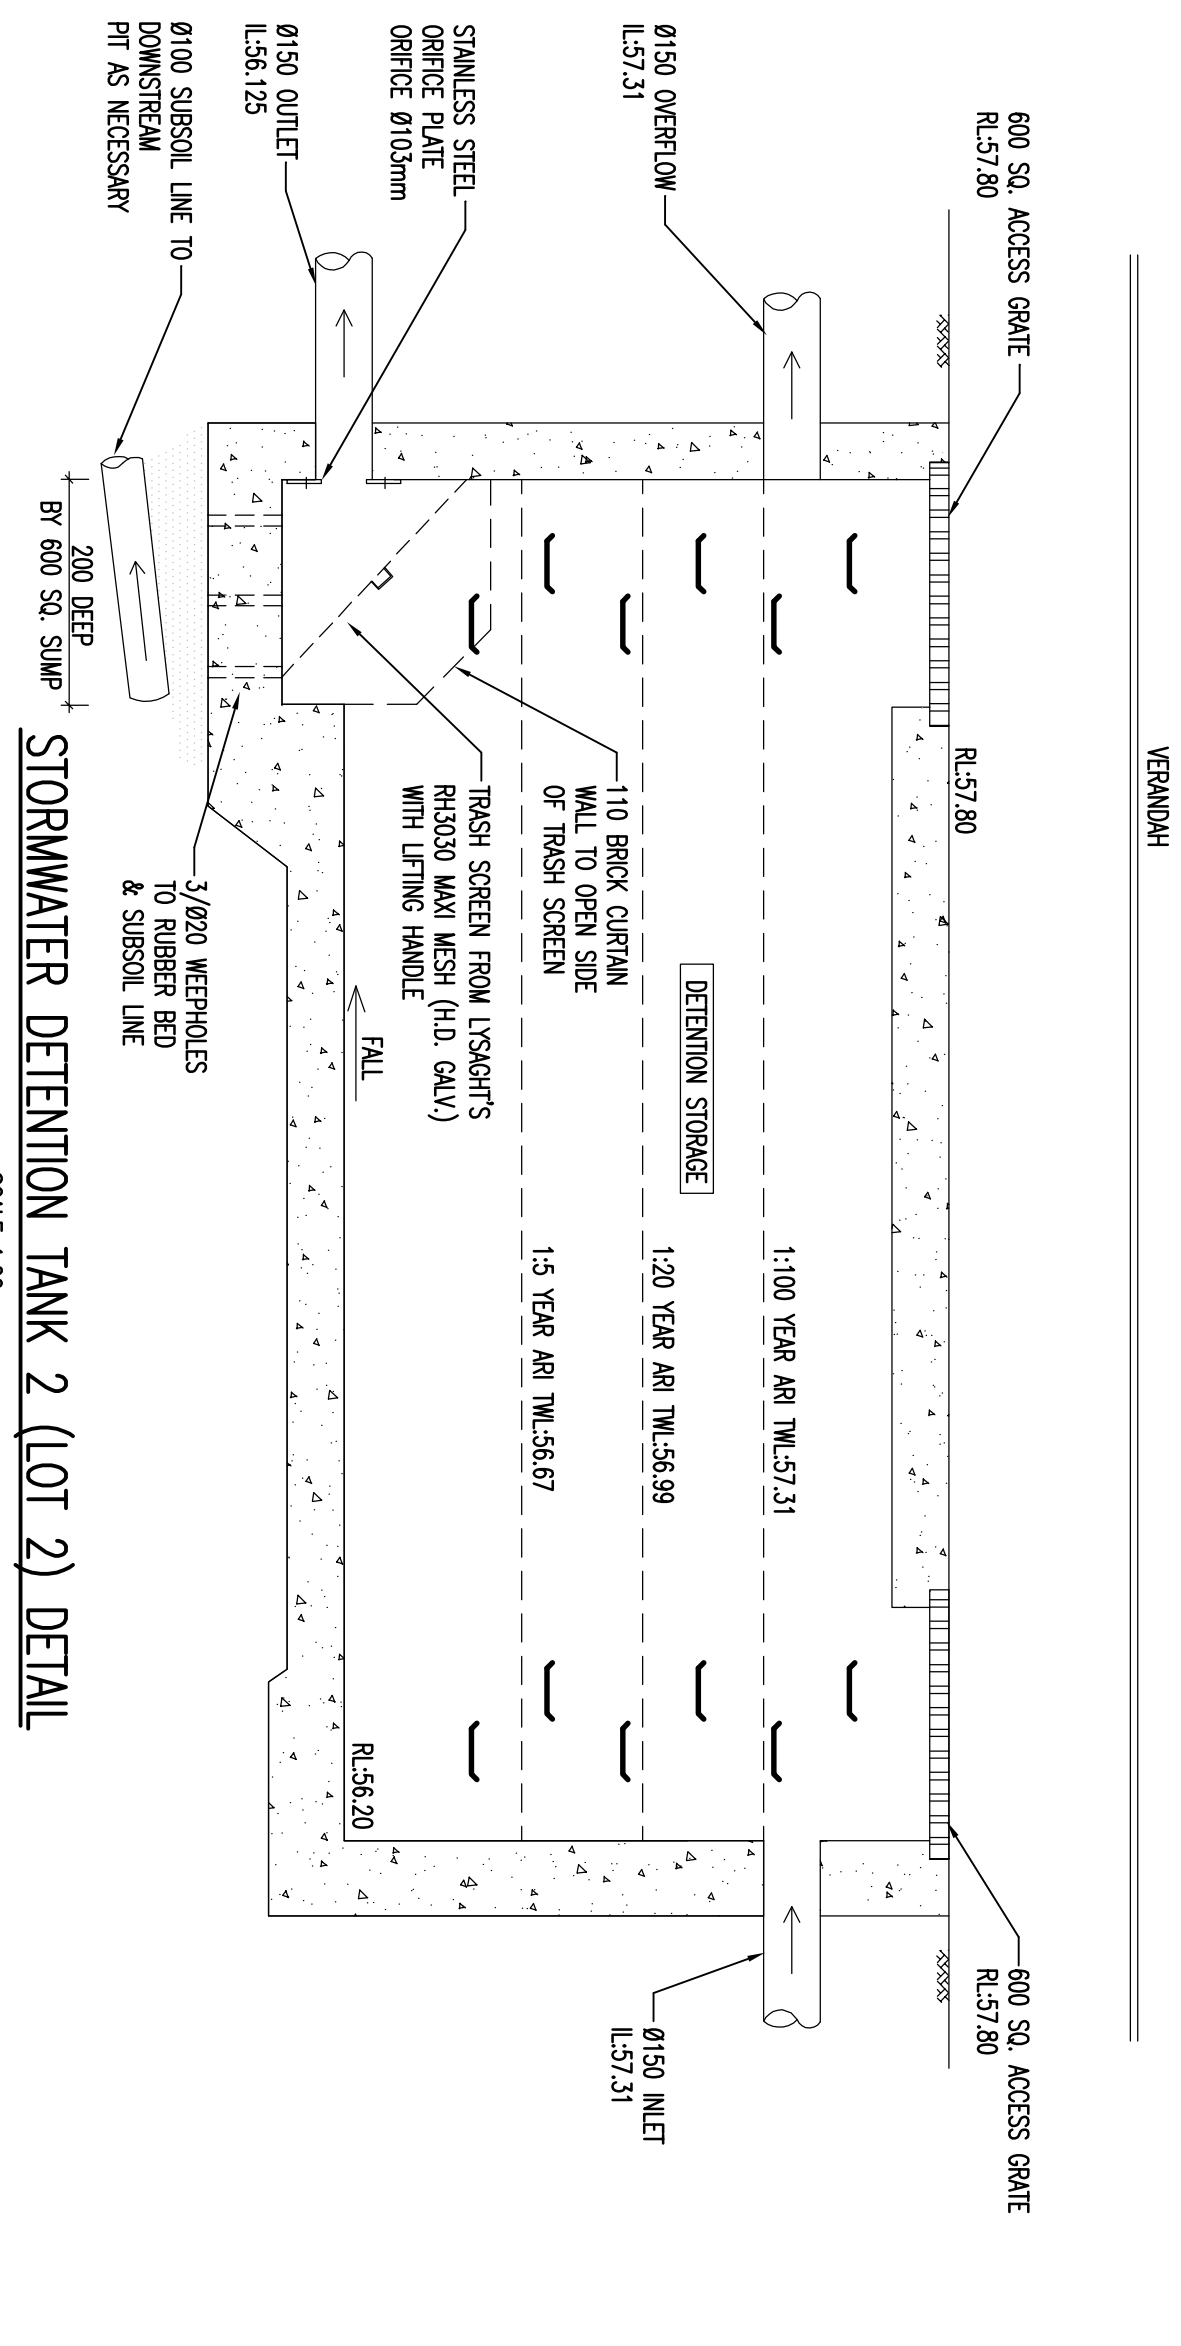


SCALE 1:20

STORMWATER DETENTION TANK 2 (LOT 2) DETAIL

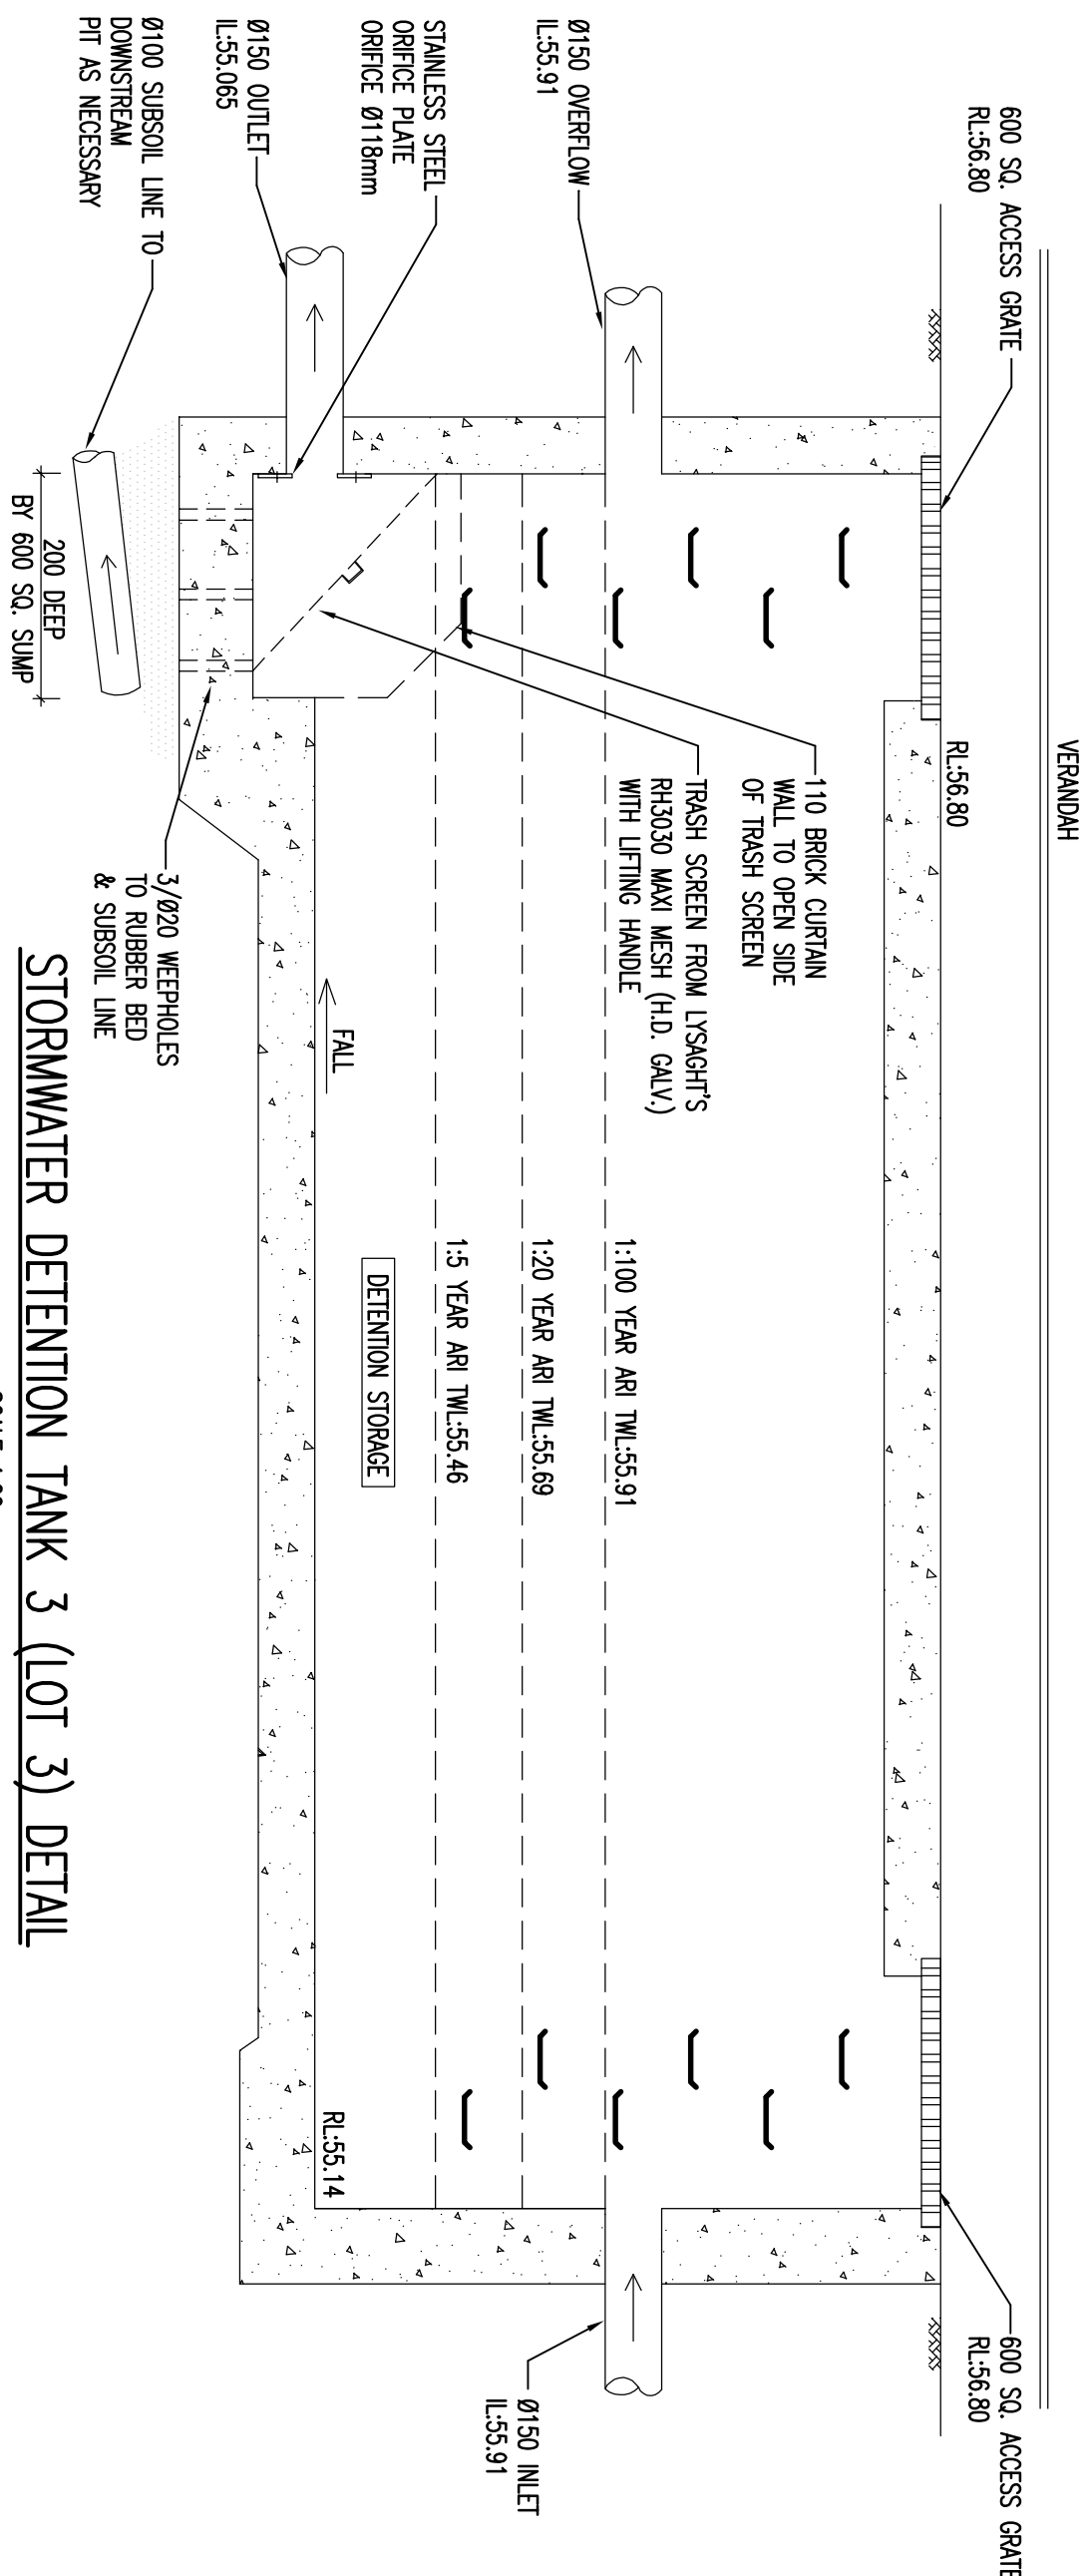



SCALE 1:20

STORMWATER DETENTION TANK 3 (LOT 3) DETAIL

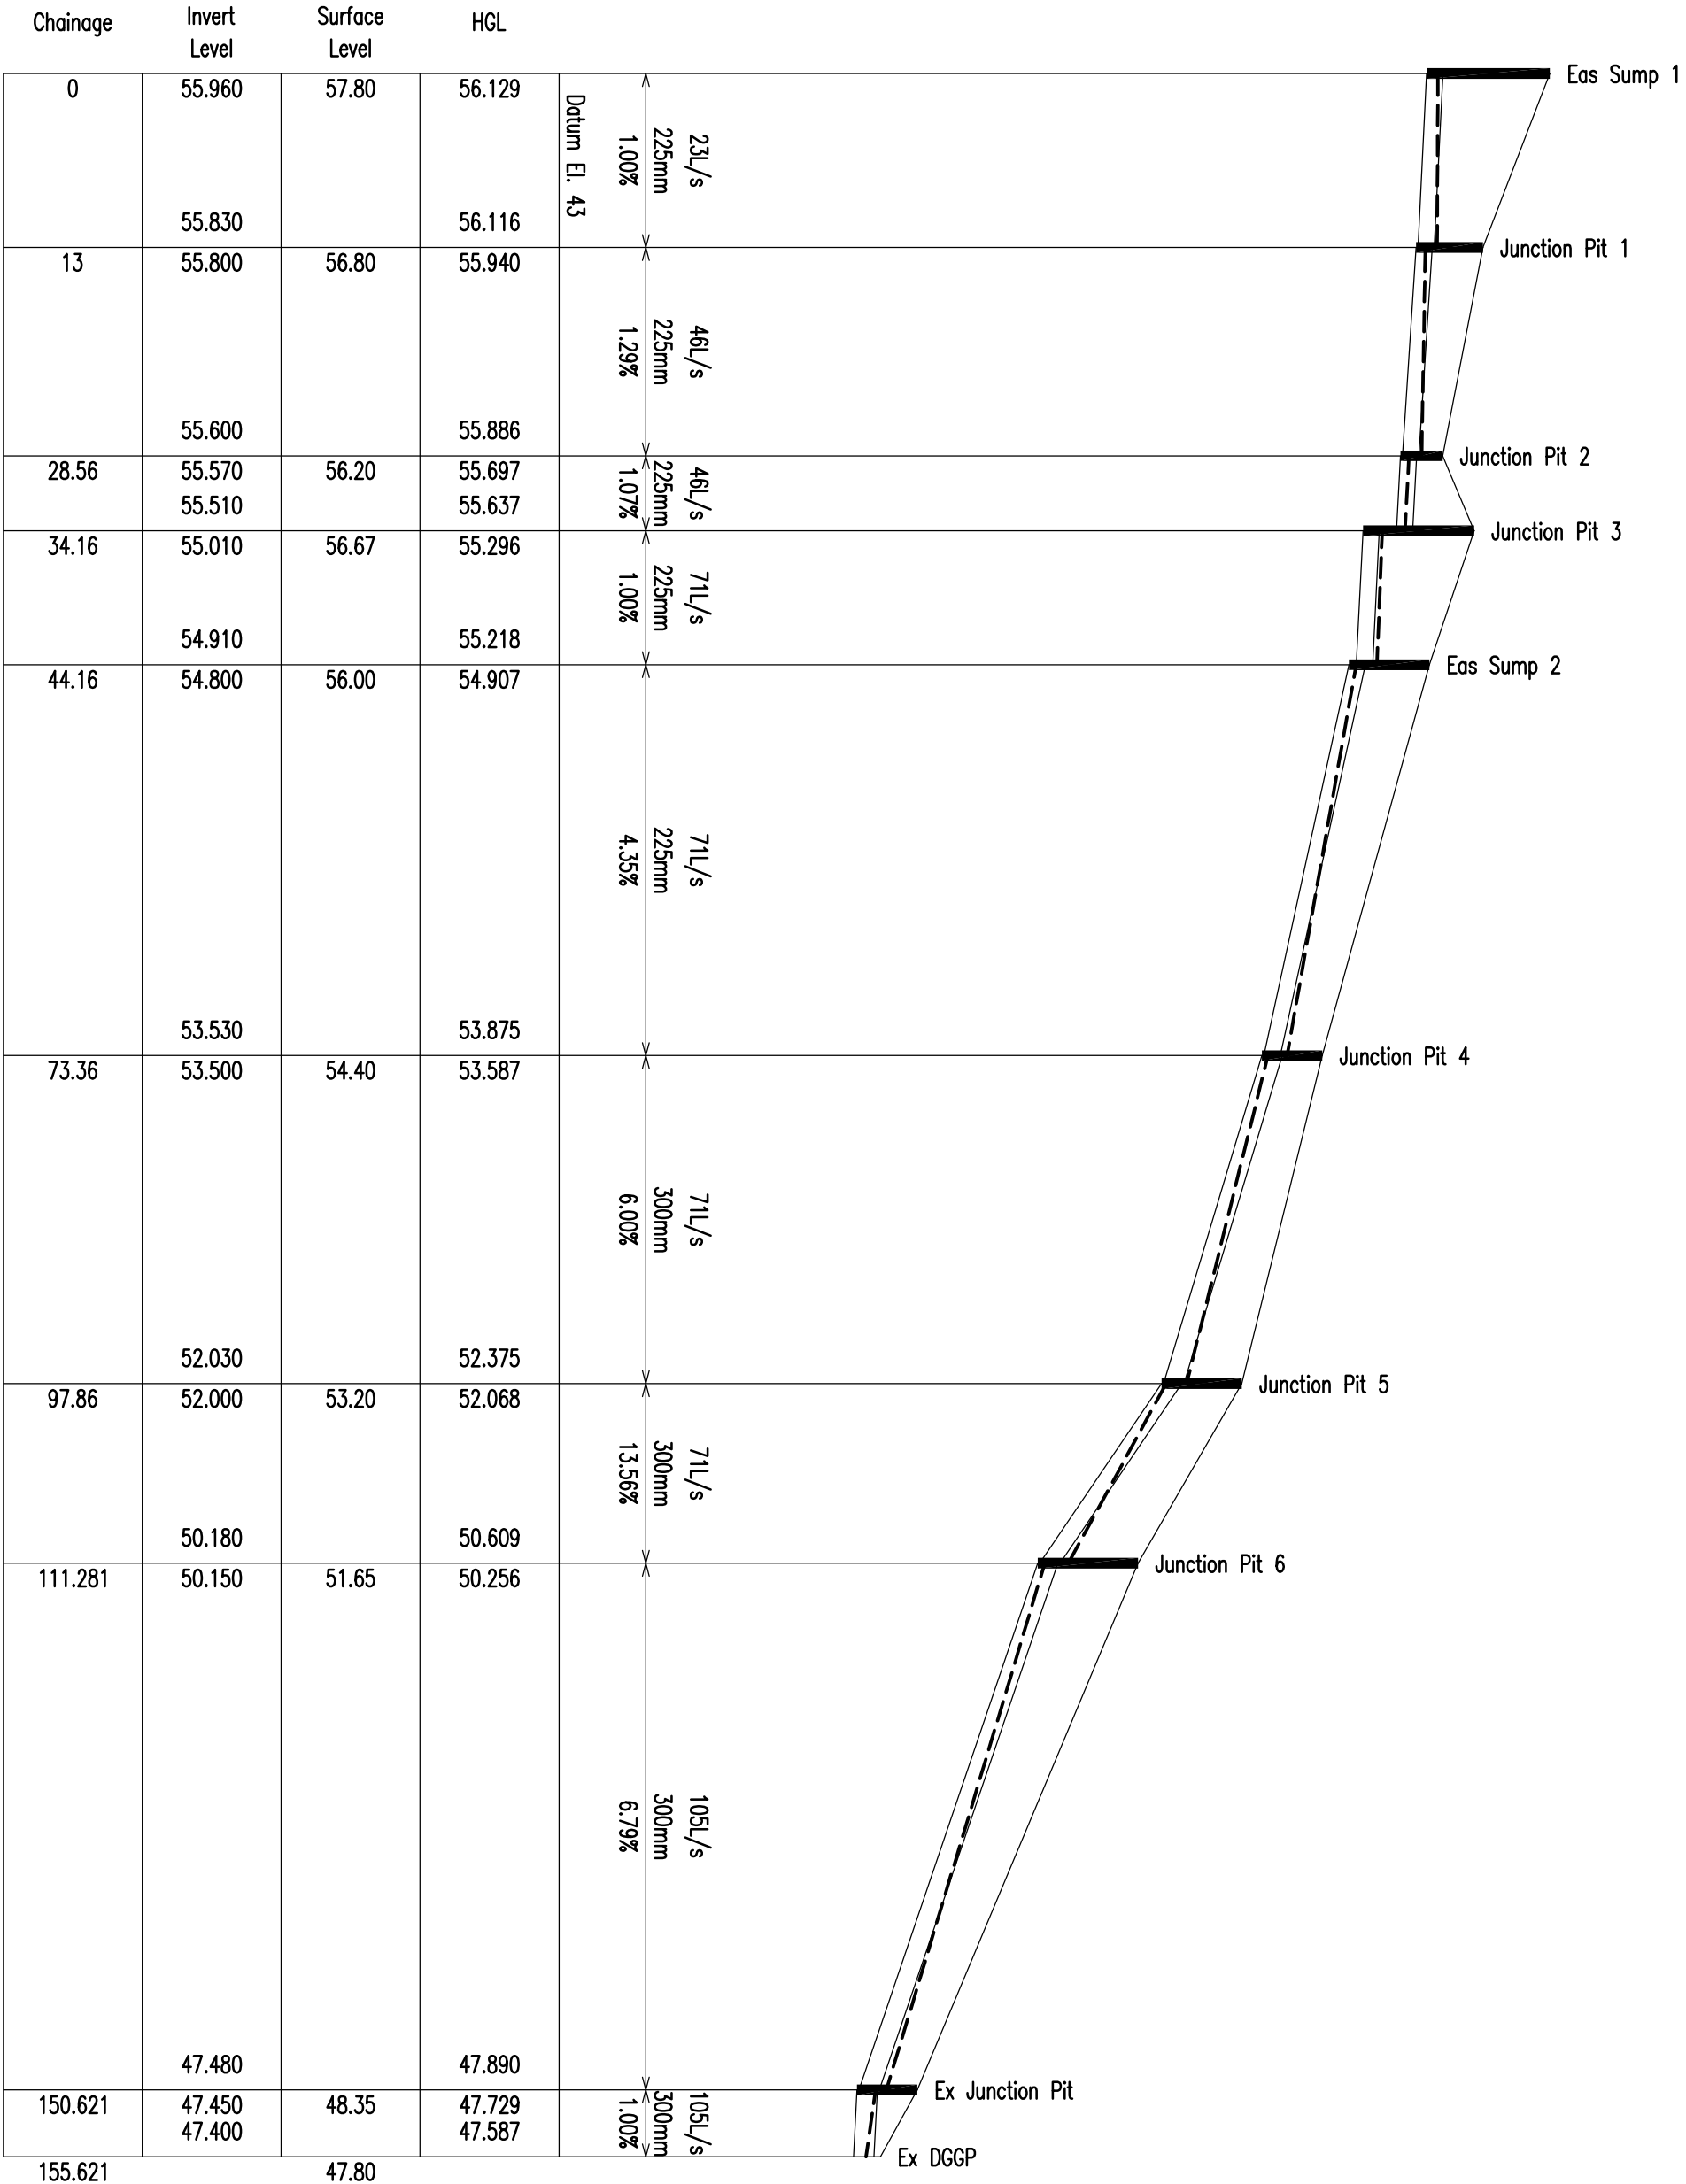

SCALE 1:500 HORIZONTAL
1:100 VERTICAL

DRAINAGE LONGITUDINAL SECTION

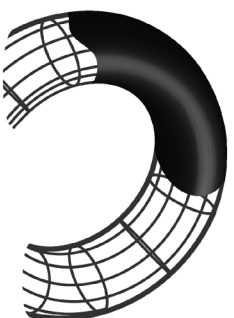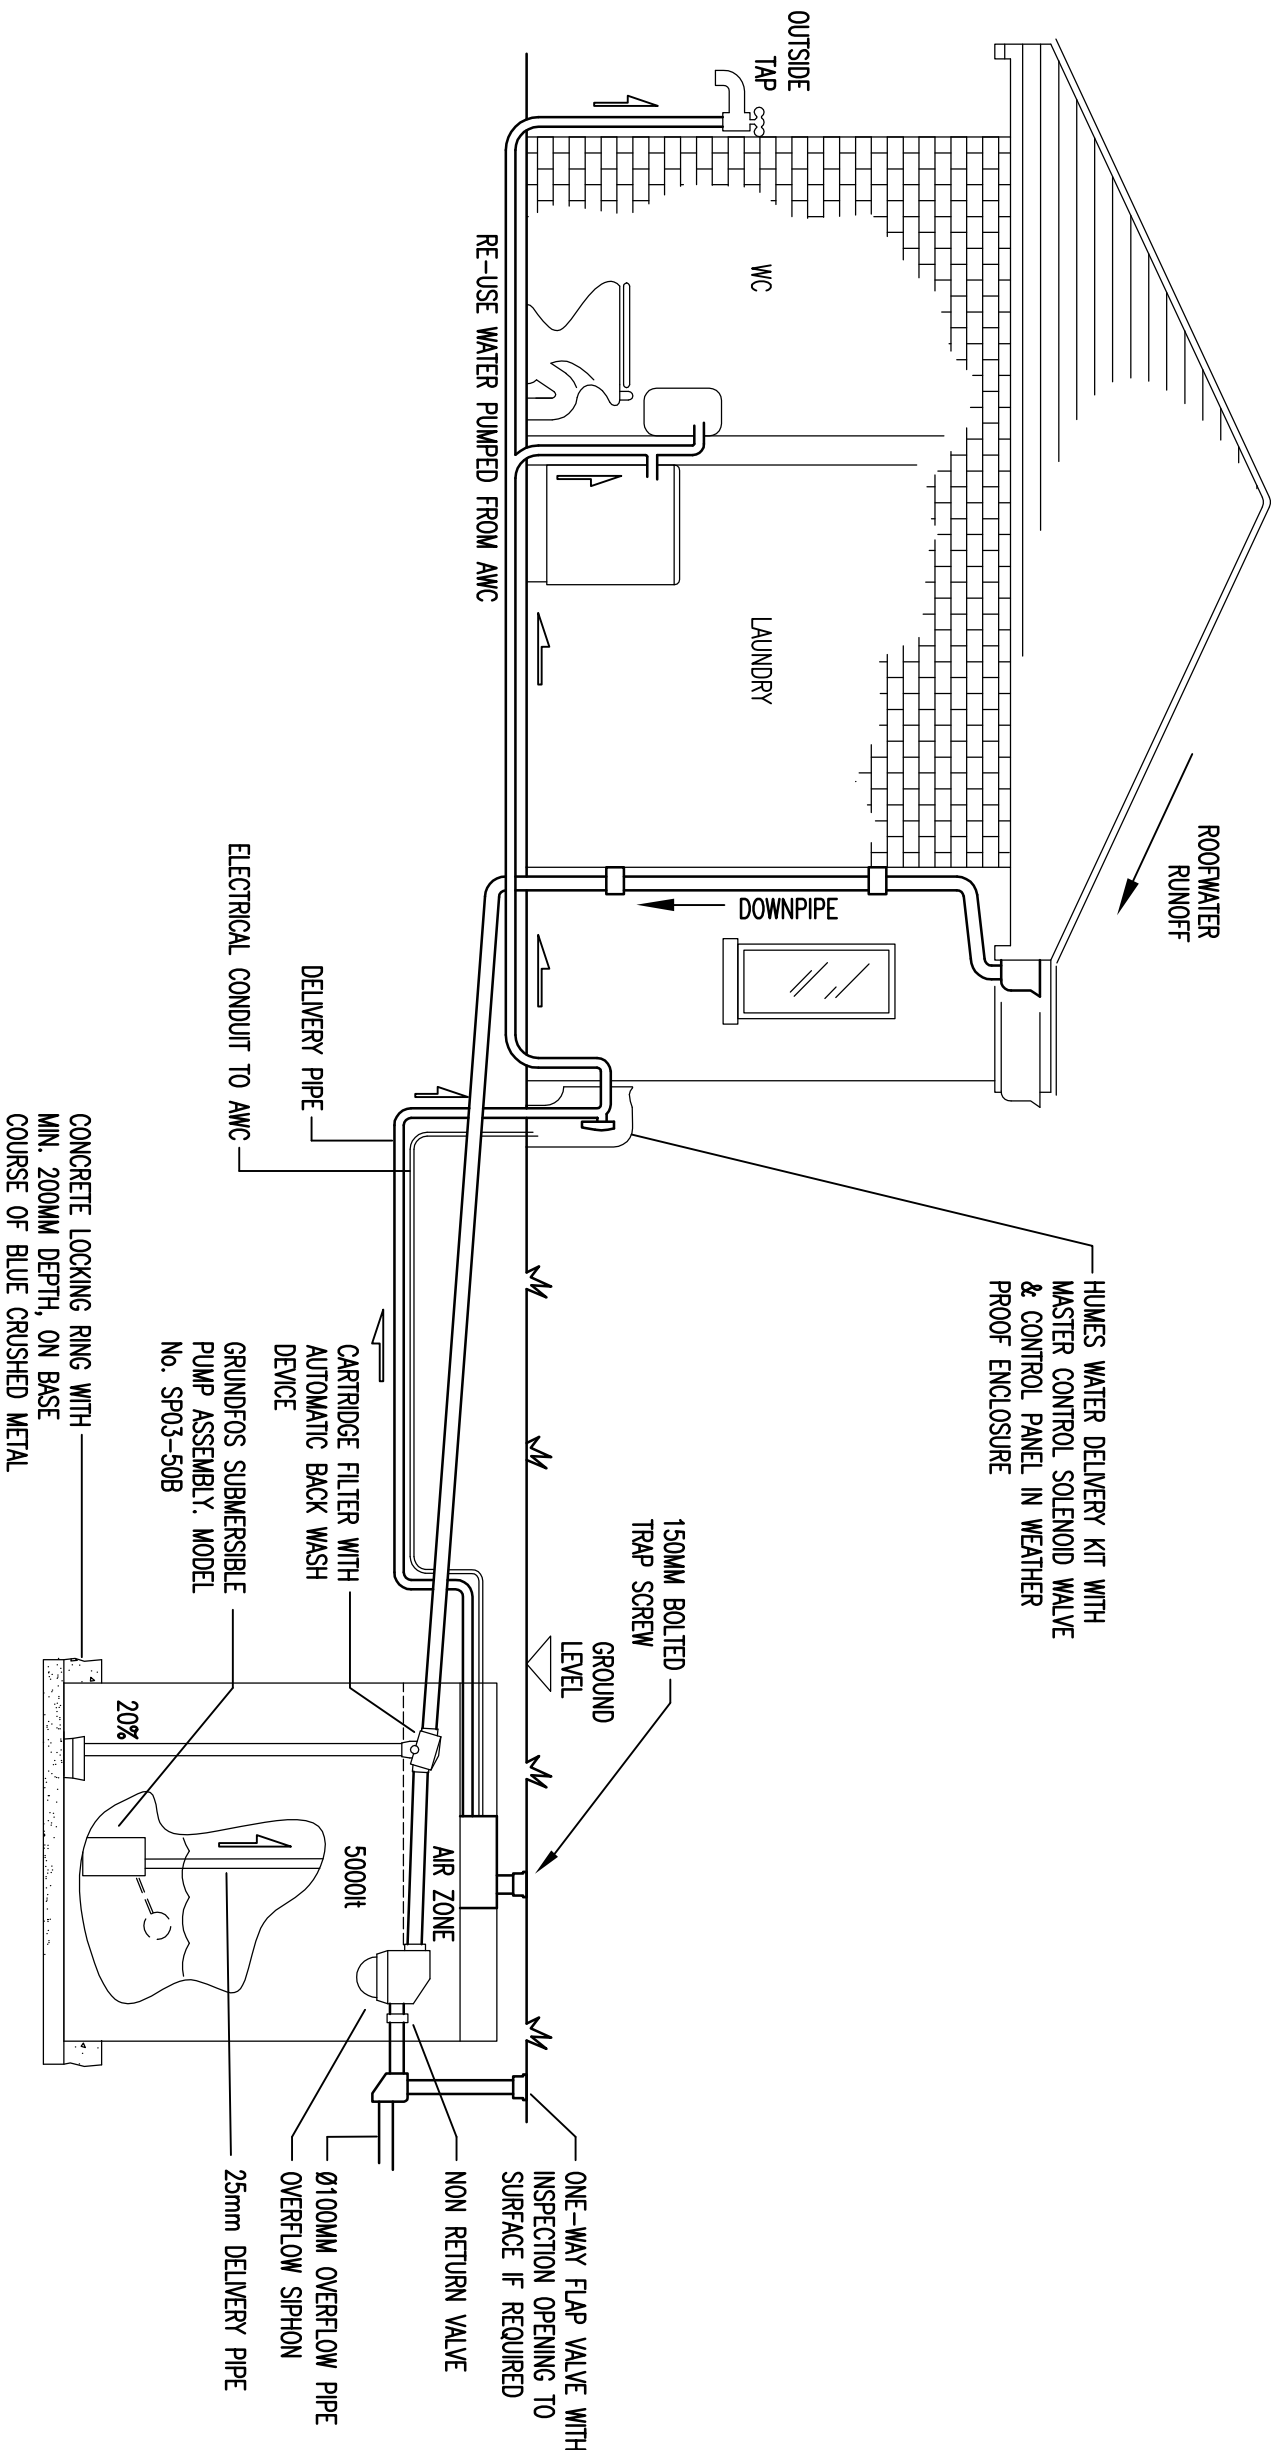

GLENN HAIG
& Partners

Hydraulic + Fire Consultants
7/70 First Avenue
Smylie NSW 2452
E-mail: office@glennhaig.com.au
Phone: (02) 6658 2444
Fax: (02) 6658 2455
Mobile: 0413 308 660

 


www.quattrodsgn.com.au

Quattro Design Pty Limited
ACN 094 615 853
Sydney 61 2 9899 9881
Studio Level 11, 55 Buckingham Street
Smylie Hills NSW 2010
Cambera 61 6251 2016
Suite 2, Level 1, 53 Bowman Street
PO Box 816 Macquarie ACT 2614

Project
PROPOSED NEW HOUSES
136 ANZAC AVENUE
COLLAROY NSW

Drawing title
DETAIL SHEET



Figured dimensions shall take precedence over words. Contractors must verify all dimensions on job before commencing any work or making shop drawings.

Revised
10/1726
Drawing
101726
H-401
D