




01 PLAN VIEW
SCALE 1:500@A1

Symbol	Description
	Horizontal Illuminance 1.0 lux
	Horizontal Illuminance 2.0 lux
	Horizontal Illuminance 5.0 lux
	Horizontal Illuminance 10.0 lux
	Horizontal Illuminance 20.0 lux
	Horizontal Illuminance 50.0 lux

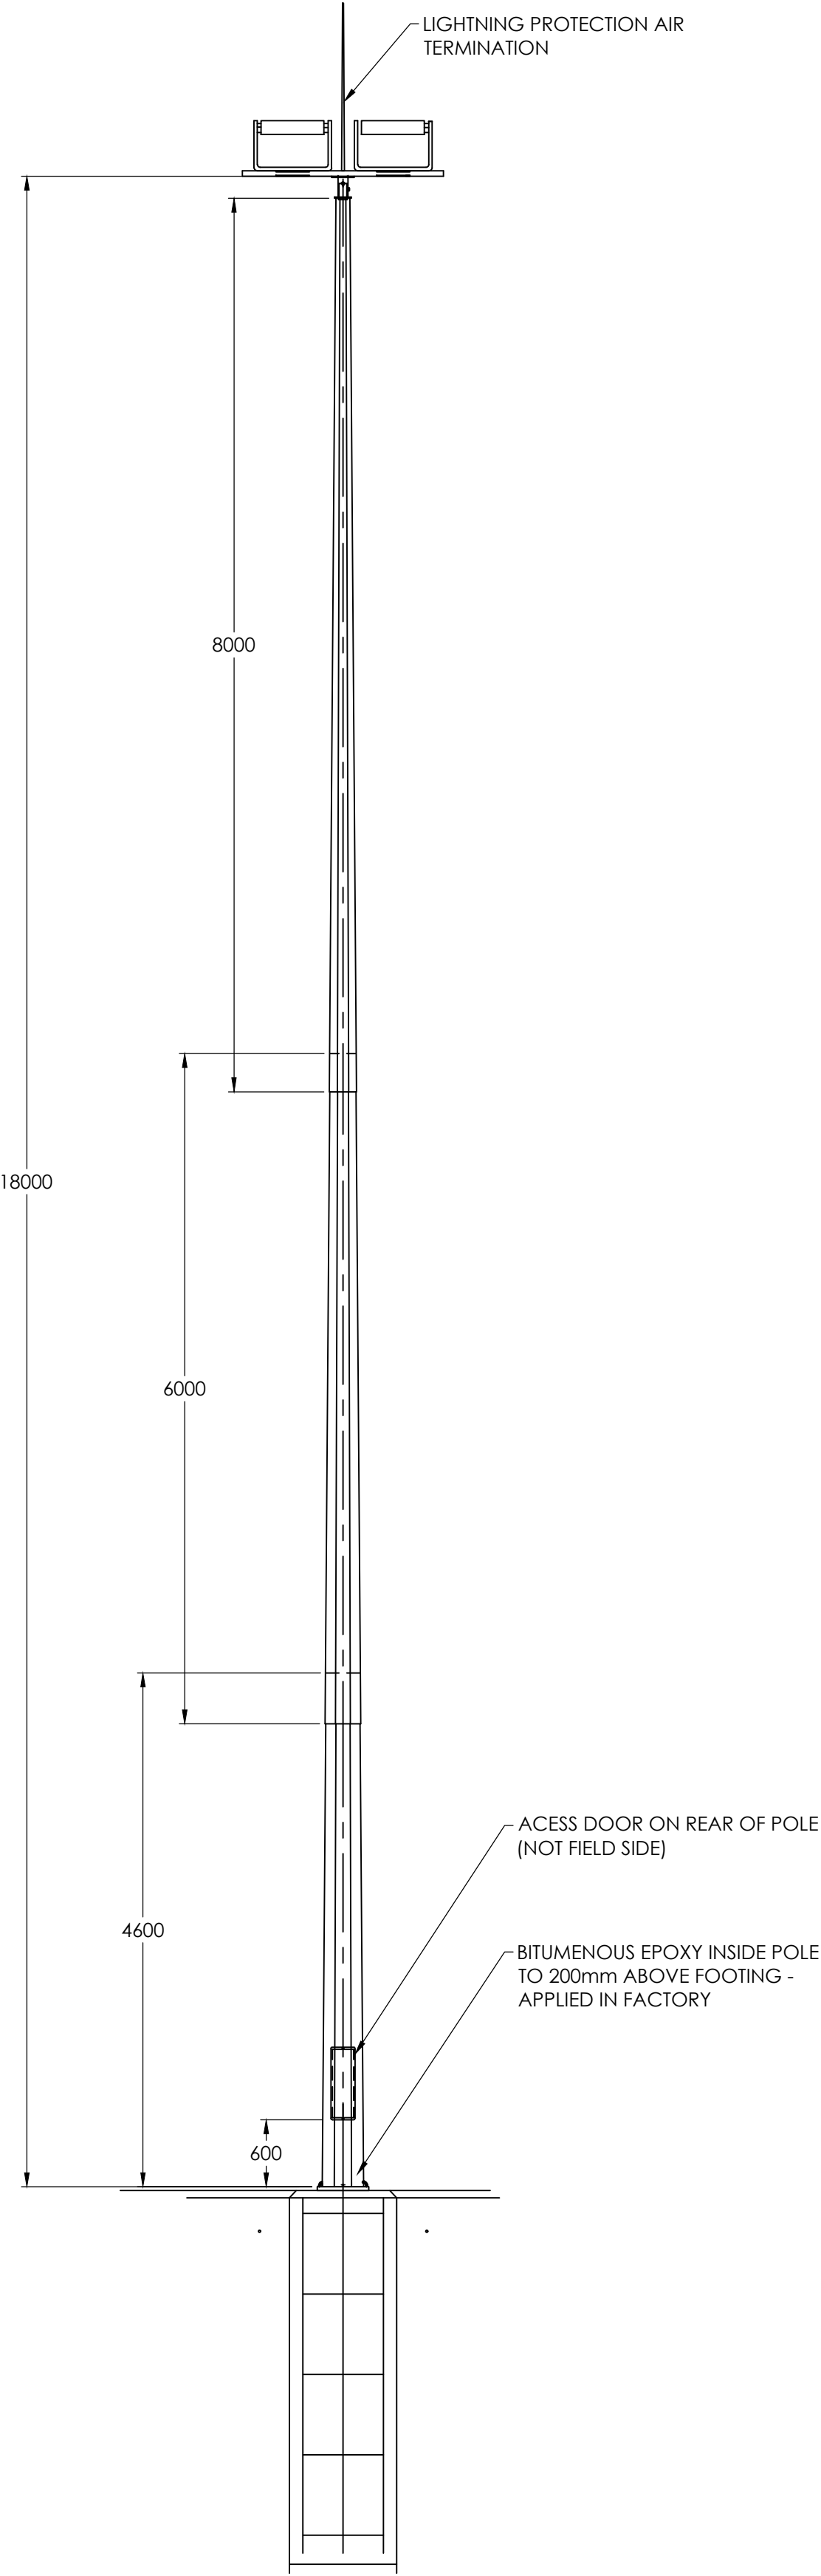

02 SPORTS FIELD LIGHT POLE - FRONT ELEVATION
SCALE 1:50@A1

Issue	Amendment	Date
P1	PRELIMINARY ISSUE	15-06-22

Lead Consultant
Client
NORTHERN BEACHES COUNCIL

Lighting, Art & Science
Lighting Consultants, Electrical Engineers
Level 1, 41 Hume Street,
CROWS NEST N.S.W. 2065
p: 02 9436 0998 e: mail@laands.com.au

Project
CROMER HIGH SCHOOL
SPORTS FIELD LIGHTING

Drawing
SPORTS LIGHTING
GENERAL ARRANGEMENT

Date MAY 2022
Scale AS SHOWN
Project No

Drawn MA
Approved RM

Drawing No
CL-104

Rev
P1