


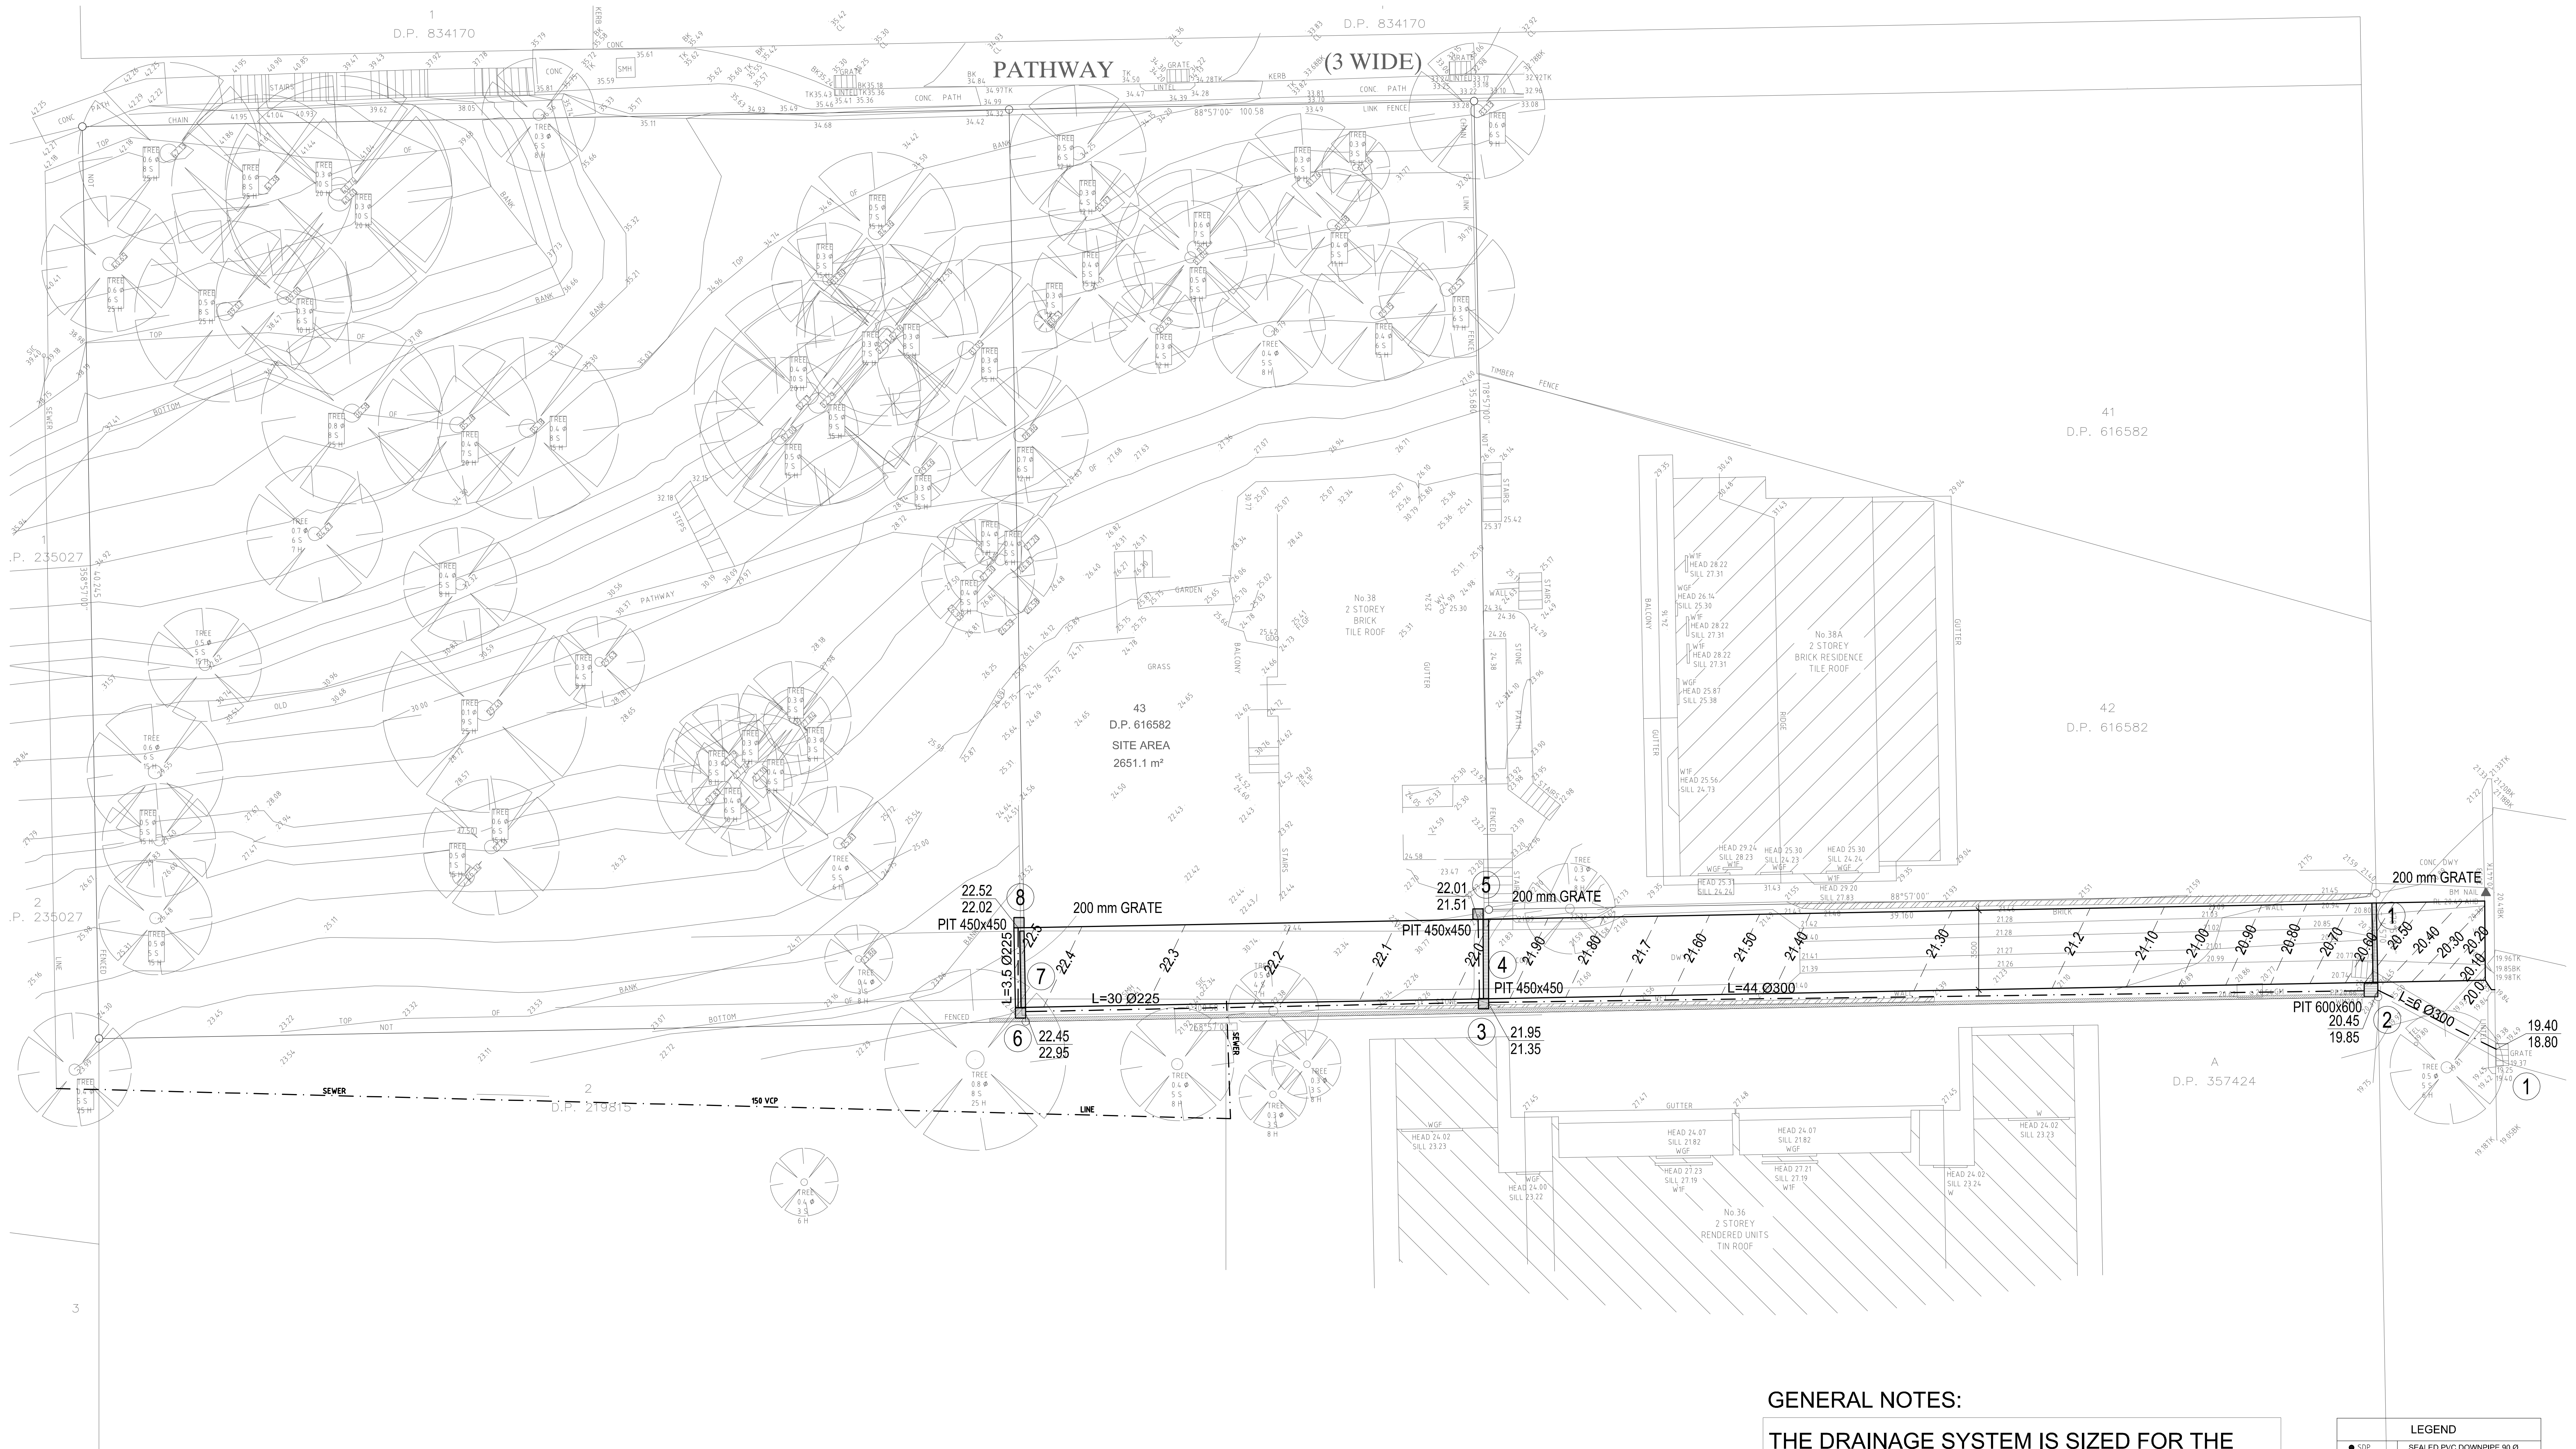

GENERAL NOTES:

THE DRAINAGE SYSTEM IS SIZED FOR THE 1 in 20 years ARI STORM. THE EXCESS FLOW FROM THE SITE WOULD BE DIRECTED TO THE STREET ALONG THE PROPOSED DRIVEWAY

LEGEND	
● SDP	SEALED PVC DOWNPIPE 90 Ø
● DP	DOWNPIPE
---	EXISTING CONTOUR (m)
- - -	PROPOSED CONTOUR (m)
● F	SUB SOIL DRAINAGE FLUSH POINT
○ F	FLOOR WASTE 250x250 mm
---	STORMWATER DRAINAGE PIPE
---	DIAMETER = 100 mm, 9 m LONG
---	SUBSOIL DRAINAGE PIPE
---	(default Ø100mm, min. slope 1%)
---	FINISHED GROUND LEVEL=23.0(m)
---	PIPE INVERT LEVEL=22.5 (m)
---	EXISTING GROUND LEVEL (m)
---	PROPOSED GROUND LEVEL (m)
---	TOP OF WALL (m)

Amendments		
Issue	Date	Comments
1	2018/08/01	For comments
2		
3		
4		
5		
6		
7		
8		
9		
10		

STORMWATER DRAINAGE PLAN FOR
PROPOSED SUBDIVISION AT
No. 38 NULLABURRA RD, NEWPORT

DESIGNED BY: PAVEL KOZAROVSKI,
MIEAUS, CPEng, NPER-3

DRAWN BY: P.K.
DRAWING NO.C-3519-01
SCALE: 1:100 on A0, 1:400 on A3

Kozarovski & Partners
1405-24 WINDSWAY, CROMULLA NSW 2230
(02) 8544 8720
Mobile: 0412 560 787 pavelk@stormnet.com.au

