

PROPOSED GUEST AND CARER'S UNIT

at

DeeWhy Gardens Retirement Village

Lot 61 DP 869675

155 - 171 Fisher Road North, Cromer

for

Becton Living

THIS PLAN TO BE READ IN
CONJUNCTION WITH

MOD2012/0244

WARRINGAH COUNCIL

DEVELOPMENT APPLICATION

Drawing Index:

DA00	COVER PAGE
DA01	OVERALL SITE PLAN
DA02	FLOOR PLAN, KITCHEN LAYOUT PLAN & JOINERIES DETAILS
DA03	CARER'S UNIT WALL ELEVATIONS
DA04	RCP ELECTRICAL LAYOUT PLAN

DA ISSUED 07-11-12 REVISION A


GILSENAN ASSOCIATES
ARCHITECTURE + URBAN DESIGN

Suite 6, 53 Great Buckingham St, Redfern NSW 2016
t: (02) 9690 0012 e: studio@gilsenanassociates.com.au

THIS PLAN TO BE READ IN
CONJUNCTION WITH

MOD2012/0244


WARRINGAH COUNCIL

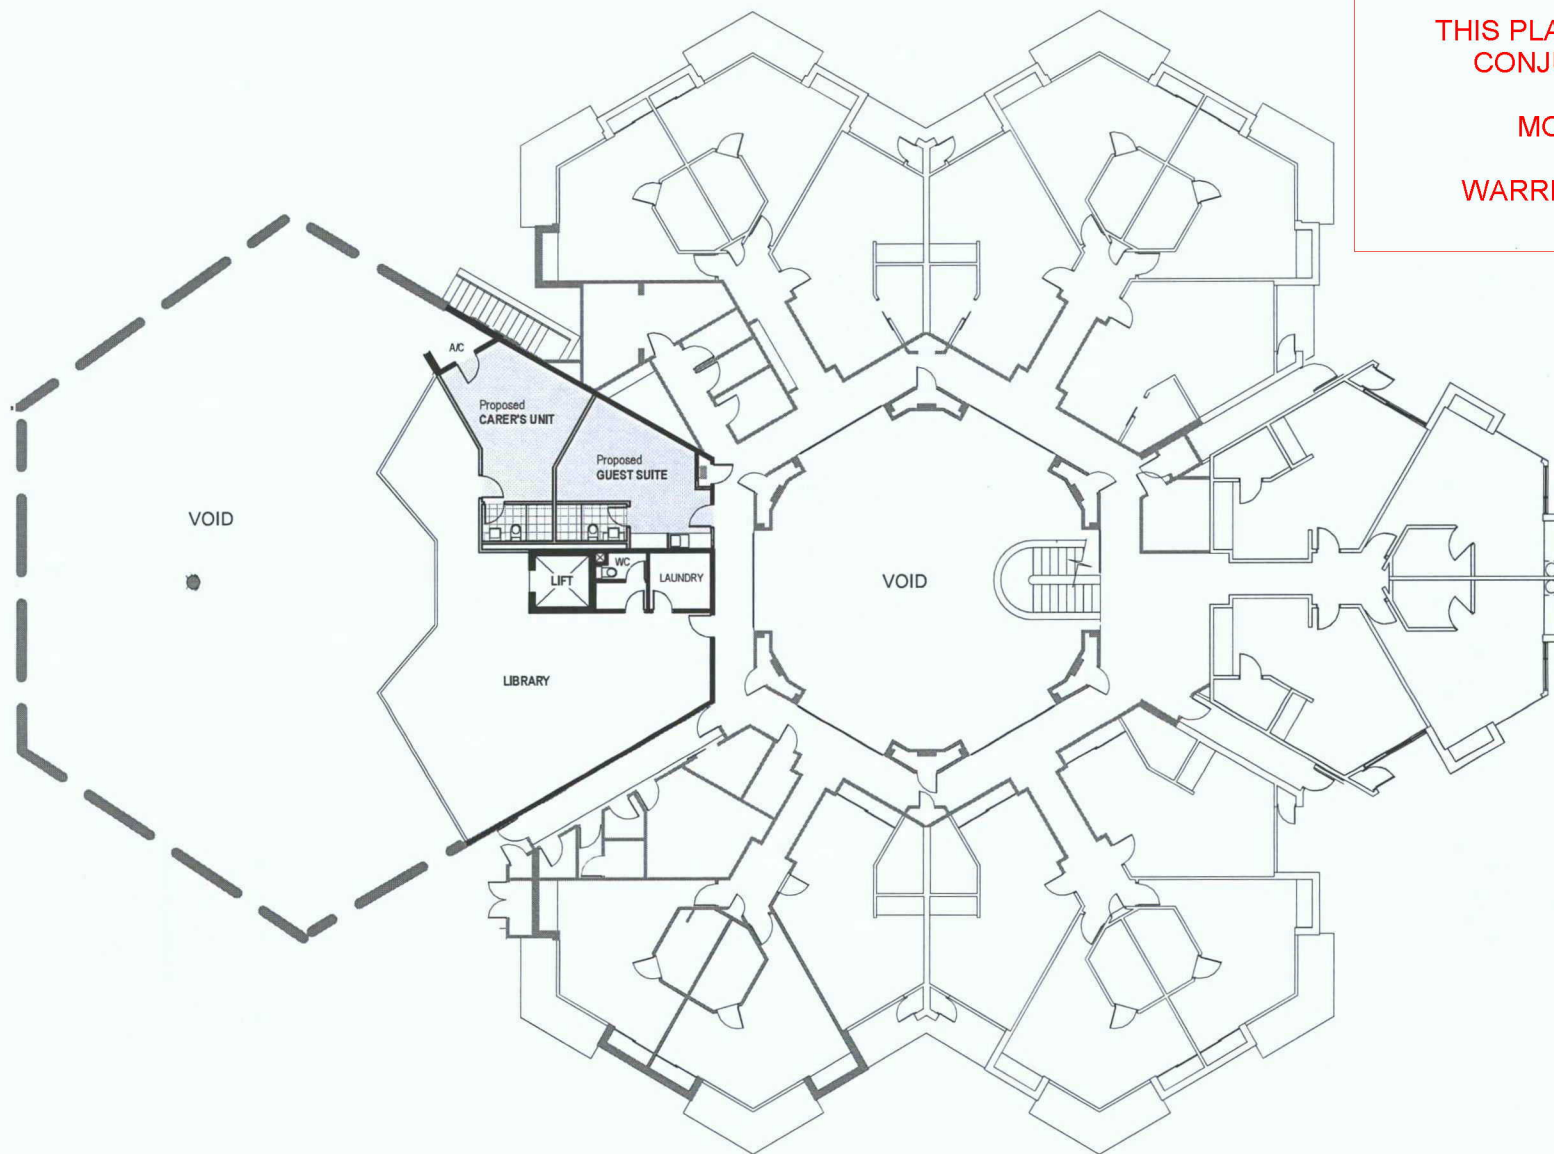

OVERALL SITE PLAN - FIRST FLOOR

DA ISSUED 07-11-12

GILSENAN ASSOCIATES ARCHITECTURE + URBAN DESIGN Suite 6, 53 Great Buckingham St, Redfern NSW 2016 t: (02) 9600 0012 e: studio@gilsenanassociates.com.au		DATE: 07/11/12 DRAWING: A	REVISION: ISSUED FOR DA
		ADDRESS: 155 - 171 Fisher Road North, Crompton	PROJECT: DeeWhy Gdns Retirement Village
Scale: 1:100 Date: 07/11/12		Scale: 1:100 Date: 07/11/12	Project: 1074
Client: Becton Living		Designer: KN	Checker: DAB

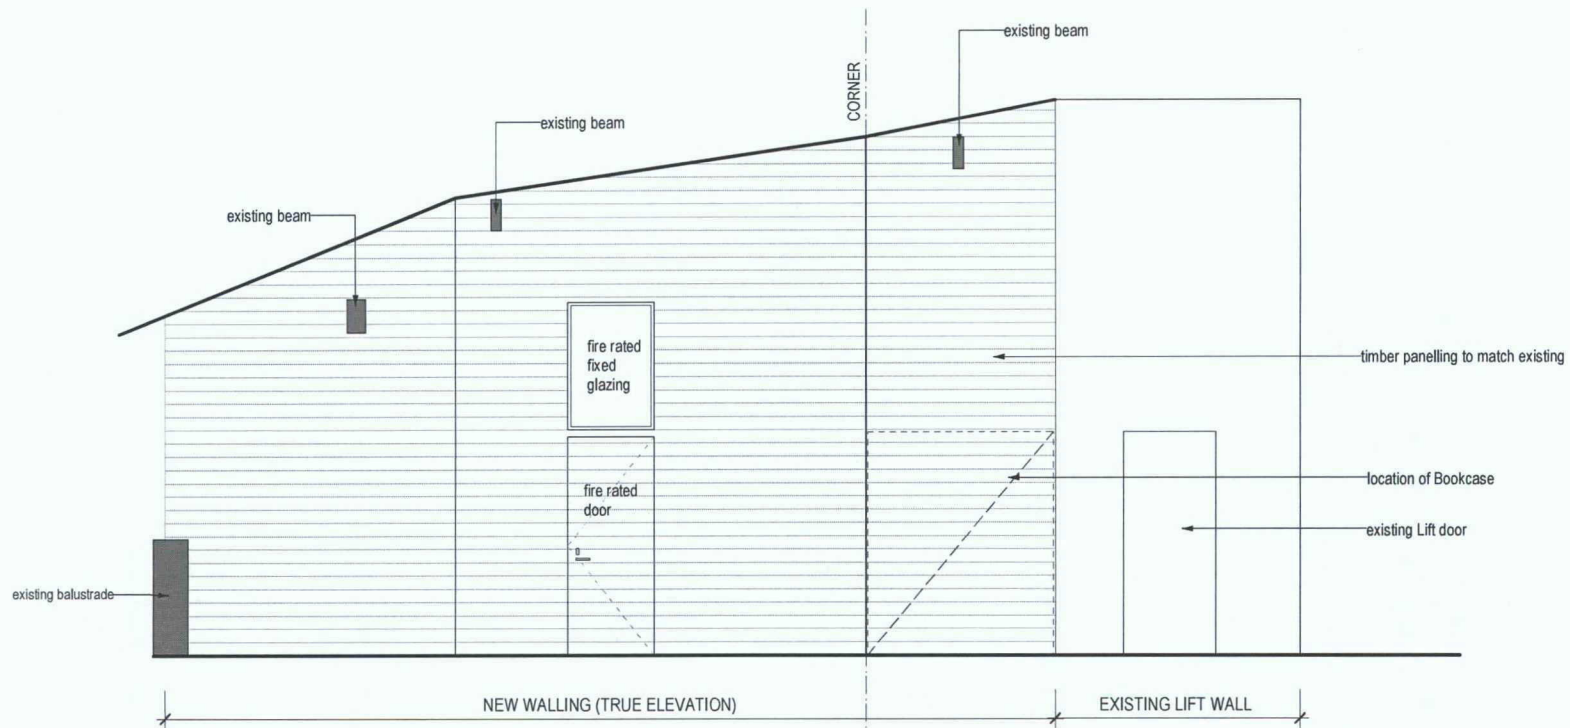


1 WALL ELEVATION
Scale 1:50

2 WALL ELEVATION
Scale 1:50

CARER'S UNIT WALL ELEVATION

THIS PLAN TO BE READ IN
CONJUNCTION WITH
MOD2012/0244
WARRINGAH COUNCIL

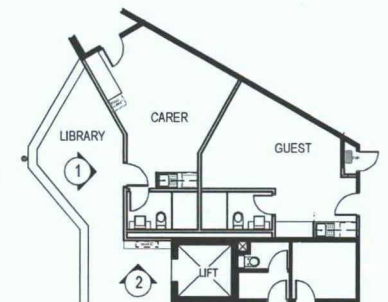

DA ISSUED 07-11-12



GILSENAN ASSOCIATES ARCHITECTURE + URBAN DESIGN Suite 6, 53 Great Buckingham St, Redfern NSW 2015 t: (02) 9690 0012 e: studio@gilsenanassociates.com.au		DATE: 07/11/12 PROJECT: DeeWhy Gdns Retirement Village CLIENT: Becton Living	REVISION: 07/11/12 ISSUED FOR DA ADDRESS: 155-171 Fisher Road North, Crompton SCALE: 1:50 PROJECT: 10/4 CHECKED: JN DRAWN: DRA03
---	--	--	--



THIS PLAN TO BE READ IN
CONJUNCTION WITH

MOD2012/0244

WARRINGAH COUNCIL

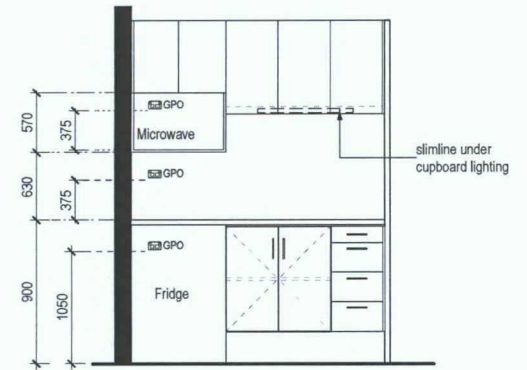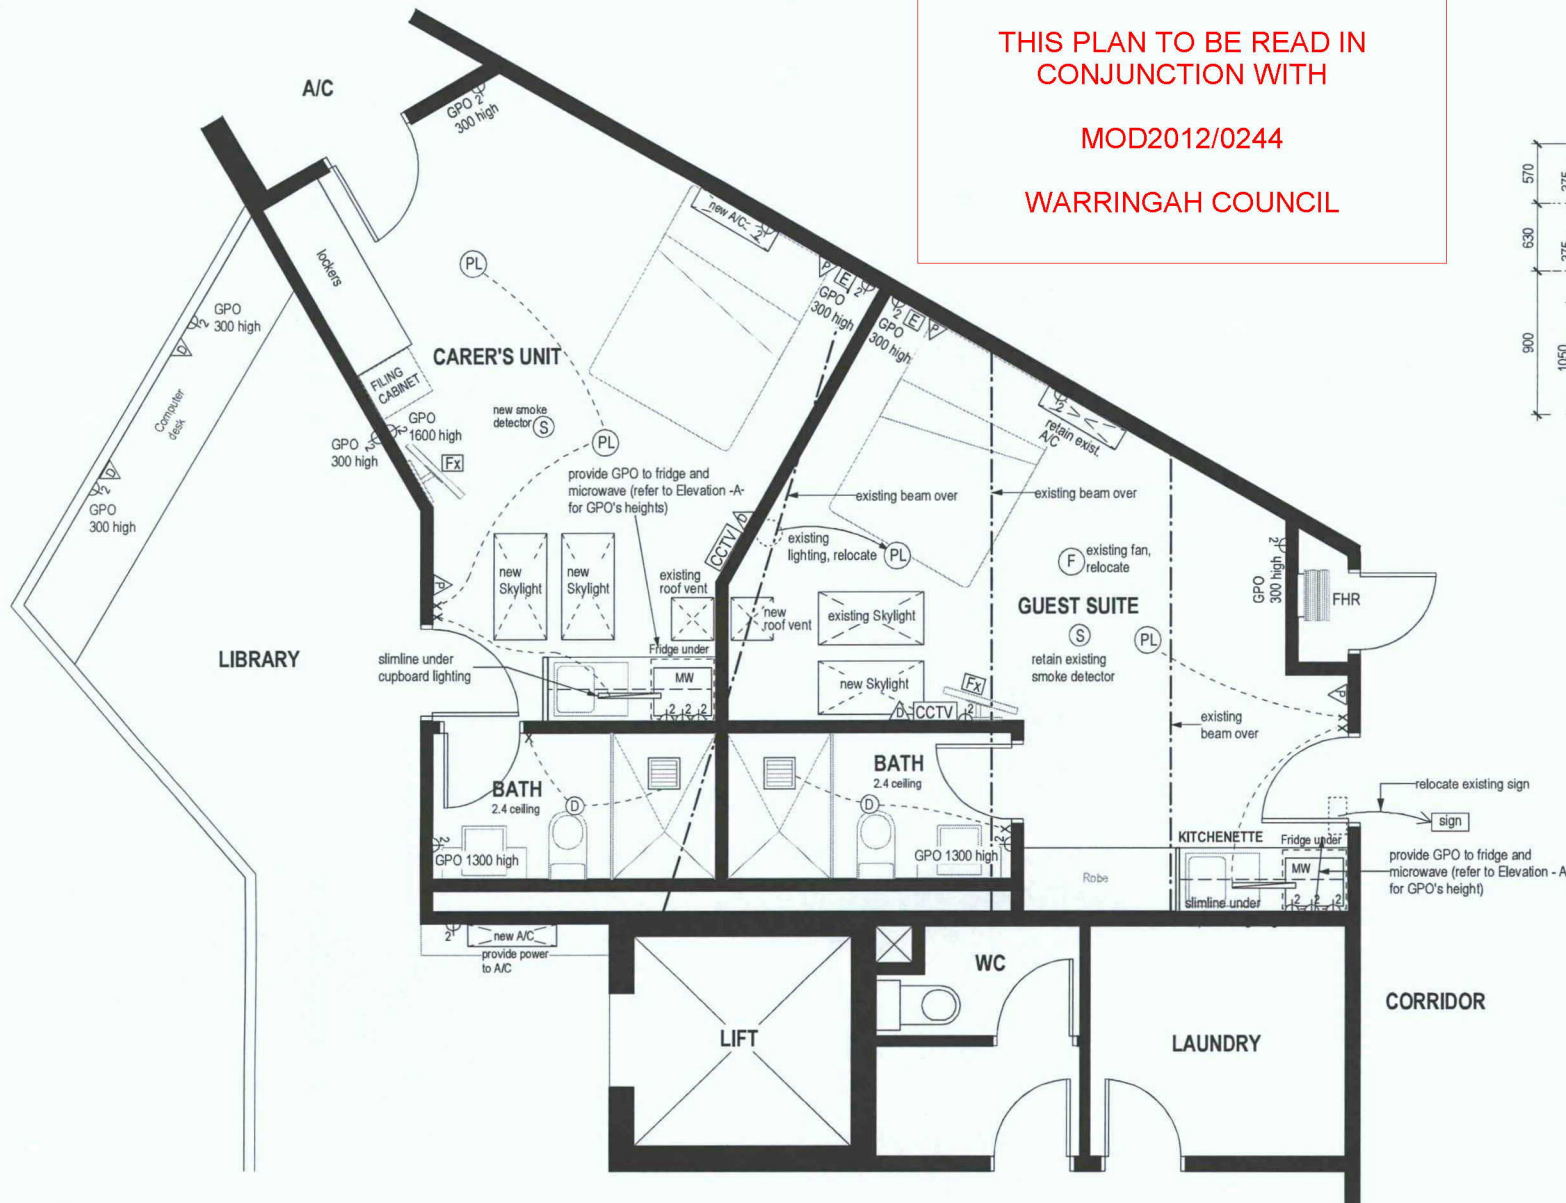

LEGEND

- Ⓟ PL Pendant Light
- Ⓛ D Low Voltage Downlight
- Ⓜ A Phone & Data Outlet at 300 high
- Ⓜ A Data Outlet at 300 high
- Ⓜ Fx Foxtel TV
- Ⓜ 2 Double GPO
- Ⓜ E Emergency Call
- Ⓜ S Smoke Detector
- Ⓜ CCTV CCTV
- Ⓜ Exhaust Fan
- Ⓜ X Switch
- Slimline Lighting

RCP ELECTRICAL LAYOUT PLAN

DA ISSUED 07-11-12

GILSENAN ASSOCIATES ARCHITECTURE + URBAN DESIGN		DATE: 07/11/12	REVISION: A	ISSUED FOR DA
Suite 6, 53 Great Buckingham St, Redfern NSW 2015 t: (02) 9690 0012 e: studio@gilsenanassociates.com.au		DRAWING: RCP ELECTRICAL LAYOUT PLAN		
PROJECT: DeeWhy Gdns Retirement Village		ADDRESS: 155-171 Fisher Road North, Cromer		
CLIENT: Becton Living		DATE: 07-11-12	SCALE: 1:50	PROJECT: 10/4
		CHECKED: KN	APPROVED: A	DRAWN: DA03

