

PROPOSED GUEST AND CARER'S UNIT

at

DeeWhy Gardens Retirement Village

Lot 61 DP 869675

155 - 171 Fisher Road North, Cromer

for


Becton Living

DEVELOPMENT APPLICATION	Drawing Index:	
	DA00	COVER PAGE
	DA01	OVERALL SITE PLAN
	DA02	FLOOR PLAN, KITCHEN LAYOUT PLAN & JOINERIES DETAILS
	DA03	CARER'S UNIT WALL ELEVATIONS
	DA04	RCP ELECTRICAL LAYOUT PLAN

DA ISSUED 07-11-12 REVISION A

GILSENAN ASSOCIATES
ARCHITECTURE + URBAN DESIGN



Suite 6, 53 Great Buckingham St, Redfern NSW 2016
t: (02) 9690 0012 e: studio@gilsenanassociates.com.au

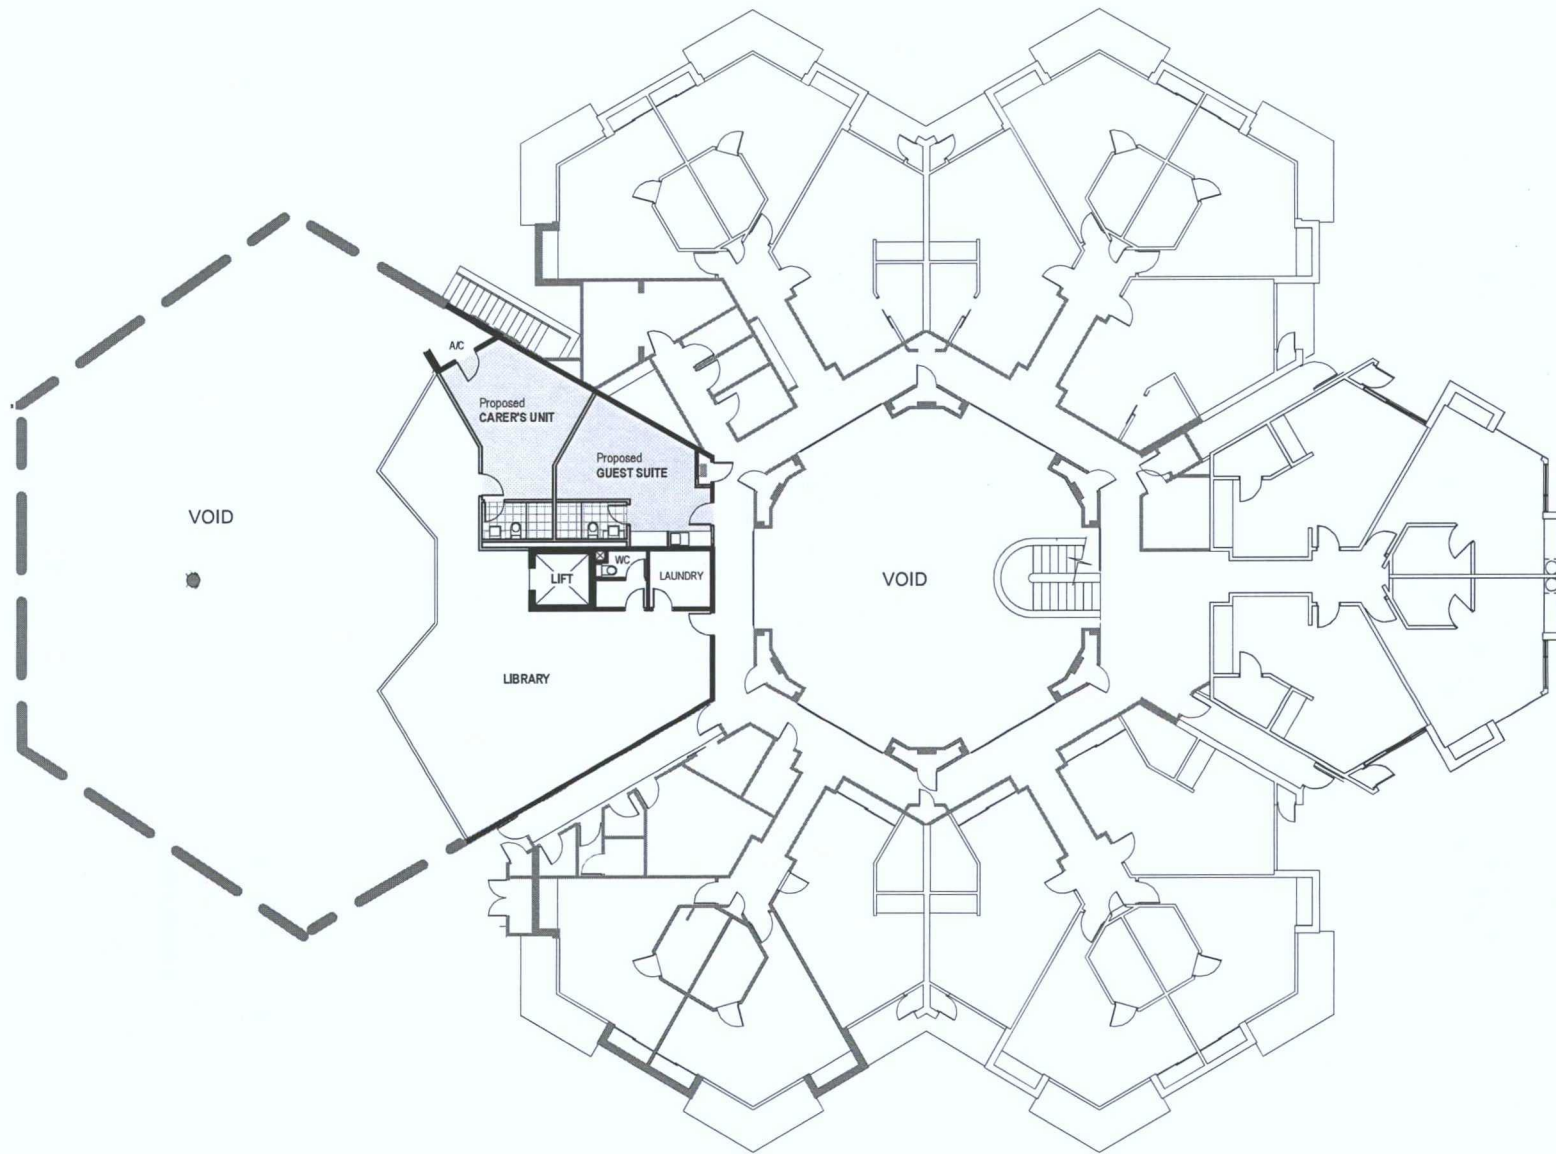

OVERALL SITE PLAN - FIRST FLOOR

DA ISSUED 07-11-12


GILSENAN ASSOCIATES ARCHITECTURE + URBAN DESIGN Suite 6, 53 Great Buckingham St, Redfern NSW 2016 t (02) 9600 0012 e studio@gilsenanassociates.com.au	DRAWN: A	DATE: 07/11/12	REVISION: ISSUED FOR DA
	OVERALL SITE PLAN - FIRST FLOOR		
	ADDRESS: 155 - 171 Fisher Road North, Cromer		
	PROJECT: DeeWhy Gdns Retirement Village	DATE: 07-11-12	PROJECT: 1074
If ground dimensions to be taken in preference to scale, verify all dimensions on site. Copyright for the information contained herein remains the property of Gilsenan Associates Architects.	CLIENT: Becton Living	SCALE: 1/100	PROJECT: 1074 CHECKED: KN DATE: 07/11/12 DRAWN: A

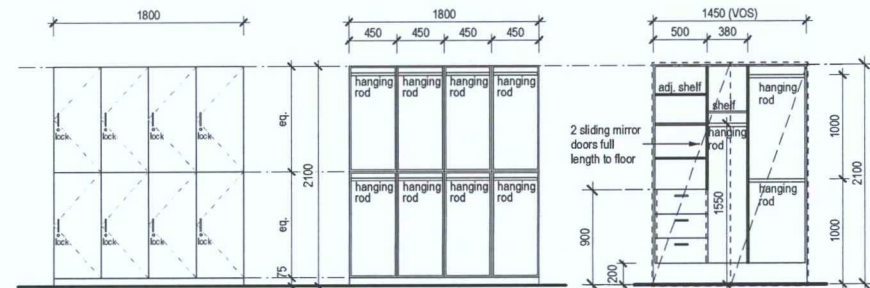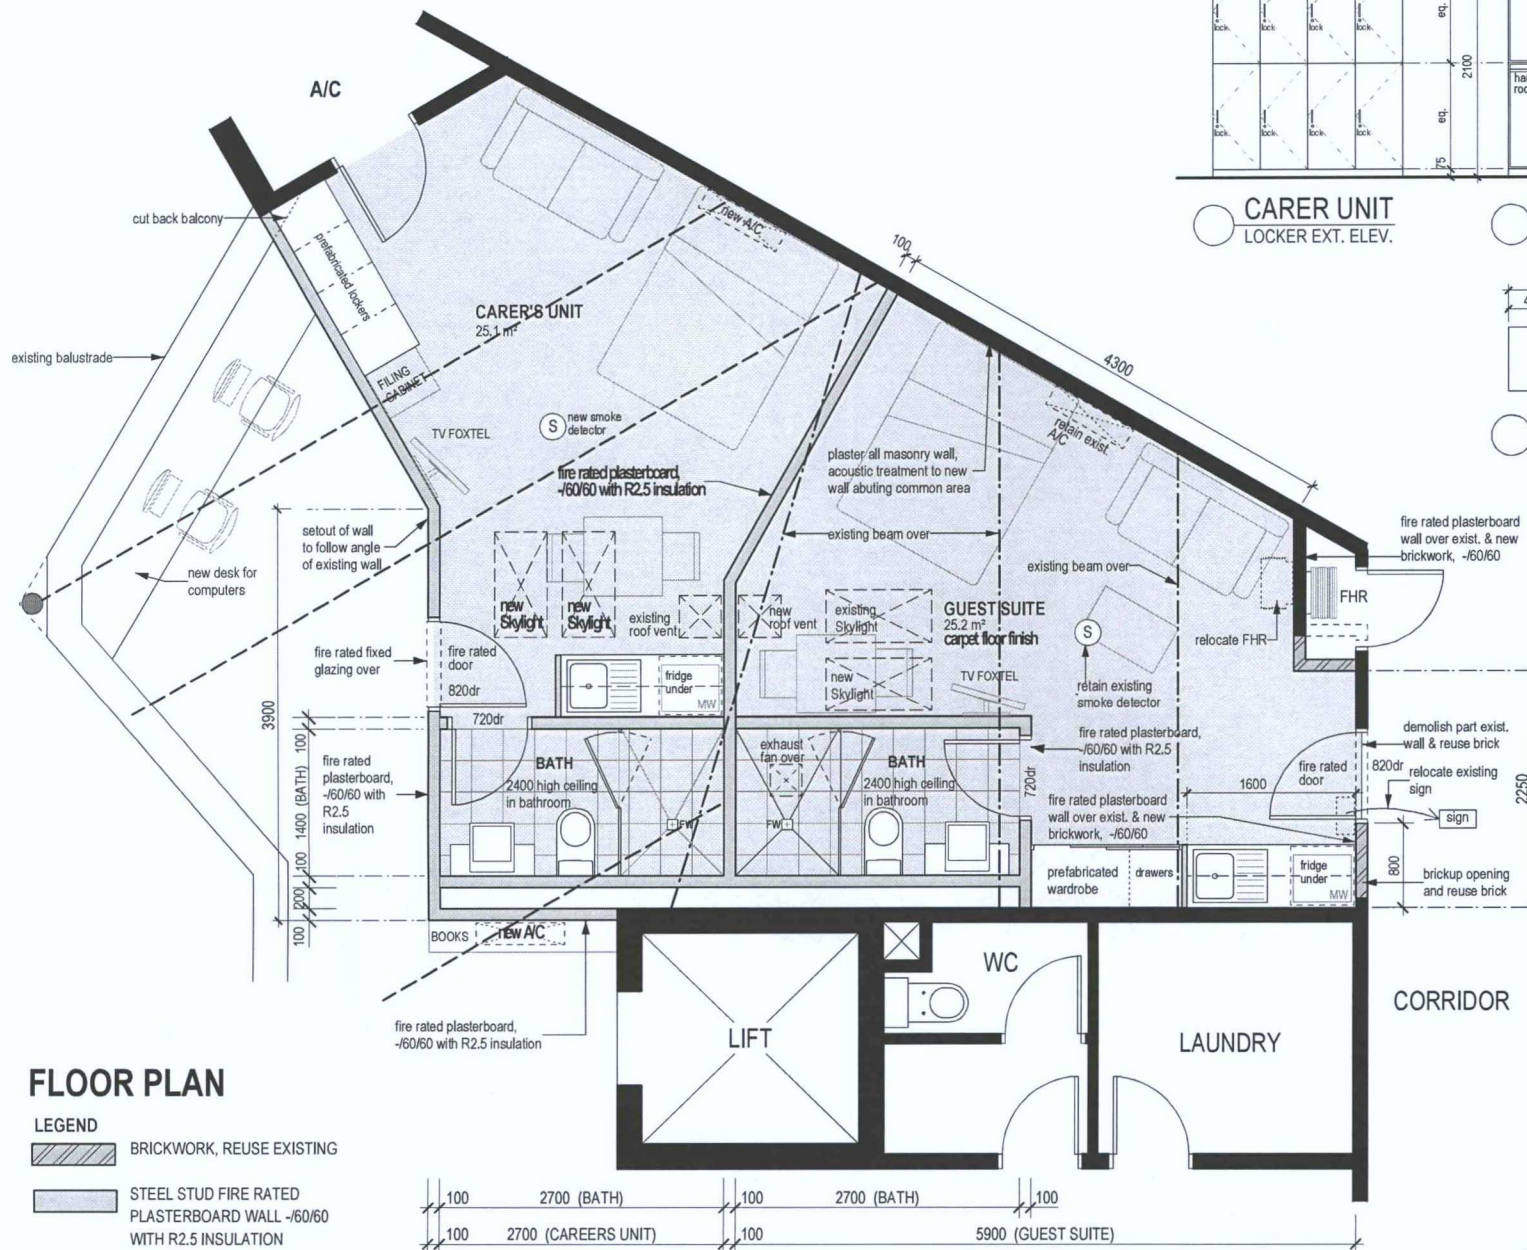


CARER UNIT LOCKER EXT. ELEV.

CARER UNIT LOCKER INT. ELEV.


GUEST SUITE WARDROBE ELEVATION

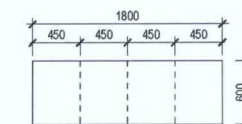


CARER UNIT LOCKER PLAN

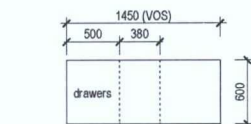

GUEST SUITE WARDROBE PLAN

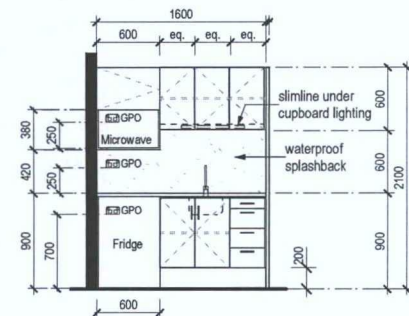


KITCHENETTE ELEVATION

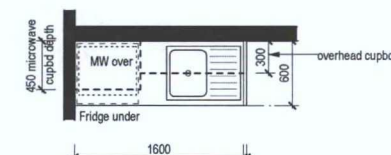

KITCHENETTE PLAN

DA ISSUED 07-11-12


GILSENAN ASSOCIATES		DATE: 07/11/12	ISSUED FOR DA
ARCHITECTURE + URBAN DESIGN		PROJECT: DeeWhy Gdns Retirement Village	SCALE: 1:50
Suite 6, 53 Great Buckingham St, Redfern NSW 2015		CHECKED: KN	DATE: 07-11-12
T: (02) 9690 0012 e: studio@gilsenanassociates.com.au		PROJECT: Becton Living	PROJECT: 10/4
Figured dimensions to be taken in preference to scale. North arrow shown on all sheets. Copyright for the information contained herein remains the property of Gilson Associates Architects.		CHECKED: DMS	DATE: 07/11/12

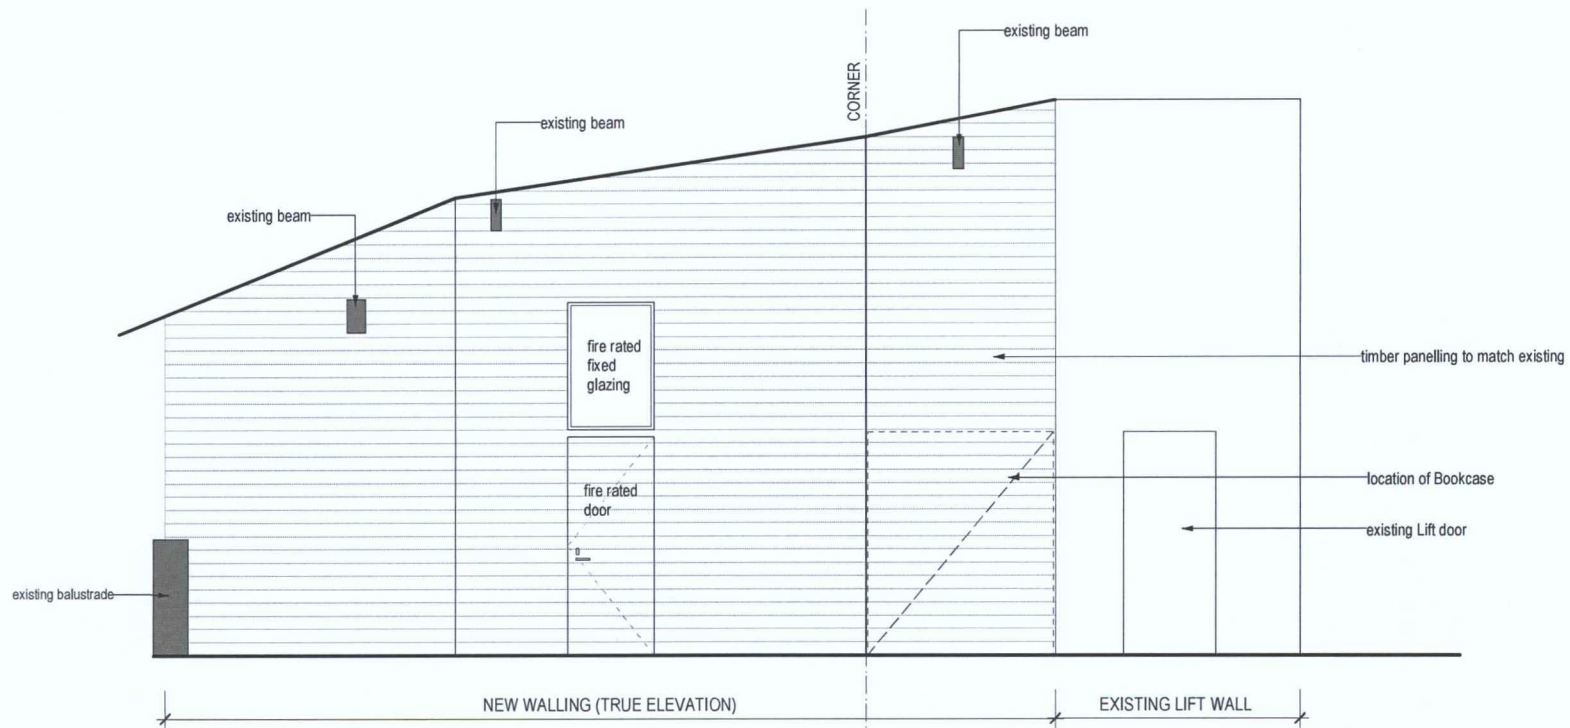

1 WALL ELEVATION
Scale 1:50

2 WALL ELEVATION
Scale 1:50

CARER'S UNIT WALL ELEVATION

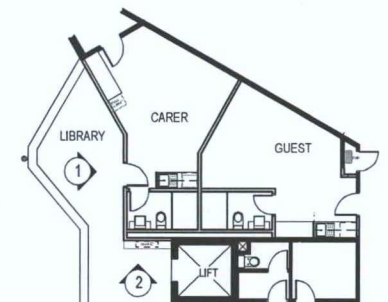

DA ISSUED 07-11-12

GILSENAN ASSOCIATES ARCHITECTURE + URBAN DESIGN Suite 6, 53 Great Buckingham St, Redfern NSW 2015 t: (02) 9660 0012 e: studio@gilsenanassociates.com.au		DATE: 07/11/12 REVISION: A ISSUED FOR DA	PROJECT: DeeWhy Gdns Retirement Village CLIENT: Becton Living	SCALE: 1:50 DRAWN: A CHECKED: JN DATE: 07-11-12 PROJECT: 10/4
---	--	--	--	---

Figured dimensions to be taken in preference to words. Verify all dimensions on site. Copyright for the information contained herein remains the property of Gilsenan Associates Architects.

