


LAND AND CONSTRUCTION SURVEYING
 SYDNEY WARDEN
 10 BARKILL RD, BEROWLA
 NSW 061244257 FAX 9444412
 member Spatial Services Institute (SSI)

CLIENT: IAN WALTERS
 PLAN SHOWING DETAIL & LEVELS OVER
 LOT 10 IN DP 15762
 13 BRUCE ST, WARRENWOOD
 L.G.A. PITWATER

SCALE 1:200
 DATE 14-7-2004
 REF. NO. 0414

- NOTES:**
- Levels are on the Australian Height Datum (A.H.D.).
 - Origin of levels SSM 40537 RL 31.391 AHD
 - Boundaries not marked.
 - Tree trunks and spreads are diagrammatic only.
 - No investigation of underground services has been made. Contact the authorities prior to any excavation on or near the site.
 - The boundaries should be marked prior to any construction near the boundaries.
 - E - Denotes overhead electricity wires.
 - Covenant B833965

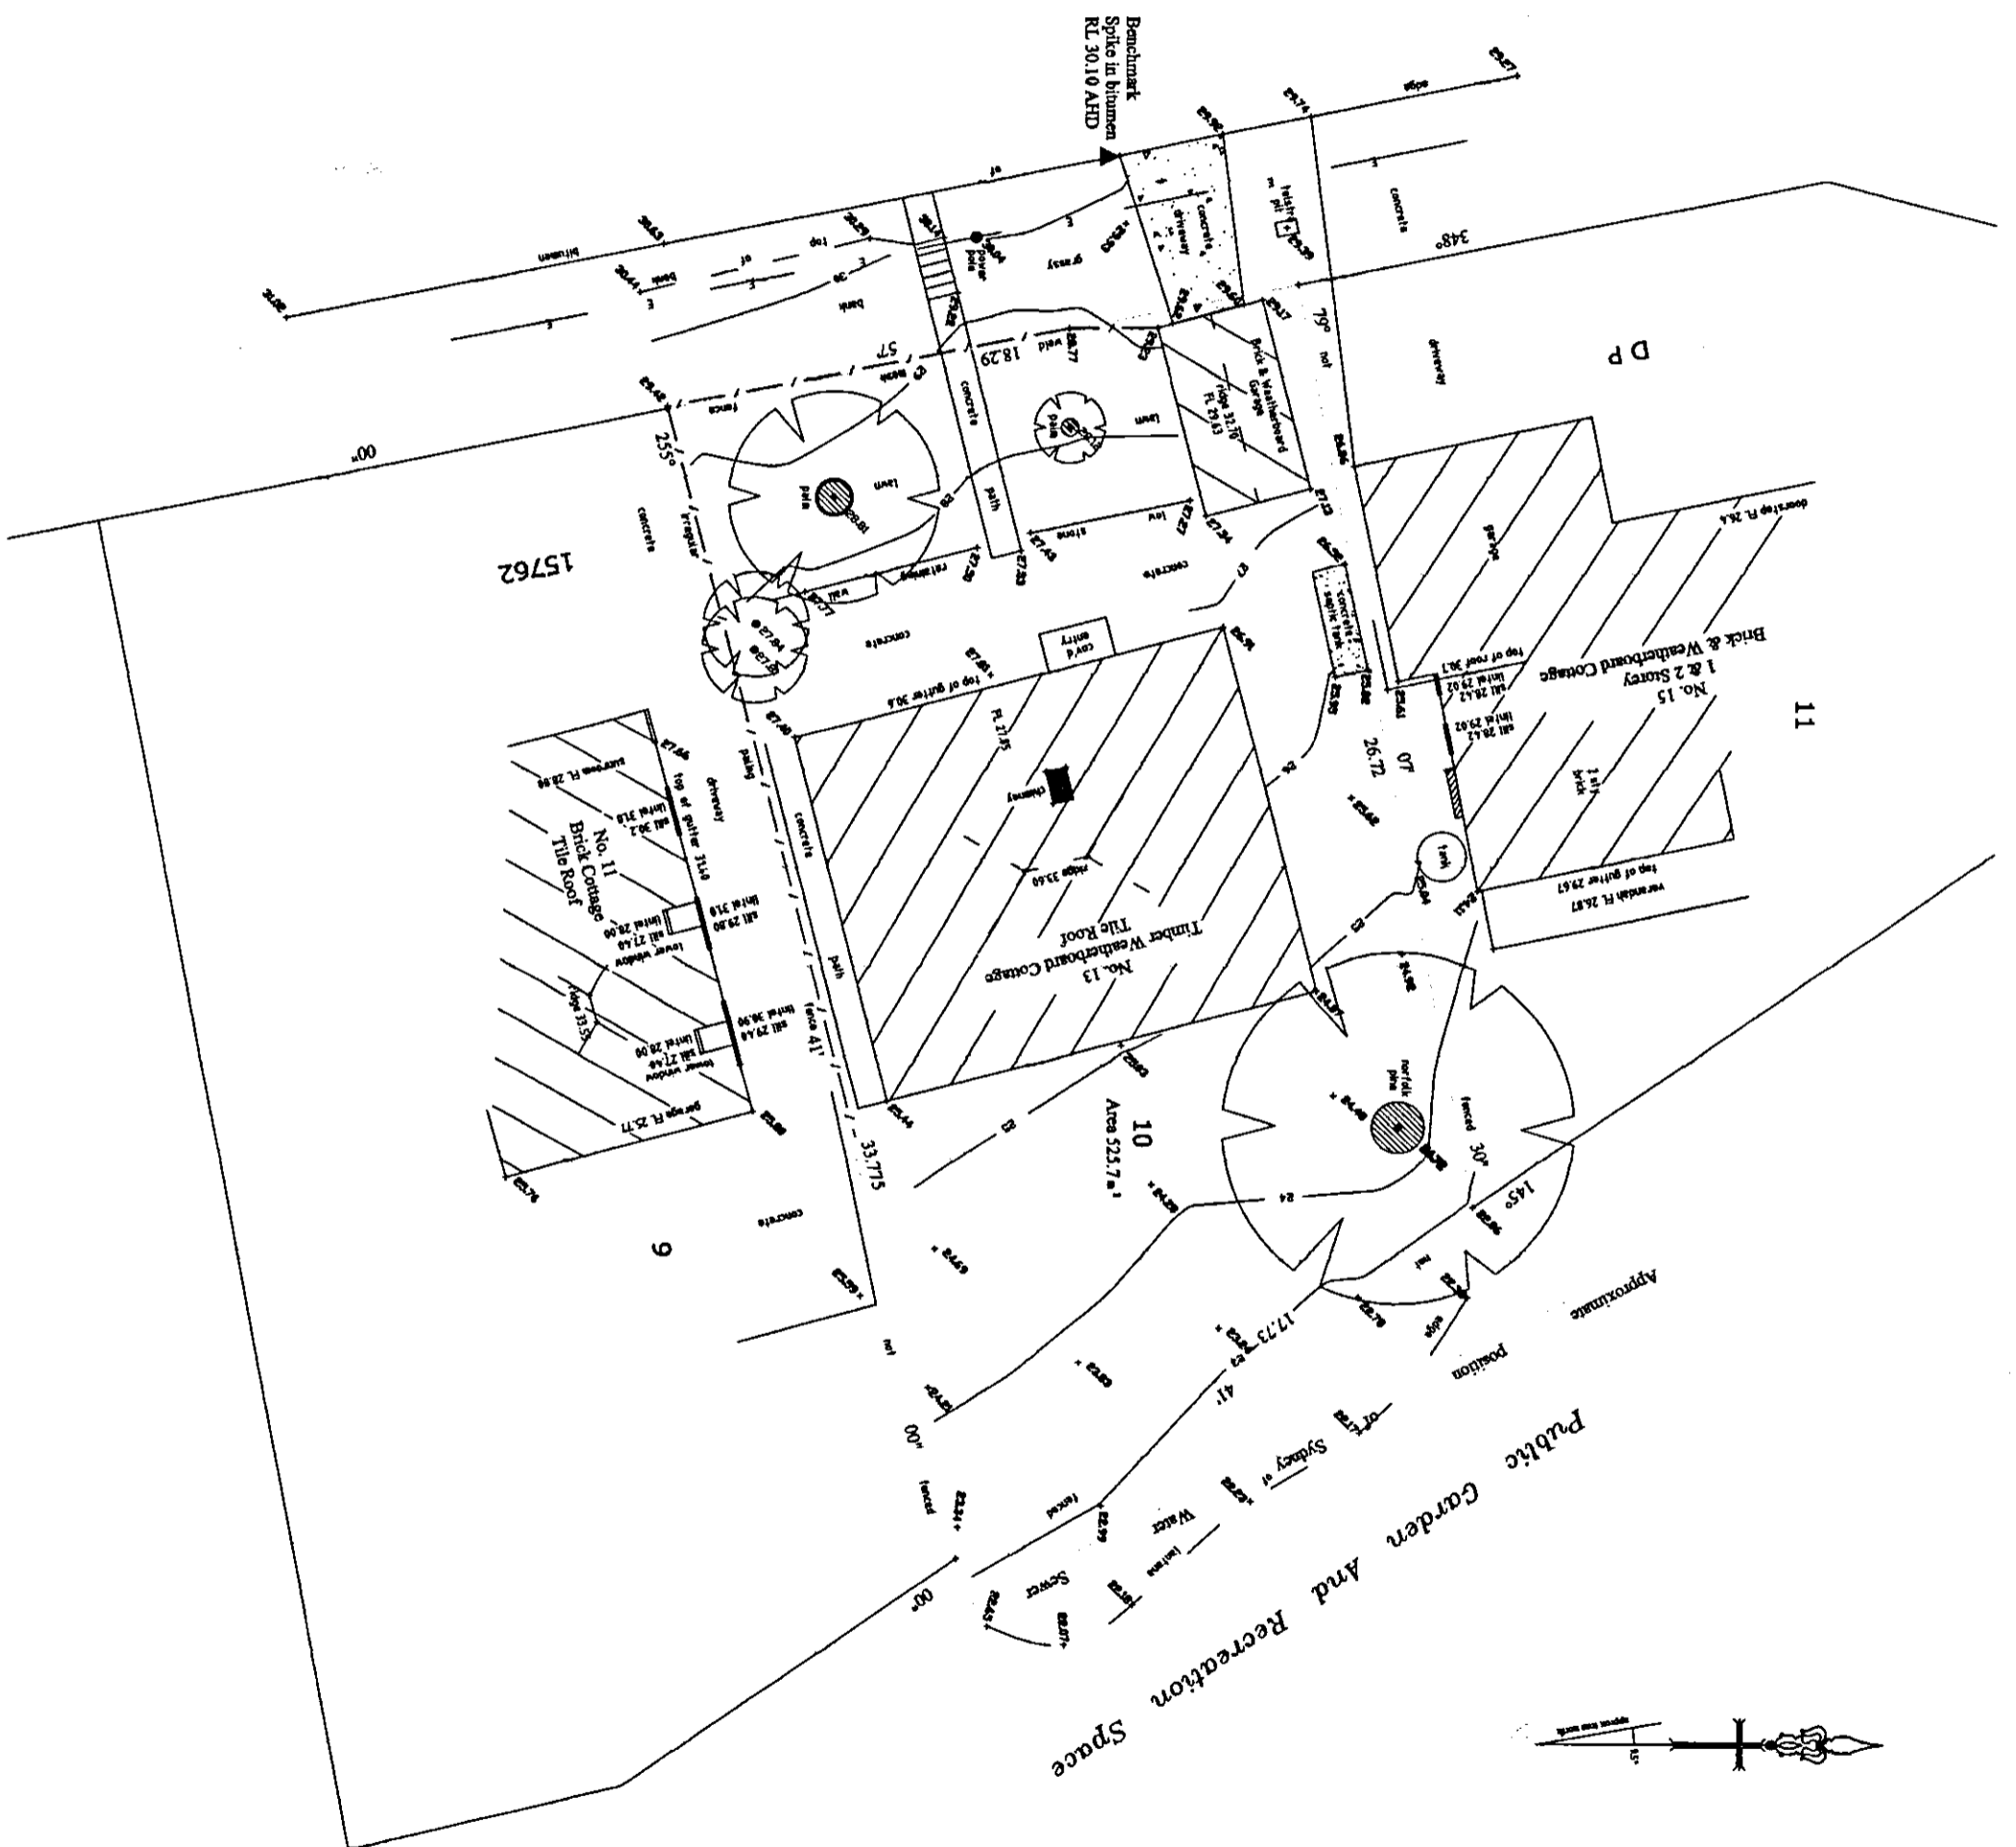

SCANNED
 05 OCT 2006
 PITWATER COUNCIL