

 
[illegible]

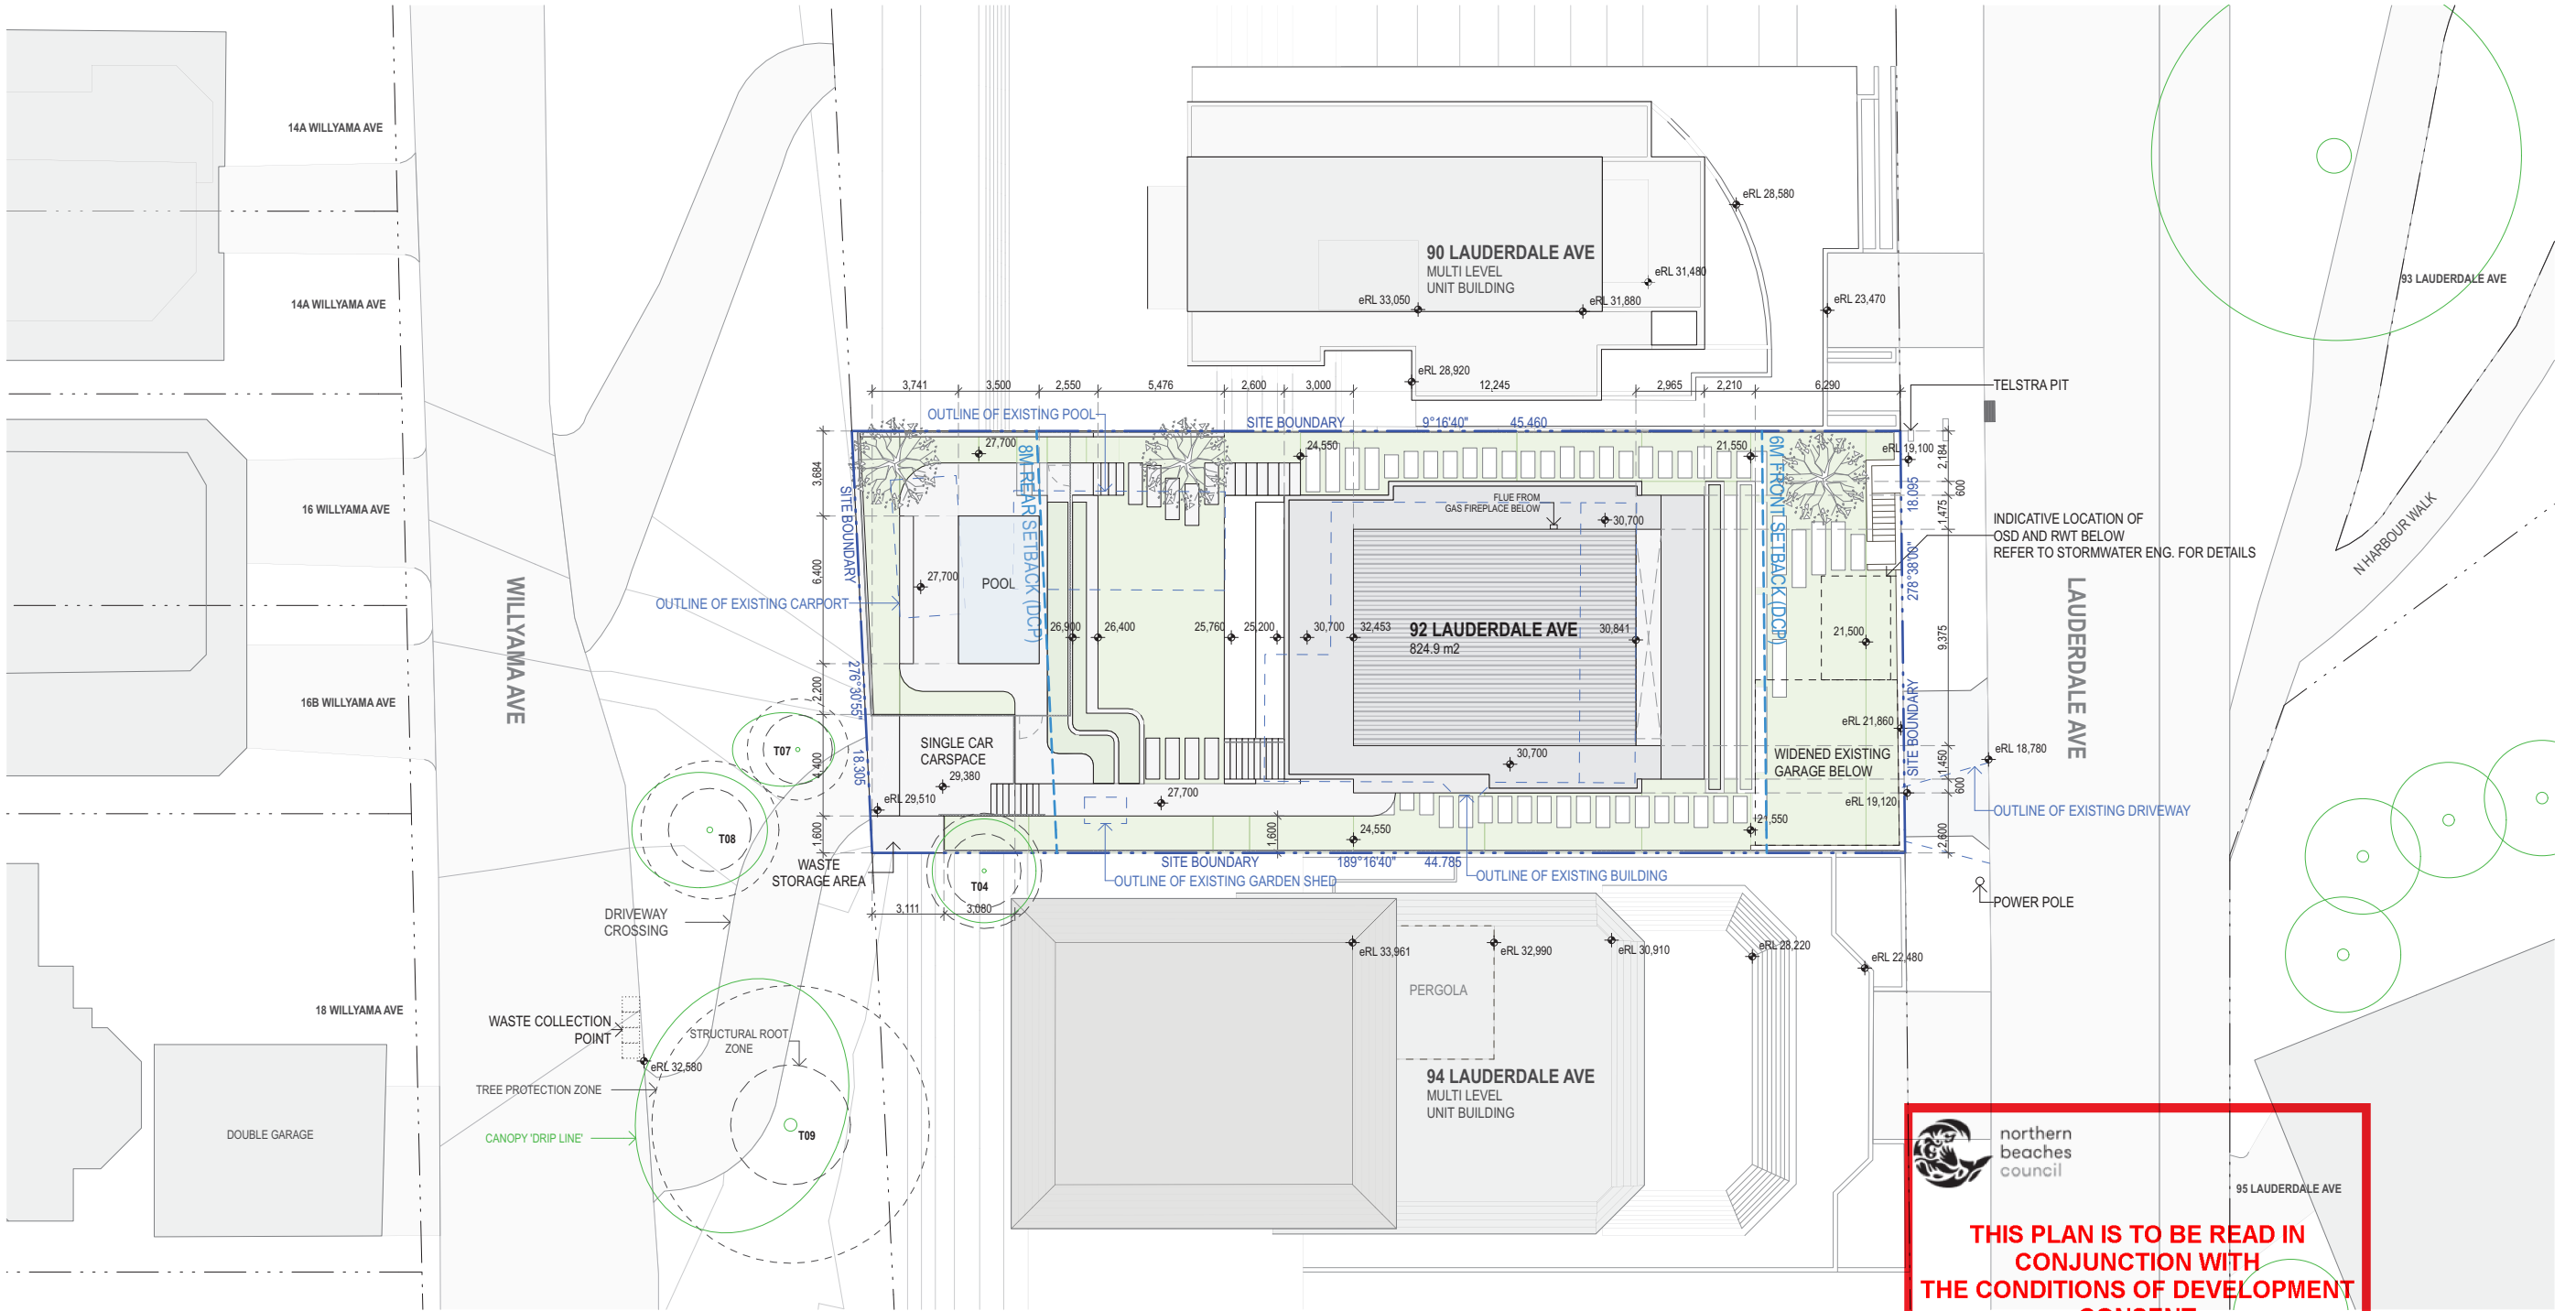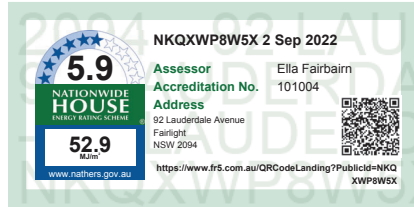

1 SITE PLAN
1:300

REV	DATE	DESCRIPTION
DA01	31.08.2022	DEVELOPMENT APPLICATION

NOTES



THIS DRAWING SHOULD BE READ IN CONJUNCTION WITH ALL RELEVANT CONTRACTS, SPECIFICATIONS, REPORTS AND DRAWINGS. DO NOT SCALE DRAWINGS. DIMENSIONS GOVERN. VERIFY ALL DIMENSIONS ON SITE BEFORE CONSTRUCTION. COPYRIGHT OF THIS DRAWING IS VESTED IN ARCHER OFFICE PTY LTD.

CONSULTANTS

ARBORIST - EARTHScape
BASIX - ELLA FAIRBAIRN
CIVIL ENG. - PARTRIDGE
GEOTECH - CROZIER GEOTECH
HERITAGE - JOHN OULTRAM
LANDSCAPE ARCHITECT - 360
PLANNER - GYDE
STORMWATER ENG. - PARTRIDGE

CLIENT

EDWINA & LACHLAN COBON
92 LAUDERDALE AVENUE
FAIRLIGHT
NSW 2094

ARCHITECT

ARCHER OFFICE

ARCHER OFFICE PTY LTD
LEVEL 5, RECORDS BUILDING
1 PRINCE ALBERT ROAD
SYDNEY NSW 2000
NOMINATED ARCHITECT:
TOMEK ARCHER 9495

PROJECT

92 LAUDERDALE AVENUE

PROJECT NUMBER	DRAWN	CHECKED	SHEET SCALE	SHEET SIZE
2105	NK	TA	1:300	A3

DRAWING TITLE

SITE PLAN

DOCUMENTATION STAGE


DA

SHEET NUMBER



A050

REVISION

DA01
31 AUGUST 2022

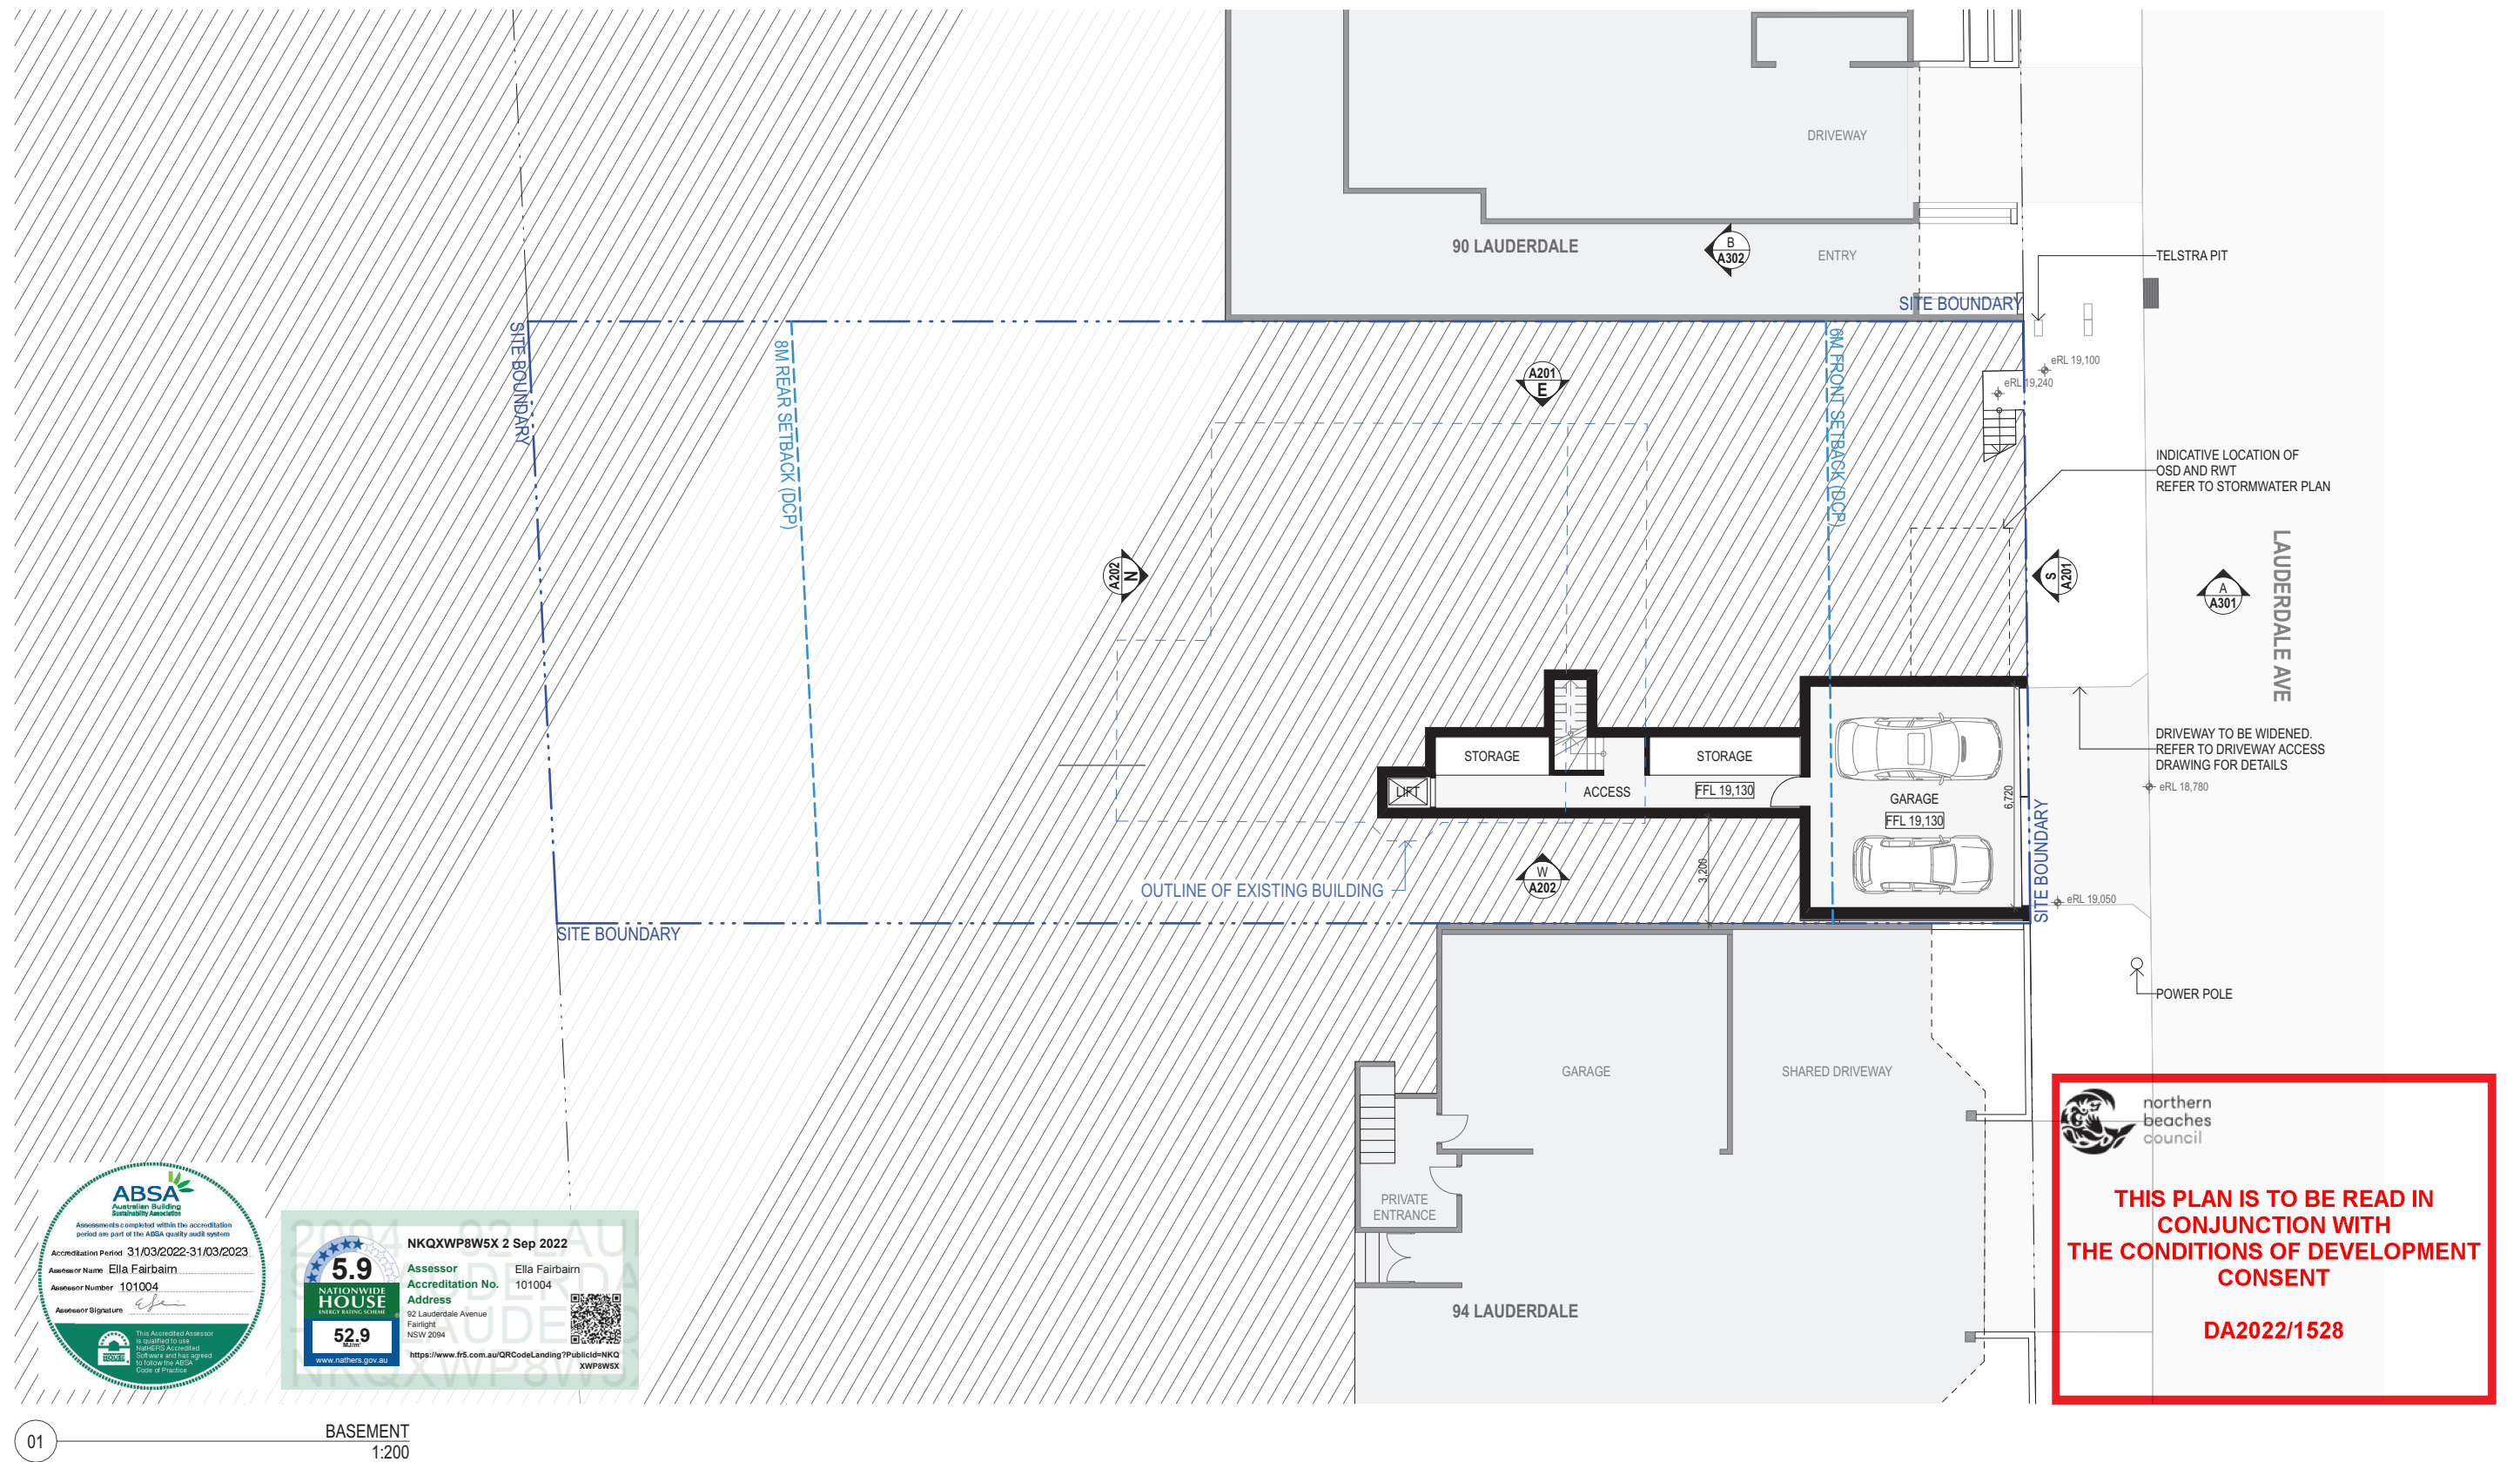


REV	DATE	DESCRIPTION	NOTES	SCALE BAR	CONSULTANTS	CLIENT	ARCHITECT	PROJECT	DRAWING TITLE
DA01	31.08.2022	DEVELOPMENT APPLICATION		0 1 5 10 SCALE 1:200 @ A3	ARBORIST - EARTHSCAPE BASIX - ELLA FAIRBAIRN CIVIL ENG. - PARTRIDGE GEOTECH - CROZIER GEOTECH HERITAGE - JOHN OULTRAM LANDSCAPE ARCHITECT- 360 PLANNER - GYDE STORMWATER ENG. - PARTRIDGE	EDWINA & LACHLAN COBON 92 LAUDERDALE AVENUE FAIRLIGHT NSW 2094	ARCHER OFFICE ARCHER OFFICE PTY LTD LEVEL 5, RECORDS BUILDING 1 PRINCE ALBERT ROAD SYDNEY NSW 2000 NOMINATED ARCHITECT:	92 LAUDERDALE AVENUE PROJECT NUMBER 2105	BASEMENT FLOOR PLAN
								DRAWN NK	DOCUMENTATION STAGE DA
								CHECKED TA	SHEET NUMBER A101
								SHEET SCALE 1:200	REVISION DA01
								SHEET SIZE A3	ISSUE DATE 31 AUGUST 2022

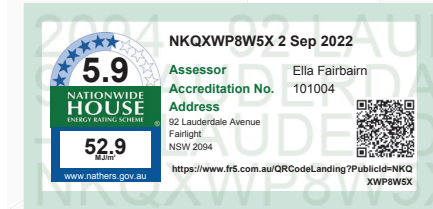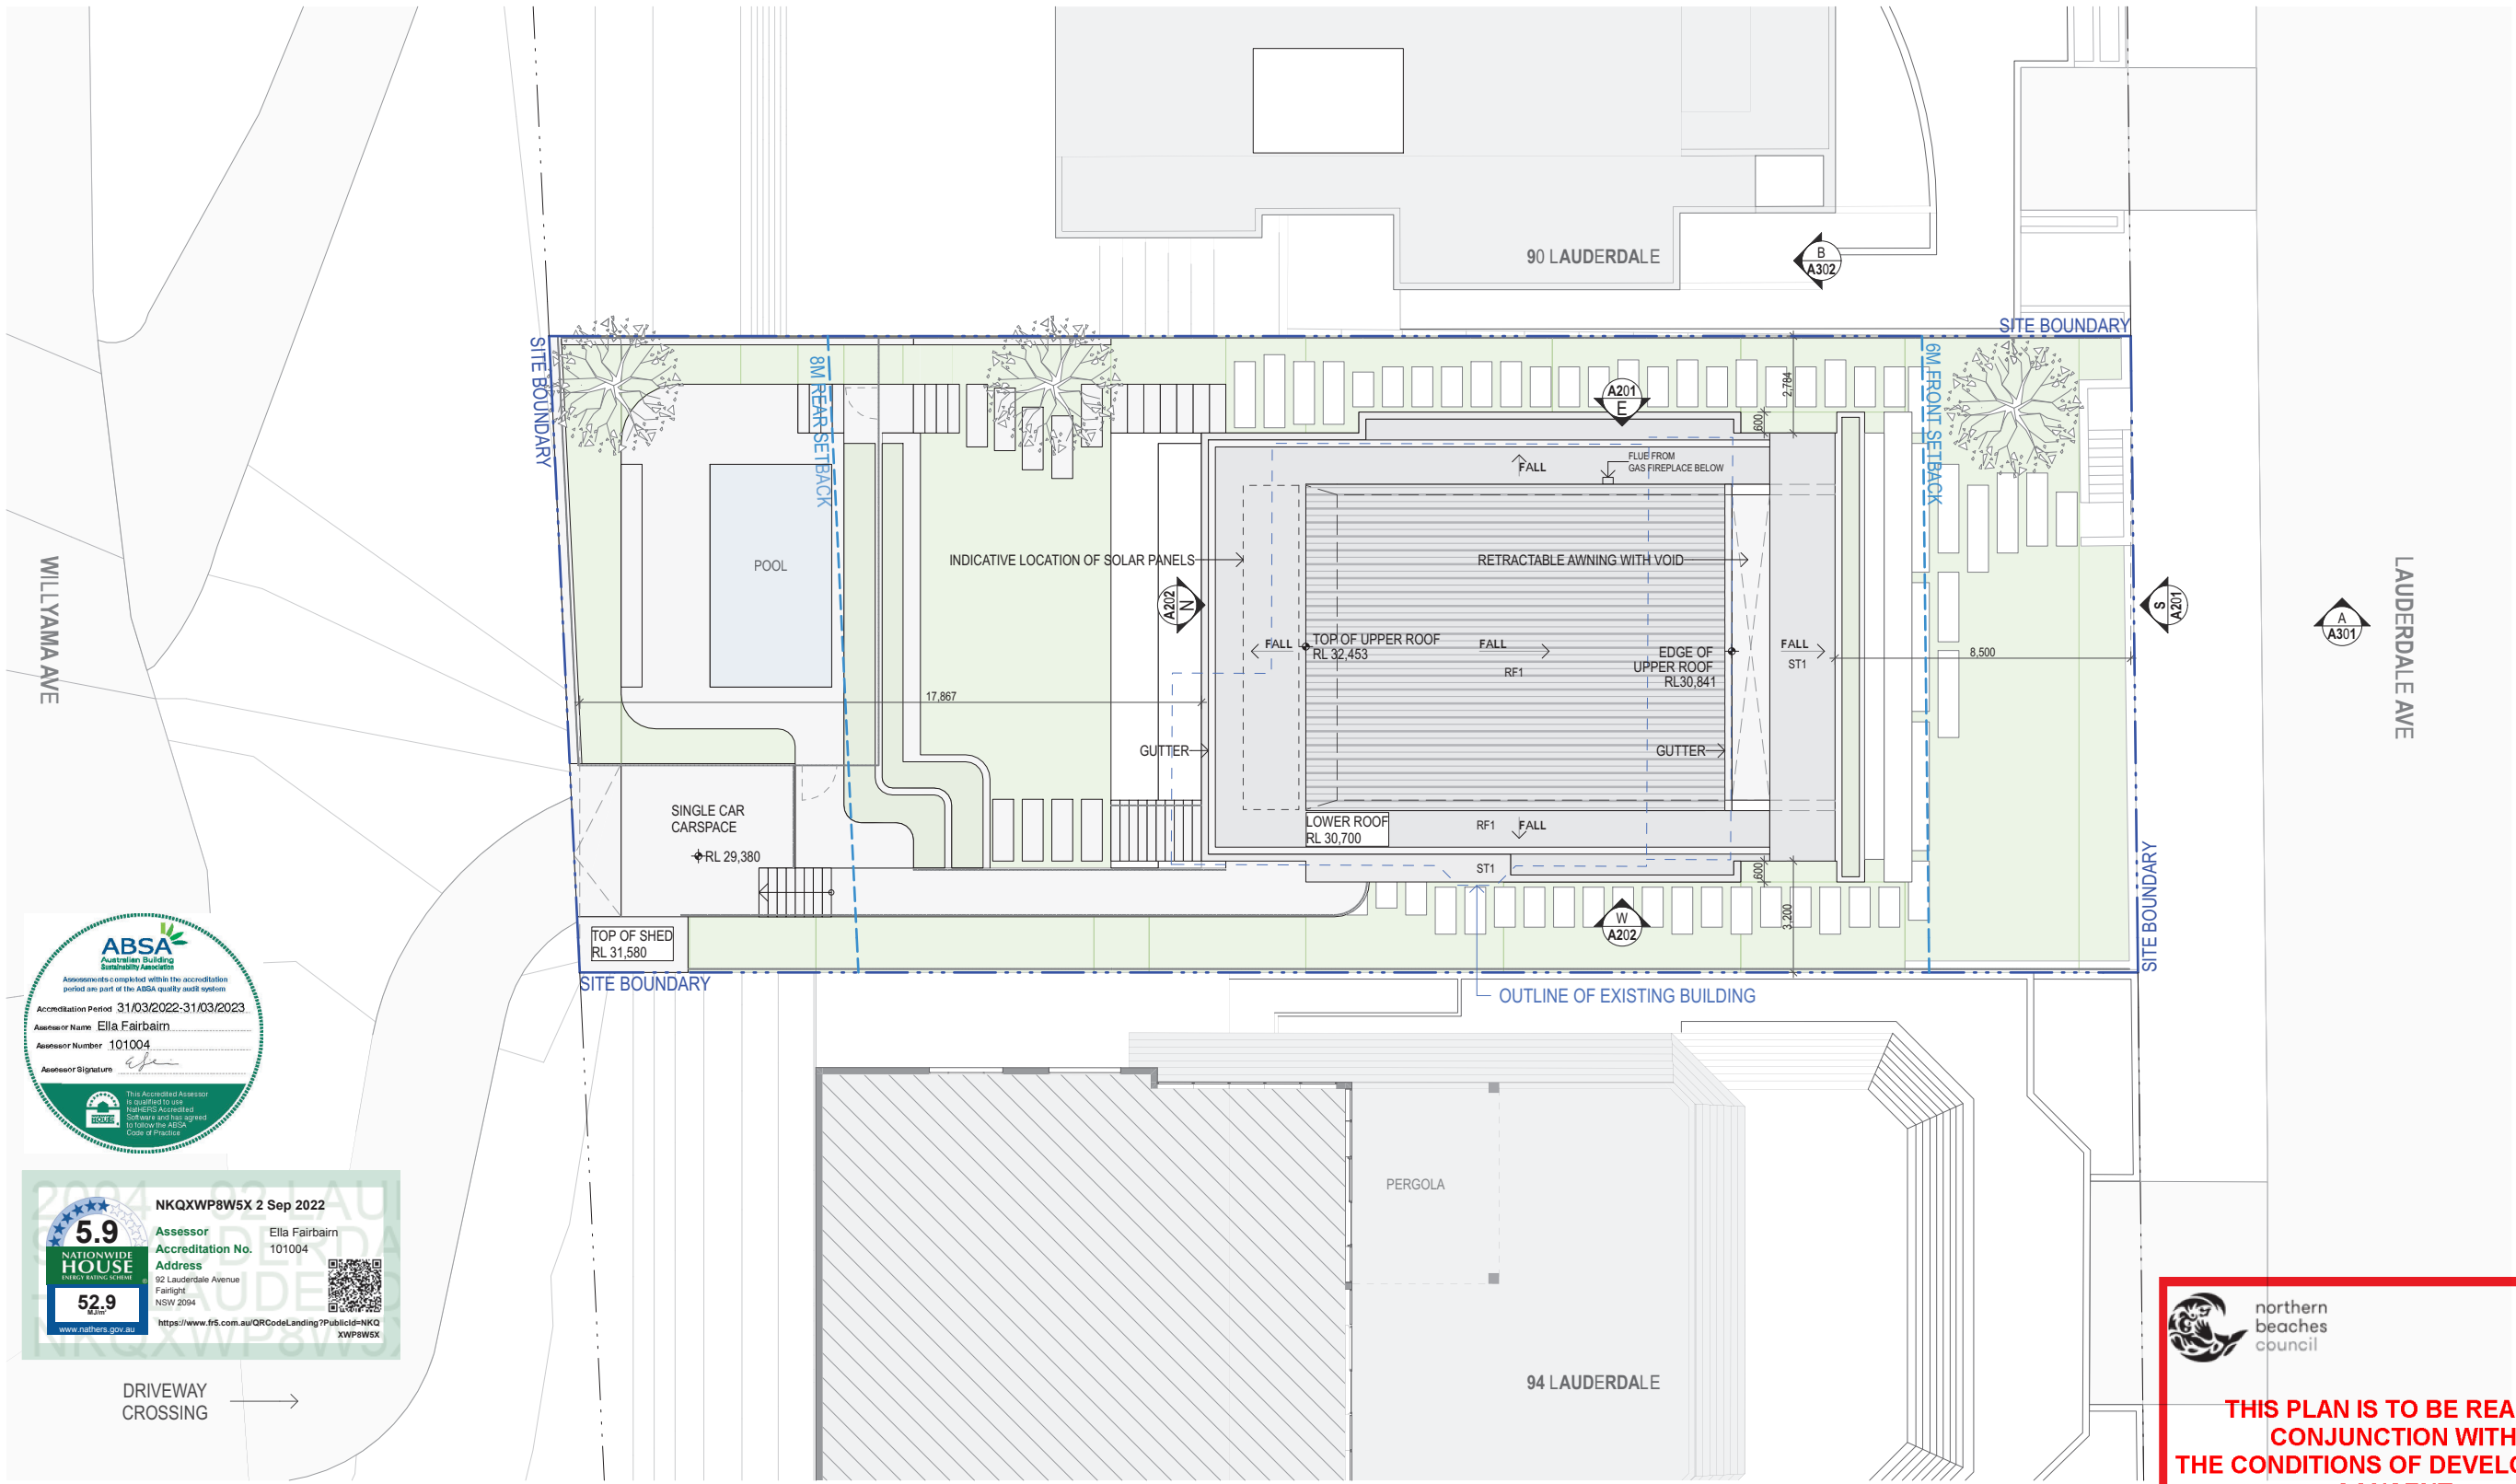


THIS PLAN IS TO BE READ IN CONJUNCTION WITH THE CONDITIONS OF DEVELOPMENT CONSENT

DA2022/1528


REV	DATE	DESCRIPTION	NOTES	SCALE BAR	CONSULTANTS	CLIENT	ARCHITECT	PROJECT	DRAWING TITLE
DA01	31.08.2022	DEVELOPMENT APPLICATION		0 1 5 10 SCALE 1:200 @ A3	ARBORIST - EARTHScape BASIX - ELLA FAIRBAIRN CIVIL ENG. - PARTRIDGE GEOTECH - CROZIER GEOTECH HERITAGE - JOHN OULTRAM LANDSCAPE ARCHITECT- 360 PLANNER - GYDE STORMWATER ENG. - PARTRIDGE	EDWINA & LACHLAN COBON 92 LAUDERDALE AVENUE FAIRLIGHT NSW 2004	ARCHER OFFICE PTY LTD LEVEL 5, RECORDS BUILDING 1 PRINCE ALBERT ROAD SYDNEY NSW 2000 NOMINATED ARCHITECT:	92 LAUDERDALE AVENUE PROJECT NUMBER 2105	ROOF PLAN
								DRAWN NK	CHECKED TA
								SHEET SCALE 1:200	SHEET SIZE A3
								DOCUMENTATION STAGE DA	SHEET NUMBER A105
								REVISION DA01 ISSUE DATE 31 AUGUST 2022	

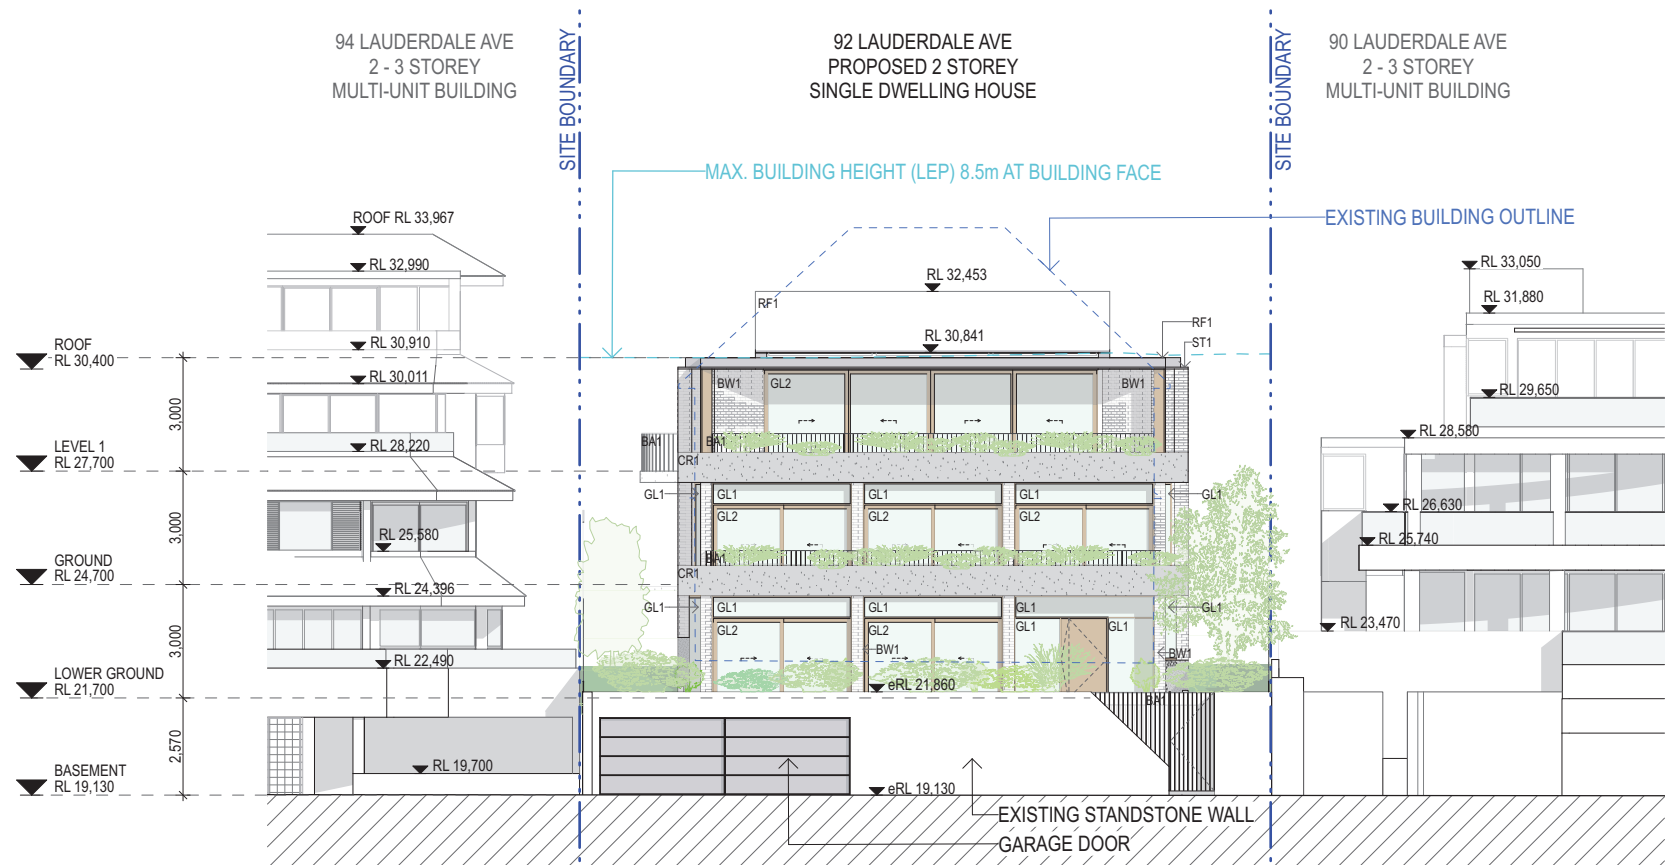

01 SOUTH ELEVATION
1:200

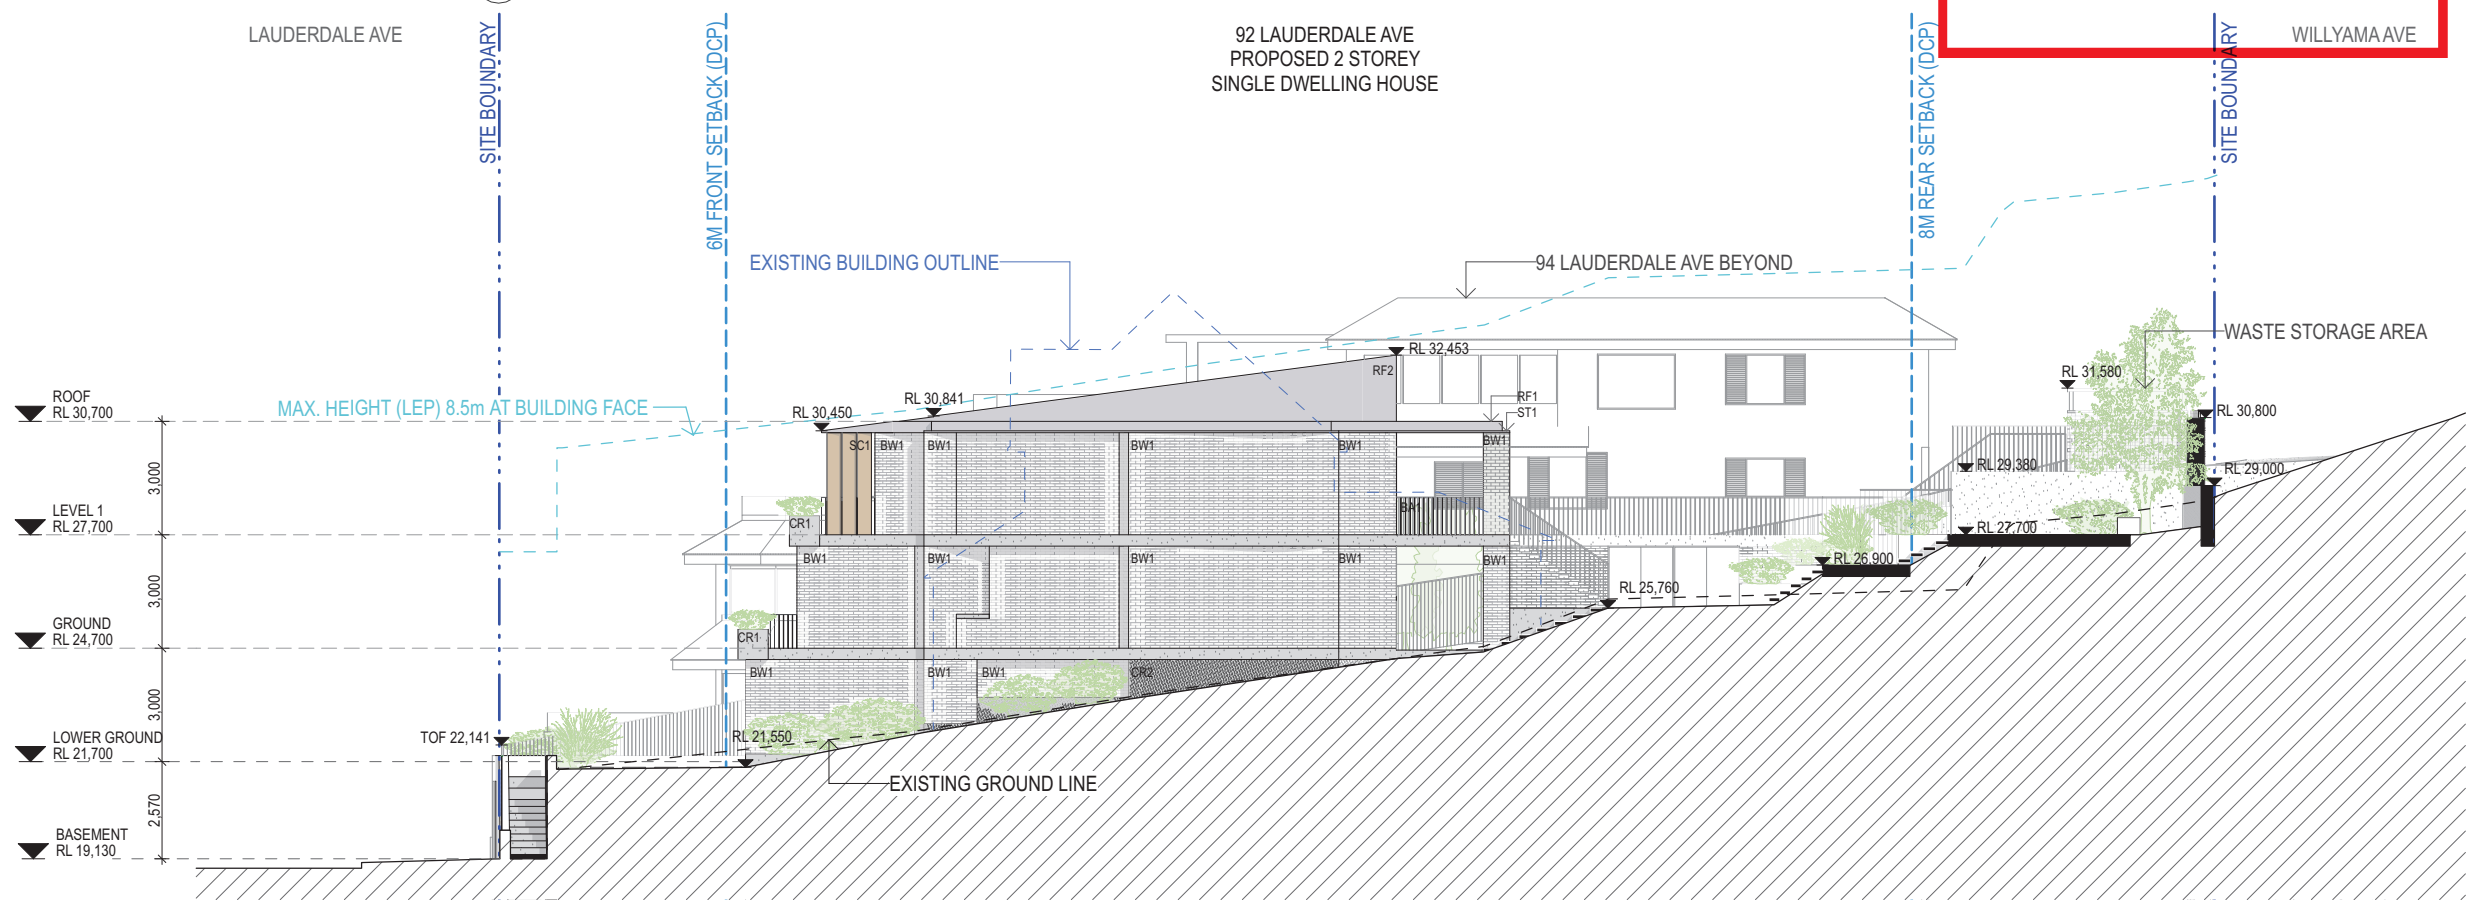

02 EAST ELEVATION
1:200

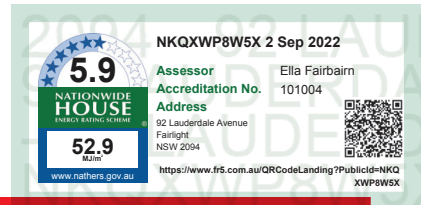




northern beaches council

THIS PLAN IS TO BE READ IN CONJUNCTION WITH THE CONDITIONS OF DEVELOPMENT CONSENT


DA2022/1528

WILLYAMA AVE


REV	DATE	DESCRIPTION	NOTES	SCALE BAR	CONSULTANTS	CLIENT	ARCHITECT	PROJECT	DRAWING TITLE				
DA01	31.08.2022	DEVELOPMENT APPLICATION		<									

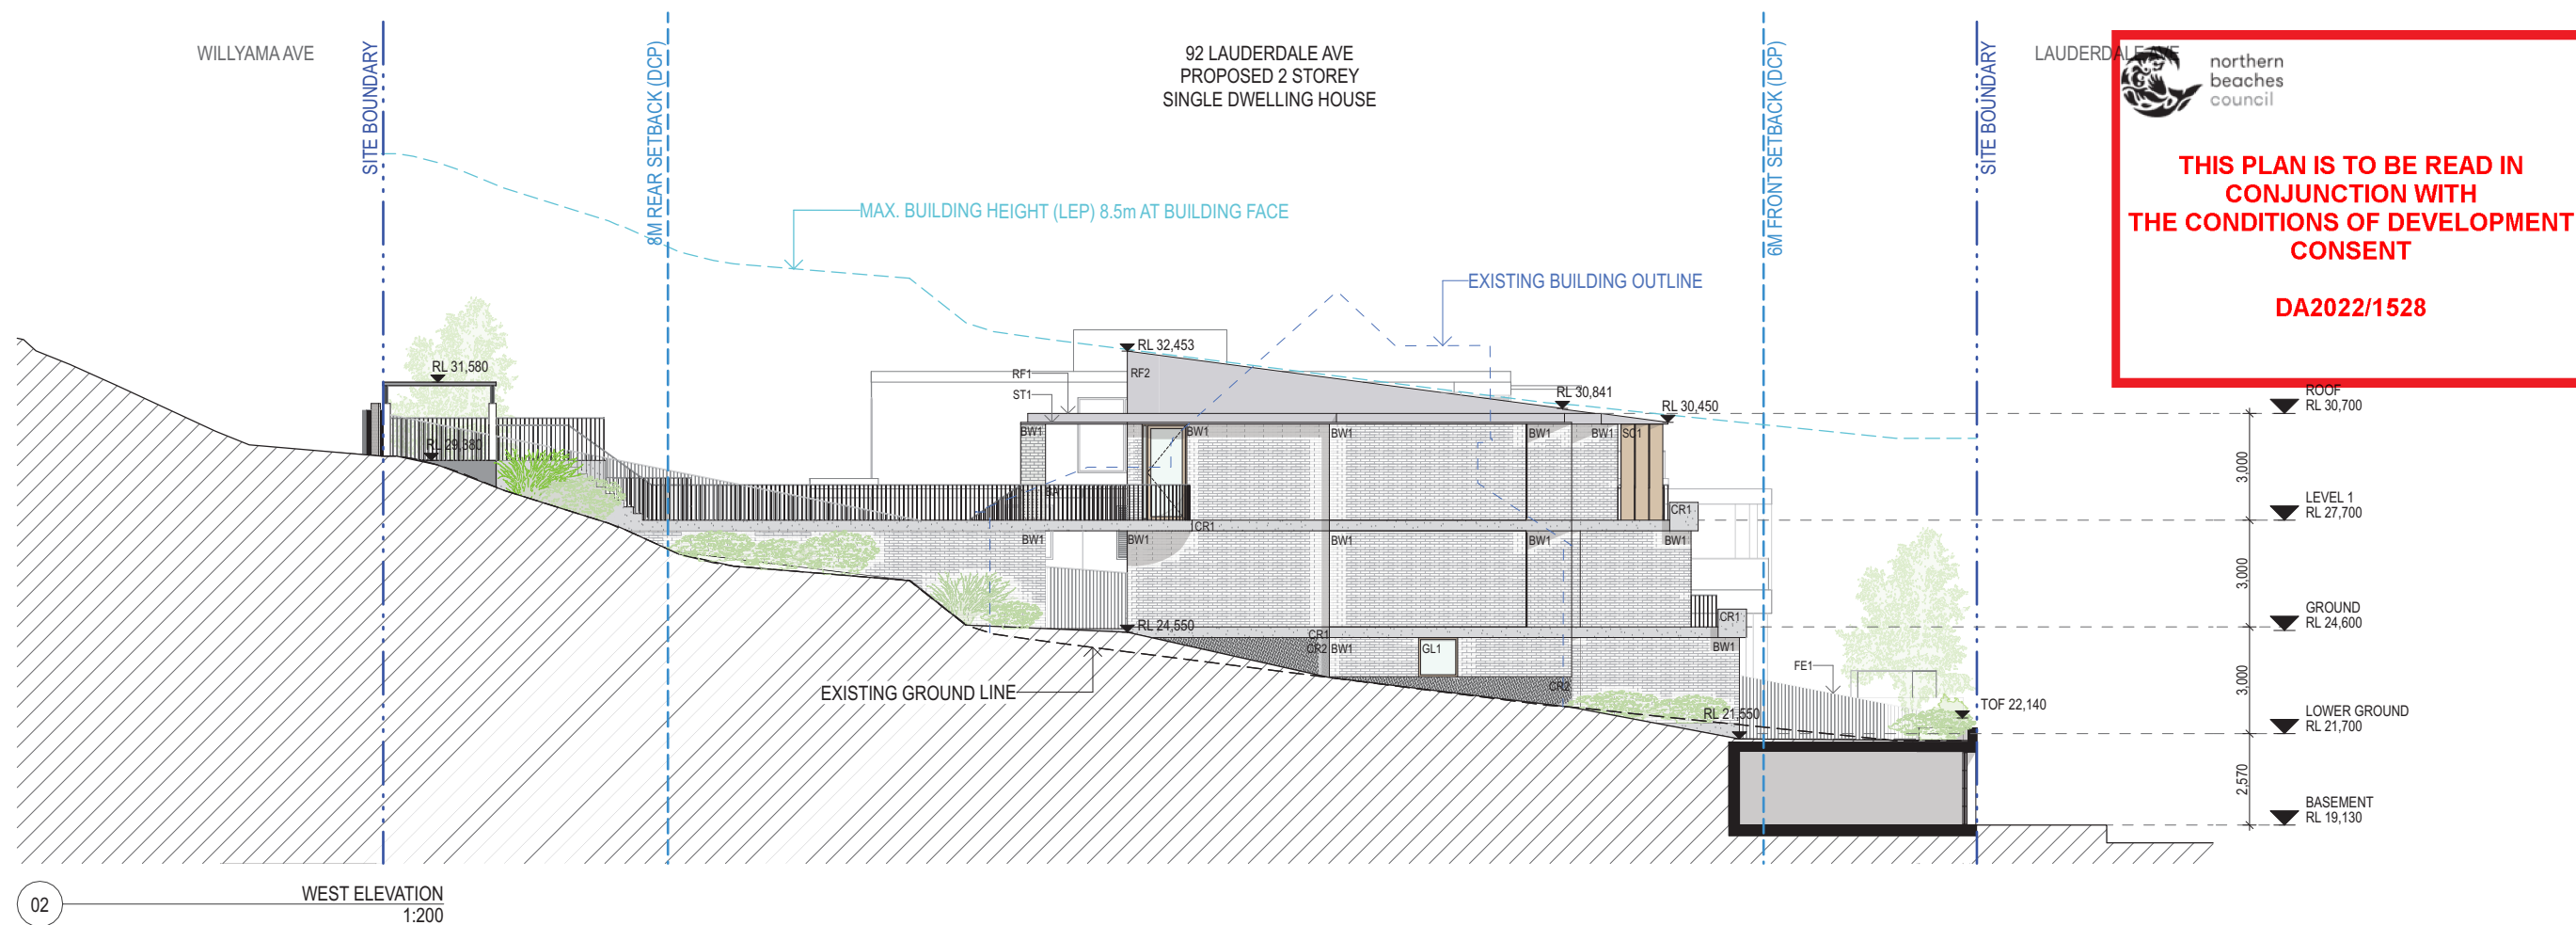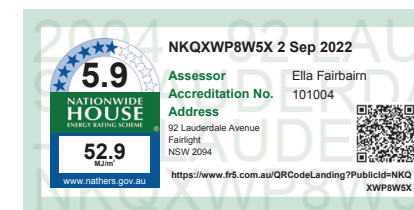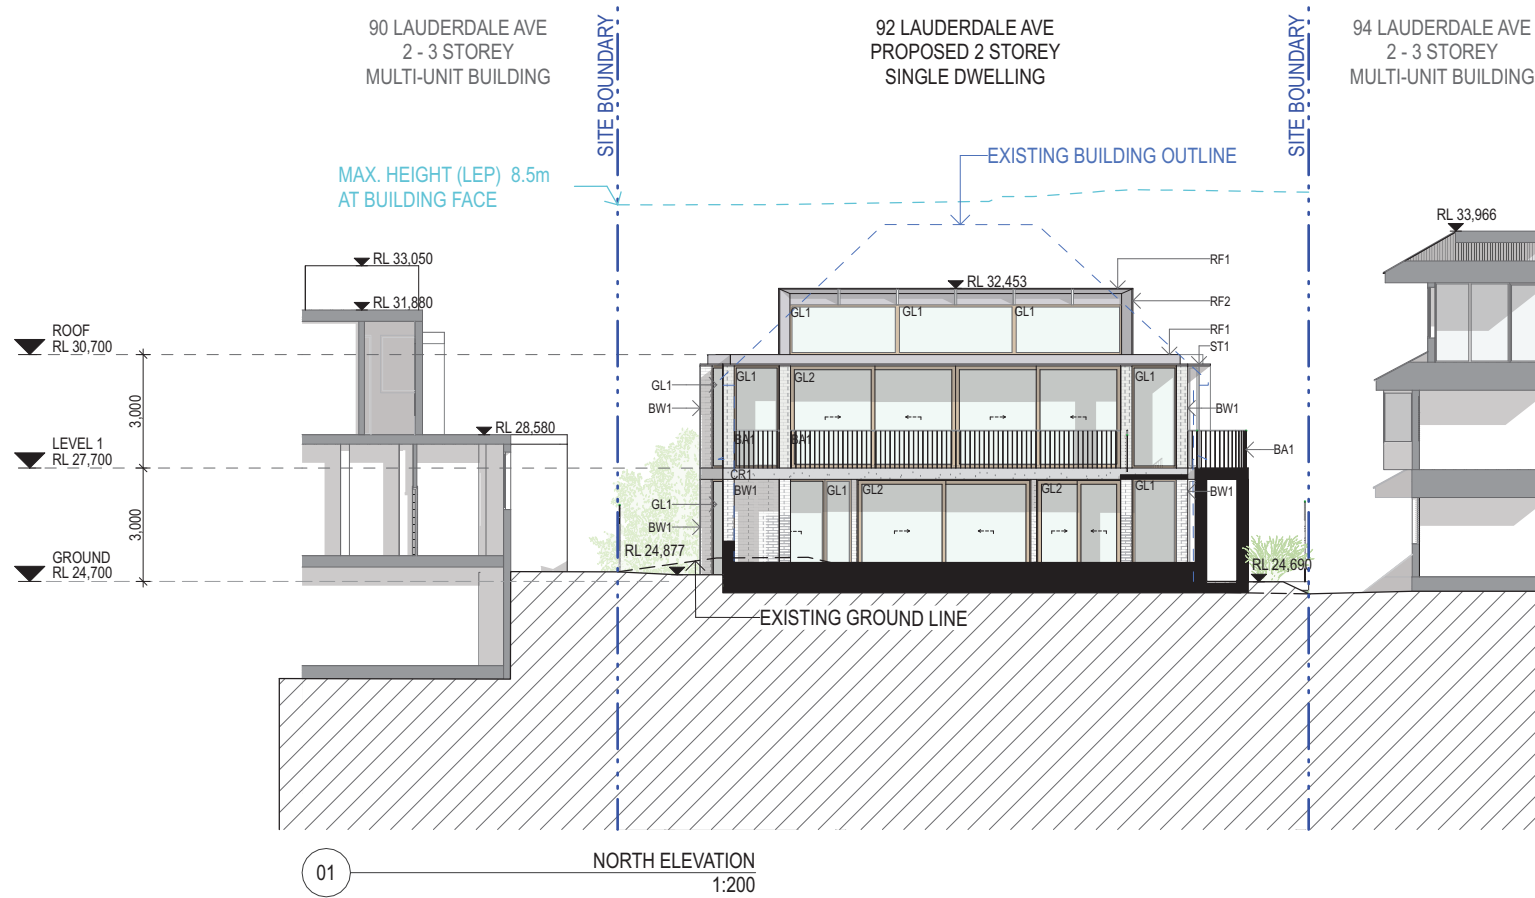

REV	DATE	DESCRIPTION	NOTES	SCALE BAR	CONSULTANTS	CLIENT	ARCHITECT	PROJECT	DRAWING TITLE
DA01	31.08.2022	DEVELOPMENT APPLICATION		0 1 5 10 SCALE 1:200 @ A3 THIS DRAWING SHOULD BE READ IN CONJUNCTION WITH ALL RELEVANT CONTRACTS, SPECIFICATIONS, REPORTS AND DRAWINGS. DO NOT SCALE DRAWINGS. DIMENSIONS GOVERN. VERIFY ALL DIMENSIONS ON SITE BEFORE CONSTRUCTION. COPYRIGHT OF THIS DRAWING IS VESTED IN ARCHER OFFICE PTY LTD.	ARBORIST - EARTHSCAPE BASIX - ELLA FAIRBAIRN CIVIL ENG. - PARTRIDGE GEOTECH - CROZIER GEOTECH HERITAGE - JOHN OULTRAM LANDSCAPE ARCHITECT-360 PLANNER - GYDE STORMWATER ENG. - PARTRIDGE	EDWINA & LACHLAN COBON 92 LAUDERDALE AVENUE FAIRLIGHT NSW 2094	ARCHER OFFICE PTY LTD LEVEL 5, RECORDS BUILDING 1 PRINCE ALBERT ROAD SYDNEY NSW 2000 NOMINATED ARCHITECT: ARCHER OFFICE ABN 78162692293 P: +612 9191 7326 E: STUDIO@ARCHEROFFICE.COM TOMEK ARCHER 9495	92 LAUDERDALE AVENUE PROJECT NUMBER 2105 DRAWN NK CHECKED TA SHEET SCALE 1:200 SHEET SIZE A3	NORTH & WEST ELEVATION DOCUMENTATION STAGE DA SHEET NUMBER A202 REVISION DA01 31 AUGUST 2022

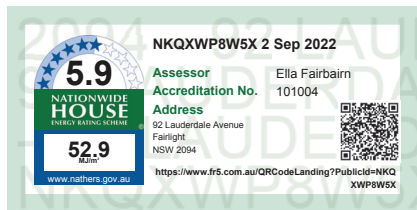

REV	DATE	DESCRIPTION	NOTES	SCALE BAR	CONSULTANTS	CLIENT	ARCHITECT	PROJECT	DRAWING TITLE						
DA01	31.08.2022	DEVELOPMENT APPLICATION		01510 SCALE 1:200 @ A3 THIS DRAWING SHOULD BE READ IN CONJUNCTION WITH ALL RELEVANT CONTRACTS, SPECIFICATIONS, REPORTS AND DRAWINGS. DO NOT SCALE DRAWINGS. DIMENSIONS GOVERN. VERIFY ALL DIMENSIONS ON SITE BEFORE CONSTRUCTION. COPYRIGHT OF THIS DRAWING IS VESTED IN ARCHER OFFICE PTY LTD.	ARBORIST - EARTHSCAPE BASIX - ELLA FAIRBAIRN CIVIL ENG. - PARTRIDGE GEOTECH - CROZIER GEOTECH HERITAGE - JOHN QUILTRAM LANDSCAPE ARCHITECT- 360 PLANNER - GYDE STORMWATER ENG. - PARTRIDGE	EDWINA & LACHLAN COBON 92 LAUDERDALE AVENUE FAIRLIGHT NSW 2094	ARCHER OFFICE ARCHER OFFICE PTY LTD LEVEL 5, RECORDS BUILDING 1 PRINCE ALBERT ROAD SYDNEY NSW 2000 NOMINATED ARCHITECT: TOMEK ARCHER 9495	92 LAUDERDALE AVENUE	SECTION A						
								PROJECT NUMBER	DRAWN	CHECKED	SHEET SCALE	SHEET SIZE	DOCUMENTATION STAGE	SHEET NUMBER	REVISION
								2105	NK	TA	1:200	A3	DA	A301	DA01 ISSUE DATE 31 AUGUST 2022

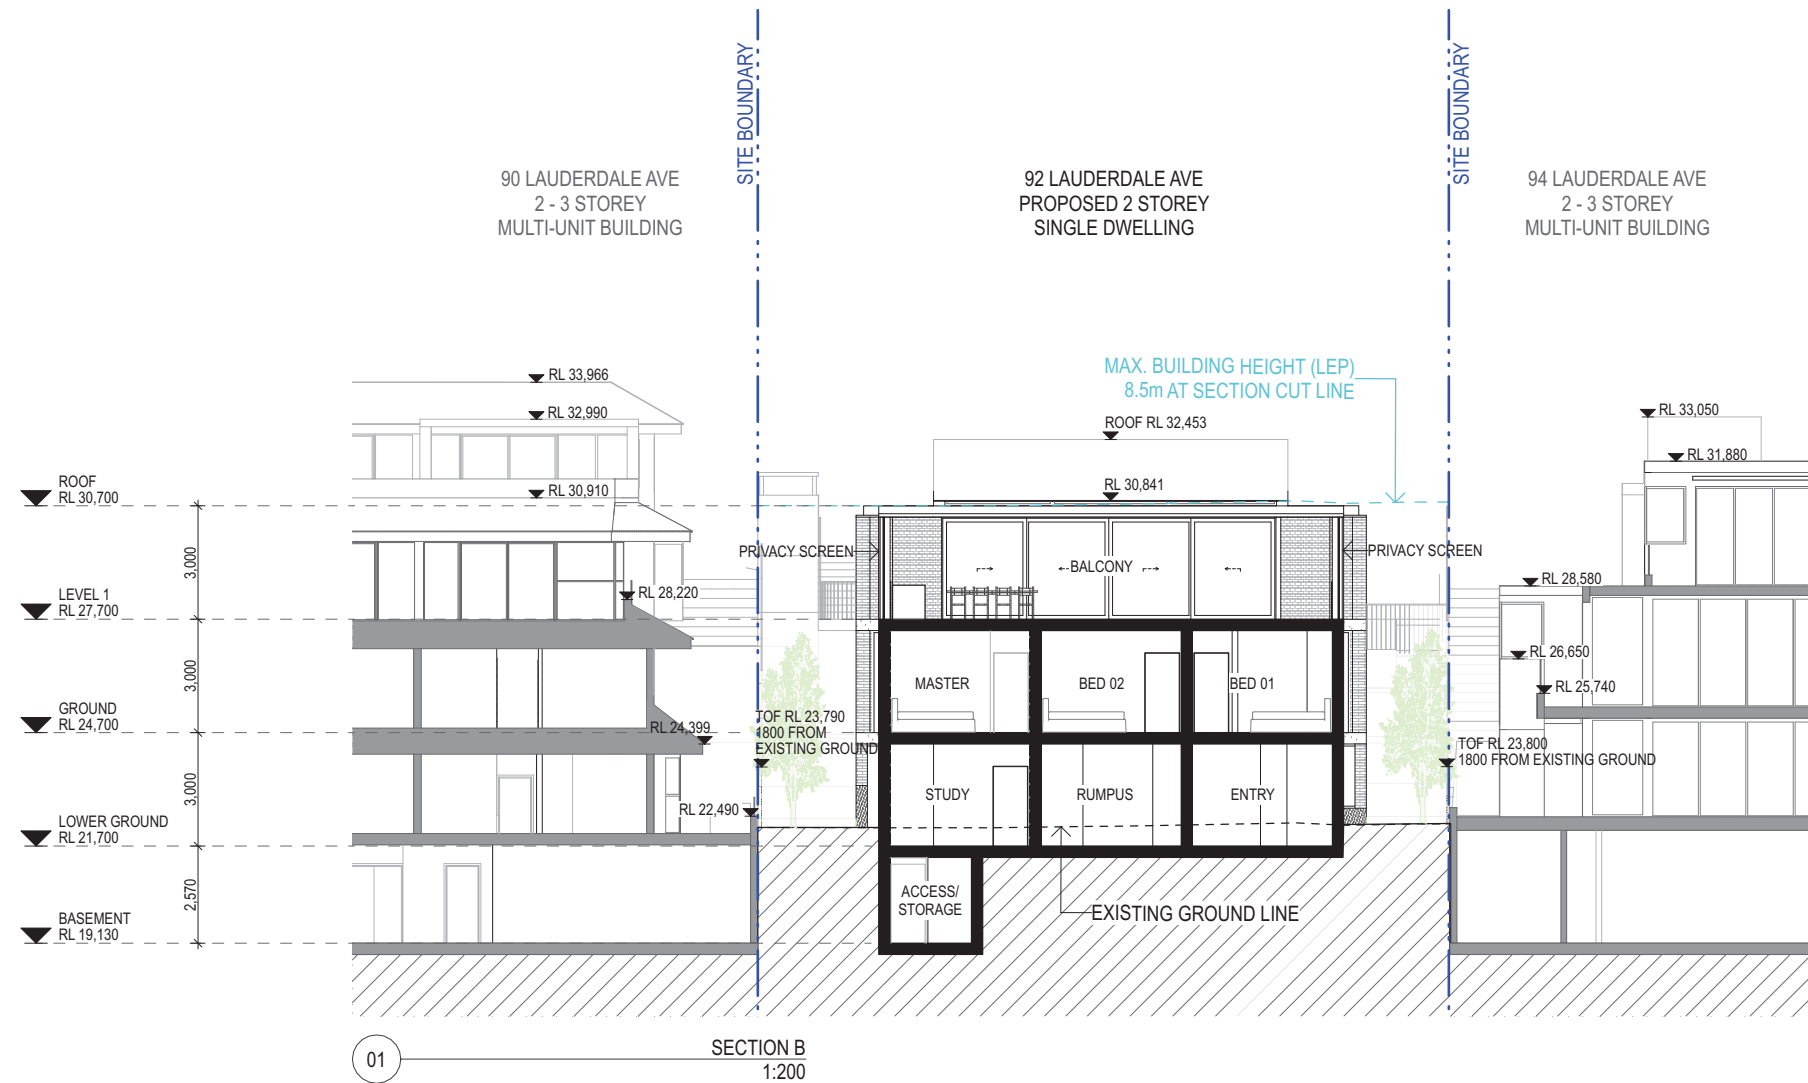

THIS PLAN IS TO BE READ IN
CONJUNCTION WITH
THE CONDITIONS OF DEVELOPMENT
CONSENT

DA2022/1528

REV	DATE	DESCRIPTION	NOTES	SCALE BAR	CONSULTANTS	CLIENT	ARCHITECT	PROJECT	DRAWING TITLE
DA01	31.08.2022	DEVELOPMENT APPLICATION		0 1 5 10 SCALE 1:200 @ A3	ARBORIST - EARTHSCAPE BASIX - ELLA FAIRBAIRN CIVIL ENG. - PARTRIDGE GEOTECH - CROZIER GEOTECH HERITAGE - JOHN OULTRAM LANDSCAPE ARCHITECT- 360 PLANNER - GYDE STORMWATER ENG. - PARTRIDGE	EDWINA & LACHLAN COBON 92 LAUDERDALE AVENUE FAIRLIGHT NSW 2094	ARCHER OFFICE PTY LTD LEVEL 5, RECORDS BUILDING 1 PRINCE ALBERT ROAD SYDNEY NSW 2000 NOMINATED ARCHITECT:	92 LAUDERDALE AVENUE	SECTION B
							ABN 78162692293 P: +612 9191 7326 E: STUDIO@ARCHEROFFICE.COM TOMEK ARCHER 9495	PROJECT NUMBER 2105	DRAWN NK
								CHECKED TA	SHEET SCALE 1:200
								SHEET SIZE A3	DOCUMENTATION STAGE DA
									SHEET NUMBER A302
									REVISION DA01 ISSUE DATE 31 AUGUST 2022



CR1



BW1



SC1



BA1



RF1



northern
beaches
council

THIS PLAN IS TO BE READ IN
CONJUNCTION WITH
THE CONDITIONS OF DEVELOPMENT
CONSENT

DA2022/1528

MATERIAL FINISHES

CR1	CONCRETE, LIGHT COLOUR
CR2	CEMENT FINISH, LIGHT COLOUR
SC1	PRIVACY SCREEN, MEDIUM COLOUR
BW1	BRICKWORK, LIGHT COLOUR
BA1	BALUSTRADE
RF1	LIGHTWEIGHT METAL ROOF, MEDIUM COLOUR
RF2	LIGHTWEIGHT METAL CLADDING, MEDIUM COLOI
GL1	FIXED GLAZING, CLEAR
GL2	SLIDING DOOR, CLEAR
ST1	STEEL DETAILING, LIGHT COLOUR
FE1	TIMBER FENCE, DARK COLOUR

* FOR DEVELOPMENT APPLICATION ONLY

* All tree dimensions and RLs in metres. All other dimensions in mm unless stated otherwise.

* Do not scale from drawings. Use figured dimensions only. Larger scale drawings and written dimensions take preference.

* All work shall be carried out in accordance with current versions of Australian Standards, BCA and Local Government Regulations.

* Structural Details are indicative only and are subject to Structural Engineer's Details and Specifications.

* Drainage details are subject to Hydraulic / Civil Engineer's Detail and Specification.

* Subbase details including compaction are to Civil and Structural Engineer's Specification.

* Lighting Plans are subject to detailed design by a qualified Lighting Consultant or Electrical Contractor.

* Water Feature Details are indicative only and are subject to detailed design by a specialist Water Feature designer.

* Service location on plans are indicative only. *360 Degrees Landscape Architects Pty Ltd* accepts no responsibility for the accuracy of service locations shown or for services not shown. It is the responsibility of the contractor to determine service locations prior to the commencement of work, including contacting *Dial Before You Dig* and performing on site service locations. Locate and protect all services on site and in adjacent public domain. Any damages to services and associated damages remains the responsibility of the contractor and shall be rectified at no cost to the client or any other party.

*All adjoining property elements including but not limited to buildings, walls, trees and paving to be protected. Damaged elements remain the responsibility of the contractor and shall be rectified at no cost to the client or any other party.

* Existing trees to be retained are to be protected to Council and Project Arborist's requirements. No vehicular traffic, stockpiling or storage of materials within Tree Protection Zones (TPZs).

* No responsibility will be taken by 360 Degrees Landscape Architects Pty Ltd for any variations in design, construction method, materials specified and general specifications without permission from the Project Landscape Architect.

* This Drawing is copyright to 360 Degrees Landscape Architects Pty Ltd.

* Irrigation by specialist D&C Irrigation Consultant in accordance with the Performance Specification in the Landscape Technical Specification. Refer to Irrigation Consultant documentation for details and requirements of landscape irrigation system.

* Irrigation is to comply with Council Conditions of Consent and Water Authorities.

* All turf and garden beds within the site boundary are to be irrigated unless stated otherwise.

* Irrigation must be spaced at min. 200 centres and adjusted according to plant setout to provide adequate irrigation to all plants.

* Drip irrigation is to be fully concealed by 75mm minimum of mulch.

ID	Botanical Name	Common Name	Size	Qty	Notes
Trees					
Bac cit	Backhousia citriflora	Lemon Myrtle	100L	5	
Cup ana	Cupaniopsis anacardioides	Tuckeroo	200L	2	
Pan tec	Pandanus tectorius	Screw Pine	400L	1	
Ran fit	Randia fitzalanii	Native Gardenia	100L	8	
Palms & Bamboo					
Cha hum	Chamaerops humilis	European Fan Palm	100L	2	
How for	Howea forsteriana	Kentia Palm	Various heights	3	
Shrubs & Perennials					
Acm AM	Acmena smithii 'Allens Magic'	Allens Magic Dwarf Lilly Pilly	300mm	28	
Acm Sub	Acmena smithii 'Sublime'	Sublime Lilly Pilly	400mm	34	
Alp cae	Alpinia caerulea	Common Ginger	300mm	13	
Bux mic	Buxus microphylla	Japanese Box	200mm	20	
Hel pet	Helichrysium petiolare	Liquorice Plant	200mm	10	
Hyd mac	Hydrangea macrophylla	Hydrangea	300mm	32	
Hyd que	Hydrangea quercifolia	Oakleaf Hydrangea	300mm	14	
Hym Lus	Hymenosporum flavum 'Lushious'	Lushious Dwarf Native Frangipani	200mm	36	
Pit MM	Pittosporum 'Miss Muffet'	Miss Muffet	300mm	17	
Sal VW	Salvia leucantha 'Velour White'	Velour White Sage	200mm	5	
Grasses, Lilies & Aquatic					
Alo mac	Alocasia macrorrhiza	Elephant's Ear	200mm	3	
Dia LJ	Dianella caerulea 'Little Jess'	Little Jess Flax Lily	150mm	49	
Lom LT	Lomandra 'Lime Tuff'	Lime Tuff Mat Rush	150mm	150	
Ground Covers					
Cas Cl	Casuarina glauca 'Cousin It'	Cousin It Sheoak	200mm	9	
Dic rep	Dichondra repens	Kidney Weed	150mm	427	
Ros Ire	Rosmarinus officinalis 'Irene'	Prostrate Rosemary	200mm	9	
Vio hed	Viola hederacea	Native Violet	150mm	427	
Climbers					
Bea gra	Beaumontia grandiflora	Nepal Trumpet Flower	200mm	5	
Hoy aus	Hoya australis	Australian Hoya	200mm	32	
Ferns, Cycads & Bromeliads					
Ble SL	Blechnum gibbum 'Silver Lady'	Silver Lady Fern	200mm	27	
Doo asp	Doodia aspera	Prickly Rasp	150mm	23	
Zam fur	Zamia furfuracea	Cardboard Palm	300mm	1	
Succulents & Cactus					
Cra Min	Crassula ovata 'Minima'	Baby Jade	200mm	22	
Sen ser	Senecio serpens	Chalksticks	150mm	5	

Rev	Amendment	Date	By
A	Draft DA	17.08.22	CB
B	Draft DA	30.08.22	CB
C	Draft DA	30.08.22	CB
D	DA	01.09.22	CB

PRELIMINARY
NOT FOR CONSTRUCTION

[illegible]

CLIENT
Lachlan & Edwina Cobon

ARCHITECT
Archer Office

SCALE
N/A @ A1

CHECKED
CB

DRAWN
BHC

STAGE
DA

DWG. TITLE
Landscape Schedules & Notes

PROJECT
92 Lauderdale Avenue, Fairlight

northern
beaches
council

**THIS PLAN IS TO BE READ IN
CONJUNCTION WITH
THE CONDITIONS OF DEVELOPMENT
CONSENT**


DA2022/1528

360
Level 1, 1 Mary's Place
Surry Hills, 2010

P 02 9332 3601
W 360.net.au
ABN 90 146 901 322

L-DA-01


**REFER TO L-DA-05 -
GROUND LEVEL AND
LEVEL 1**

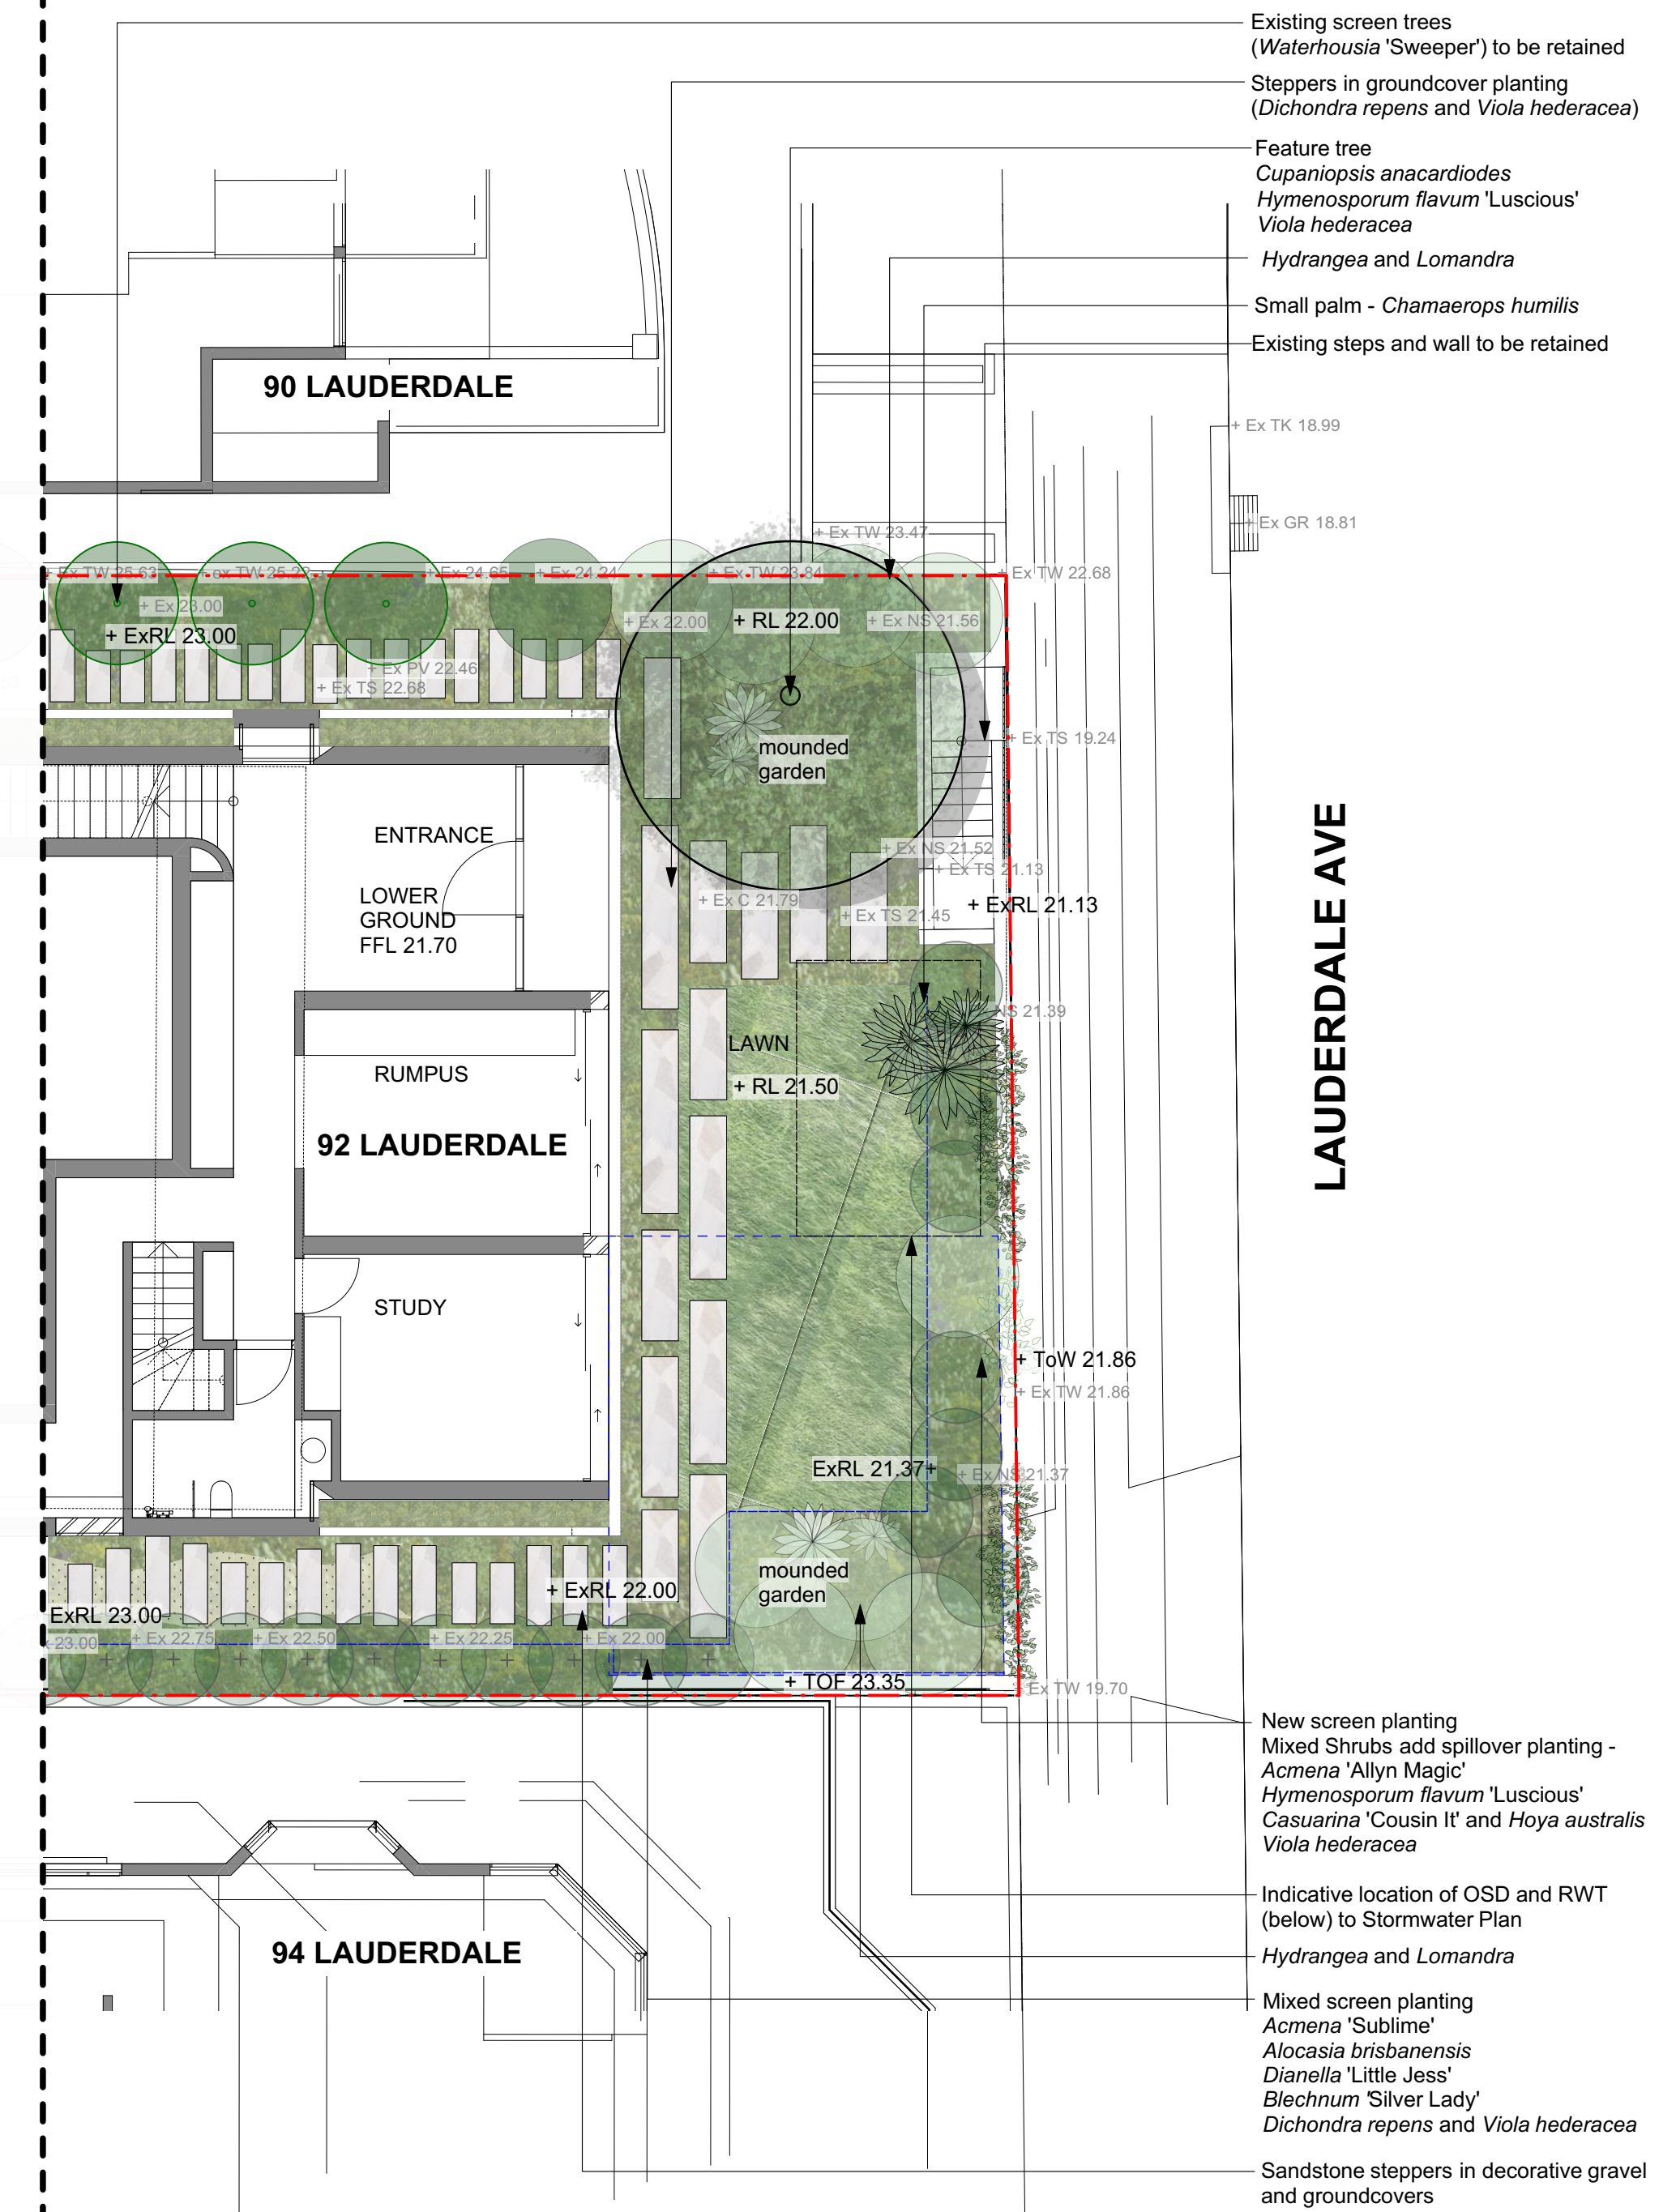

**THIS PLAN IS TO BE READ IN
CONJUNCTION WITH
THE CONDITIONS OF DEVELOPMENT
CONSENT**

DA2022/1528

Rev	Amendment	Date	By
A	Draft DA	17.08.22	CB
B	Draft DA	30.08.22	CB
C	Draft DA	30.08.22	CB
D	DA	01.09.22	CB

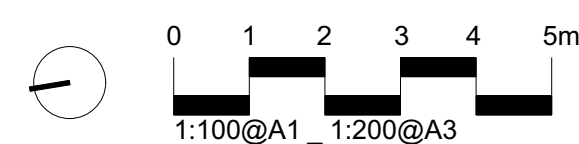

IMPORTANT NOTES:
Do not scale from drawings.
All discrepancies to be brought to the attention of the Project Landscape Architect.
Dimensions shown on drawings are not necessarily intended to reflect field preferences. All dimensions in inches unless otherwise stated.
All line dimensions and A:R:G is a metric.
All dimensions are in inches unless otherwise noted.
Verify all dimensions on site before the commencement of any work.
Contractors shall locate and mark all dimensions on site.
All work shall be carried out in accordance with A:R:G, BCA and Local Government Regulations.
Structural Details shall be subject to Engineer's Specifications.
Design & Material Preferences Details shall be subject to Hydraulic Engineer's Specifications.
All work shall be carried out in a professional manner by Qualified Tradesmen according to Landscape Drawings and all applicable specifications.
No responsibility will be taken for 30% Degree Landscape Architects Pty Ltd for any variations in design, construction or materials from the original design and specifications without permission from the Project Engineer or Landscape Architect.
This document is copyright to 30% Degree Landscape Architects Pty Ltd.

CLIENT Lachlan & Edwina Cobon		CHECKED CB
ARCHITECT Archer Office		DRAWN BHC
SCALE 1:100	SIZE A1	STAGE DA

DWG. TITLE
Landscape Plan - Lower Ground

PROJECT
92 Lauderdale Avenue, Fairlight

360 
Level 1, 1 Mary's Place
Surry Hills, 2010

P 02 9332 3601
W 360.net.au
ABN 90 146 901 322

L-D A-04



360 

Level 1, 1 Mary's Place
Surry Hills, 2010

P 02 9332 3601
W 360.net.au
ABN 90 146 901 322

360 
Level 1, 1 Mary's Place
Surry Hills, 2010
P 02 9332 3601
W 360.net.au
ABN 90 146 901 322

