


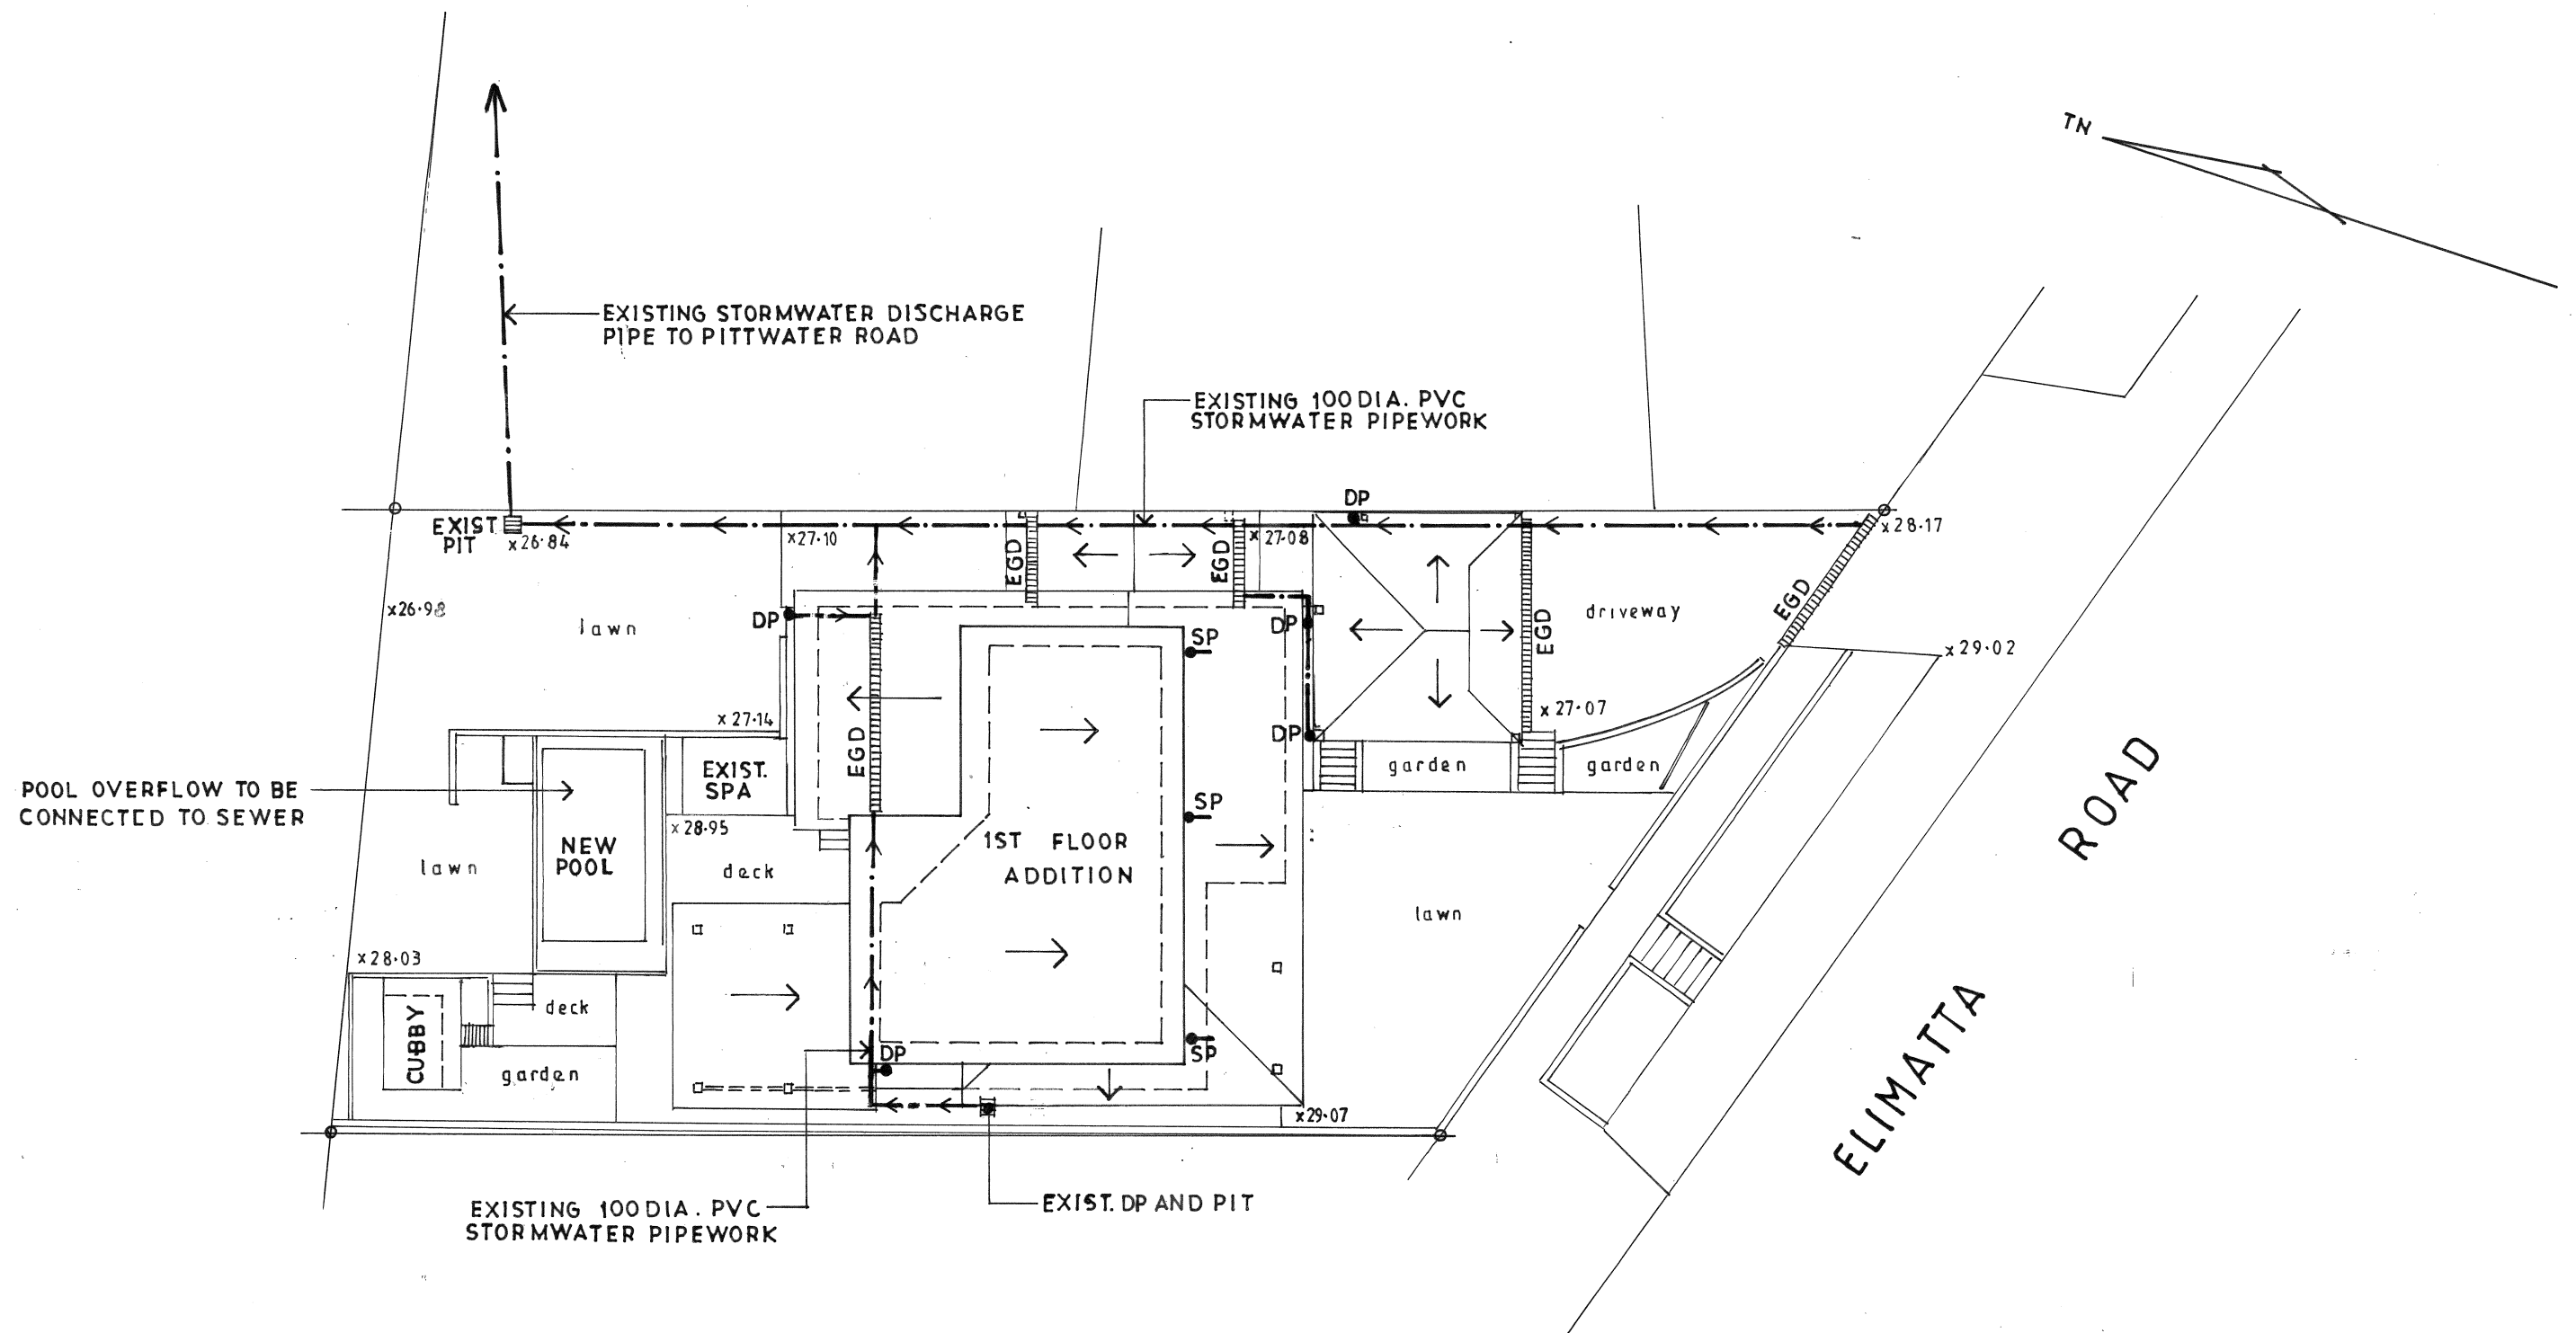

STORMWATER DRAINAGE PLAN

Stormwater Notes

- DP denotes existing downpipe
- SP denotes new downpipe and spreader to roof below
- EGD denotes existing grated drain at ground level
- All downpipes to be 90mm
- Down pipe locations to be confirmed on site
- All work to be in accordance with local council standards and specifications.
- All levels shown are to AHD.
- All works to be in accordance with AS 3500 -1990 National Plumbing and Drainage Code Part 3 - Stormwater Drainage.

These plans are for formal planning assessment (DA or CDC) only not for construction



John Wright

NETWORK DESIGN

a.b.n.52 057 985 118

37 McKillop Road Beacon Hill 2100

M. 0417 459 596

alwayswright@optusnet.com.au

ALTERATIONS, ADDITIONS AND NEW SWIMMING POOL

3 ELIMATTA ROAD
MONA VALE LOT B D372473

CLIENT

JANELLE OSBORNE

STORMWATER DRAINAGE PLAN

DATE
SEPTEMBER 2021

DRAWN
J.WRIGHT

DRG. NO.
09-21-EL

SCALE
1:200

ISSUE:
DA

SHEET NO.
11