


LEGEND:

- TO MATCH EXISTING DOWNLIGHTS LIGHTING LAYOUT TO CONTINUE ON FROM EXISTING
- L3 FESTOON LIGHTS
- AP1 ACOUSTIC PANELING REFER TO FINISHES SCHEDULE FOR DETAILS
- EXISTING EMERGENCY LIGHT
- EXISTING SLIM LINE EXIT SIGN
- NEW SPEAKER FLUSH - WHITE PAINTED TO MATCH CEILING. CONSULTANT TO CONFIRM LOCATIONS
- CF - CEILING FAN IN OAK SUPPLIER TO ACCESS AND ADVISE ON QUANTITIES AND SETOUT LOCATION TO AVOID STROBE EFFECT OF LIGHTING

NOTE: SPRINKLERS LAYOUT TO BE CONFIRMED BY FIRE CONSULTANT.
ACCESS PANELS TO BE PAINTED IN PT3 CONFIRM LOCATIONS ONSITE.
AIR CONDITIONING REGISTERS TO BE CLEANED AND RE PAINTED IN PT3 CONFIRM LOCATIONS ONSITE.

WENTWORTH STREET

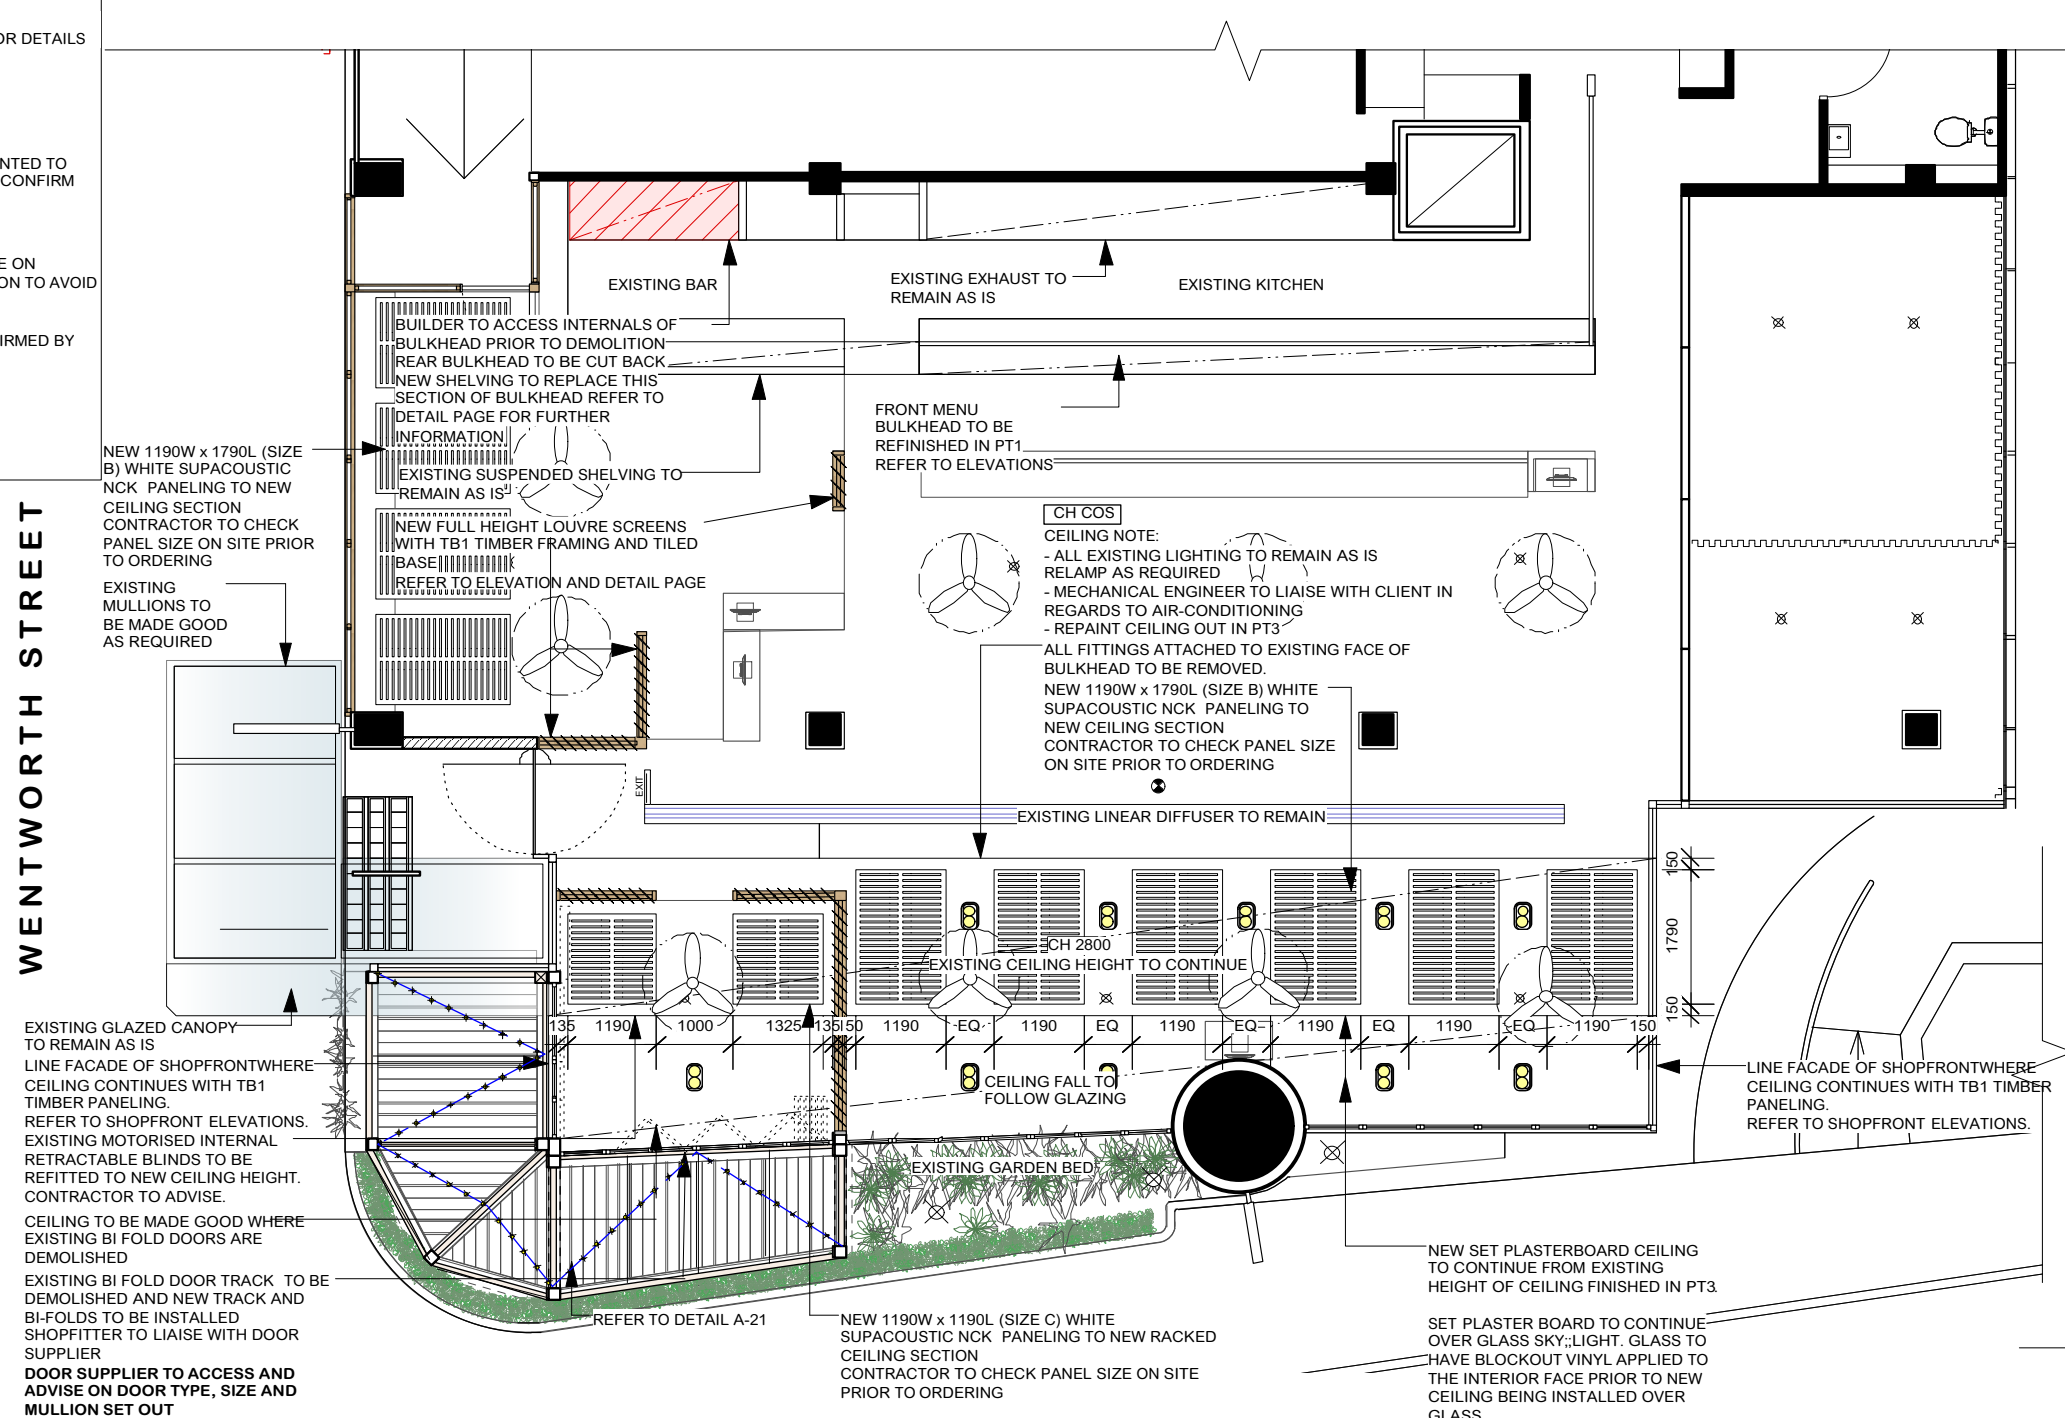

EXISTING GLAZED CANOPY TO REMAIN AS IS
LINE FACADE OF SHOPFRONTWHERE CEILING CONTINUES WITH TB1 TIMBER PANELING. REFER TO SHOPFRONT ELEVATIONS.
EXISTING MOTORISED INTERNAL RETRACTABLE BLINDS TO BE REFITTED TO NEW CEILING HEIGHT. CONTRACTOR TO ADVISE.
CEILING TO BE MADE GOOD WHERE EXISTING BI FOLD DOORS ARE DEMOLISHED
EXISTING BI FOLD DOOR TRACK TO BE DEMOLISHED AND NEW TRACK AND BI-FOLDS TO BE INSTALLED SHOPFITTER TO LIAISE WITH DOOR SUPPLIER
DOOR SUPPLIER TO ACCESS AND ADVISE ON DOOR TYPE, SIZE AND MULLION SET OUT

CH COS
CEILING NOTE:
- ALL EXISTING LIGHTING TO REMAIN AS IS RELAMP AS REQUIRED
- MECHANICAL ENGINEER TO LIAISE WITH CLIENT IN REGARDS TO AIR-CONDITIONING
- REPAINT CEILING OUT IN PT3
ALL FITTINGS ATTACHED TO EXISTING FACE OF BULKHEAD TO BE REMOVED.
NEW 1190W x 1790L (SIZE B) WHITE SUPACOUSTIC NCK PANELING TO NEW CEILING SECTION CONTRACTOR TO CHECK PANEL SIZE ON SITE PRIOR TO ORDERING

NOTE:
REFLECTED CEILING PLAN INDICATIVELY ONLY
SHOPFITTER TO CONFIRM ALL SERVICES ON SITE
PRIOR TO CONSTRUCTION & REUSE/RELOCATE EXISTING SERVICES WHERE POSSIBLE

01 reflected ceiling plan
Scale: 1:100

EAST ESPLANADE

STATUS
CONSTRUCTION

NOTES
DO NOT SCALE THIS DRAWING.
ALL DIMENSIONS TO BE VERIFIED ON SITE PRIOR TO CONSTRUCTION.
ANY INCONSISTENCIES TO BE REPORTED TO MORRIS SELVATICO IMMEDIATELY. IF ANY DOUBT PLEASE ASK MORRIS SELVATICO FOR CLARIFICATION. ANY VARIATIONS TO THESE DRAWINGS REQUIRES APPROVAL FROM MORRIS SELVATICO. THIS DRAWING HAS BEEN PRODUCED TO ILLUSTRATE DESIGN INTENT. ALL SHOP DRAWINGS ARE TO BE SUBMITTED TO AND SANCTIONED BY MORRIS SELVATICO PRIOR TO MANUFACTURE OR CONSTRUCTION. CONTRACTOR TO LIAISE WITH THIRD PARTY SUPPLIERS TO CONFIRM EXACT REQUIREMENTS

CLIENT DETAILS
GARFISH RESTAURANT & BAR

PROJECT
SHOP 1, 39 EAST ESPLANADE
MANLY

JOB NO
GAR01

ISSUE DETAILS

A	24.03.16	PRELIMINARY ISSUE
B	19.04.16	PRELIMINARY ISSUE
C	27.06.16	REVISED TENDER ISSUED
D	08.09.16	CONSTRUCTION ISSUE

DRAWING DETAILS
REFLECTED CEILING PLAN

DRAWN BY AM/LS/AB	SCALE 1:100 @ A3	START DATE 17.06.15
CHECKED BY AM	DATE 08.09.16	DRAWING NO A-03

WHERE PARTITIONS/WINDOWS/DOORS HAVE BEEN DEMOLISHED SHOPFITTER TO REPATCHED, MAKE GOOD AND REPAINT CEILINGS PT3