


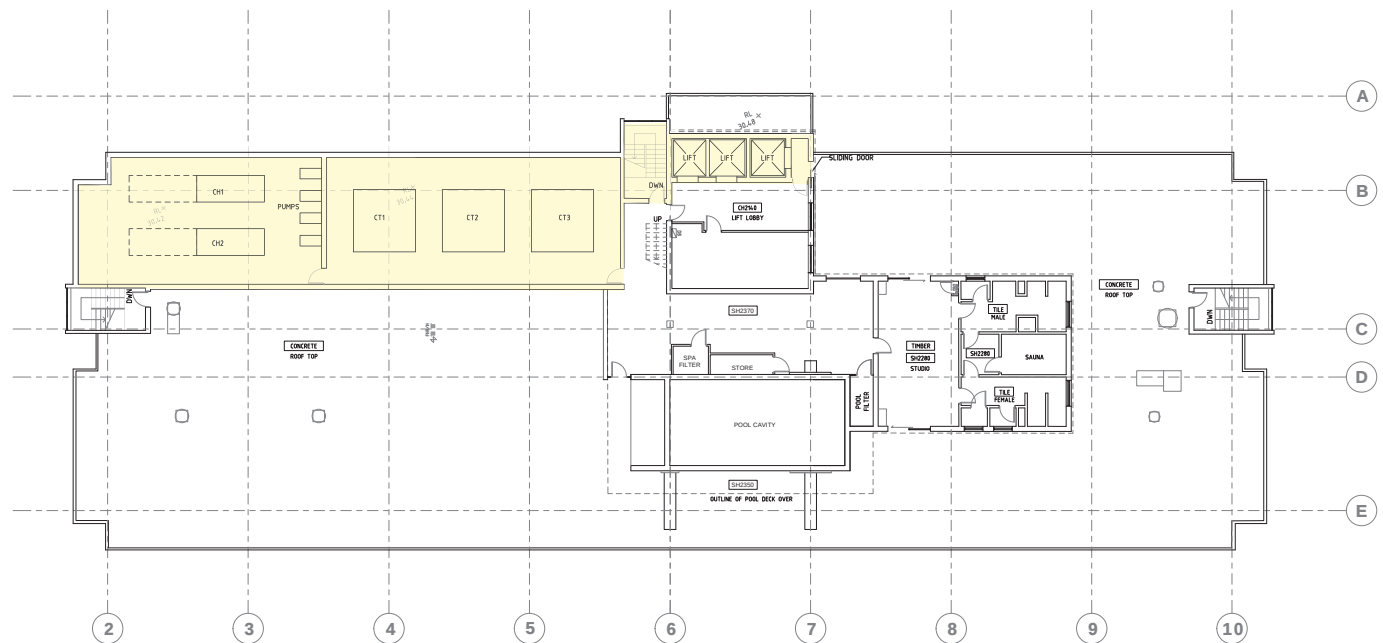

LEVEL 8 PLANT AND LIFT LAYOUT



CLIENT:
RATEWAVE PTY LTD


DATE	REV	COMMENTS
-	-	-
-	-	-
-	-	-
-	-	-
-	-	-
-	-	-

**LIFT EXTENSION AND
NEW MECHANICAL PLANT ROOM
56-58 NORTH STEYNE MANLY, NSW**




JOB No.: 19295	Date: 15-11-2019
Description:	Revision: 01
Drawn By: VA/LS	Checked by: VA
Scale: 1:150 @ A1 1:300 @ A3	Sheet No.: 1 of 6

LEVEL 8 PLAN

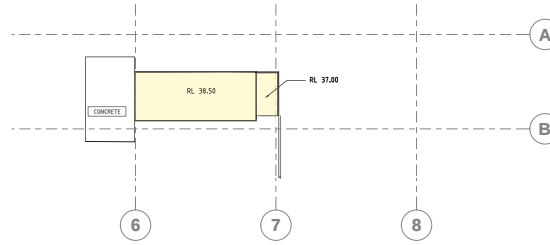

LIFT OVERRUN

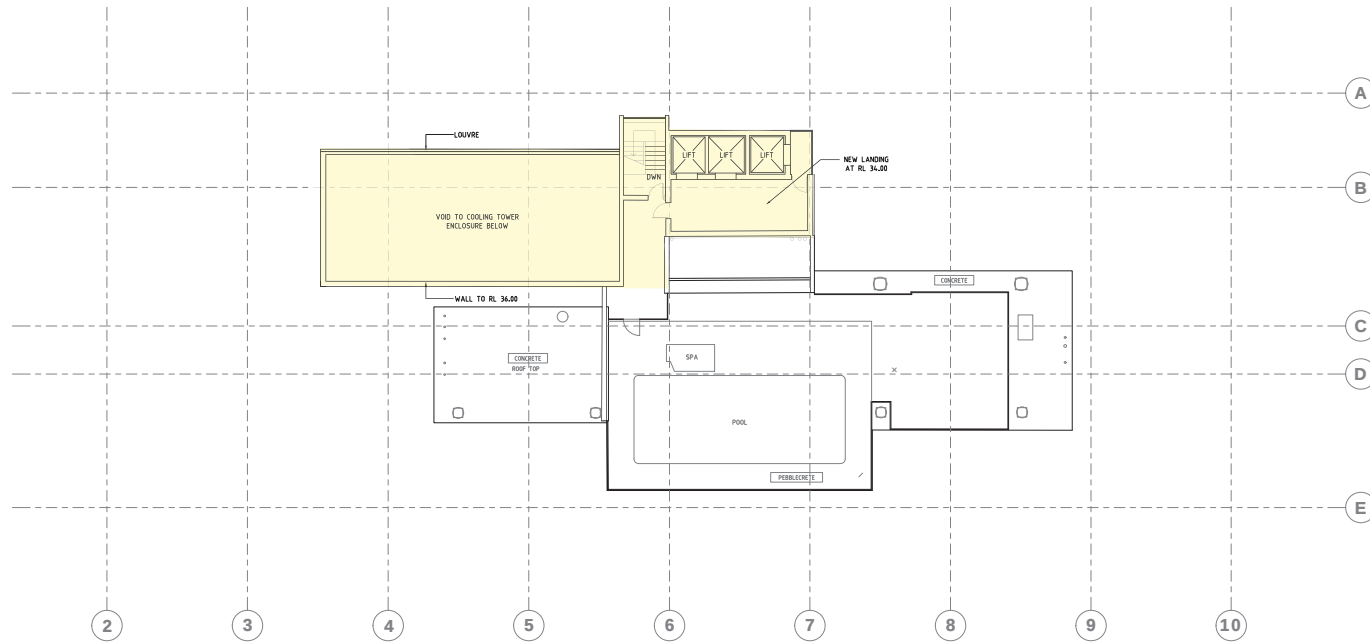

POOL DECK FLOOR PLAN



CLIENT:
RATEWAVE PTY LTD

DATE	REV	COMMENTS
-	-	-
-	-	-
-	-	-
-	-	-
-	-	-
-	-	-
-	-	-

**LIFT EXTENSION AND
NEW MECHANICAL PLANT ROOM
56-58 NORTH STEYNE MANLY, NSW**



JOB No.: 19295	Date: 15-11-2019
Description:	Revision: 01
Drawn By: VA/LS	Checked by: VA
Scale: 1:150 @ A1 1:300 @ A3	Sheet No.: 1 of 6

LEVEL 9 PLAN