

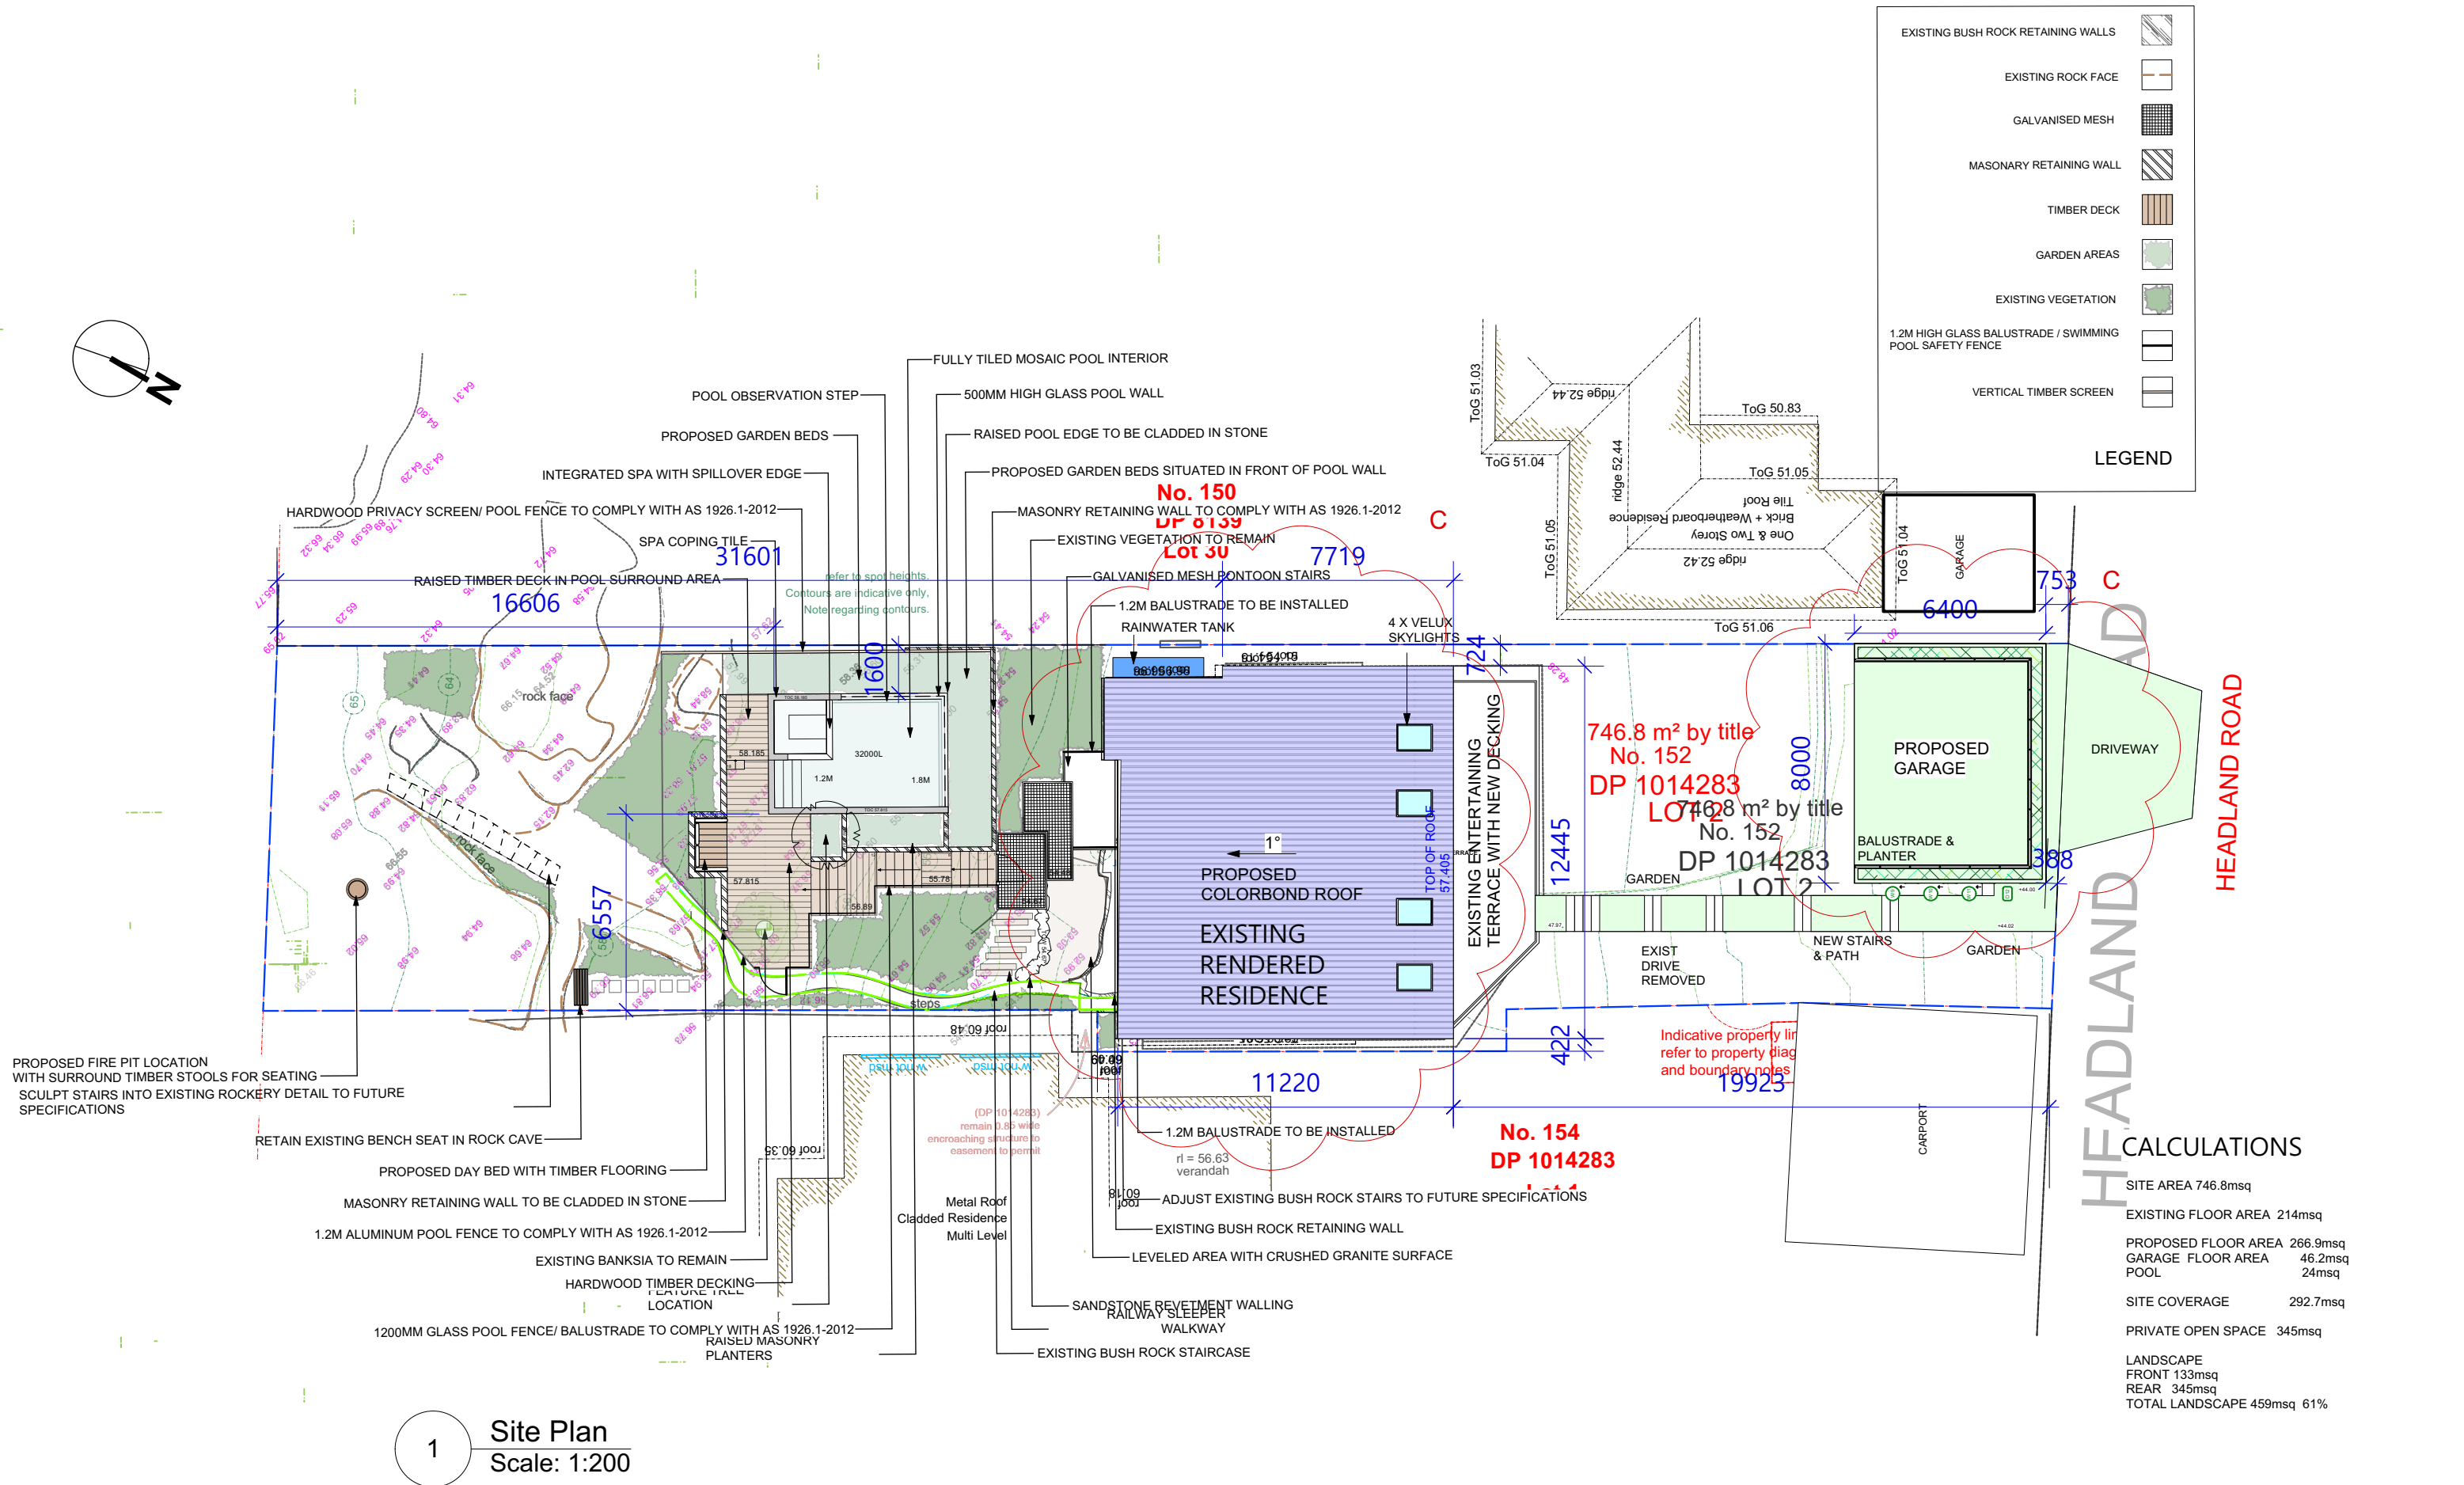


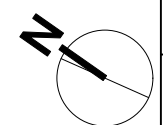

1 Site Plan
Scale: 1:200

CALCULATIONS	
SITE AREA	746.8msq
EXISTING FLOOR AREA	214msq
PROPOSED FLOOR AREA	266.9msq
GARAGE FLOOR AREA	46.2msq
POOL	24msq
SITE COVERAGE	292.7msq
PRIVATE OPEN SPACE	345msq
LANDSCAPE	
FRONT	133msq
REAR	345msq
TOTAL LANDSCAPE	459msq 61%

 Inlet Design Studio Newport, NSW, 2106, P 0415647351 E robyn@inletdesign.com.au ABN: 26 075 061 335 Copyright © JACARANDA TRADING COMPANY PTY LTD	REVISION: A	DATE: 6/07/21	REVISION NOTE: SETBACK DIMENSIONS ADDED		CLIENT: Luke Rowlands	DRAWING: Site Plan	DRAWN: RJ	SHEET NO.: A01
	C	30/05/22	PROPOSED TERRACE ROOF LOWERED PLANTER BOX LOWERED & BALUSTRADE ADDED		ADDRESS: 152 Headland Road, NORTH CURL CURL	PROJECT: ALTERATIONS AND ADDITIONS	CHKD: RJ	SCALE @ A3: 1:200
			PROJECT NO: HEA001		ISSUE TYPE: 2	ISSUE DATE: 16/06/21	REVISION: C	

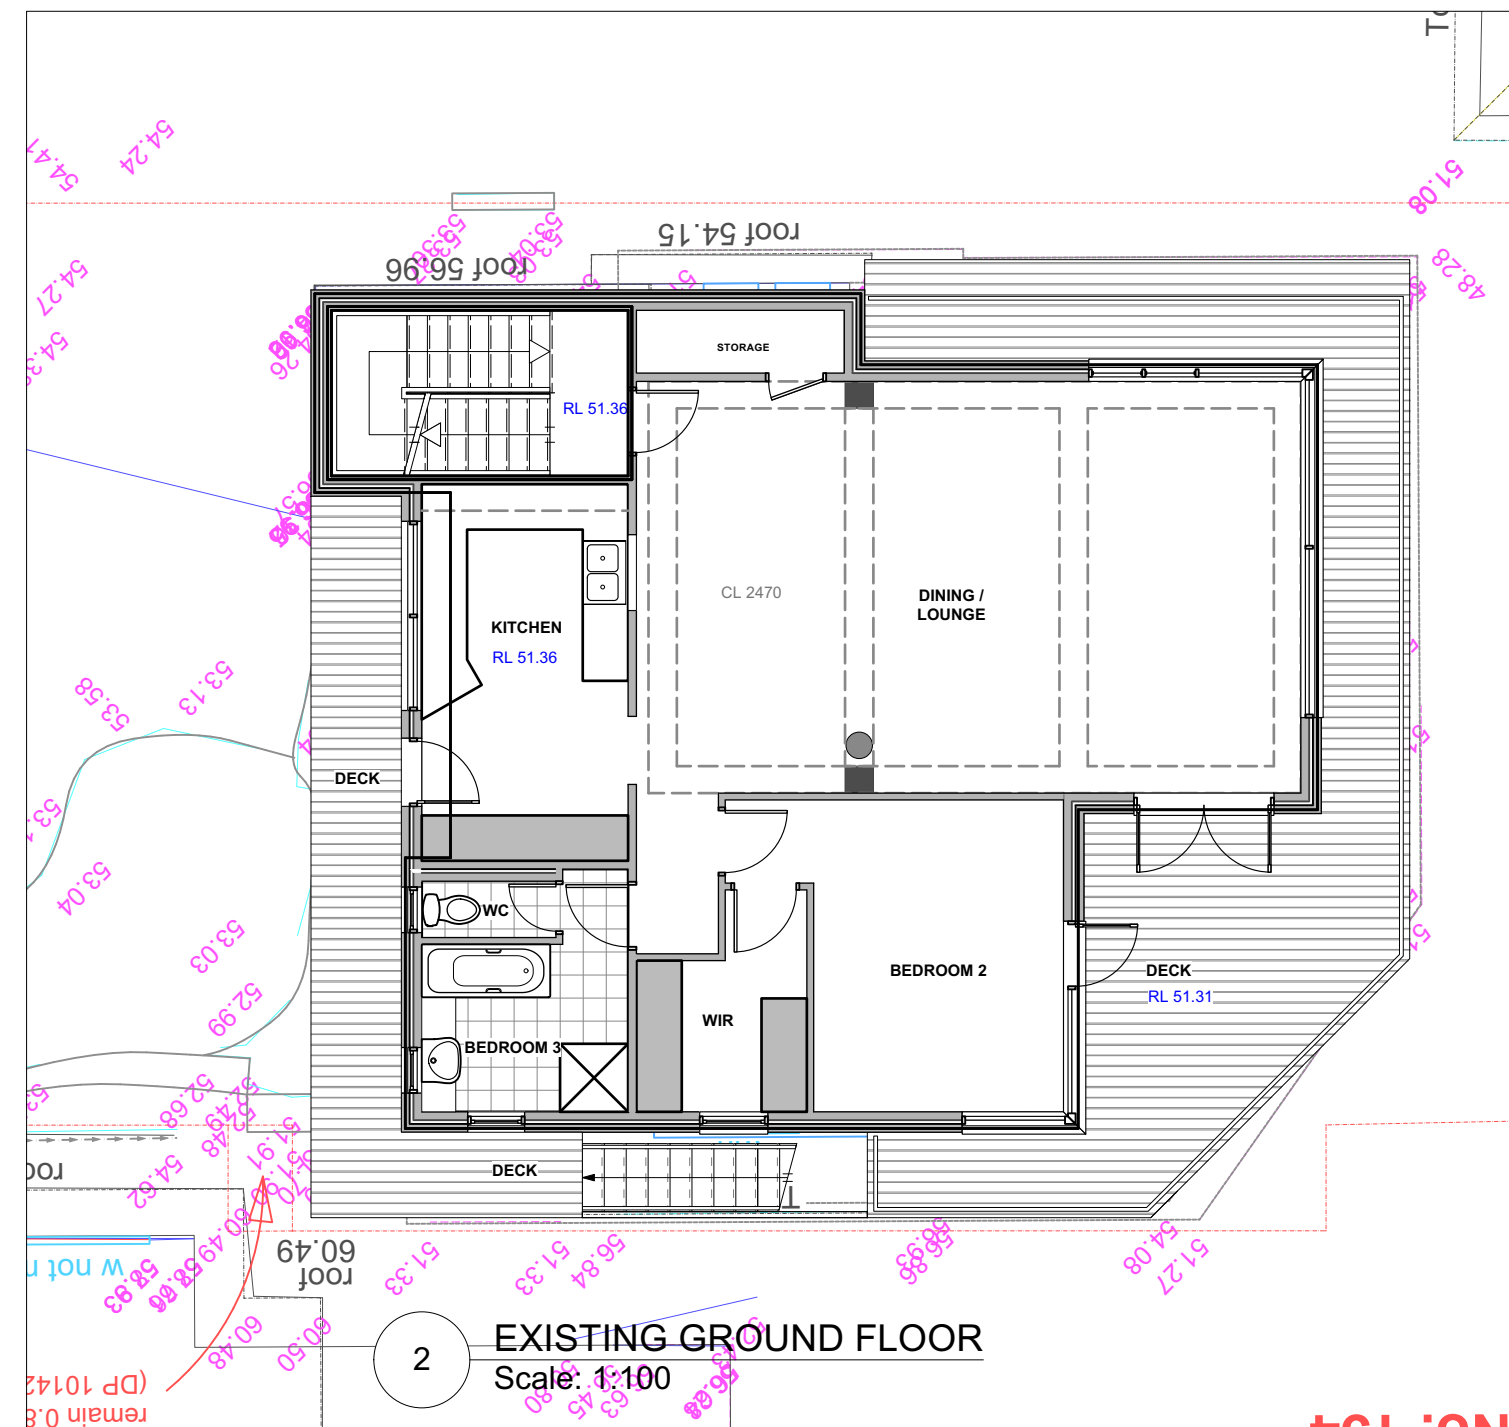

 


Inlet Design Studio

Newport, NSW, 2106,
P 0415647351
E robyn@inletdesign.com.au

ABN: 26 075 061 335
Copyright © JACARANDA TRADING COMPANY PTY LTD


REVISION: DATE: REVISION NOTE:



CLIENT:
Luke Rowlands

ADDRESS:
152 Headland Road, NORTH CURL CURL

DRAWING: Existing First Floor Plan	DRAWN: RJ	SHEET NO: A03
PROJECT: ALTERATIONS AND ADDITIONS	CHKD: RJ	SCALE @ A3: 1:100
PROJECT NO: HEA001	ISSUE TYPE: 1	REVISION: 16/06/21



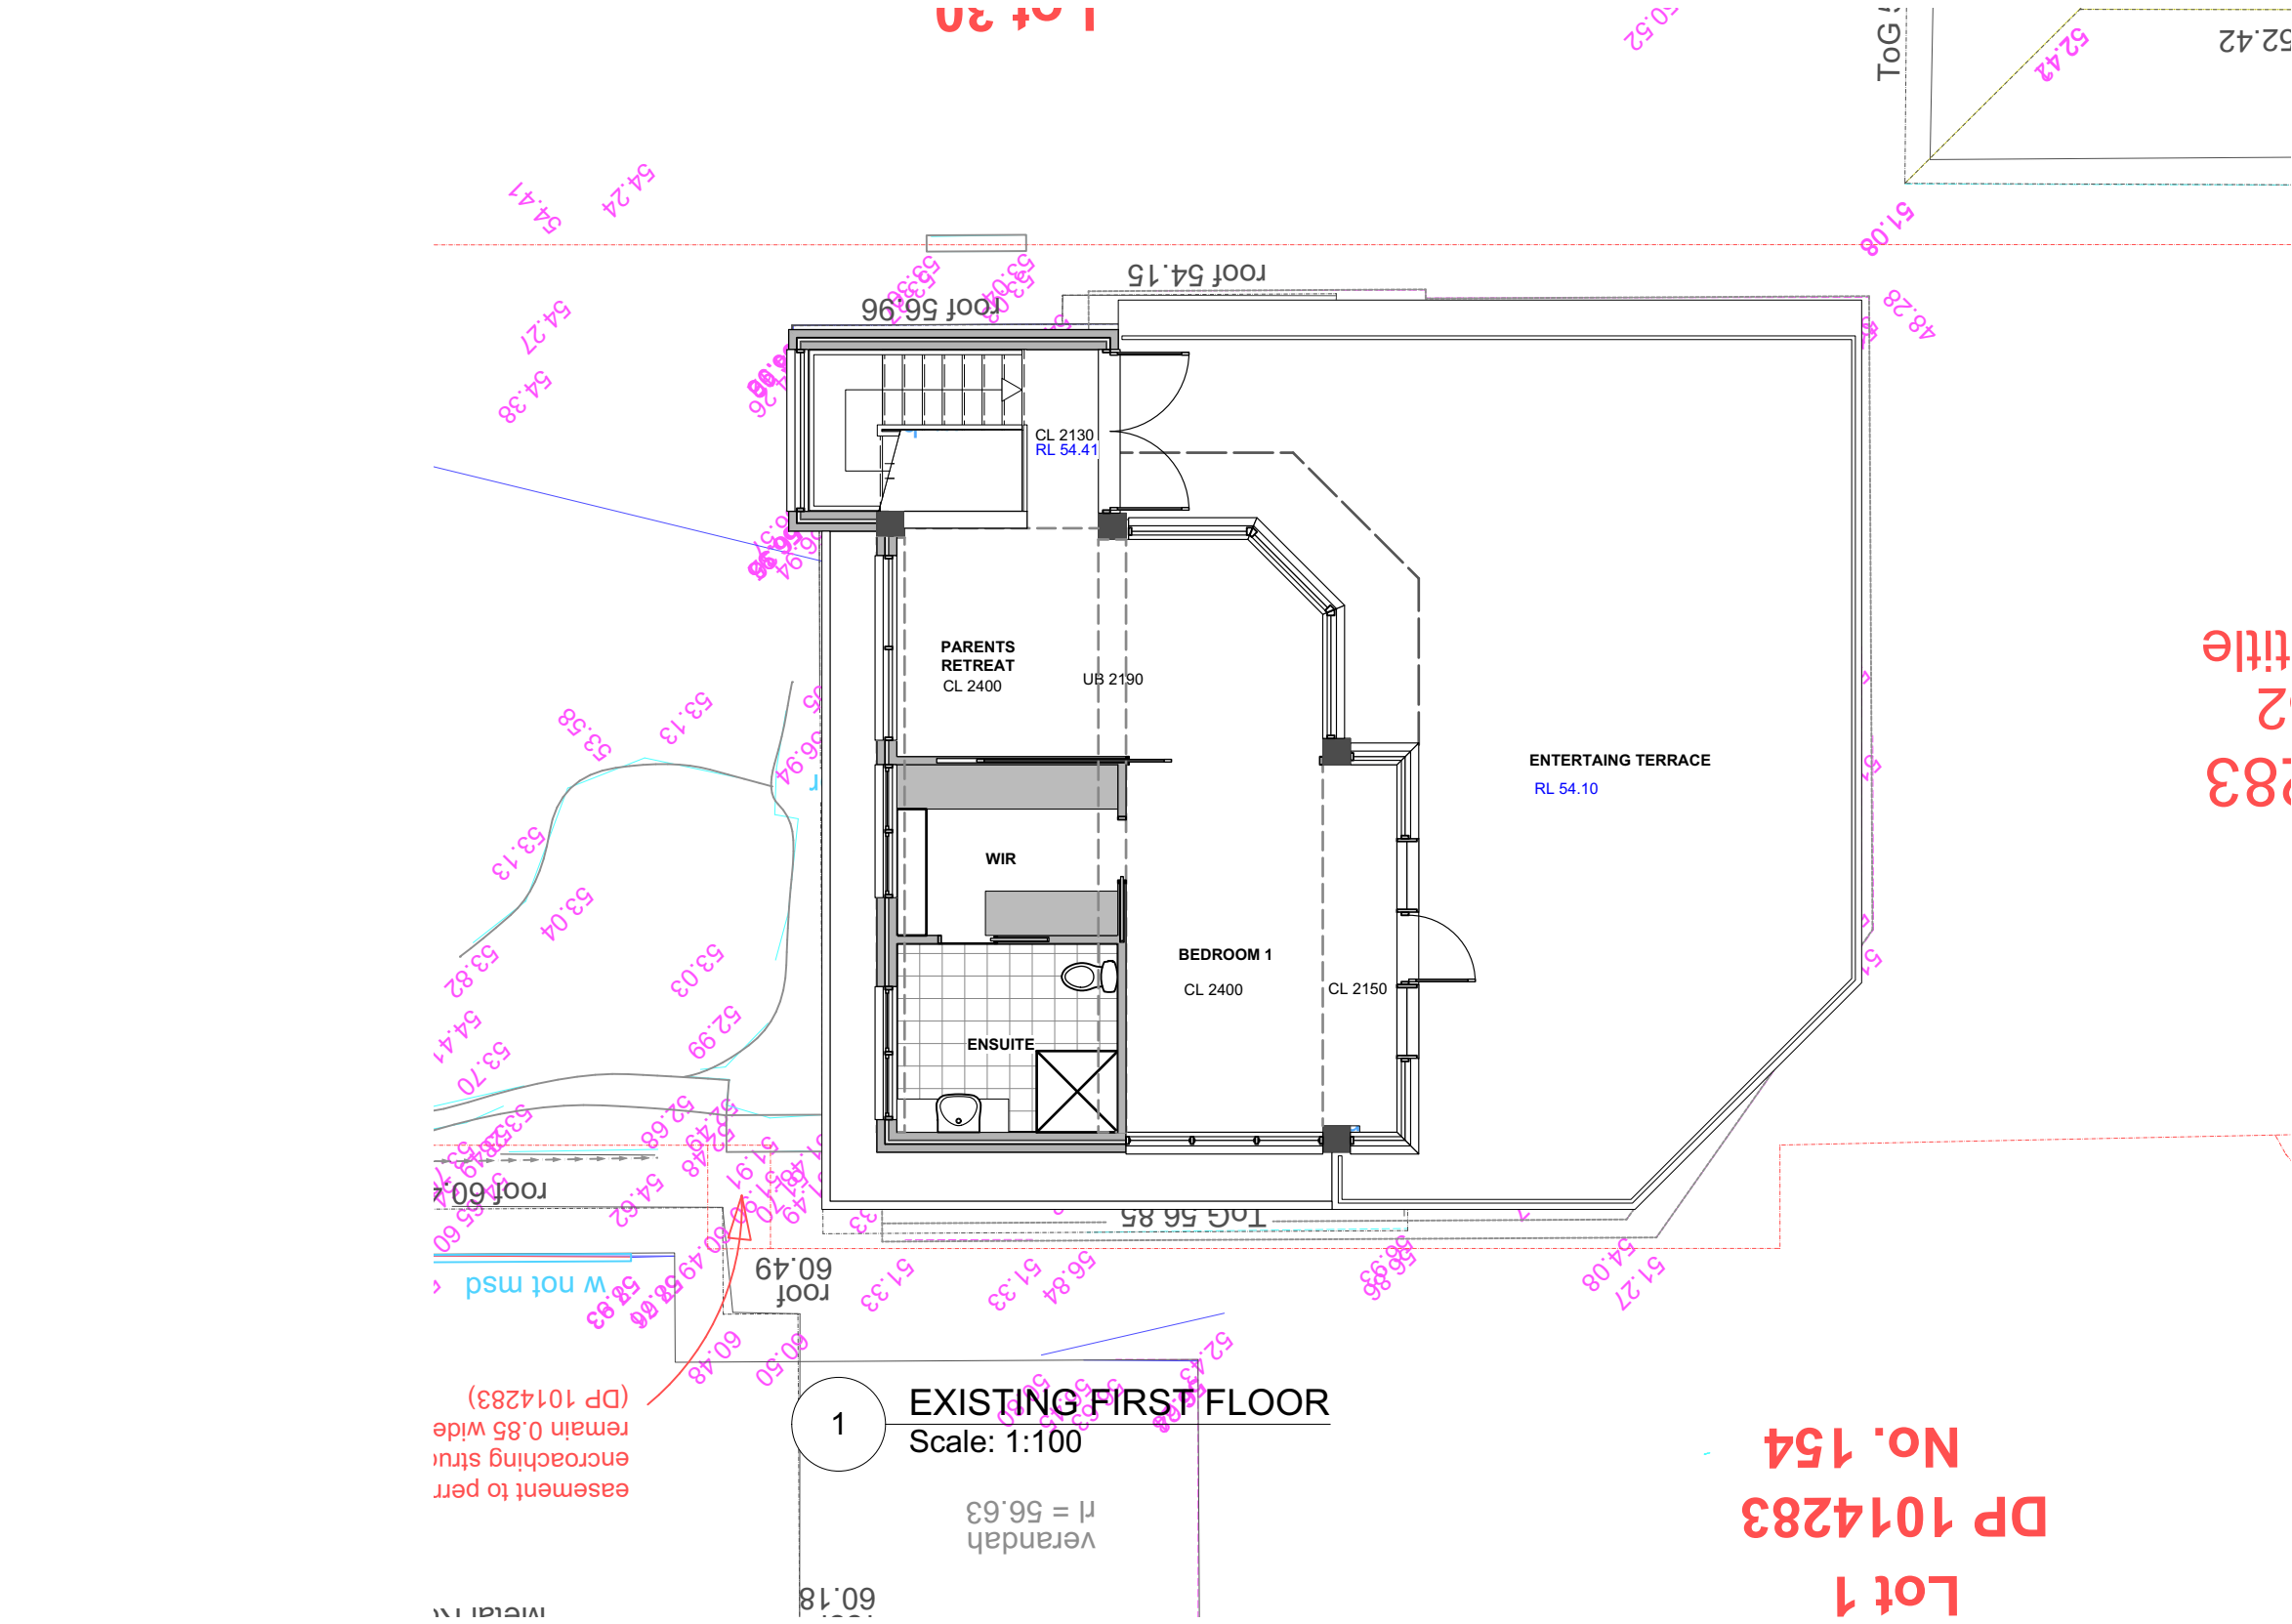


1 EXISTING FIRST FLOOR
Scale: 1:100

verandah
rl = 56.63

Lot 1
DP 1014283
No. 154

title
283

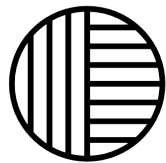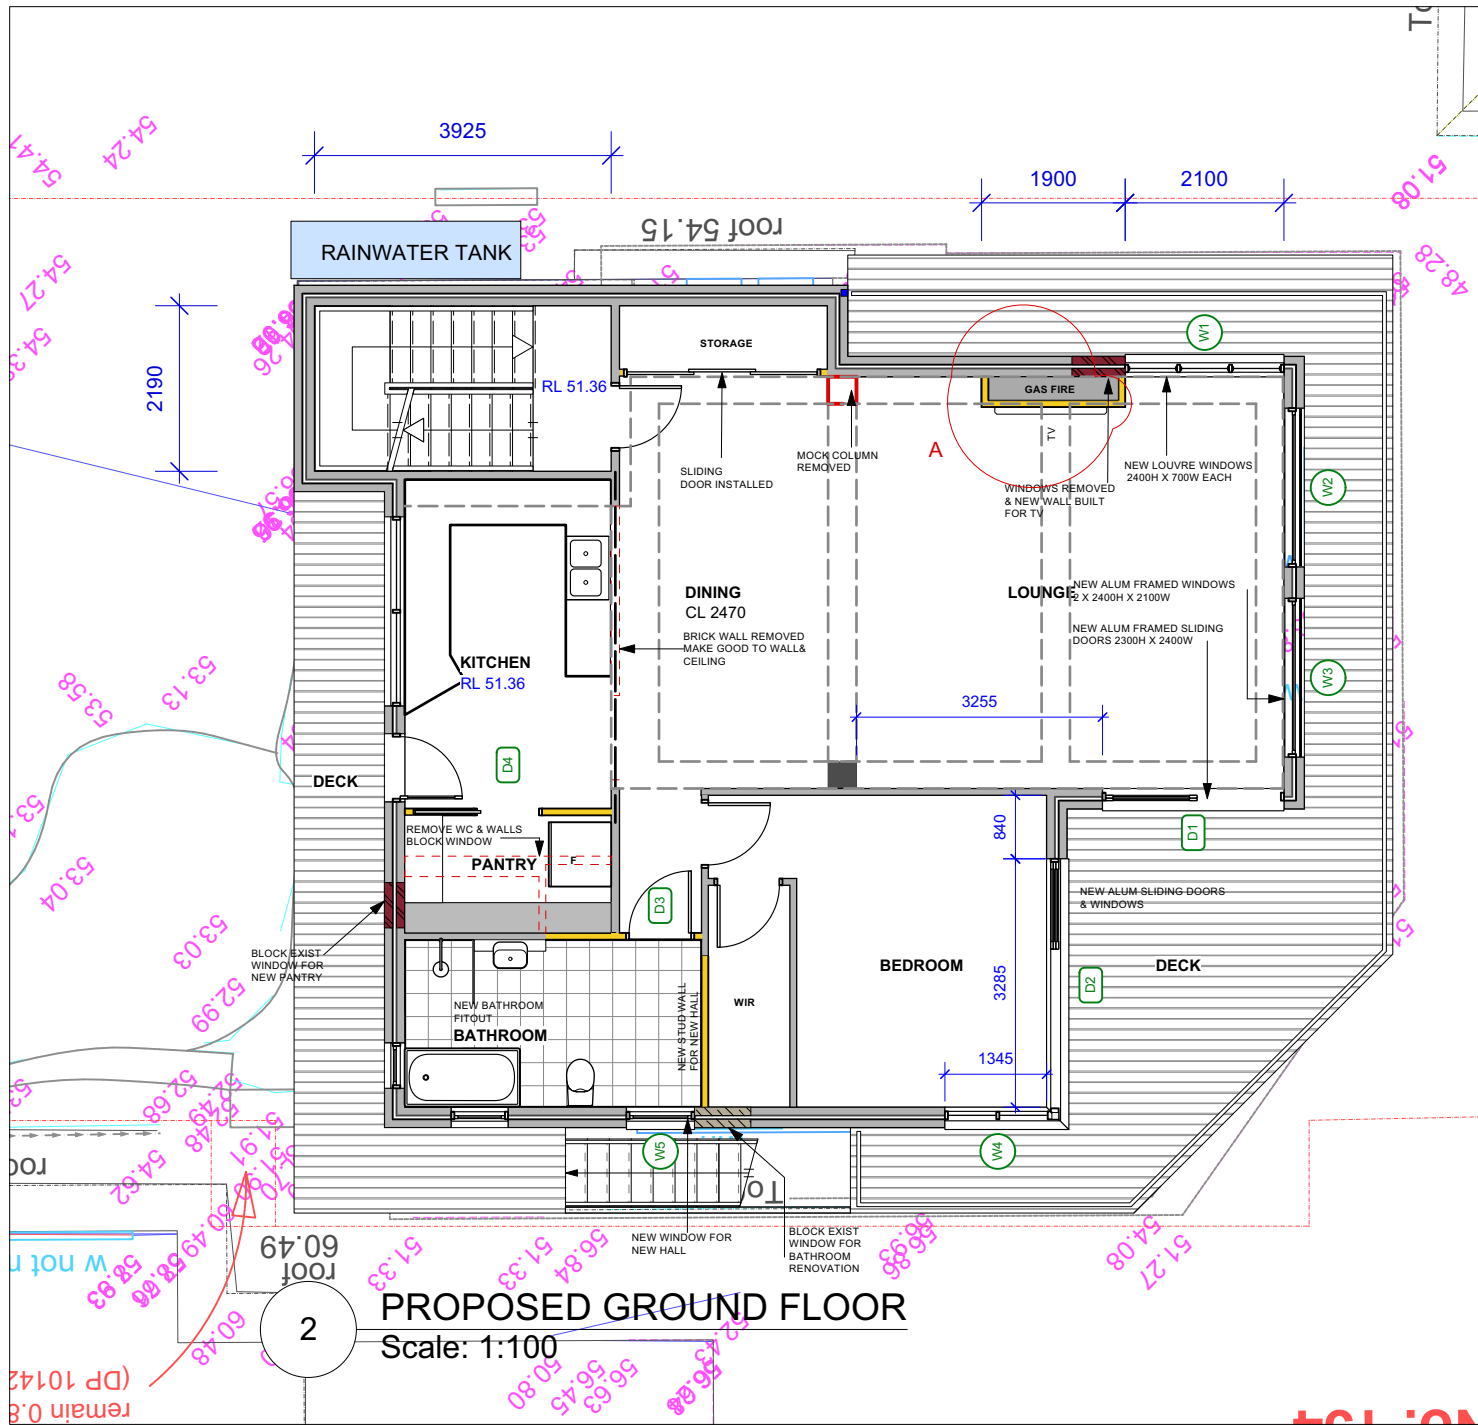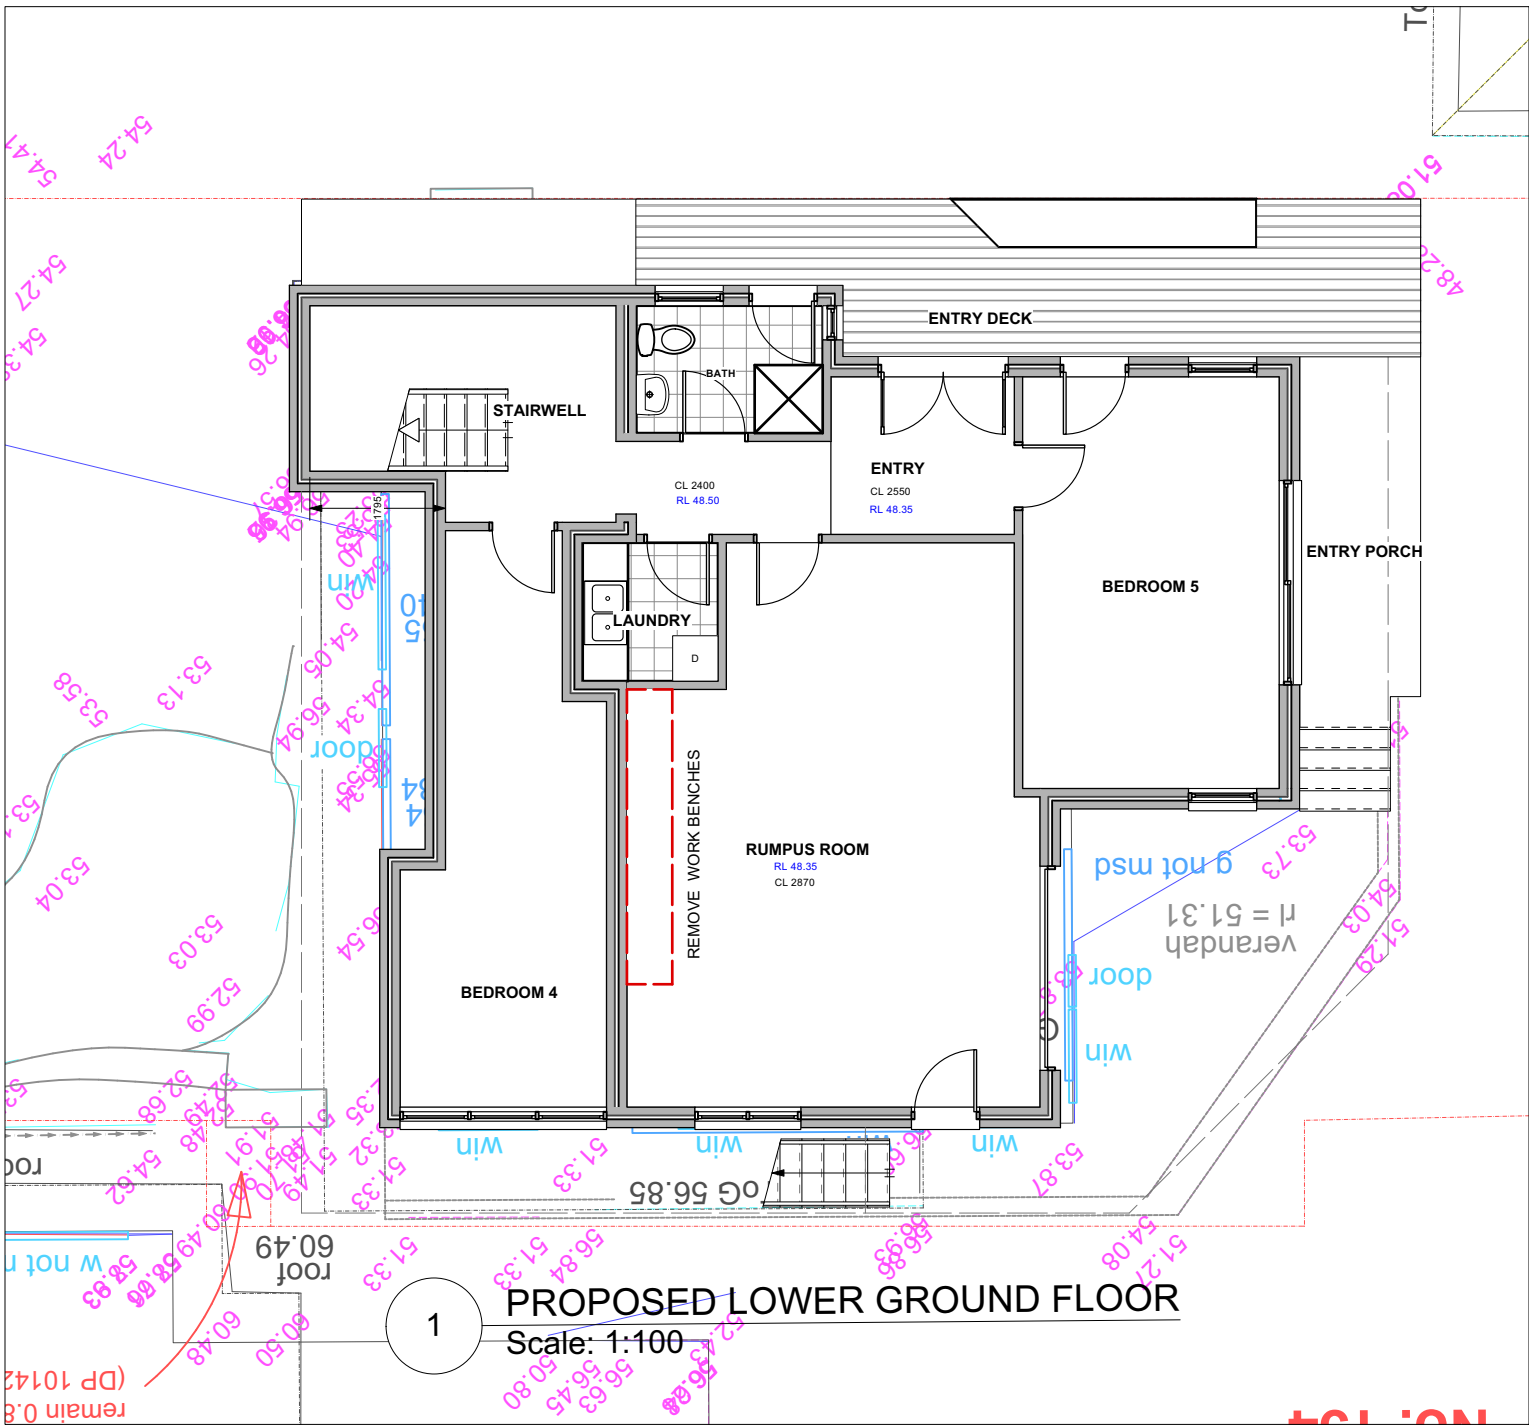


Inlet Design Studio

Newport, NSW, 2106,
P 0415647351
E robyn@inletdesign.com.au

ABN: 26 075 061 335
Copyright © JACARANDA TRADING COMPANY PTY LTD

 REVISION: A
DATE: 6/07/21
REVISION NOTE: GAS FIRE NOTE ADDED



CLIENT:
Luke Rowlands

ADDRESS:
152 Headland Road, NORTH CURL CURL

DRAWING:
Proposed Lower and Ground Floor Plans

PROJECT:
ALTERATIONS AND ADDITIONS

PROJECT NO:
HEA001

ISSUE TYPE:
1

DRAWN:
RJ

CHKD:
RJ

ISSUE DATE:
16/06/21

SHEET NO:
A04

SCALE @ A3:
1:100

REVISION:
A

COLORBOND ROOF OVER
EXISTING
ROOF SLAB TO ENG DETAIL

TIMBER STUD WALLS TO
SUPPORT SKILLION ROOF
WITH SELECTED CLADDING

RIDGE 57.405

SELECTED BALUSTRADE

TIMBER DECK OVER
EXISTING SLAB

NEW LOUVRE WINDOWS
AS SPECIFIED

8417

EXISTING EXCAVATION
FOR EXISTING HOUSE

RAINWATER TANK

8.5m Building height

COLORBOND ROOF CONSTRUCTED
WITH 1 DEG PITCH
TO ENGINEERS SPECIFICATIONS

8.5m Building height

TOP OF ROOF
RL 57.405

CL 56.81

BALUSTRADE

GALV MESH PLATFORMS

FFL 54.41

CL 53.83

GFL 51.36

LGFL 48.50

NEW GLASS DOOR

1

East Elevation
Scale: 1:100

2

North Elevation
Scale: 1:100



Inlet Design Studio

Newport, NSW, 2106,
P 0415647351
E robyn@inletdesign.com.au

ABN: 26 075 061 335
Copyright © JACARANDA TRADING COMPANY PTY LTD

REVISION:	DATE:	REVISION NOTE:
A	6/07/21	BUILDING HEIGHT LINE ADDED
B	17/03/22	BUILDING HEIGHT LINE AMENDED TO SHOW EXISTING EXCAVATED GROUND LINE & ASSUMED NATURAL GROUND LINE TOP OF ROOF RL 57.82 TO WESTERN SIDE OF SKILLION ROOF
C	30/05/22	PROPOSED TERRACE ROOF LOWERED PLANTER BOX REMOVED FROM GARAGE



CLIENT:
Luke Rowlands

ADDRESS:
152 Headland Road, NORTH CURL CURL

DRAWING:
NORTH AND EAST ELEVATIONS

PROJECT:
ALTERATIONS AND ADDITIONS

PROJECT NO:
HEA001

ISSUE TYPE:
3

DRAWN:
AJ


CHKD:
RJ

ISSUE DATE:
16/06/21

SHEET NO:
A06

SCALE @ A3:
1:100

REVISION:
C

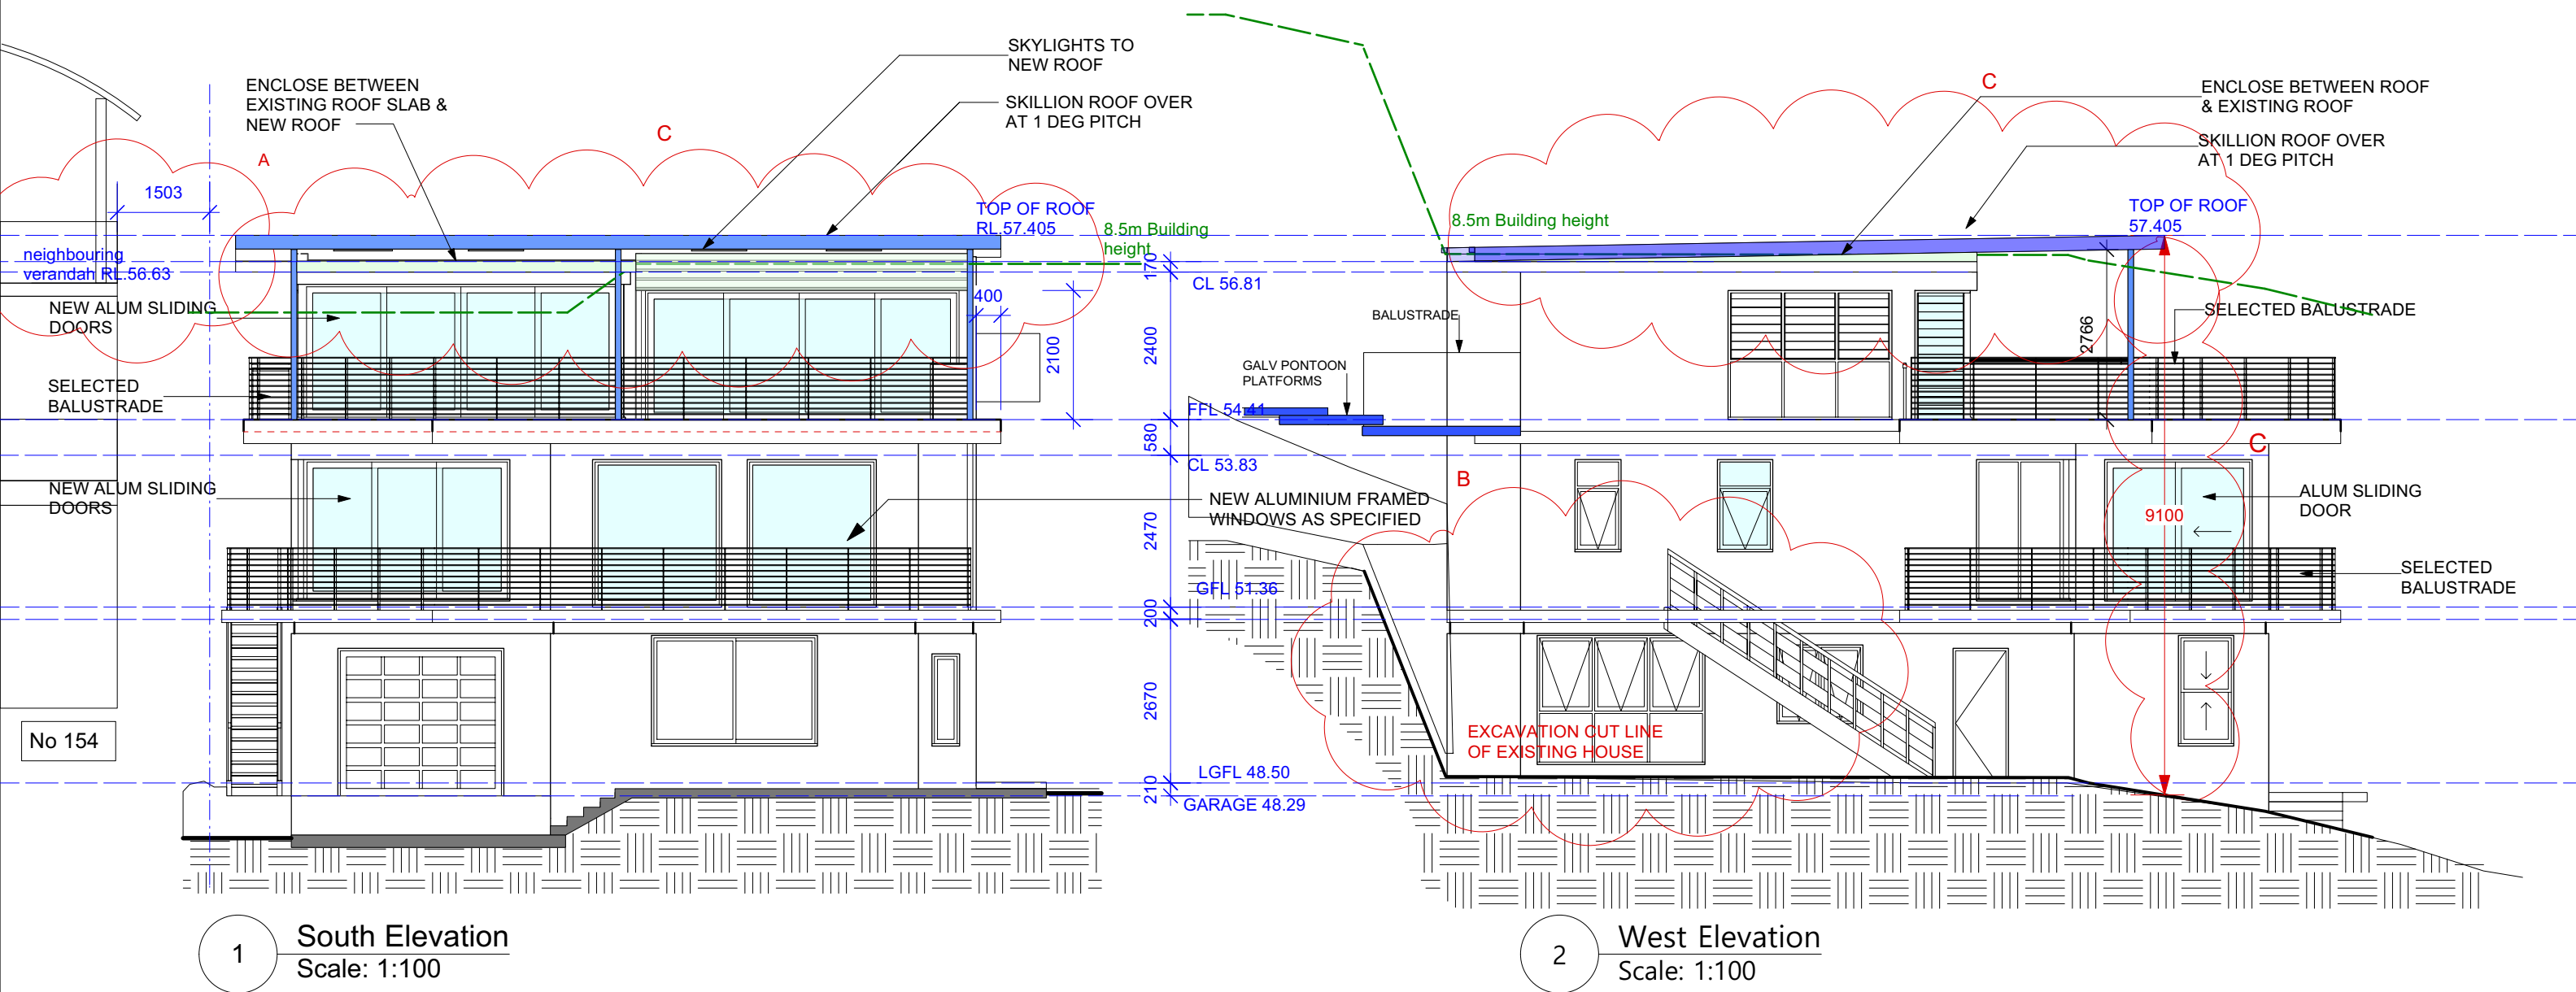

Inlet Design Studio

Newport, NSW, 2106,
P 0415647351
E robyn@inletdesign.com.au

ABN: 26 075 061 335
Copyright © JACARANDA TRADING COMPANY PTY LTD

REVISION:	DATE:	REVISION NOTE:
A	6/07/21	BUILDING HEIGHT LINE ADDED HEIGHT OF ROOF DIMENSIONED FROM GROUND LINE WEST ELEVATION WESTERN NEIGHBOURS VERANDAH PLOTTED
B	17/03/22	BUILDING HEIGHT LINE AMENDED TO SHOW EXISTING EXCAVATED GROUND LINE & ASSUMED NATURAL GROUND LINE TOP OF ROOF RL 57.82 TO WESTERN SIDE OF SKILLION ROOF
C	30/05/22	PROPOSED TERRACE ROOF LOWERED PLANTER BOX LOWERED & BALUSTRADE ADDED



CLIENT:
Luke Rowlands

ADDRESS:
152 Headland Road, NORTH CURL CURL

DRAWING:
SOUTH AND WEST ELEVATIONS

PROJECT:
ALTERATIONS AND ADDITIONS

PROJECT NO:
HEA001

ISSUE TYPE:
1

DRAWN:
AJ


SHEET NO:
A07

CHKD:
RJ

SCALE @ A3:
1:100

ISSUE DATE:
16/06/21

REVISION:
C

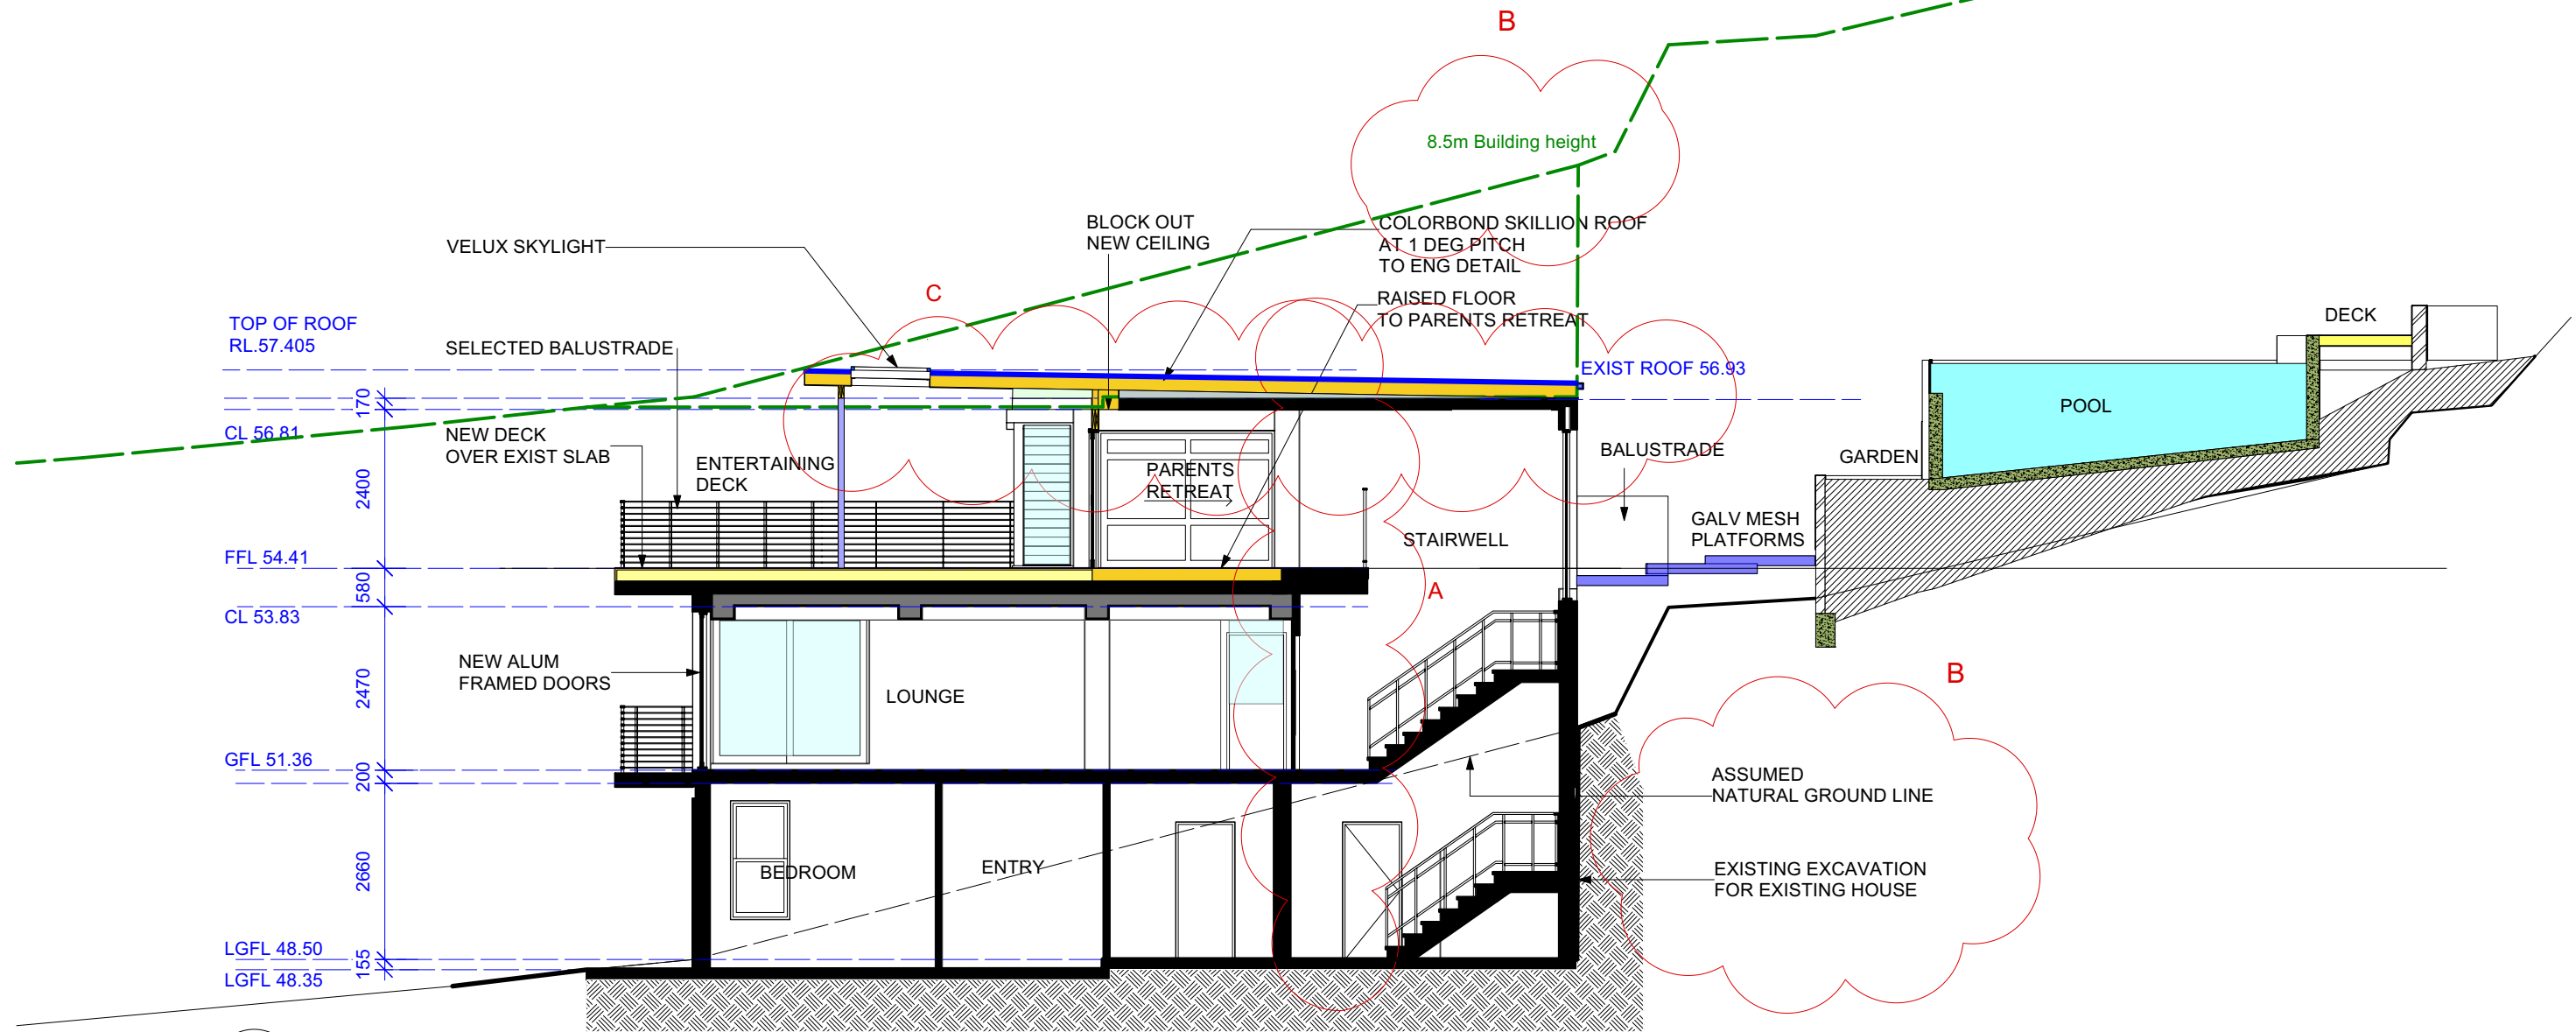

1 Section A-A
Scale: 1:100

BASIX Certificate number: A400627_07

page 2 / 8

BASIX Certificate number: A400627_07

page 3 / 8

BASIX Certificate number: A400627_07

page 4 / 8

Pool and Spa	Show on DA Plans	Show on CC/CDC Plans & specs	Certifier Check
Rainwater tank			
The applicant must install a rainwater tank of at least 5140 litres on the site. This rainwater tank must meet, and be installed in accordance with, the requirements of all applicable regulatory authorities.	✓	✓	✓
The applicant must configure the rainwater tank to collect rainwater runoff from at least 90 square metres of roof area.		✓	✓
The applicant must connect the rainwater tank to a tap located within 10 metres of the edge of the pool and outdoor spa.		✓	✓
Outdoor swimming pool			
The swimming pool must be outdoors.	✓	✓	✓
The swimming pool must not have a capacity greater than 32 kilolitres.	✓	✓	✓
The applicant must install a pool pump timer for the swimming pool.		✓	✓
The applicant must install the following heating system for the swimming pool that is part of this development: solar only.		✓	✓
Outdoor spa			
The spa must not have a capacity greater than 5.45 kilolitres.	✓	✓	✓
The spa must have a spa cover.		✓	✓
The applicant must install a spa pump timer.		✓	✓
The applicant must install the following heating system for the outdoor spa that is part of this development: gas.		✓	✓

Fixtures and systems	Show on DA Plans	Show on CC/CDC Plans & specs	Certifier Check
Lighting			
The applicant must ensure a minimum of 40% of new or altered light fixtures are fitted with fluorescent, compact fluorescent, or light-emitting-diode (LED) lamps.		✓	✓
Fixtures			
The applicant must ensure new or altered showerheads have a flow rate no greater than 9 litres per minute or a 3 star water rating.		✓	✓
The applicant must ensure new or altered toilets have a flow rate no greater than 4 litres per average flush or a minimum 3 star water rating.		✓	✓
The applicant must ensure new or altered taps have a flow rate no greater than 9 litres per minute or minimum 3 star water rating.		✓	✓

Construction	Show on DA Plans	Show on CC/CDC Plans & specs	Certifier Check												
Insulation requirements															
The applicant must construct the new or altered construction (floor(s), walls, and ceilings/roofs) in accordance with the specifications listed in the table below, except that a) additional insulation is not required where the area of new construction is less than 2m2, b) insulation specified is not required for parts of altered construction where insulation already exists.															
	✓	✓	✓												
<table><tr><th>Construction</th><th>Additional insulation required (R-value)</th><th>Other specifications</th></tr><tr><td>floor above existing dwelling or building.</td><td>nil</td><td></td></tr><tr><td>external wall: framed (weatherboard, fibro, metal clad)</td><td>R1.30 (or R1.70 including construction)</td><td></td></tr><tr><td>flat ceiling, flat roof: framed</td><td>ceiling: R1.58 (up), roof: foil backed blanket (55 mm)</td><td>medium (solar absorptance 0.475 - 0.70)</td></tr></table>	Construction	Additional insulation required (R-value)	Other specifications	floor above existing dwelling or building.	nil		external wall: framed (weatherboard, fibro, metal clad)	R1.30 (or R1.70 including construction)		flat ceiling, flat roof: framed	ceiling: R1.58 (up), roof: foil backed blanket (55 mm)	medium (solar absorptance 0.475 - 0.70)			
Construction	Additional insulation required (R-value)	Other specifications													
floor above existing dwelling or building.	nil														
external wall: framed (weatherboard, fibro, metal clad)	R1.30 (or R1.70 including construction)														
flat ceiling, flat roof: framed	ceiling: R1.58 (up), roof: foil backed blanket (55 mm)	medium (solar absorptance 0.475 - 0.70)													

Planning, Industry & Environment

Building Sustainability Index www.basix.nsw.gov.au

Planning, Industry & Environment

Building Sustainability Index www.basix.nsw.gov.au

Planning, Industry & Environment

Building Sustainability Index www.basix.nsw.gov.au




Inlet Design Studio

Newport, NSW, 2106,
P 0415647351
E robyn@inletdesign.com.au

ABN: 26 075 061 335
Copyright © JACARANDA TRADING COMPANY PTY LTD

REVISION:	DATE:	REVISION NOTE:
A	6/07/21	BUILDING HEIGHT LINE ADDED HEIGHT OF ROOF DIMENSION ABOVE GROUND LINE
B	17/03/22	BUILDING HEIGHT LINE AMENDED TO SHOW EXISTING EXCAVATED GROUND LINE & ASSUMED NATURAL GROUND LINE TOP OF ROOF RL 57.82 TO WESTERN SIDE OF SKILLION ROOF
C	30/05/22	PROPOSED TERRACE ROOF LOWERED PLANTER BOX LOWERED & BALUSTRADE ADDED

 

CLIENT:
Luke Rowlands

ADDRESS:
152 Headland Road, NORTH CURL CURL

DRAWING:
Section A-A

PROJECT:
ALTERATIONS AND ADDITIONS

PROJECT NO:
HEA001

ISSUE TYPE:
1




DRAWN:
AJ

CHKD:
RJ


SCALE @ A3:
1:100

ISSUE DATE:
16/06/21

REVISION:
C

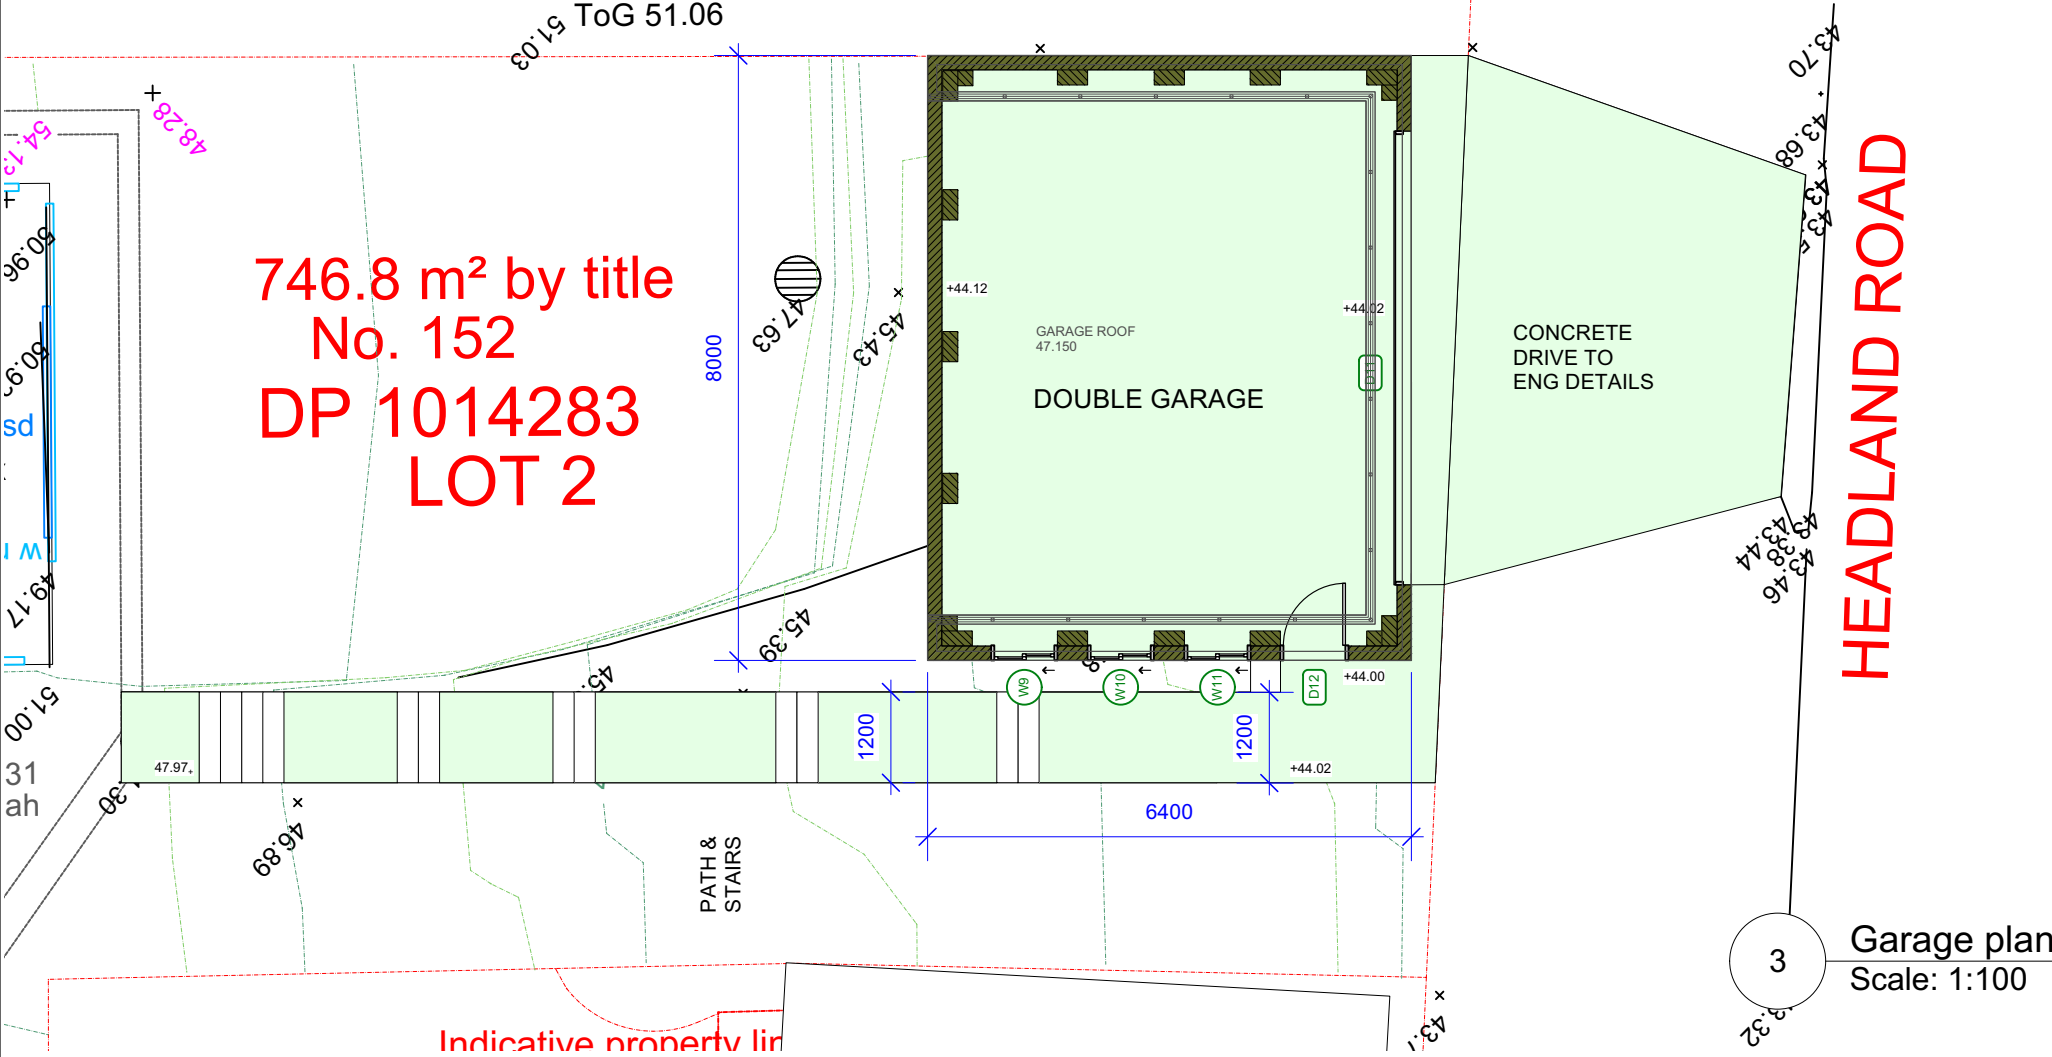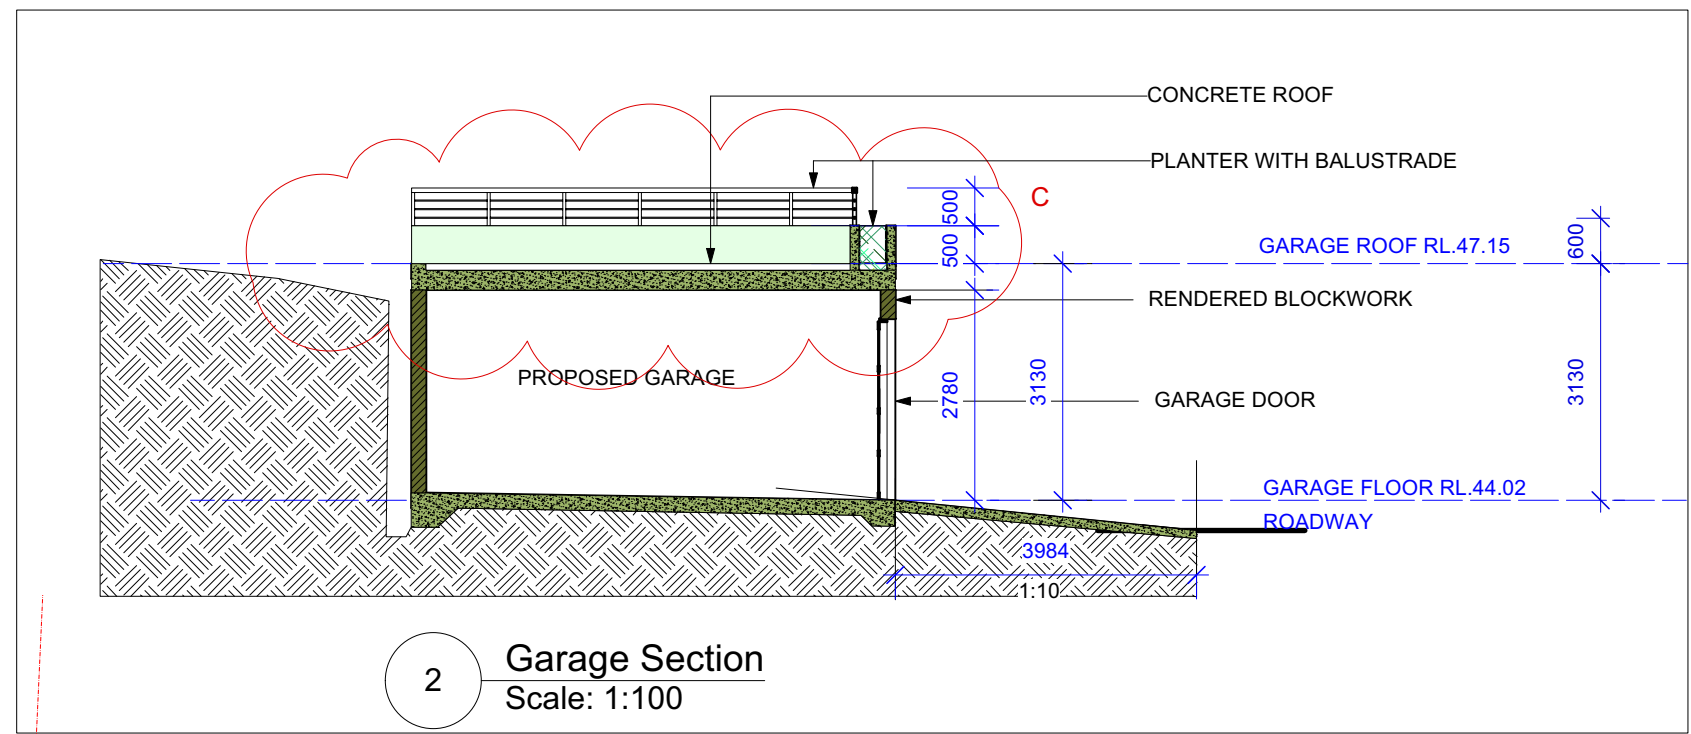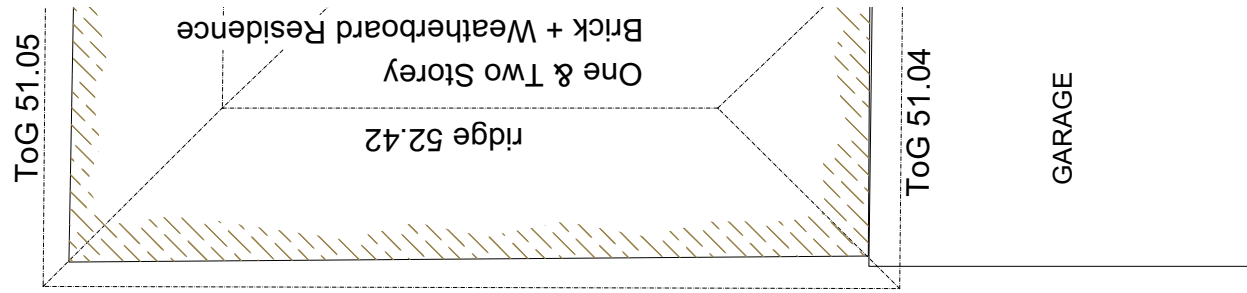

 Inlet Design Studio Newport, NSW, 2106, P 0415647351 E robyn@inletdesign.com.au ABN: 26 075 061 335 Copyright © JACARANDA TRADING COMPANY PTY LTD	REVISION: C	DATE: 30/05/22	REVISION NOTE: PROPOSED TERRACE ROOF LOWERED, PLANTER BOX LOWERED & BALUSTRADE INSTALLED	CLIENT: Luke Rowlands	DRAWING: Garage Plan & Section	DRAWN: AJ	SHEET NO: A09
				ADDRESS: 152 Headland Road, NORTH CURL CURL	PROJECT: ALTERATIONS AND ADDITIONS	CHKD: RJ	SCALE @ A3: 1:100
					PROJECT NO: HEA001	ISSUE DATE: 16/06/21	REVISION: C
					ISSUE TYPE: 4		

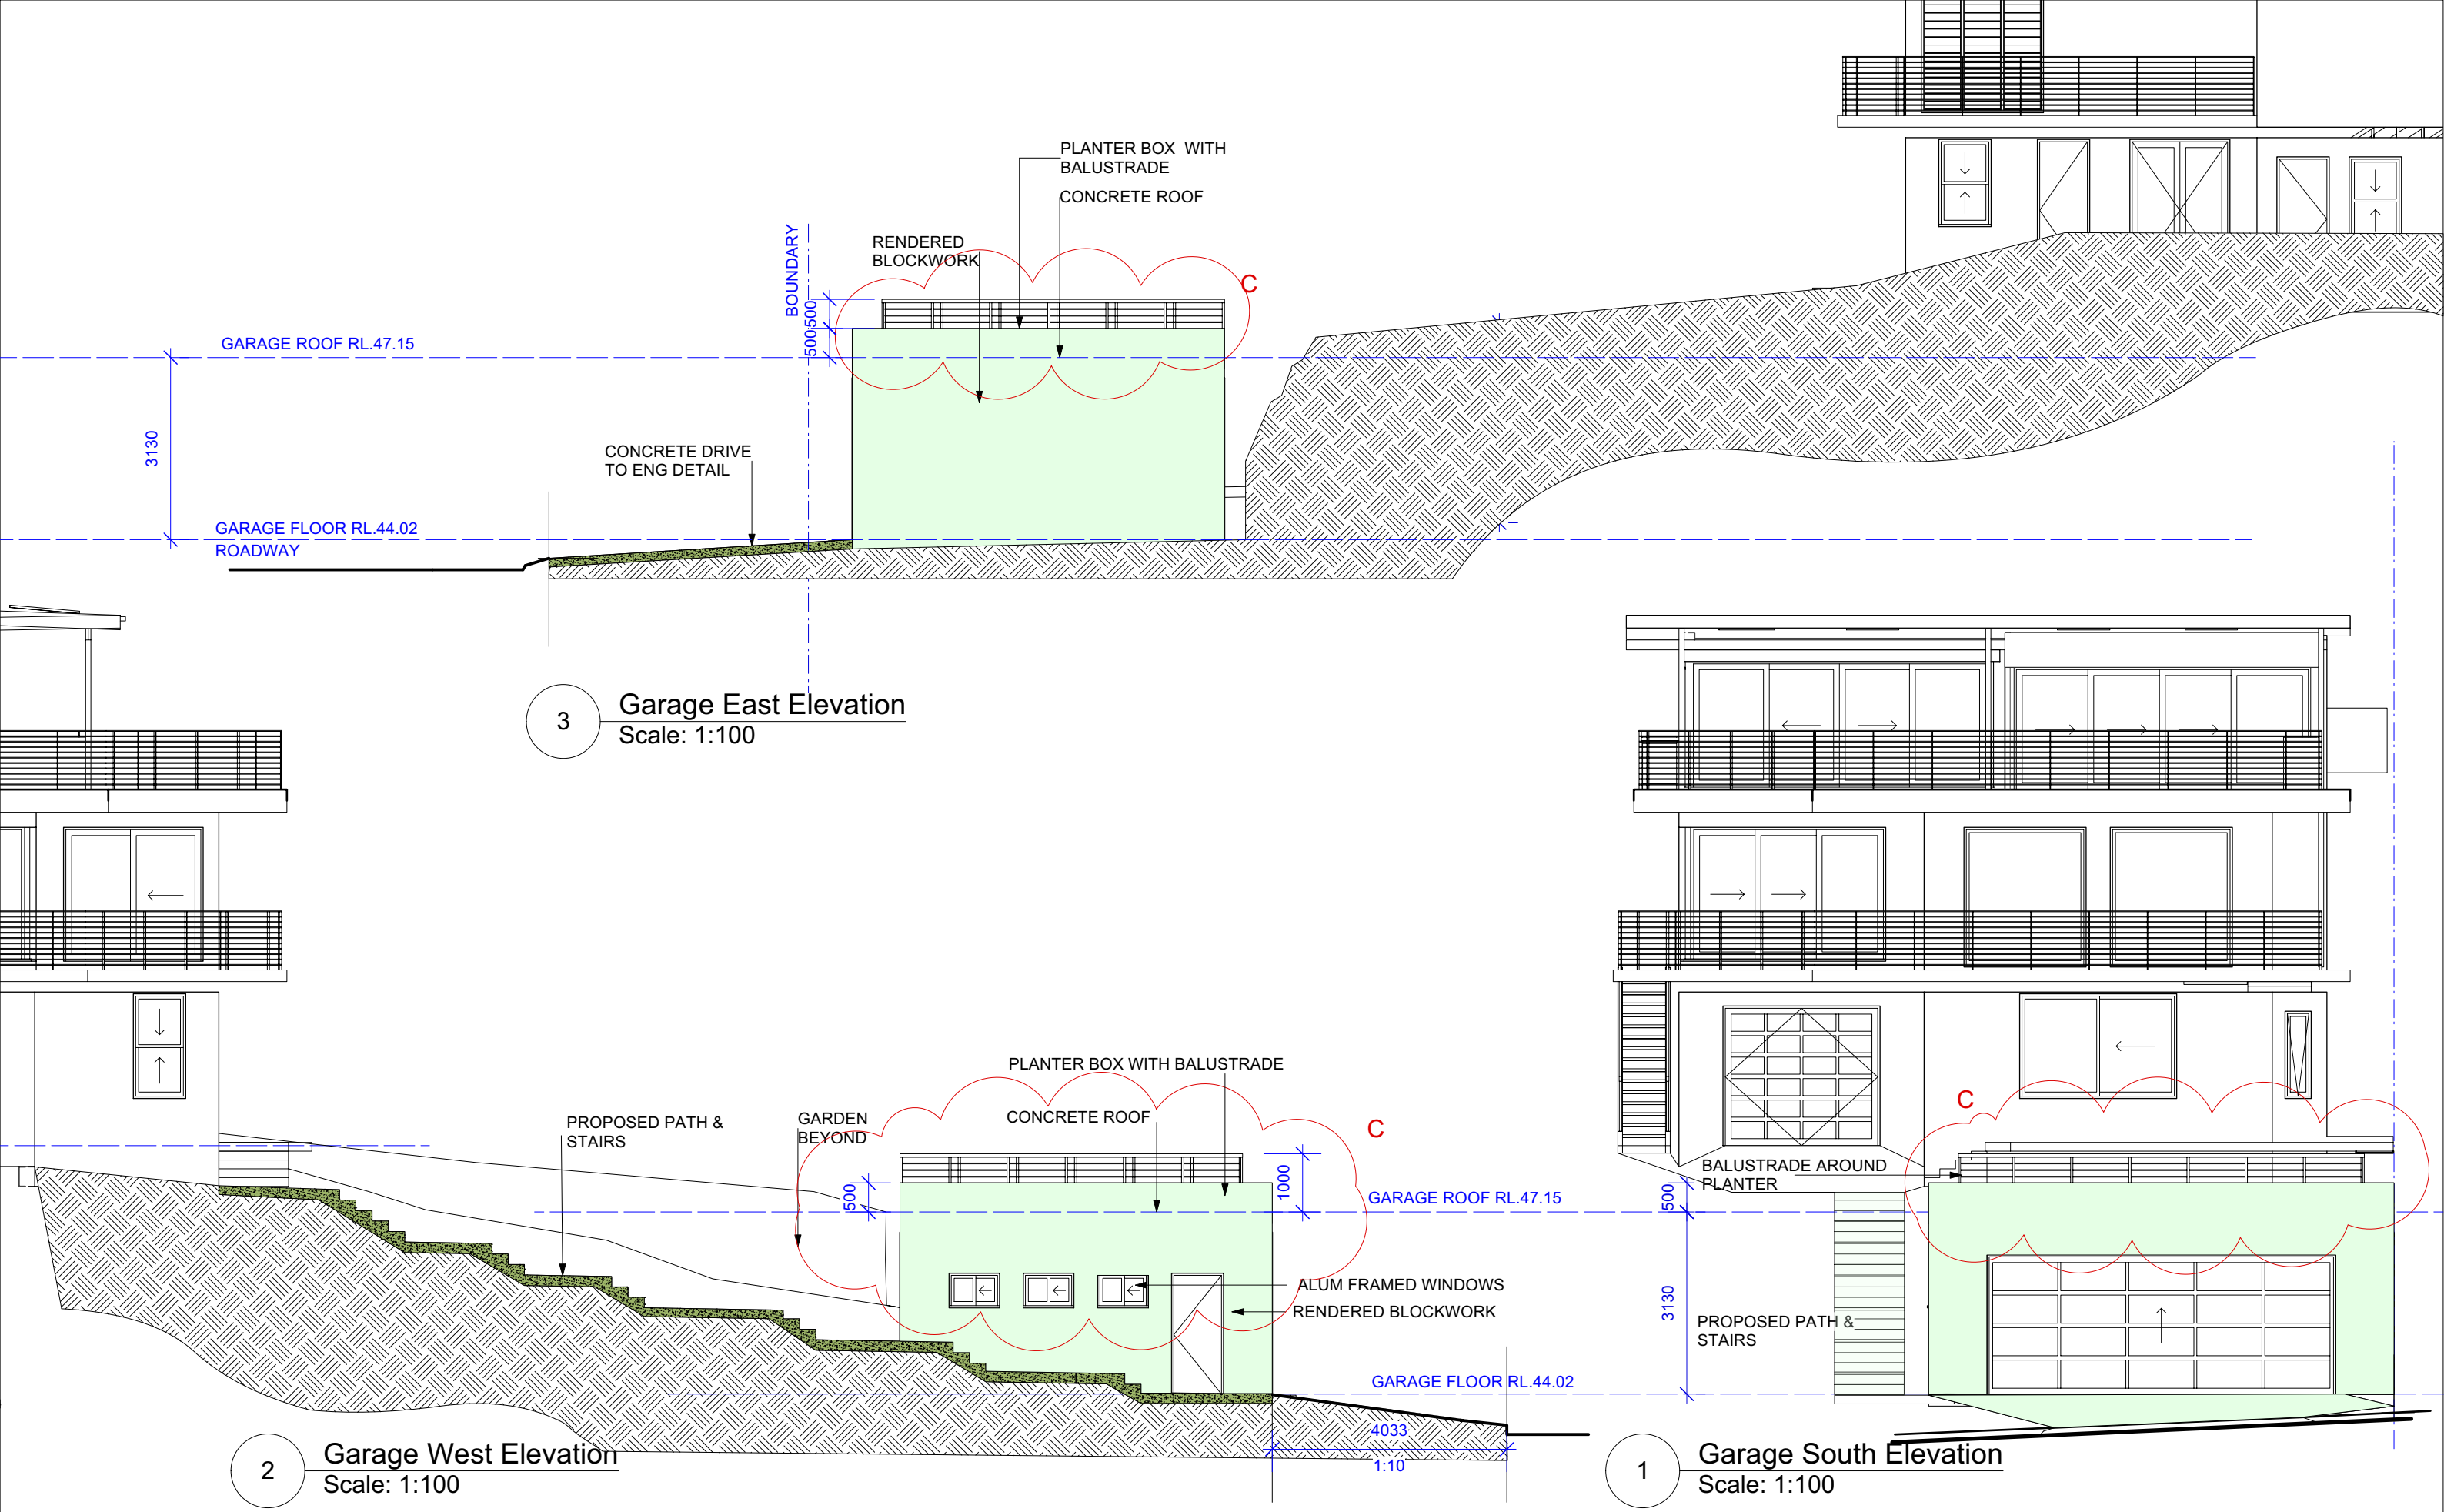

3 Garage East Elevation
Scale: 1:100

2 Garage West Elevation
Scale: 1:100

1 Garage South Elevation
Scale: 1:100




Inlet Design Studio

Newport, NSW, 2106,
P 0415647351
E robyn@inletdesign.com.au

ABN: 26 075 061 335
Copyright © JACARANDA TRADING COMPANY PTY LTD



REVISION:	DATE:	REVISION NOTE:
C	30/05/22	PROPOSED TERRACE ROOF LOWERED PLANTER LOWERED & BALUSTRADE ADDED

 


CLIENT:	Luke Rowlands
ADDRESS:	152 Headland Road, NORTH CURL CURL


DRAWING:	Garage Elevations	DRAWN:	AJ	SHEET NO:	A10
PROJECT:	ALTERATIONS AND ADDITIONS	CHKD:	RJ	SCALE @ A3:	1:100
PROJECT NO:	HEA001	ISSUE TYPE:	4	ISSUE DATE:	16/06/21
				REVISION:	C

  SUN @ JUNE 21ST




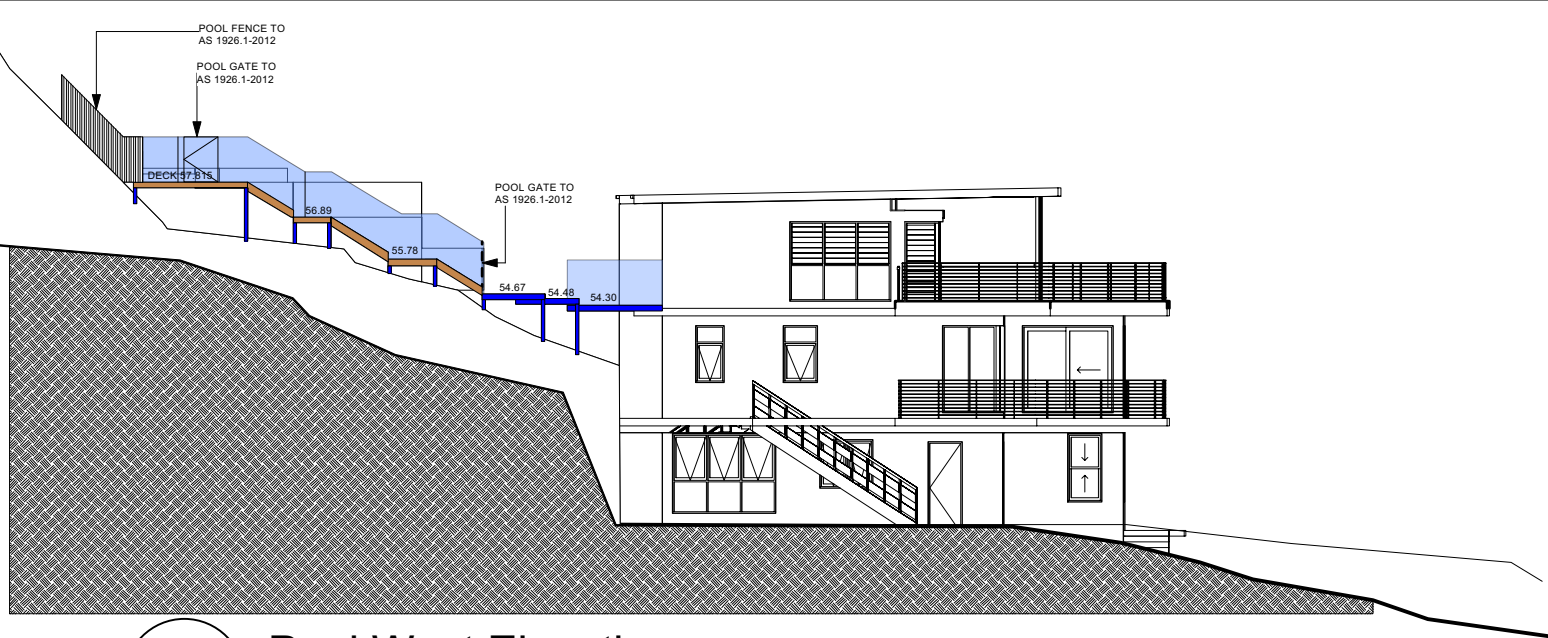


1 **Pool West Elevation**
Scale: 1:200

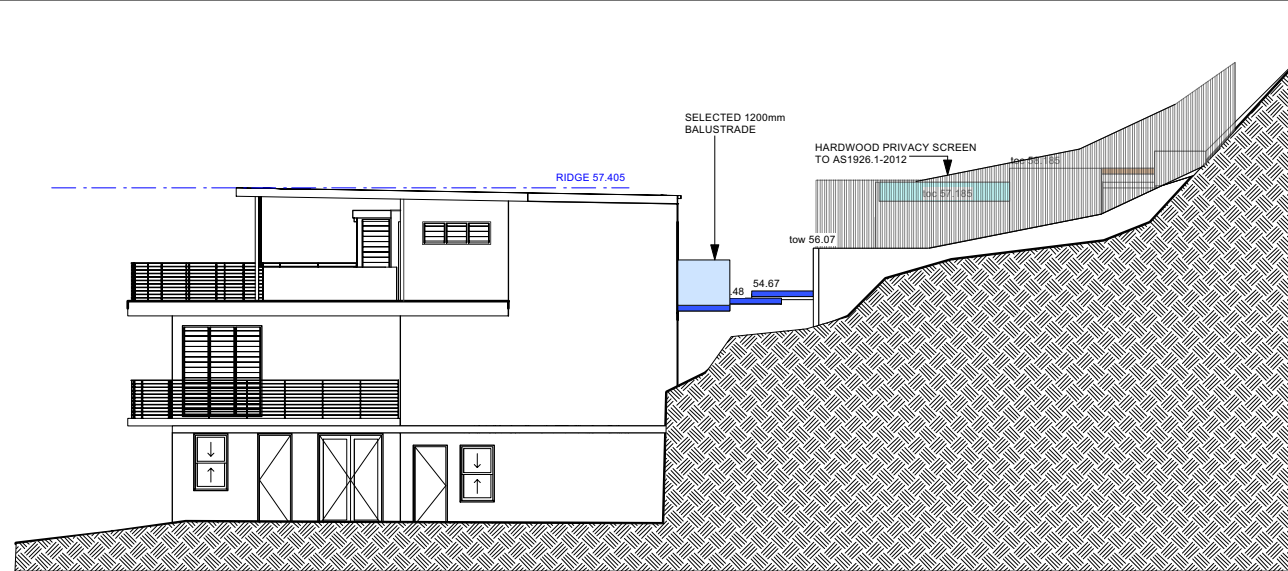


2 **Pool East Elevation**
Scale: 1:200

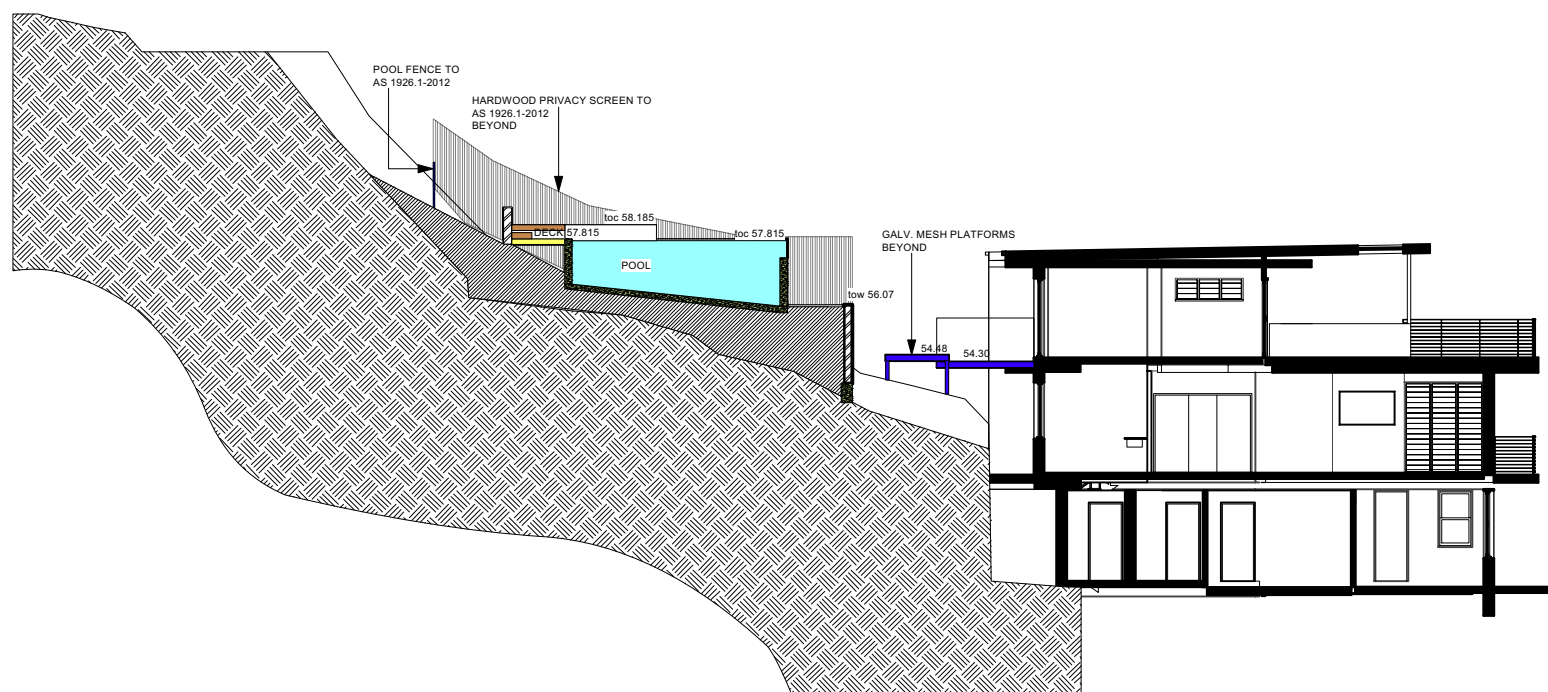

4 **Pool Section**
Scale: 1:200

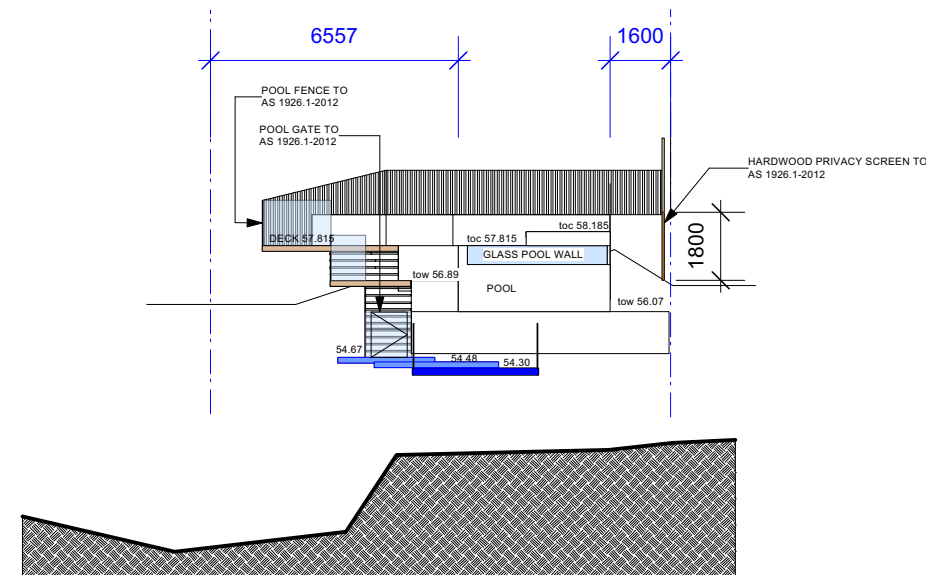

3 **Pool South Elevation**
Scale: 1:200

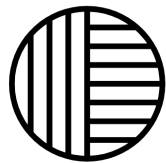

Inlet Design Studio

Newport, NSW, 2106,
P 0415647351
E robyn@inletdesign.com.au

ABN: 26 075 061 335
Copyright © JACARANDA TRADING COMPANY PTY LTD

REVISION: DATE: REVISION NOTE:



CLIENT:
Luke Rowlands

ADDRESS:
152 Headland Road, NORTH CURL CURL

DRAWING:
Pool Elevations & Sections

PROJECT:
ALTERATIONS AND ADDITIONS

PROJECT NO:
HEA001

ISSUE TYPE:
7

DRAWN:
RJ

CHKD:
RJ

ISSUE DATE:
16/06/21

SHEET NO:
A13

SCALE @ A3:
1:200

REVISION:

WINDOWS												
Image	ID	Type	Frame Height	Frame Width	Glazed Area	Hardware	Manufacturer	Model	Screen	Egress	Glazing	Comments
	W1	LW	2400	2100	8.58							
	W2	FS	2400	2100	4.22							
	W3	FS	2400	2100	4.22							
	W4	FG	2300	1400	2.84							
	W5	CU	1500	900	0.95							
	W6	LW	2200	800	2.93							
	W7	LW	2200	800	3.1							
	W8	LW	600	1800	1.61							
	W9	SL	600	875	0.26							
	W10	SL	600	875	0.26							
	W11	SL	600	875	0.26							

DOORS

Image	ID	Type	Frame Height	Frame Width	Leaf Height	Leaf Width	Thickness	Glazed Area	Hardware	Screen	Glazing	Comments
	D1	LS	2300	2400				4.12				
	D2	LP	2300	3340				5.72				
	D3	HL	2080	900				0				
	D4	CS	2080	900				0				
	D5	FS	2100	2500				4.14				
	D6	LP	2100	5100				8.32				
	D7	LS	2200	5100				8.4				
	D8	CS	2080	800				0				
	D9	CS	2080	900				0				
	D10	CS	2080	2665				4.19				
	D11	OS	2400	6000				0				
	D12	HR	2080	900				0				

COMBINATION UNITS

Image	ID	Type	Frame Height	Frame Width	Glazed Area	Hardware	Manufacturer	Model	Screen	Egress	Glazing	Comments
-------	----	------	--------------	-------------	-------------	----------	--------------	-------	--------	--------	---------	----------

BASIX Certificate number: A400027_07				page 6 / 8			
BASIX Certificate number: A400027_07							
page 7 / 8							
BASIX Certificate number: A400027_07							
page 8 / 8							
BASIX Certificate number: A400027_07							
page 9 / 9							
BASIX Certificate number: A400027_07							
page 10 / 10							
BASIX Certificate number: A400027_07							
page 11 / 11							
BASIX Certificate number: A400027_07							
page 12 / 12							
BASIX Certificate number: A400027_07							
page 13 / 13							
BASIX Certificate number: A400027_07							
page 14 / 14							
BASIX Certificate number: A400027_07							
page 15 / 15							
BASIX Certificate number: A400027_07							
page 16 / 16							
BASIX Certificate number: A400027_07							
page 17 / 17							
BASIX Certificate number: A400027_07							
page 18 / 18							
BASIX Certificate number: A400027_07							
page 19 / 19							
BASIX Certificate number: A400027_07							
page 20 / 20							
BASIX Certificate number: A400027_07							
page 21 / 21							
BASIX Certificate number: A400027_07							
page 22 / 22							
BASIX Certificate number: A400027_07							
page 23 / 23							
BASIX Certificate number: A400027_07							
page 24 / 24							
BASIX Certificate number: A400027_07							
page 25 / 25							
BASIX Certificate number: A400027_07							
page 26 / 26							
BASIX Certificate number: A400027_07							
page 27 / 27							
BASIX Certificate number: A400027_07							
page 28 / 28							
BASIX Certificate number: A400027_07							
page 29 / 29							
BASIX Certificate number: A400027_07							
page 30 / 30							
BASIX Certificate number: A400027_07							
page 31 / 31							
BASIX Certificate number: A400027_07							
page 32 / 32							
BASIX Certificate number: A400027_07							
page 33 / 33							
BASIX Certificate number: A400027_07							
page 34 / 34							
BASIX Certificate number: A400027_07							
page 35 / 35							
BASIX Certificate number: A400027_07							
page 36 / 36							
BASIX Certificate number: A400027_07							
page 37 / 37							
BASIX Certificate number: A400027_07							
page 38 / 38							
BASIX Certificate number: A400027_07							
page 39 / 39							
BASIX Certificate number: A400027_07							
page 40 / 40							
BASIX Certificate number: A400027_07							
page 41 / 41							
BASIX Certificate number: A400027_07							
page 42 / 42							
BASIX Certificate number: A400027_07							
page 43 / 43							
BASIX Certificate number: A400027_07							
page 44 / 44							
BASIX Certificate number: A400027_07							
page 45 / 45							
BASIX Certificate number: A400027_07							
page 46 / 46							
BASIX Certificate number: A400027_07							
page 47 / 47							
BASIX Certificate number: A400027_07							
page 48 / 48							
BASIX Certificate number: A400027_07							
page 49 / 49							
BASIX Certificate number: A400027_07							
page 50 / 50							
BASIX Certificate number: A400027_07							
page 51 / 51							
BASIX Certificate number: A400027_07							
page 52 / 52							
BASIX Certificate number: A400027_07							
page 53 / 53							
BASIX Certificate number: A400027_07							
page 54 / 54							
BASIX Certificate number: A400027_07							
page 55 / 55							
BASIX Certificate number: A400027_07							
page 56 / 56							
BASIX Certificate number: A400027_07							
page 57 / 57							
BASIX Certificate number: A400027_07							
page 58 / 58							
BASIX Certificate number: A400027_07							
page 59 / 59							
BASIX Certificate number: A400027_07							
page 60 / 60							
BASIX Certificate number: A400027_07							
page 61 / 61							
BASIX Certificate number: A400027_07							
page 62 / 62							
BASIX Certificate number: A400027_07							
page 63 / 63							
BASIX Certificate number: A400027_07							
page 64 / 64							
BASIX Certificate number: A400027_07							
page 65 / 65							
BASIX Certificate number: A400027_07							
page 66 / 66							
BASIX Certificate number: A400027_07							
page 67 / 67							
BASIX Certificate number: A400027_07							
page 68 / 68							
BASIX Certificate number: A400027_07							
page 69 / 69							
BASIX Certificate number: A400027_07							
page 70 / 70							
BASIX Certificate number: A400027_07							
page 71 / 71							
BASIX Certificate number: A400027_07							
page 72 / 72							
BASIX Certificate number: A400027_07							
page 73 / 73							
BASIX Certificate number: A400027_07							
page 74 / 74							
BASIX Certificate number: A400027_07							
page 75 / 75							
BASIX Certificate number: A400027_07							
page 76 / 76							
BASIX Certificate number: A400027_07							
page 77 / 77							
BASIX Certificate number: A400027_07							
page 78 / 78							
BASIX Certificate number: A400027_07							
page 79 / 79							
BASIX Certificate number: A400027_07							
page 80 / 80							
BASIX Certificate number: A400027_07							
page 81 / 81							
BASIX Certificate number: A400027_07							
page 82 / 82							
BASIX Certificate number: A400027_07							
page 83 / 83							
BASIX Certificate number: A400027_07							
page 84 / 84							
BASIX Certificate number: A400027_07							
page 85 / 85							
BASIX Certificate number: A400027_07							
page 86 / 86							
BASIX Certificate number: A400027_07							
page 87 / 87							
BASIX Certificate number: A400027_07							
page 88 / 88							
BASIX Certificate number: A400027_07							
page 89 / 89							
BASIX Certificate number: A400027_07							
page 90 / 90							
BASIX Certificate number: A400027_07							
page 91 / 91							
BASIX Certificate number: A400027_07							
page 92 / 92							
BASIX Certificate number: A400027_07							
page 93 / 93							
BASIX Certificate number: A400027_07							
page 94 / 94							
BASIX Certificate number: A400027_07							
page 95 / 95							
BASIX Certificate number: A400027_07							
page 96 / 96							
BASIX Certificate number: A400027_07							
page 97 / 97							
BASIX Certificate number: A400027_07							
page 98 / 98							
BASIX Certificate number: A400027_07							
page 99 / 99							
BASIX Certificate number: A400027_07							
page 100 / 100							
BASIX Certificate number: A400027_07							
page 101 / 101							
BASIX Certificate number: A400027_07							
page 102 / 102							
BASIX Certificate number: A400027_07							
page 103 / 103							
BASIX Certificate number: A400027_07							
page 104 / 104							
BASIX Certificate number: A400027_07							
page 105 / 105							
BASIX Certificate number: A400027_07							
page 106 / 106							
BASIX Certificate number: A400027_07							
page 107 / 107							
BASIX Certificate number: A400027_07							
page 108 / 108							
BASIX Certificate number: A400027_07							
page 109 / 109							
BASIX Certificate number: A400027_07							
page 110 / 110							
BASIX Certificate number: A400027_07							
page 111 / 111							
BASIX Certificate number: A400027_07							
page 112 / 112							
BASIX Certificate number: A400027_07							
page 113 / 113							
BASIX Certificate number: A400027_07							
page 114 / 114							
BASIX Certificate number: A400027_07							
page 115 / 115							
BASIX Certificate number: A400027_07							
page 116 / 116							
BASIX Certificate number: A400027_07							
page 117 / 117							
BASIX Certificate number: A400027_07							
page 118 / 118							
BASIX Certificate number: A400027_07							
page 119 / 119							
BASIX Certificate number: A400027_07							
page 120 / 120							
BASIX Certificate number: A400027_07							
page 121 / 121							
BASIX Certificate number: A400027_07							
page 122 / 122							
BASIX Certificate number: A400027_07							
page 123 / 123							
BASIX Certificate number: A400027_07							
page 124 / 124							
BASIX Certificate number: A400027_07							
page 125 / 125							
BASIX Certificate number: A400027_07							
page 126 / 126							
BASIX Certificate number: A400027_07							
page 127 / 127							
BASIX Certificate number: A400027_07							
page 128 / 128							
BASIX Certificate number: A400027_07							
page 129 / 129							
BASIX Certificate number: A400027_07							
page 130 / 130							
BASIX Certificate number: A400027_07							
page 131 / 131							
BASIX Certificate number: A400027_07							
page 132 / 132							
BASIX Certificate number: A400027_07							
page 133 / 133							
BASIX Certificate number: A400027_07							
page 134 / 134							
BASIX Certificate number: A400027_07							
page 135 / 135							
BASIX Certificate number: A400027_07							
page 136 / 136							
BASIX Certificate number: A400027_07							
page 137 / 137							
BASIX Certificate number: A400027_07							
page 138 / 138							
BASIX Certificate number: A400027_07							
page 139 / 139							
BASIX Certificate number: A400027_07							
page 140 / 140							
BASIX Certificate number: A400027_07							
page 141 / 141							
BASIX Certificate number: A400027_07							
page 142 / 142							
BASIX Certificate number: A400027_07							
page 143 / 143							
BASIX Certificate number: A400027_07							
page 144 / 144							
BASIX Certificate number: A400027_07							
page 145 / 145							
BASIX Certificate number: A400027_07							
page 146 / 146							
BASIX Certificate number: A400027_07							
page 147 / 147							
BASIX Certificate number: A400027_07							
page 148 / 148							
BASIX Certificate number: A400027_07							
page 149 / 149							
BASIX Certificate number: A400027_07							
page 150 / 150							
BASIX Certificate number: A400027_07							
page 151 / 151							
BASIX Certificate number: A400027_07							
page 152 / 152							
BASIX Certificate number: A400027_07							
page 153 / 153							
BASIX Certificate number: A400027_07							
page 154 / 154							
BASIX Certificate number: A400027_07							
page 155 / 155							
BASIX Certificate number: A400027_07							
page 156 / 156							
BASIX Certificate number: A400027_07							
page 157 / 157							
BASIX Certificate number: A400027_07							
page 158 / 158							
BASIX Certificate number: A400027_07							
page 159 / 159							
BASIX Certificate number: A400027_07							
page 160 / 160							
BASIX Certificate number: A400027_07							
page 161 / 161							
BASIX Certificate number: A400027_07							
page 162 / 162							
BASIX Certificate number: A400027_07							
page 163 / 163							
BASIX Certificate number: A400027_07							
page 164 / 164							
BASIX Certificate number: A400027_07							
page 165 / 165							
BASIX Certificate number: A400027_07							
page 166 / 166							
BASIX Certificate number: A400027_07							
page 167 / 167							
BASIX Certificate number: A400027_07							
page 168 / 168							
BASIX Certificate number: A400027_07							
page 169 / 169							
BASIX Certificate number: A400027_07							
page 170 / 170							
BASIX Certificate number: A400027_07							
page 171 / 171							
BASIX Certificate number: A400027_07							
page 172 / 172							
BASIX Certificate number: A400027_07							
page 173 / 173							
BASIX Certificate number: A400027_07							
page 174 / 174							
BASIX Certificate number: A400027_07							
page 175 / 175							
BASIX Certificate number: A400027_07							
page 176 / 176							
BASIX Certificate number: A400027_07							
page 177 / 177							
BASIX Certificate number: A400027_07							
page 178 / 178							
BASIX Certificate number: A400027_07							
page 179 / 179							
BASIX Certificate number: A400027_07							
page 180 / 180							
BASIX Certificate number: A400027_07							
page 181 / 181							
BASIX Certificate number: A400027_07							
page 182 / 182							
BASIX Certificate number: A400027_07							
page 183 / 183							
BASIX Certificate number: A400027_07							
page 184 / 184							
BASIX Certificate number: A400027_07							
page 185 / 185							
BASIX Certificate number: A400027_07							
page 186 / 186							
BASIX Certificate number: A400027_07							
page 187 / 187							
BASIX Certificate number: A400027_07							
page 188 / 188							
BASIX Certificate number: A400027_07							
page 189 / 189							
BASIX Certificate number: A400027_07							
page 190 / 190							
BASIX Certificate number: A400027_07							
page 191 / 191							
BASIX Certificate number: A400027_07							
page 192 / 192							
BASIX Certificate number: A400027_07							
page 193 / 193							
BASIX Certificate number: A400027_07							
page 194 / 194							
BASIX Certificate number: A400027_07							
page 195 / 195							
BASIX Certificate number: A400027_07							
page 196 / 196							
BASIX Certificate number: A400027_07							
page 197 / 197							
BASIX Certificate number: A400027_07							
page 198 / 198							
BASIX Certificate number: A400027_07							
page 199 / 199							
BASIX Certificate number: A400027_07							
page 200 / 200							
BASIX Certificate number: A400027_07							
page 201 / 201							
BASIX Certificate number: A400027_07							
page 202 / 202							
BASIX Certificate number: A400027_07							
page 203 / 203							
BASIX Certificate number: A400027_07							
page 204 / 204							
BASIX Certificate number: A400027_07							
page 205 / 205							
BASIX Certificate number: A400027_07							
page 206 / 206							
BASIX Certificate number: A400027_07							
page 207 / 207							
BASIX Certificate number: A400027_07							
page 208 / 208							
BASIX Certificate number: A400027_07							
page 209 / 209							
BASIX Certificate number: A400027_07							
page 210 / 210							
BASIX Certificate number: A400027_07							
page 211 / 211							
BASIX Certificate number: A400027_07							
page 212 / 212							
BASIX Certificate number: A400027_07							
page 213 / 213							
BASIX Certificate number: A400027_07							
page 214 / 214							
BASIX Certificate number: A400027_07							
page 215 / 215							
BASIX Certificate number: A400027_07							
page 216 / 216							
BASIX Certificate number: A400027_07							
page 217 / 217							
BASIX Certificate number: A400027_07							
page 218 / 218							
BASIX Certificate number: A400027_07							
page 219 / 219							
BASIX Certificate number: A400027_07							
page 220 / 220							
BASIX Certificate number: A400027_07							
page 221 / 221							
BASIX Certificate number: A400027_07							
page 222 / 222							
BASIX Certificate number: A400027_07							
page 223 / 223							
BASIX Certificate number: A400027_07							
page 224 / 224							
BASIX Certificate number: A400027_07							
page 225 / 225							
BASIX Certificate number: A400027_07							
page 226 / 226							
BASIX Certificate number: A400027_07							
page 227 / 227							
BASIX Certificate number: A400027_07							
page 228 / 228							
BASIX Certificate number: A400027_07							
page 229 / 229							
BASIX Certificate number: A400027_07							
page 230 / 230							
BASIX Certificate number: A400027_07							
page 231 / 231							
BASIX Certificate number: A400027_07							
page 232 / 232							
BASIX Certificate number: A400027_07							
page 233 / 233							
BASIX Certificate number: A400027_07							
page 234 / 234							
BASIX Certificate number: A400027_07							
page 235 / 235							
BASIX Certificate number: A400027_07							
page 236 / 236							
BASIX Certificate number: A400027_07							
page 237 / 237							
BASIX Certificate number: A400027_07							
page 238 / 238							
BASIX Certificate number: A400027_07							
page 239 / 239							
BASIX Certificate number: A400027_07							
page 240 / 240							
BASIX Certificate number: A400027_07							
page 241 / 241							
BASIX Certificate number: A400027_07							
page 242 / 242							
BASIX Certificate number: A400027_07							
page 243 / 243							
BASIX Certificate number: A400027_07							
page 244 / 244							
BASIX Certificate number: A400027_07							
page 245 / 245							
BASIX Certificate number: A400027_07							
page 246 / 246							
BASIX Certificate number: A400027_07							
page 247 / 247							
BASIX Certificate number: A400027_07							
page 248 / 248							
BASIX Certificate number: A400027_07							
page 249 / 249							
BASIX Certificate number: A400027_07							
page 250 / 250							
BASIX Certificate number: A400027_07							
page 251 / 251							
BASIX Certificate number: A400027_07							
page 252 / 252							
BASIX Certificate number: A400027_07							
page 253 / 253							
BASIX Certificate number: A400027_07							
page 254 / 254							
BASIX Certificate number: A400027_07							
page 255 / 255							
BASIX Certificate number: A400027_07							
page 256 / 256							
BASIX Certificate number: A400027_07							
page 257 / 257							
BASIX Certificate number: A400027_07							
page 258 / 258							
BASIX Certificate number: A400027_07							
page 259 / 259							
BASIX Certificate number: A400027_07							
page 260 / 260							
BASIX Certificate number: A400027_07							
page 261 / 261							
BASIX Certificate number: A400027_07							
page 26							

1. PRELIMINARIES

These specifications shall be read with consideration for established ESD (Environmentally Sustainable Design) principles. Reduction of raw materials, use of reclaimed materials, and particular attention to product standards and specifications are paramount.

These specifications shall be adopted in addition to the standard acceptable codes and methods of construction as applicable under the current Building Code of Australia (BCA) and as prescribed in all relevant Australian Standards. Where a more current Standard or Standards have superseded, or have been introduced in addition to, the specific Standards mentioned in this Specification, the Contractor shall refer to the most current Australian Standard(s) applicable.

- 1.1 Additional Work / Costs to be included
- Certification of works in accordance with as required by all regulatory bodies;

NOTE: All statutory fees, bonds, etc, including Sydney Water, Local Government and the like, including all fees stated required for the CC, to be paid by the Owner. Owner Builder to manage co-ordination and notification of all inspections required.
- Street traffic control and street protection measures as necessary and as required by the Council and other relevant authorities;
- Disconnection and protection of all services as required;
- Provision of temporary builder's services as required during construction;
- Surveys by a qualified land surveyor as required and as necessary to facilitate and complete the works;
- Siltation barriers and stormwater/erosion management in accordance with the Sediment & Erosion Control Plan provided
- Co-ordination & facilitation of all nominated sub-contractors at the Owner's request;

1.2 Dimensions of plans

Figured dimensions shall be taken in preference to those scaled off the plans. The Contractor shall verify all dimensions on site through survey of boundaries prior to commencement of ordering or construction of works and notify the Principal Designer of any discrepancy.

1.3 Contractor / Owner Builder responsibilities

The Contractor shall:
1.3.1 Comply with all relevant building codes and regulations,
1.3.2 Comply with Council regulations as per the approved DA or CDC
1.3.3 Inform the Owner or Designer of any discrepancies within the plans or Conditions of Consent.
1.3.4 Carry out the work in accordance with the contract drawings and Specifications.
1.3.5 Shall ensure that work done by others, is maintained in "as new" condition until completion of the works.
1.3.6 Where "approved", "as approved" or "as selected" is mentioned, seek approval from the Owner or their nominated representative (defined in Contract) before materials are ordered or work begins.
1.3.7 Provide all the required Warranties and Insurances as required under the Home Building Act 1989, including the Builders All Risk Insurance for Owner supplied items once delivered to site.
1.3.8 Generally make good all retained building components, surfaces, etc, affected by the works and prepare all surfaces as required for final finishes.
1.3.9 Coordinate site inspections with nominated PCA.

2. SITE PREPARATION AND EXCAVATION

2.1 Site preparation
2.1.1Site clearing shall be carried out by the Contractor prior to the commencement of construction and applies to the area of works only.
2.1.2 Provide a secure site in accordance with the Authorities' requirements.
1.1.1 Install and maintain silt and sedimentation management measures as required by the Conditions of Consent.

2.2 Demolition
2.2.1 All work to conform with AS2601-2001, including the proper methods of disposal of asbestos or other hazardous material to comply with Work Cover regulations and be disposed of in a legal manner.
2.2.2 Prepare a Hazardous substances management plan to AS 2601 clause 1.6. prior to demolition where required.
2.2.3 Demolished materials shall be re-used or recycled off-site where practicable and at no time shall be disposed of without scrutiny.
2.2.4 Demolition and waste recycling shall follow the guidelines outlined in the best practice' standards published by the Waste Wise Construction Program.

2.3 Excavation / Fill

2.3.1 Excavation for slabs, footings and services shall be limited to minimise natural ground disturbance over the site.
2.3.2 All fill to AS 3798 clause 4.4 including inorganic, non-perishable material suitably graded and capable of compaction to the documented density. (where noted in the engineering specification)

3. CONCRETING

3.0.1 All work in accordance with the Australian Standards AS3600 (Concrete Structure), AS1379 (Ready Mixed Concrete), AS 2870 (Residential slabs and Footings) and any other relevant Standard. All reinforcement shall be specified and certified by the consulting Engineer.
3.0.2 All concrete used in-situ for slabs and footings, including Council crossovers, laybacks and kerbs, shall be "Green 3 Star" concrete as supplied by Boral.
3.0.4 Any excess material spillage or splashing shall be cleaned and appropriately removed by the contractor whilst uncured, and any subsequent damage to material shall be the responsibility of the Contractor.
3.0.5 New RC slabs to be finished as required to achieve the finishes and levels shown in the drawings, including matching existing finished levels where necessary.

4.TERMITE PROTECTION

4.1.1 The Contractor shall construct the floor slabs and footings in accordance with AS2870 (residential slabs and footings) or AS 3600 (concrete structures) and AS3660 (termite management) to create a termite barrier.
4.1.2 In addition to the slab as termite barrier, provide the following non-chemical termite protection in accordance with AS3660 (termite management), by appropriately trained and licensed installers:
4.1.3 Install the termite barrier systems in various parts of the buildings as required to achieve a complete termite barrier, generally in perimeter walls, around slab penetrations, along construction/control joints and at building step-downs/retaining walls, all in accordance with manufacturer's instructions, ABCB National Certification and AS3660.
4.1.4 The Contractor is responsible for ensuring that the physical termite barriers used are fully protected during the carrying out of the works and can be fully Certified with a manufacturer's Warranty at the completion of the works

5. TIMBER PRODUCTS, FINISHES & TREATMENT

5.0.1 General: Provide timber products with finishes and treatments including for durability and carrying appropriate certification for the finishing applications.
5.0.2. General: Provide timbers having natural durability appropriate to the conditions of use, or preservative-treated timber of equivalent durability.
Natural durability class: To AS 5604.
5.0.3. Hardwood timber - As selected by Owner
5.0.4. All work to conform with Australian Standards, including AS1684 (residential timber framing), AS1720.1 (timber structures) and all relevant Australian Standards where they apply.
5.0.5. Stopping of clear-finished timbers will match the selected species or most suitable darker alternative. The stopping will match any general knots and natural deviations.

5.1 CARPENTRY

5.1.1All work to conform with Australian Standards, including AS1684 (residential timber framing), AS1720.1 (timber structures) and all relevant Australian Standards where they apply.
5.1.2 Engineered wood products are to be used structurally throughout the works in preference to steel beams and instead of solid hardwood lengths.
5.2 Roof trusses, wall frames, beams and rafters
5.2.1 New timber roof trusses shall be Carter Holt Harvey LASER Frame TERMINATOR Blue. Where engineered timber is required to meet AS1687, or the structural engineers design specification, use HYPSPAN LVL beams as the first preference. All new posts and roof framing to be termite treated.

6. ELECTRICAL

6.0.1 All electrical work to comply with Australian Standards incl. AS3000 and AS3018.
6.0.2 Lighting and electrical layouts to be reviewed and discussed with Owner prior to final installation.
6.0.3 Inspect the existing meter board and upgrade safety switching if required.
6.0.4 Generally install and position electrical switches/plates to match existing.
6.0.5 Owner to supply light fittings incl. bulbs, Contractor to install.

7.0 PLUMBING & DRAINAGE

7.0.1 All work and materials to AS3500.1.2, AS3500.2.2, AS3500.4.2 and AS2179 installed by licensed tradespersons and in accordance with all regulations.
7.0.2 Provide protection against "water hammer" in plumbing as approved.
7.0.3 Connect all new guttering to existing stormwater lines via new matching downpipes.
7.0.4 Provide sub-soil drainage lines behind retaining walls as required and connect to the existing stormwater provisions.
7.0.5 All stormwater runoff to agricultural drains shall be filtered with appropriate means with the aim of maintaining stormwater quality. All stormwater shall be prevented from carrying excessive silt and sediment into the mains system.

8 MECHANICAL VENTILATION

8.1 All mechanical ventilation and air conditioning to comply with AS 1668.2

9. ROOFING

9.0.1 Generally, all work carried out shall comply with all relevant Australian Standards, including AS1397, AS1445, AS2179, AS2049 and AS3500.
9.0.2 New flat roof material to be Lysaght Kliplok (or similar) suitable for 1° fall
9.0.3 New pitched roof material >5° to be Lysaght CustomOrb (or similar)xx4x4
9.0.4 Owner to select roof colour.

10. PAINTING

All painting to comply with Australian Standards including AS2311 and AS3750 and must be in accordance with the Australian Ecolabel Program's Good Environmental Choice Australia (GECA) standards, as outlined in their publication entitled 'Architectural and Protective Coatings'.
All paint specifications to Resene Low VOC standards (including Resene recommended surface preparation) or approved equivalent.
10.0.1 Apply new paint or appropriate surface coating to all new works externally, including areas where making good existing surfaces will necessitate new paint, unless pre-finished surface (such as Colorbond) is supplied.
10.0.2 Contractor to consult with Owner prior to purchasing paint to confirm areas and surfaces to be painted.
10.0.3 Colour schedule to be provided upon request of the Contractor who will sample test all schemes prior to implementation as approved by owner.
10.0.4 All new external cement render to be finished with selected membrane paint.
10.0.5 All finishes applied as recommended by and strictly in accordance with the manufacturer's recommendations.

11.0 SITE CLEAN UP

11.0.1 All building debris and dead vegetation shall be removed from site at the Contractor's cost and all trenches back-filled in accordance with the consulting structural Engineer's specification and/or instructions.
11.0.2 The Contractor will maintain a clean and dry site throughout the construction period where practicable, with regular cleaning of Sub-Contractor waste and rubbish.
11.0.3 The Contractor is to arrange final cleaning of works and site to the satisfaction of the the Owner.

12. STRUCTURAL STEEL General Requirements

12.1 Fabrication and erection of steel shall comply with Australian Standards including AS1252 (steel bolts, etc), AS1554 (structural steel welding), AS3750 (paints for steel), AS4100 (steel structures), AS4680 (hot-dip galvanizing) and other relevant Australian Standards where they apply.
12.3 Generally, all structural steel beams used shall be LiteSteel beams coated with AZ+ corrosion protection, as specified by the consulting structural engineer and erected only by approved or licensed trade.
12.4 Ensure all exposed steel is hot-dipped then galvanized and painted. It is recommended that all galvanized beams and other expressed structural elements are finished with enamel paint.
12.5 All steel reinforcement used in the works shall comply with Australian Standards including AS 4671 (steel reinforcing materials) or AS 4672 (pre-stressed steel). It shall be cut and bent in accordance with AS 3600 (concrete structures) or AS 2870 (slabs and footings).

13. WINDOWS AND GLAZED DOORS

13.1 Window and door selection as selected by owner, to comply with the BASIX certificate
13.2 Selection and installation: To AS 2047.
13.3 For smoke and heat venting, see AS 2665 which is cited in the BCA.
13.4 Glass type and thickness: To AS 1288, where no glass type or thickness is nominated.
13.5 For Glass type and thickness refer to Table 4.1 AS 1288 and to AS/NZS 4667.
13.6 Glass thickness may be governed by human safety and other requirements – see AS 1288 Section 5. The commonly available thicknesses of various glasses are shown on the wind pressure figures of AS 1288, Section 4.
13.7 In other cases the determination of thickness is usually within the competence of the glazing contractor.
Where thickness is determined by loading from wind actions, the 'design wind pressure' needs to be known in order to interpret the figures and tables of glass sizes and thicknesses in AS 1288.
13.8 Design wind pressure: To AS/NZS 1170.2 or AS 4055 as appropriate.
13.9 Materials and installation: To AS 1288.
13.10 Quality requirements for cut-to-size and processed glass: To AS/NZS 4667.
13.11 Terminology for work on glass: To AS/NZS 4668.

14 METALWORK General Requirements

14.1 All work shall comply with Australian Standards, including AS1163 (steel hollow sections), AS3679 (hot rolled steel), AS1231 (anodised aluminium), AS3715 (powder-coated aluminium), AS1627 (metal finishing) AS2047 (windows) and AS1664 (aluminium structures), AS1554 (welding) and all relevant Australian Standards where they apply.
14.2 Construction detail as required shall be provided within the relevant drawing and only modified with the approval of either the Owner or Principal Designer. All steel sections to be approved by the consulting structural engineer.
14.3 All external stainless steel components shall be 316 external marine grade. Where stainless steel components aren't used, ensure all other exposed steel is hot-dipped then galvanized and enamel painted.

15 MASONRY General Requirements

15.1 Generally, all work to comply with Australian Standards, including AS3700 (masonry construction), AS1316 (masonry cement), AS2904 (damp proof courses) and all relevant Australian Standards where they apply.

16 THERMAL INSULATION

16.1 All thermal insulation shall comply with Australian Standards, including AS4859.1 (thermal insulation materials), AS3999 (installation of bulk insulation), AS4200.1 (reflective foil, etc), AS4426 (insulation of pipework, ducts, etc) and all relevant Australian Standards where they apply.
16.2 Install insulation in walls, roofs and ceilings as detailed in the plans and ensure that all insulation complies with BASIX and the current requirements, and is in accordance with the Australian Ecolabel Program's Good Environmental Choice Australia (GECA) standards, as outlined in their publication entitled 'Insulation'.
16.3 Thermal insulation / lagging shall be fixed to all hot water plumbing..

17 Polystyrene / insulated cladding system (Where applicable)

17.1 Where shown in the plans as painted rendered EPS cladding, provide 100mm thick expanded polystyrene board insulation fixed to stud walls, rendered and coloured as specified by owner.
17.2 The EPS cladding system used shall be Uni-TWS supplied by Unitex, or a similar approved system, and installed strictly as per the manufacturer's details by appropriately trained & skilled trades people.
17.3 The rendering system used shall incorporate all items recommended by the manufacturer for correct installation, including collared fixings; mesh reinforcing at joins, corners, etc; water-based polymer render for fixing the mesh; reinforcing corner/edge/sill reveals; expansion joint sealant (with covering expansion joint profiles); lightweight high impact cement-based render (applied 10 min. thick) such as Unitex High Fibre Render; a selected coloured top-coat such as the Unitex Décor Range; and a final protective membrane coat such as Uniflex Membrane.

18 EXTERNAL WALL LININGS / TEXTURE COATING

18.1 All external wall linings and coatings shall comply with all relevant Australian Standards, including AS3972 (cement), AS1672.1 (limes), AS2758.1 (aggregates), AS1478 (admixtures), AS4548 (texture coatings) and AS1580 (paints, etc).
18.2 Where nominated in plans, rendered external masonry walls shall be painted with an approved proprietary render membrane paint.
18.4 All selected finish colours to be pre-approved by supplying sample boards in nominated colours, prior to application on walls.

19 GENERAL

19.1 Demolition of existing structur and/or alterations to the existing structure to comply with AS 4361.2 - Guid to lead paint management
19.2 Outdoor lighting to comply with AS 4282:1997
19.3 Pruning of amenity trees to comply with AS 4373-2007
19.4 Tree protection measures where relevant on the development site to comply with AS 4970-2009
19.5 Off-street parking to comply with AS/NZS 2890.1:2004, and Council regulations

 Inlet Design Studio Newport, NSW, 2106, P 0415647351 E robyn@inletdesign.com.au ABN: 26 075 061 335 Copyright © JACARANDA TRADING COMPANY PTY LTD	REVISION: DATE: REVISION NOTE:	
--	--------------------------------------	---

Alterations and Additions

Certificate number: A400627_07

This certificate confirms that the proposed development will meet the NSW government's requirements for sustainability, if it is built in accordance with the commitments set out below. Terms used in this certificate, or in the commitments, have the meaning given by the document entitled "BASIX Alterations and Additions Definitions" dated 06/10/2017 published by the Department. This document is available at www.basix.nsw.gov.au

Secretary
Date of issue: Thursday, 16, June 2022
To be valid, this certificate must be lodged within 3 months of the date of issue.



Description of project

Project address	
Project name	152 Headland_07
Street address	152 Headland Road North Curl Curl 2099
Local Government Area	Northern Beaches Council
Plan type and number	Deposited Plan 1014283
Lot number	2
Section number	
Project type	
Dwelling type	Separate dwelling house
Type of alteration and addition	My renovation work is valued at \$50,000 or more, and includes a pool (and/or spa).

Certificate Prepared by (please complete before submitting to Council or PCA)
Name / Company Name: Jacaranda Trading International Pty Ltd
ABN (if applicable): 26075061335

Construction	Show on DA Plans	Show on CC/CDC Plans & specs	Certifier Check
Insulation requirements			
The applicant must construct the new or altered construction (floor(s), walls, and ceilings/roofs) in accordance with the specifications listed in the table below, except that a) additional insulation is not required where the area of new construction is less than 2m ² , b) insulation specified is not required for parts of altered construction where insulation already exists.			
Construction	Additional insulation required (R-value)	Other specifications	
floor above existing dwelling or building.	nil		
external wall: framed (weatherboard, fibro, metal clad)	R1.30 (or R1.70 including construction)		
flat ceiling, flat roof: framed	ceiling: R1.58 (up), roof: foil backed blanket (55 mm)	medium (solar absorptance 0.475 - 0.70)	

Glazing requirements						Show on DA Plans	Show on CC/CDC Plans & specs	Certifier Check
Window / door no.	Orientation	Area of glass inc. frame (m ²)	Overshadowing Height (m) Distance (m)		Shading device	Frame and glass type		
W8	E	1.61	0	0	eave/verandah/ pergola/balcony >=600 mm	improved aluminium, single pyrolytic low-e, (U-value: 4.48, SHGC: 0.46)		


Pool and Spa	Show on DA Plans	Show on CC/CDC Plans & specs	Certifier Check
Rainwater tank			
The applicant must install a rainwater tank of at least 5140 litres on the site. This rainwater tank must meet, and be installed in accordance with, the requirements of all applicable regulatory authorities.	✓	✓	✓
The applicant must configure the rainwater tank to collect rainwater runoff from at least 90 square metres of roof area.		✓	✓
The applicant must connect the rainwater tank to a tap located within 10 metres of the edge of the pool and outdoor spa.		✓	✓
Outdoor swimming pool			
The swimming pool must be outdoors.	✓	✓	✓
The swimming pool must not have a capacity greater than 32 kilolitres.	✓	✓	✓
The applicant must install a pool pump timer for the swimming pool.		✓	✓
The applicant must install the following heating system for the swimming pool that is part of this development: solar only.		✓	✓
Outdoor spa			
The spa must not have a capacity greater than 5.45 kilolitres.	✓	✓	✓
The spa must have a spa cover.		✓	✓
The applicant must install a spa pump timer.		✓	✓
The applicant must install the following heating system for the outdoor spa that is part of this development: gas.		✓	✓

Fixtures and systems	Show on DA Plans	Show on CC/CDC Plans & specs	Certifier Check
Lighting			
The applicant must ensure a minimum of 40% of new or altered light fixtures are fitted with fluorescent, compact fluorescent, or light-emitting-diode (LED) lamps.		✓	✓
Fixtures			
The applicant must ensure new or altered showerheads have a flow rate no greater than 9 litres per minute or a 3 star water rating.		✓	✓
The applicant must ensure new or altered toilets have a flow rate no greater than 4 litres per average flush or a minimum 3 star water rating.		✓	✓
The applicant must ensure new or altered taps have a flow rate no greater than 9 litres per minute or minimum 3 star water rating.		✓	

Glazing requirements	Show on DA Plans	Show on CC/CDC Plans & specs	Certifier Check			
Windows and glazed doors						
The applicant must install the windows, glazed doors and shading devices, in accordance with the specifications listed in the table below. Relevant overshadowing specifications must be satisfied for each window and glazed door.	✓	✓	✓			
The following requirements must also be satisfied in relation to each window and glazed door:		✓	✓			
Each window or glazed door with standard aluminium or timber frames and single clear or toned glass may either match the description, or, have a U-value and a Solar Heat Gain Coefficient (SHGC) no greater than that listed in the table below. Total system U-values and SHGCs must be calculated in accordance with National Fenestration Rating Council (NFRC) conditions.		✓	✓			
Each window or glazed door with improved frames, or pyrolytic low-e glass, or clear/air gap/clear glazing, or toned/air gap/clear glazing must have a U-value and a Solar Heat Gain Coefficient (SHGC) no greater than that listed in the table below. Total system U-values and SHGCs must be calculated in accordance with National Fenestration Rating Council (NFRC) conditions. The description is provided for information only. Alternative systems with complying U-value and SHGC may be substituted.		✓	✓			
For projections described in millimetres, the leading edge of each eave, pergola, verandah, balcony or awning must be no more than 500 mm above the head of the window or glazed door and no more than 2400 mm above the sill.	✓	✓	✓			
Pergolas with polycarbonate roof or similar translucent material must have a shading coefficient of less than 0.35.		✓	✓			
Pergolas with fixed battens must have battens parallel to the window or glazed door above which they are situated, unless the pergola also shades a perpendicular window. The spacing between battens must not be more than 50 mm.		✓	✓			
Overshadowing buildings or vegetation must be of the height and distance from the centre and the base of the window and glazed door, as specified in the 'overshadowing' column in the table below.	✓	✓	✓			
Windows and glazed doors glazing requirements						
Window / door no.	Orientation	Area of glass inc. frame (m ²)	Overshadowing Height (m) Distance (m)	Shading device	Frame and glass type	
W1	E	8.58	0	0	eave/verandah/ pergola/balcony >=900 mm	standard aluminium, single clear, (or U-value: 7.63, SHGC: 0.75)
W2	S	4.22	0	0	eave/verandah/ pergola/balcony >=900 mm	standard aluminium, single clear, (or U-value: 7.63, SHGC: 0.75)

Glazing requirements							Show on DA Plans	Show on CC/CDC Plans & specs	Certifier Check
Window / door no.	Orientation	Area of glass inc. frame (m ²)	Overshadowing		Shading device	Frame and glass type			
			Height (m)	Distance (m)					
W3	S	4.22	0	0	eave/verandah/pergola/balcony >=900 mm	standard aluminium, single clear, (or U-value: 7.63, SHGC: 0.75)			
W4	W	2.84	0	0	eave/verandah/pergola/balcony >=900 mm	standard aluminium, single clear, (or U-value: 7.63, SHGC: 0.75)			
W5	E	1.41	0	0	eave/verandah/pergola/balcony >=600 mm	standard aluminium, single pyrolytic low-e, (U-value: 5.7, SHGC: 0.47)			
W6	E	2.93	0	0	eave/verandah/pergola/balcony >=900 mm	standard aluminium, single pyrolytic low-e, (U-value: 5.7, SHGC: 0.47)			
W7	W	3.1	0	0	eave/verandah/pergola/balcony >=900 mm	standard aluminium, single clear, (or U-value: 7.63, SHGC: 0.75)			
D2	W	4.12	0	0	eave/verandah/pergola/balcony >=900 mm	standard aluminium, single clear, (or U-value: 7.63, SHGC: 0.75)			
D3	S	5.72	0	0	eave/verandah/pergola/balcony >=900 mm	standard aluminium, single clear, (or U-value: 7.63, SHGC: 0.75)			
D5	N	4.14	0	0	eave/verandah/pergola/balcony >=900 mm	standard aluminium, single clear, (or U-value: 7.63, SHGC: 0.75)			
D6	S	8.4	0	0	eave/verandah/pergola/balcony >=900 mm	standard aluminium, single clear, (or U-value: 7.63, SHGC: 0.75)			
W7	W	3.1	0	0	eave/verandah/pergola/balcony >=900 mm	standard aluminium, single clear, (or U-value: 7.63, SHGC: 0.75)			
W9	W	0.26	4	4	none	standard aluminium, single clear, (or U-value: 7.63, SHGC: 0.75)			
W10	W	0.26	4	4	none	improved aluminium, single pyrolytic low-e, (U-value: 4.48, SHGC: 0.46)			
W11	W	0.26	4	4	none	improved aluminium, single pyrolytic low-e, (U-value: 4.48, SHGC: 0.46)			

 Legend
In these commitments, "applicant" means the person carrying out the development.
Commitments identified with a "✓" in the "Show on DA plans" column must be shown on the plans accompanying the development application for the proposed development (if a development application is to be lodged for the proposed development).
Commitments identified with a "✓" in the "Show on CC/CDC plans & specs" column must be shown in the plans and specifications accompanying the application for a construction certificate / complying development certificate for the proposed development.
Commitments identified with a "✓" in the "Certifier check" column must be certified by a certifying authority as having been fulfilled, before a final occupation certificate for the development may be issued.

 Inlet Design Studio Newport, NSW, 2106, P 0415647351 E robyn@inletdesign.com.au ABN: 26 075 061 335 Copyright © JACARANDA TRADING COMPANY PTY LTD	REVISION: DATE: REVISION NOTE:		CLIENT: Luke Rowlands	DRAWING: Basix	DRAWN: RJ	SHEET NO: A16	
			ADDRESS: 152 Headland Road, NORTH CURL CURL	PROJECT: ALTERATIONS AND ADDITIONS	CHKD: RJ	SCALE @ A3: NTS	
				PROJECT NO: HEA001	ISSUE TYPE: 7	ISSUE DATE: 16/06/21	REVISION: