

NOTE:

OWNER TO DEMOLISH & REMOVE FROM WITHIN SITE EXISTING HOUSE, INCLUDING FOOTINGS & SERVICES ABOVE & BELOW GROUND, PATHS, DRIVE, TREES & FENCES etc. PRIOR TO COMMENCEMENT OF CONSTRUCTION.
* EXISTING REAR STRUCTURES AT THE REAR OF HOUSE TO BE REMAINED, SUCH AS POOL/SPA, PUMP HOUSE, CUBBY HOUSE, GRASS AND TREES.

STORMWATER TO STREET VIA RAINWATER TANK

REFER TO HYDRAULIC DETAILS

FINAL
2 FEBRUARY 2016
CONSTRUCTION

DA COUNCIL APPROVAL

COUNCIL DEVELOPMENT APPROVAL PROCESS REQUIRED
REFER TO COUNCIL REGULATIONS FOR FURTHER DETAILS

LOT 2
D.P.: 13139
L.G.A.: WARRINGAH

EXISTING TREES TO BE RETAINED.
ALL TREE PROTECTION MEASURES, INCLUDING FENCING, ARE TO BE IN PLACE PRIOR TO COMMENCEMENT OF WORKS.
REFER TO CONST. WASTE & EROSION PLAN

RETAINING WALL BY KURMOND HOMES
LOCATION OF RAIN WATER TANK
EXISTING POOL/SPA TO BE REMAINED

Original location of aircon unit

PROPOSED RESIDENCE
FFL R.L. 71.988
FGL R.L. 71.603

New location of air conditioning unit

GARAGE STEPDOWN
429mm
FFL R.L. 71.559

PROPOSED CONCRETE DRIVEWAY & PATH BY KURMOND HOMES
(approx gradient of 13%)
(approx area 37.63m²)

PLAIN CONCRETE CROSSOVER SUBJECT TO COUNCIL'S SPECIFICATION
(approx area 25.76m²)

RAYNER AVENUE

BM 58
NAIL IN KERB
RL 69.99
(AHD)

EXISTING BRICK FENCE TO BE RETAINED

NOTE:

DRAINAGE PLAN.
REFER TO HYDRAULIC ENGR'S DETAILS.

EXISTING LAYBACK TO BE REMOVED AND MAKE A NEW LAYBACK AS PROPOSED LOCATION.

SITE PLAN

SCALE 1:200M

NOTES

- Bearings and distances are by Title and/or Deed only.
This detail survey is not a "survey" as defined by the Surveyors Act 1982.
If any construction is planned it would be advisable to carry out further survey work to determine the boundary dimensions.
- Relationship of improvements to boundaries is diagrammatic only.
Where offsets are critical they should be confirmed by further survey.
- Contours shown depict the topography, except at spot levels shown they do not represent the exact level at any particular point.
- Services shown hereon have been determined from visual evidence only.
Prior to any demolition, excavation or construction on the site the relevant authority should be contacted to establish detailed location and depth.
Australian Height Datum was established from SSM 168755 RL 69.056
- Tree locations are accurate to +/- 0.30m
- The information is only to be used at a scale accuracy of 1:200.

LOCATION PLAN

UBD REF: 177, P3
LAT: -33.74598
LONG: 151.27756

Maximum 1000mm CUT
Maximum 1000mm FILL

WIND CLASSIFICATION: "N1"

SLAB CLASSIFICATION: "H2"

www.dialbeforeyoudig.com.au



SITE INDUCTION

Before entering site please review and make yourself familiar with Emergency Contacts. Site Specific Hazards and the Site Specific Induction Information that is located on the Site Induction Sign. If you have any trouble understanding this instruction, contact the Site Supervisor or Emergency Contact Number located on the sign.

SITE SPECIFIC HAZARDS

- * OVERHEAD POWERLINES
- * EXISTING POOL
- * TRAFFIC CONTROL REQUIRED
- * EXISTING TREES / OVERHEAD OBSTRUCTION

CLIENT'S SIGNATURE: _____

DATE: _____

I accept and understand the plans and documents that have been provided to me by Kurmond Homes.

NOTE:
ALL DIMENSIONS ARE IN MILLIMETERS. ALL DIMENSIONS ARE FRAME TO FRAME. DO NOT SCALE OFF PLANS.

HOUSE NAME:
GLENLEIGH 47.86

FACADE:
VOGUE

DESCRIPTION:
DIAMOND INCL

SCALE:
1:200

DATE:
L/H

CLIENT:
**EDDIE DE MARTIN
DIANA DE MARTIN**

SITE ADDRESS:
**LOT 2 DP 13139
24 RAYNER AVENUE
NARRAWEENA 2099**

JOB No:
14174

DRAWN: ME DATE: 10.05.16

CHECKED: ME SHEET: 2


CONSTRUCTION

kurmondhomes

Kurmond Homes PTY LTD
19 Sovereign Place, South Windsor 2756
T: 1300 764 761 BL No. 205 457C
F: (02) 45714015 ABN 481 288 211 98
All rights reserved. This plan is the property of KURMOND HOMES PTY LTD.
Copyright in this document is owned by KURMOND HOMES PTY LTD.
Under the provisions of the Copyright Act 1968 and is not to be used only as authorized by KURMOND HOMES PTY LTD.




© COPYRIGHT

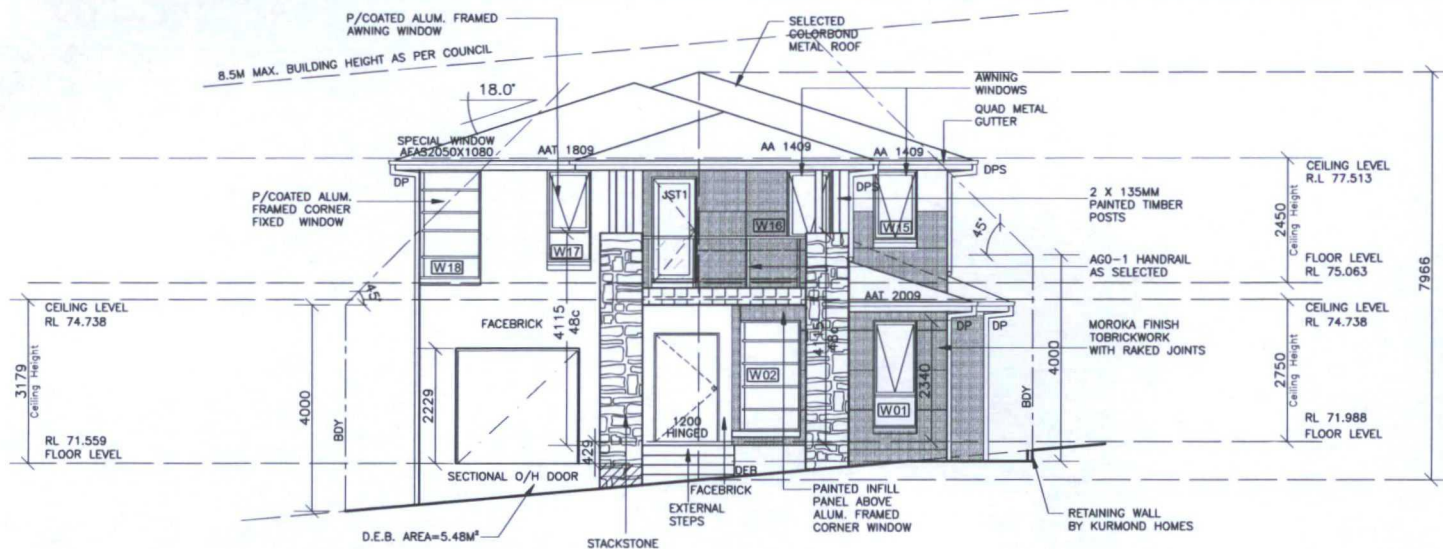

NORTH ELEVATION

Front Elevation

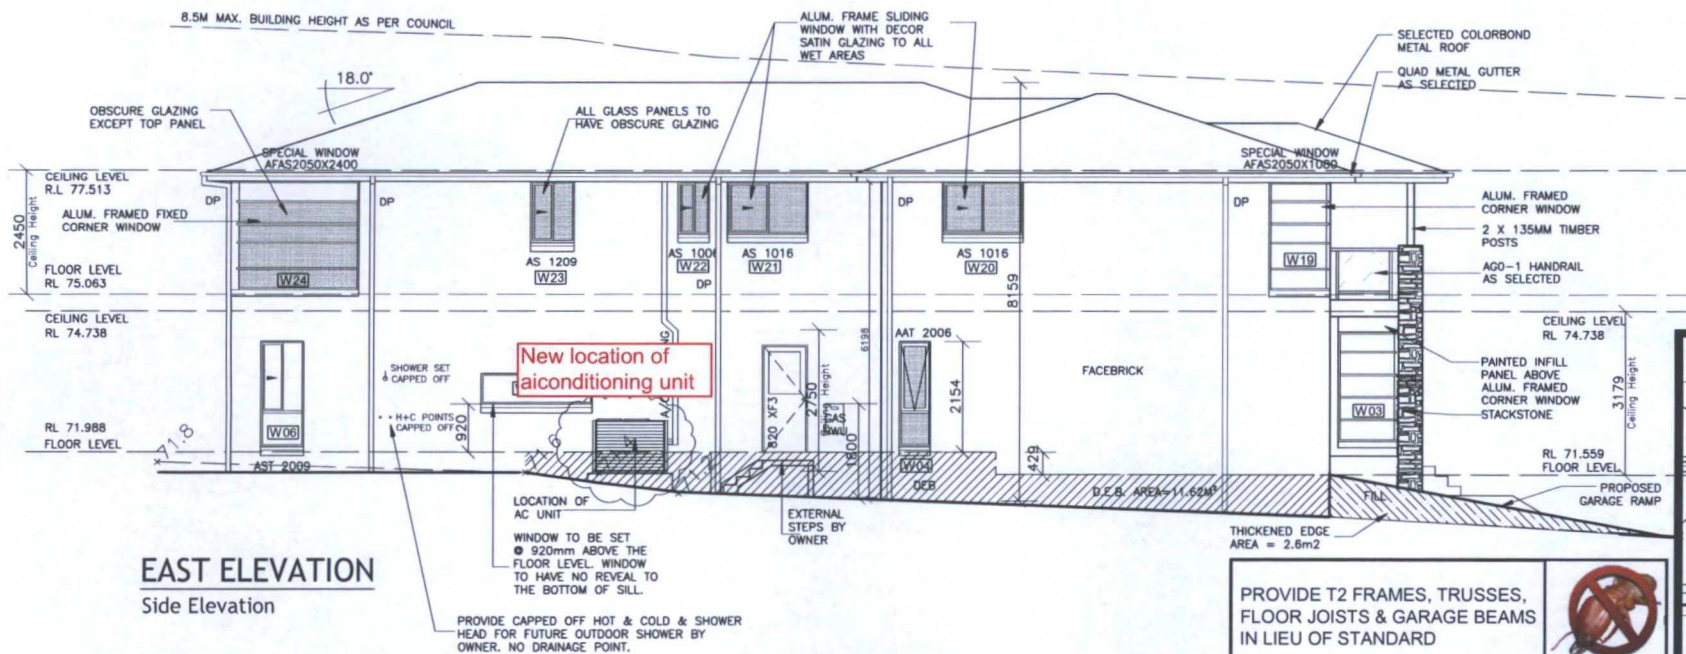


EAST ELEVATION

Side Elevation

- NOTE:**
- ALL SQUARE SET OPENINGS TO BE 2350MM HIGH TO 2750MM HIGH CEILINGS
 - ALL SQUARE SET OPENINGS TO BE 2200MM HIGH TO 2450MM HIGH CEILINGS
 - ALL INTERNAL DOORS TO BE 2040MM HIGH WINDOWS TO HAVE PROTECTION OF OPENABLE WINDOWS TO COMPLY WITH THE BUILDING CODE OF AUSTRALIA VOLUME 2 2013, IN RELATION TO THE BEDROOM WINDOWS
 - ELECTRIC WALL MOUNTED OVEN, RANGEHOOD & COOKTOP TO BE INSTALLED AND SUPPLIED BY OWNER AFTER HANDOVER.
 - GAS POINTS LOCATION AND ELECTRICAL LAYOUTS, REFER TO ROD WEST ELECTRICAL PL.
 - KITCHEN, SCULLERY AND VANITIES DETAILS, REFER TO STAR KITCHEN DETAILS.
 - R2.5 ACOUSTIC INSULATION BATTS TO BED 2, 3, 4 & THEATRE ROOM
 - R2.5 ACOUSTIC CEILING BATTS TO THEATRE ROOM
 - R3.0 CEILING BATTS TO GARAGE
 - R2.0 EXTERNAL WALLS INSULATION AND R 3.0 CEILING INSULATION BATTS IN ACCORDANCE WITH BASIX CERTIFICATE
 - ARTICULATION JOINTS AND STEEL BEAMS IN ACCORDANCE WITH STRUCTURAL ENGINEER'S PLANS.
 - LANDSCAPING IN ACCORDANCE WITH A TOTAL CONCEPT PLANS AND SPECIFICATION BY OWNER.
 - RETAINING WALLS TO BE VERIFIED ON SITE.
 - DRAINER PLUMBER TO MAKE SURE THAT DRAINAGE IS AWAY FROM THE SLAB BY 50mm AND PLUMBER TO USE OFFSET BRACKETS WHEN INSTALLING THE DOWN PIPES.
 - OWNER TO INSTALL FIXED / SHELTERED CLOTHES DRYING AREA.

FINAL
2 FEBRUARY 2016
CONSTRUCTION

PLATFORM DETAIL

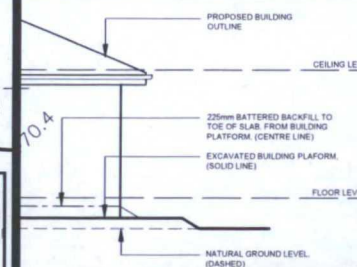

PROVIDE T2 FRAMES, TRUSSES,
FLOOR JOISTS & GARAGE BEAMS
IN LIEU OF STANDARD



CLIENT'S SIGNATURE: _____
DATE: _____
I accept and understand the plans and documents
that have been provided to me by Kurmond Homes.

NOTE:
ALL DIMENSIONS ARE IN
MILLIMETERS. ALL DIMENSIONS
ARE FRAME TO FRAME. DO NOT
SCALE OFF PLANS.


HOUSE NAME:
GLENLEIGH 47.86
FACADE:
VOGUE
INTERIOR:
DIAMOND INCL
SCALE: 1:100 L/H

CLIENT:
EDDIE DE MARTIN
DIANA DE MARTIN
SITE ADDRESS:
LOT 2 DP 13139
24 RAYNER AVENUE
NARRAWEENA 2099


JOB No: 14174
DRAWN: ME DATE: 10.05.16 Rev: W
CHECKED: ME SHEET: 5
CONSTRUCTION

kurmondhomes
Kurmond Homes PTY LTD
10 Sovereign Place, South Windsor 2756
T: 1300 764 761 BL No. 205 457C
F: (02) 45714815 ABN 481 288 211 98
ALL RIGHTS RESERVED. This plan is the property of KURMOND HOMES PTY LTD.
Copyright in this document is owned by KURMOND HOMES PTY LTD.
Under the provisions of the Copyright ACT 1968 and is intended for use only as
authorised by KURMOND HOMES PTY LTD. © COPYRIGHT



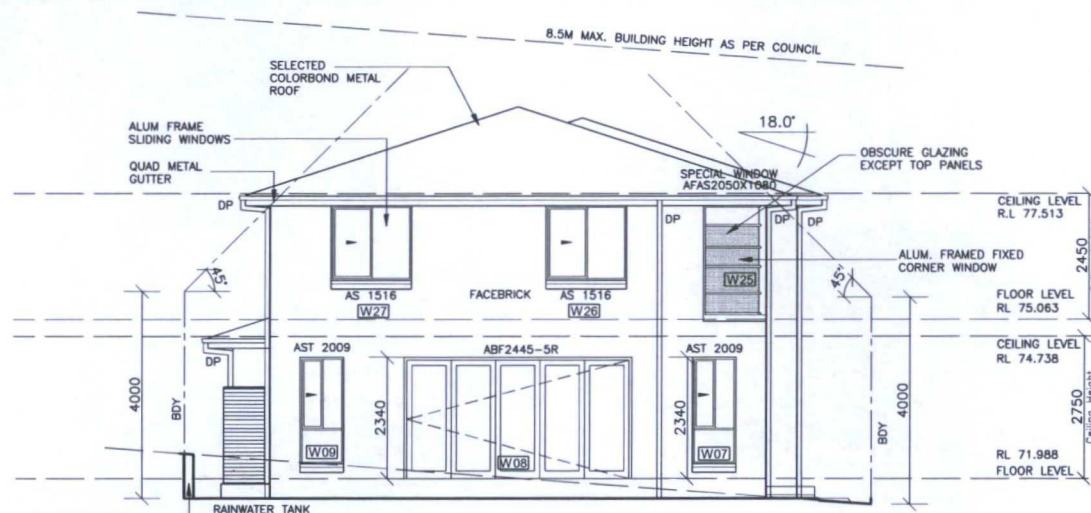


SOUTH ELEVATION
Rear Elevation

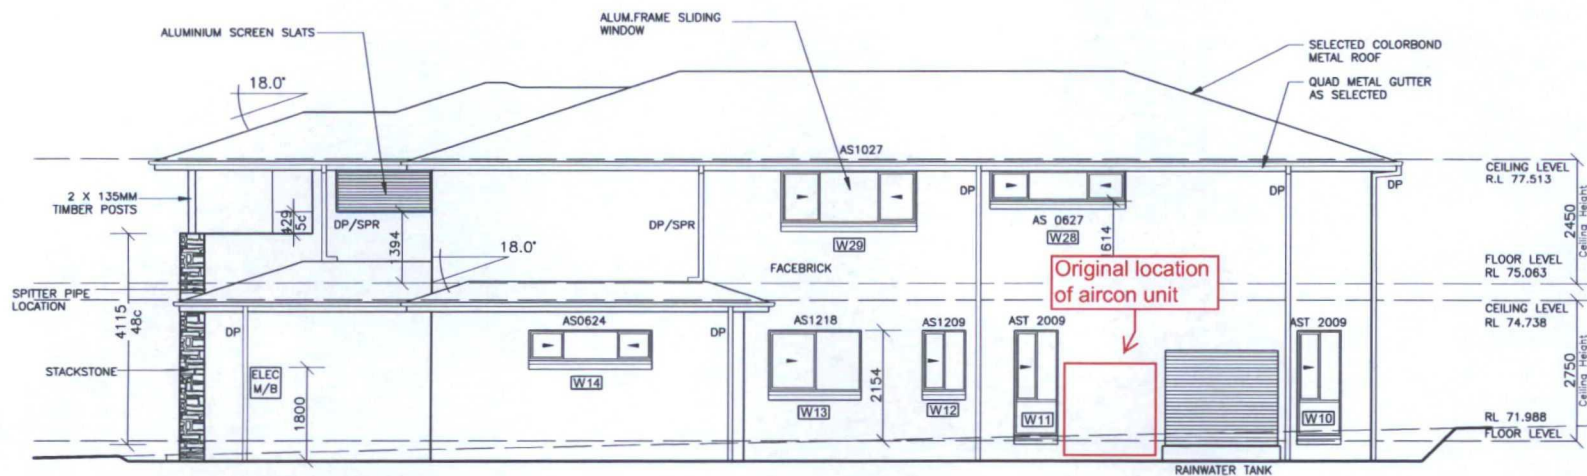

WEST ELEVATION
Side Elevation

- NOTE:**
- ALL SQUARE SET OPENINGS TO BE 2350MM HIGH TO 2750MM HIGH CEILINGS
 - ALL SQUARE SET OPENINGS TO BE 2200MM HIGH TO 2450MM HIGH CEILINGS
 - ALL INTERNAL DOORS TO BE 2040MM HIGH WINDOWS TO HAVE PROTECTION OF OPENABLE WINDOWS TO COMPLY WITH THE BUILDING CODE OF AUSTRALIA VOLUME 2 2013, IN RELATION TO THE BEDROOM WINDOWS
 - ELECTRIC WALL MOUNTED OVEN, RANGEHOOD & DOORSTOP TO BE INSTALLED AND SUPPLIED BY OWNER AFTER HANDOVER.
 - GAS POINTS LOCATION AND ELECTRICAL LAYOUTS, REFER TO ROD WEST ELECTRICAL PL.
 - KITCHEN, SCULLERY AND VANITIES DETAILS, REFER TO STAR KITCHEN DETAILS.
 - R2.5 ACOUSTIC INSULATION BATTS TO BED 2, 3, 4 & THEATRE ROOM
 - R2.5 ACOUSTIC CEILING BATTS TO THEATRE ROOM
 - R3.0 CEILING BATTS TO GARAGE
 - R2.0 EXTERNAL WALLS INSULATION AND R 3.0 CEILING INSULATION BATTS IN ACCORDANCE WITH BASIX CERTIFICATE
 - ARTICULATION JOINTS AND STEEL BEAMS IN ACCORDANCE WITH STRUCTURAL ENGINEER'S PLANS.
 - LANDSCAPING IN ACCORDANCE WITH A TOTAL CONCEPT PLANS AND SPECIFICATION BY OWNER.
 - RETAINING WALLS TO BE VERIFIED ON SITE.
- * DRAINER PLUMBER TO MAKE SURE THAT DRAINAGE IS AWAY FROM THE SLAB BY 50mm AND PLUMBER TO USE OFFSET BRACKETS WHEN INSTALLING THE DOWN PIPES.
* OWNER TO INSTALL FIXED / SHELTERED CLOTHES DRYING AREA.

FINAL
2 FEBRUARY 2016
CONSTRUCTION

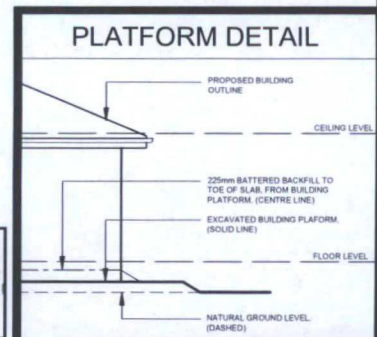

PROVIDE T2 FRAMES, TRUSSES,
FLOOR JOISTS & GARAGE BEAMS
IN LIEU OF STANDARD



CLIENT'S SIGNATURE: _____
DATE: _____
I accept and understand the plans and documents
that have been provided to me by Kurmond Homes.

NOTE:
ALL DIMENSIONS ARE IN
MILLIMETERS. ALL DIMENSIONS
ARE FRAME TO FRAME. DO NOT
SCALE OFF PLANS.

HOUSE NAME:
GLENLEIGH 47.86
FACADE:
VOGUE
REFERENCE:
DIAMOND INCL
SCALE:
1:100 L/H

CLIENT:
**EDDIE DE MARTIN
DIANA DE MARTIN**
SITE ADDRESS:
**LOT 2 DP 13139
24 RAYNER AVENUE
NARRAWEENA 2099**

JOB No:
14174
DRAWN: ME DATE: 10.05.16 Rev:
CHECKED: ME SHEET: 6 W
CONSTRUCTION

kurmondhomes
Kurmond Homes PTY LTD
10 Sovereign Place, South Windsor 2756
T: 1300 764 761 BL No. 205 457C
F: (02) 45714 015 ABN 481 288 211 98
ALL RIGHTS RESERVED. This plan is the property of KURMOND HOMES PTY LTD.
Copyright in this document is owned by KURMOND HOMES PTY LTD.
Under the provisions of the Copyright ACT 1968 and is intended for use only as
authorised by KURMOND HOMES PTY LTD. © COPYRIGHT

