


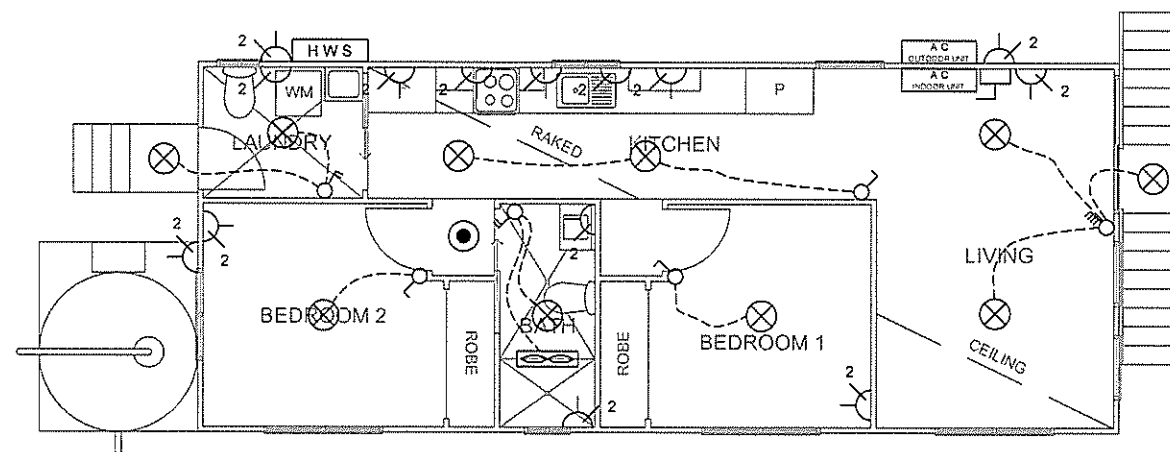

08 ELECTRICAL PLAN
20743 07 SCALE 1:100

This drawing supersedes any previous concept drawings. Please check carefully prior to signing.

Figured dimensions only to be used. DO NOT SCALE from drawing. All dimensions are to be verified on site prior to commencement of work. This drawing remains the property of Ian Cubitts Classic Home Improvements and is subject to copyright.

CURRENT ISSUE				G	
15/11/16	DA ISSUE	CN	G	Ian Cubitt's CLASSIC HOME IMPROVEMENTS 152 Russell Street Emu Plains NSW 2750 Ph: (02)4735-2944 www.classichomeimprovements.com.au Lic. 66902C	
9/08/16	DA ISSUE	MY	F		
17/05/16	DA ISSUE	MY	E		
18/12/15	DA ISSUE	DI	D		
30/09/15	DA ISSUE	MY	C		
Date	Amendment	Drawn	Issue	Checked  Drawn E.Reyes At Site Address 31A QUEENS AVENUE, AVALON	Proposed SECONDARY DWELLING for BORIS PANOV Lot No. 31 DP No. 789083 Date 17/04/15 Sheet 07 of 07 Job no. 20743 Drg No. 20743 07

