


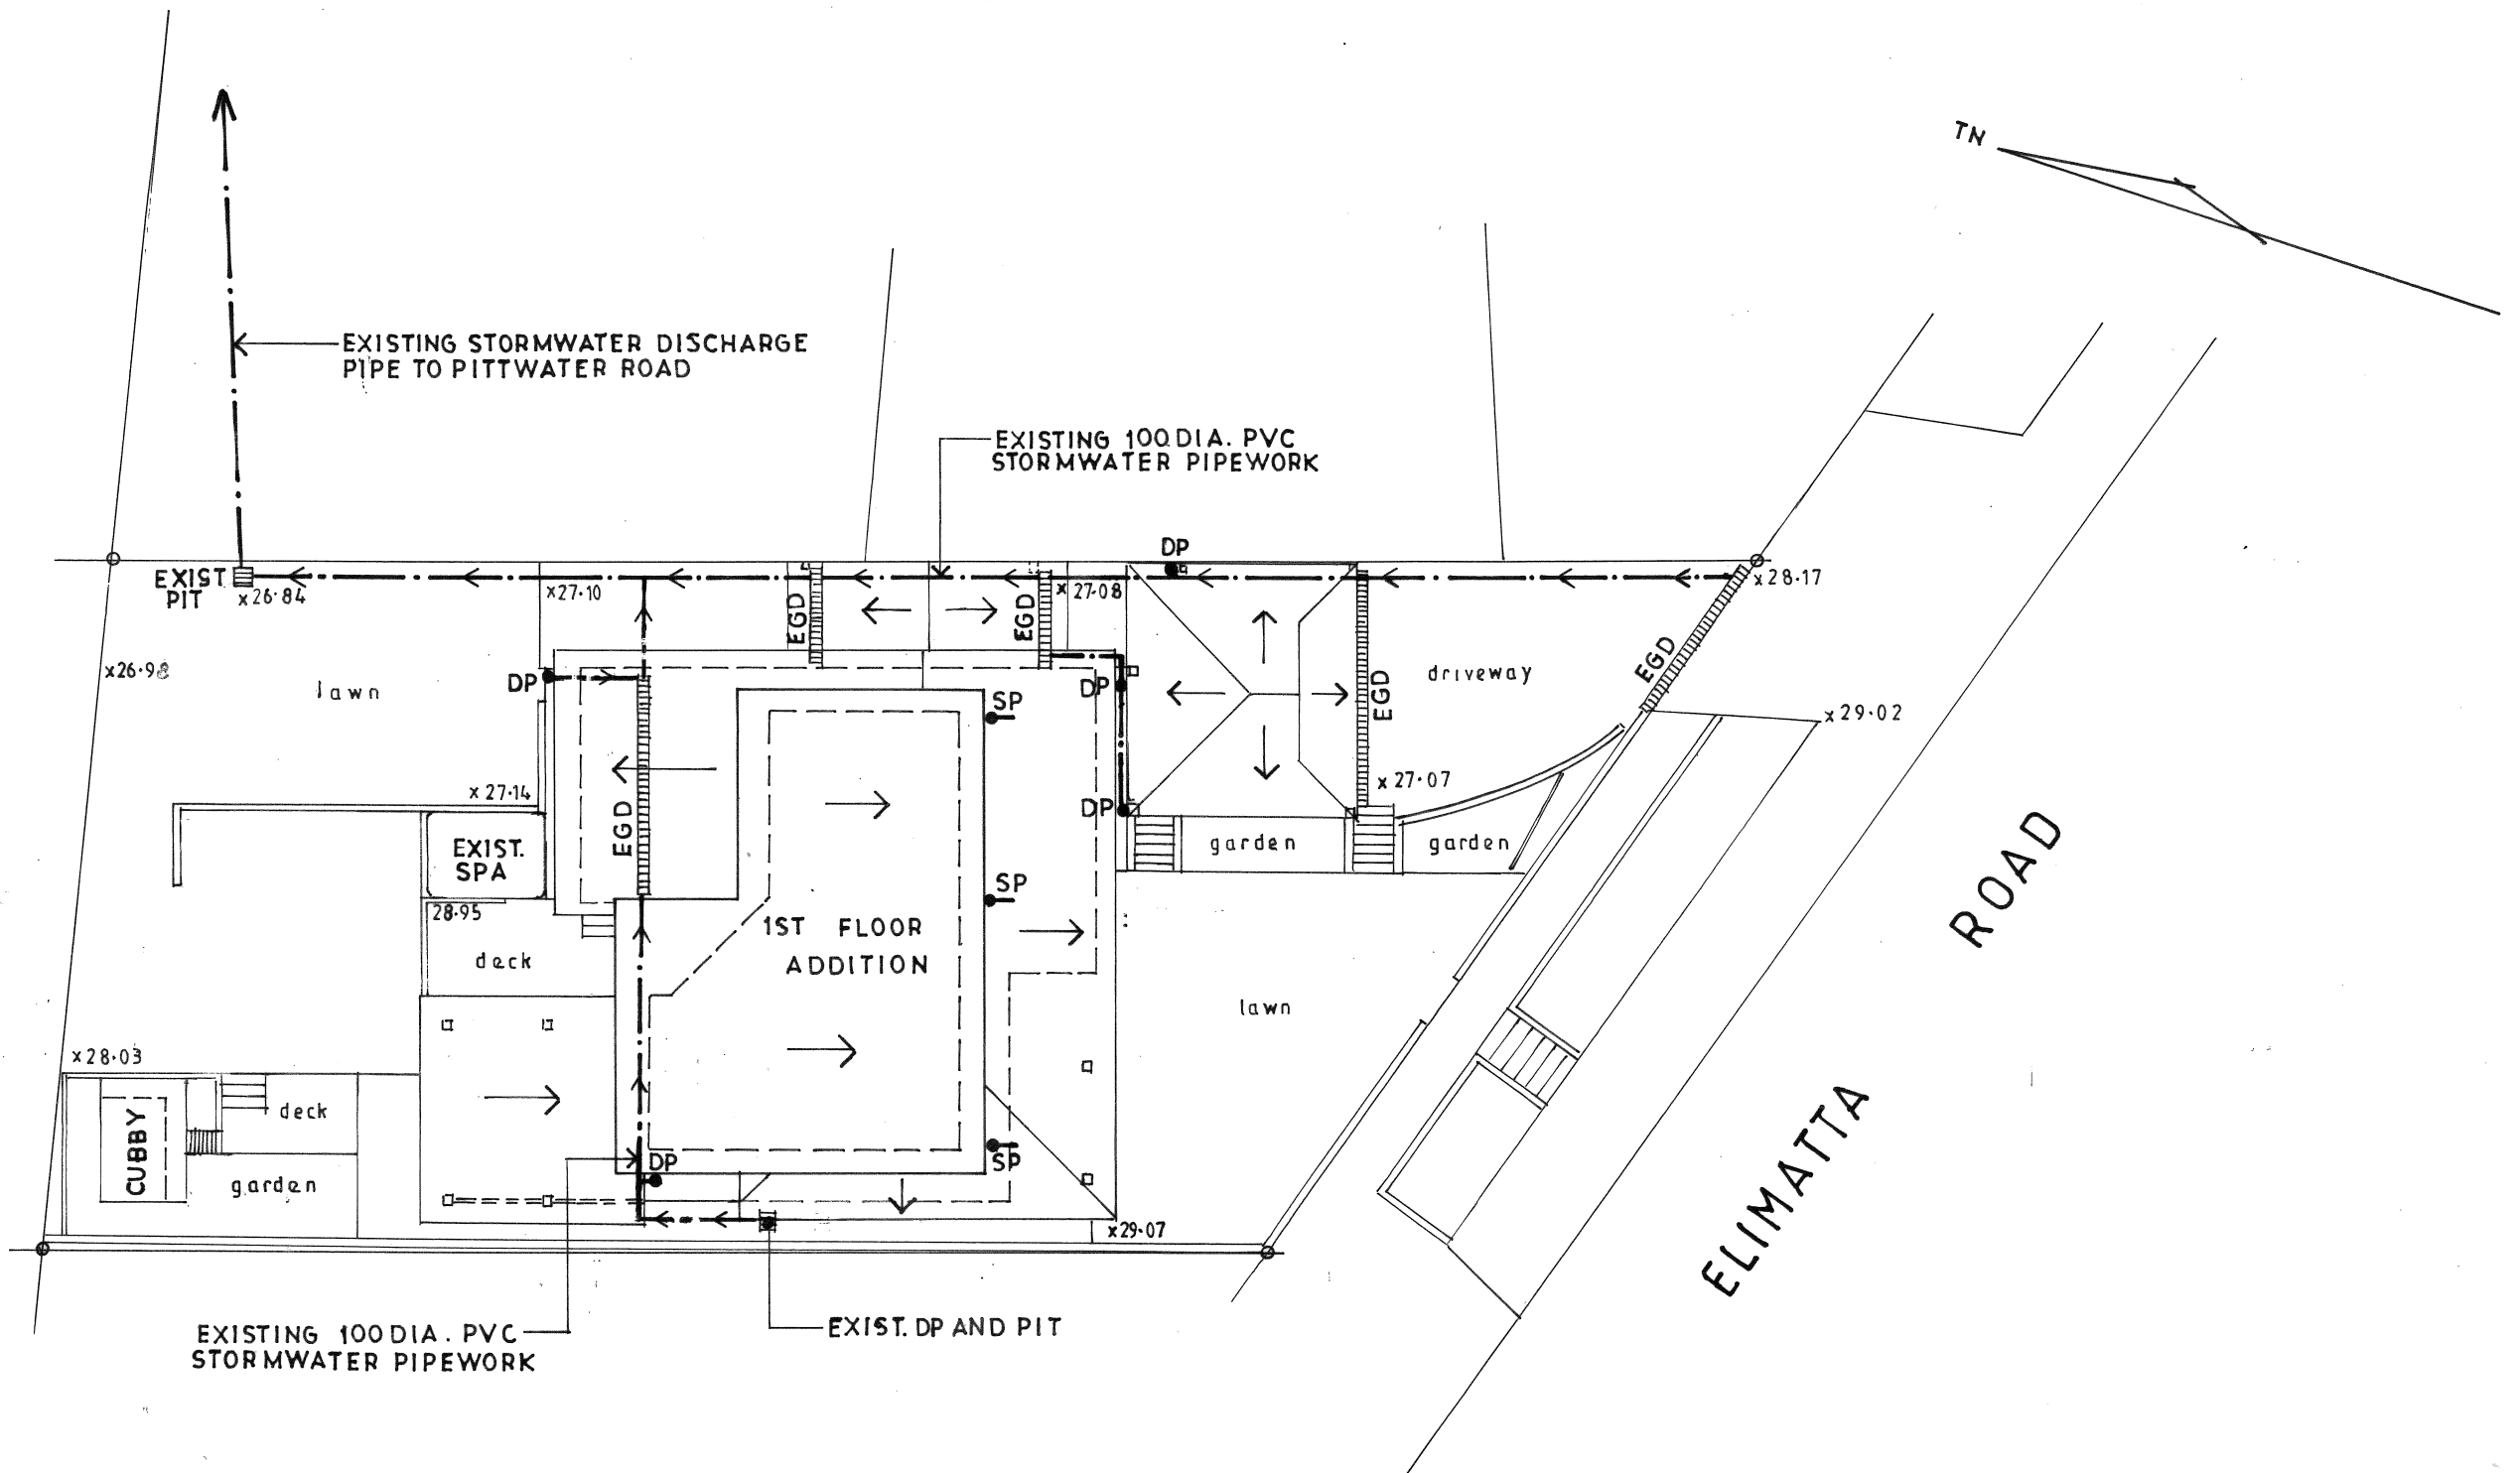

STORMWATER DRAINAGE PLAN

Stormwater Notes

- DP denotes existing downpipe
- SP denotes new downpipe and spreader to roof below
- EGD denotes existing grated drain at ground level
- All downpipes to be 90mm
- Down pipe locations to be confirmed on site
- All work to be in accordance with local council standards and specifications.
- All levels shown are to AHD.
- All works to be in accordance with AS 3500 -1990 National Plumbing and Drainage Code Part 3 - Stormwater Drainage.

Issue	Date	Revision
A	9-12-21	Pool deleted.

These plans are for formal planning assessment (DA or CDC) only not for construction



John Wright

NETWORK DESIGN

a.b.n.52 057 985 118

37 McKillop Road Beacon Hill 2100

M. 0417 459 596

alwayswright@optusnet.com.au

ALTERATIONS AND ADDITIONS

3 ELIMATTA ROAD
MONA VALE LOT B D372473

CLIENT

JANELLE OSBORNE

STORMWATER DRAINAGE PLAN

DATE	DRAWN	DRG. NO.
SEPTEMBER 2021	J.WRIGHT	09-21-EL
SCALE	ISSUE:	SHEET NO.
1:200	DA	11A